


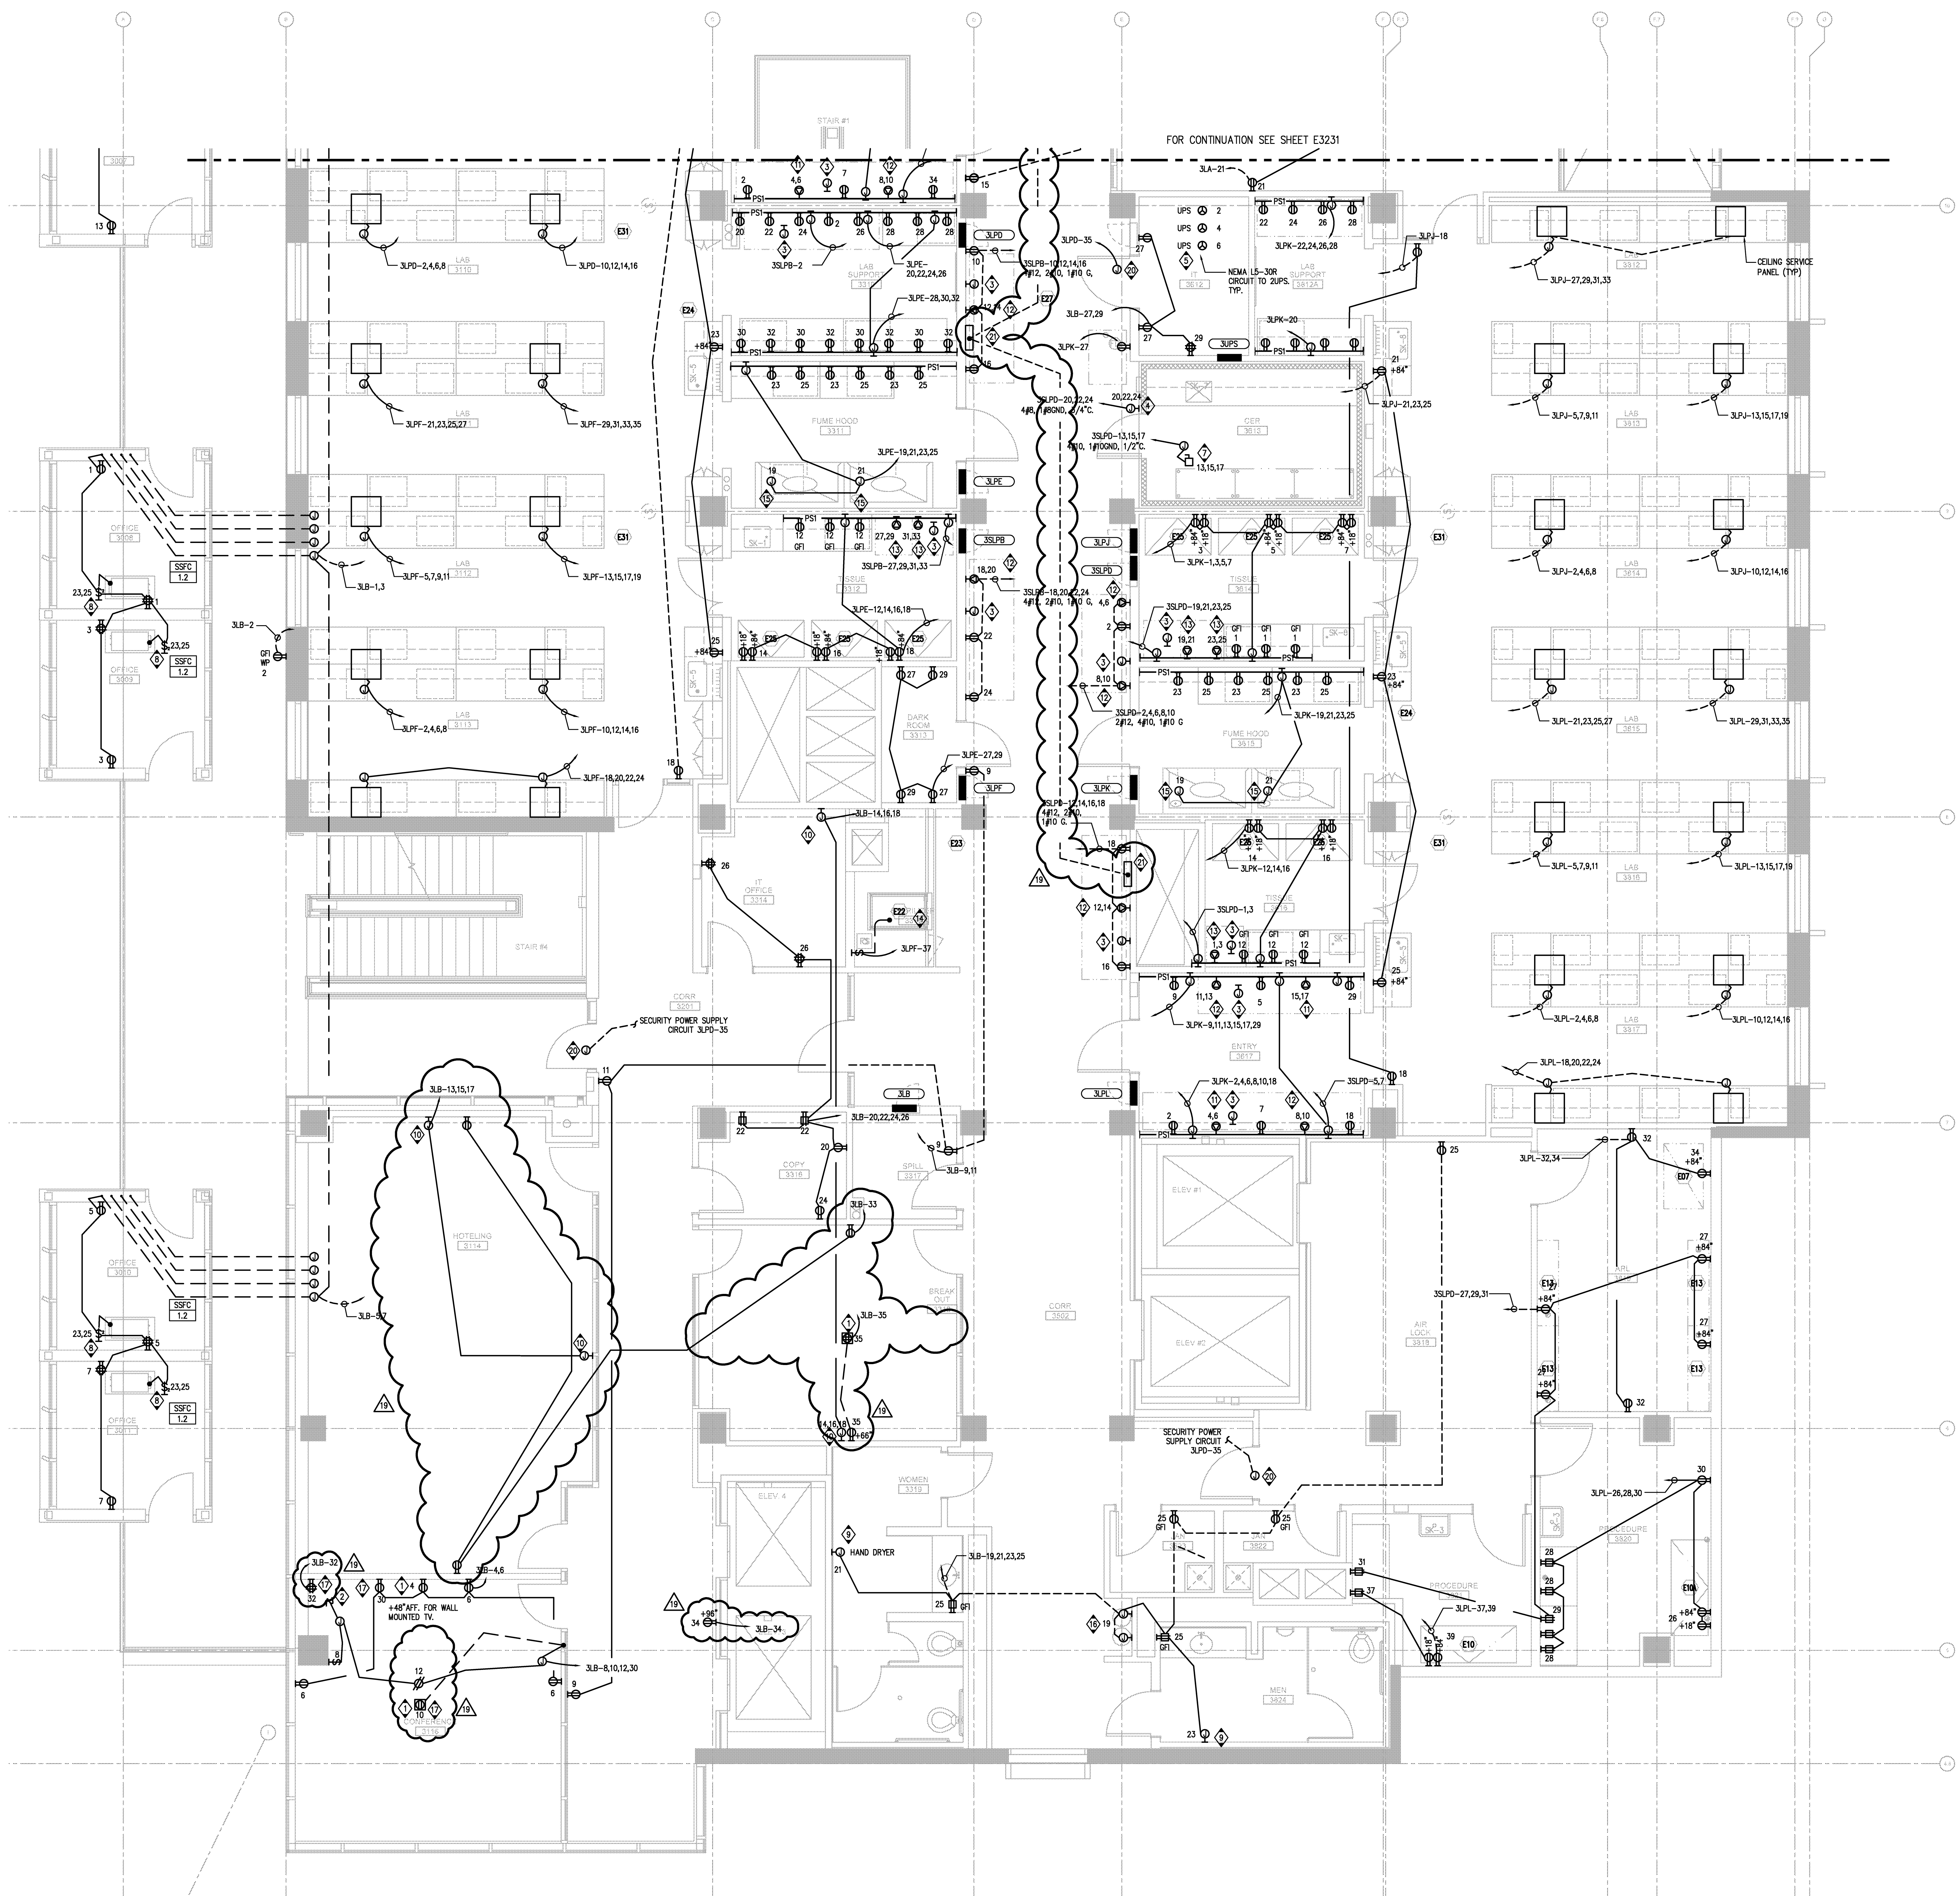

- GENERAL NOTES:
1. SEE ALL DRAWINGS FOR ADDITIONAL CONDUIT REQUIREMENTS.
 2. MOUNT ELECTRICAL DEVICES IN LER AT 42" AFF.
- KEY NOTES:
1. INSTALL IN AV BOX.
 2. CONNECT TO MOTORIZED SCREEN.
 3. STUB OUT TO CABLE TRAY, ROUTE 1' C. TO SLAB, TYP. FOR EQUIPMENT SPACE.
 4. CONNECT TO CER CONTROLS.
 5. PROVIDE UNSTRUT FOR RECEPICLES.
 6. NOT USED.
 7. CONNECT TO CER CONDENSER UNIT.
 8. PROVIDE SWITCH IN CEILING FOR DISCONNECTING MEANS, TYPICAL FOR FOD SPLIT SYSTEM.
 9. CONNECT TO HAND DRYER.
 10. CONNECT TO SYSTEMS FURNITURE.
 11. NEMA 6-20R.
 12. NEMA 6-30R. PROVIDE 2#10, 1#10G.
 13. NEMA 5-20R.
 14. CONNECT TO STERILIZER CONTROLLER.
 15. CONNECT TO FUME HOOD.
 16. CONNECT TO DRINKING FOUNTAINS.
 17. PROVIDE ISOLATED GROUND.
 18. NOT USED.
 19. NOT USED.
 20. CONNECT TO SECURITY POWER SUPPLY.
 21. CONNECT TO BUS CONTROLS. COORDINATE EXACT LOCATION WITH CONTROLS CONTRACTOR.

COPYRIGHT © FENTRESS ARCHITECTS

ISSUED FOR	DATE
Pre-Schematic Design	07/14/2008
Schematic Design	07/28/2008
BID PK #1	10/08/2008
50% Progress	10/24/2008
BID PK #1 80 CD	12/01/2008
BID PK #1 100 CD	02/16/2009
BID PK #2 100 CD	03/26/2009
100% CD	05/08/2009
CD 4	01/07/2010
COB 1	02/26/2010
COB 2	02/26/2010
CD 4	04/15/2010
RVP PERMIT	05/05/2010
ASIM008 R1	07/01/2010
ASIM009	07/06/2010
ASIM015	07/09/2010
ASIM004	07/12/2010
ASIM005	07/19/2010
ASIM010	08/13/2010

SANFORD CONSORTIUM FOR REGENERATIVE MEDICINE

2880 TORREY PINES SCENIC DRIVE
LA JOLLA, CALIFORNIA 92037

FENTRESS ARCHITECTS

415 Broadway, Denver, CO 80202
(303) 733-0606
303 17th Street, San Diego, CA 92101

LANDFORD/HELPS CONSORTIUM LLC

6100 La Jolla Village Drive, Suite 100, San Diego, CA 92121
(619) 594-0000

CONSULTANT

YITH
YITH Inc., 3070 Torrey Pines Drive, Suite 100, La Jolla, CA 92037
(858) 591-5555

STAMP

REGISTERED PROFESSIONAL ARCHITECT
FENTRESS ARCHITECTS
Exp. 06-30-11
STATE OF CALIFORNIA

SHEET NAME: PARTIAL POWER THIRD FLOOR PLAN - ZONE 2

DRAWN BY: Author

PROJECT #: 200725.000

SHEET NUMBER

E3232

SCALE: 1/4" = 1'-0"

1

PARTIAL POWER THIRD FLOOR PLAN - ZONE 2