


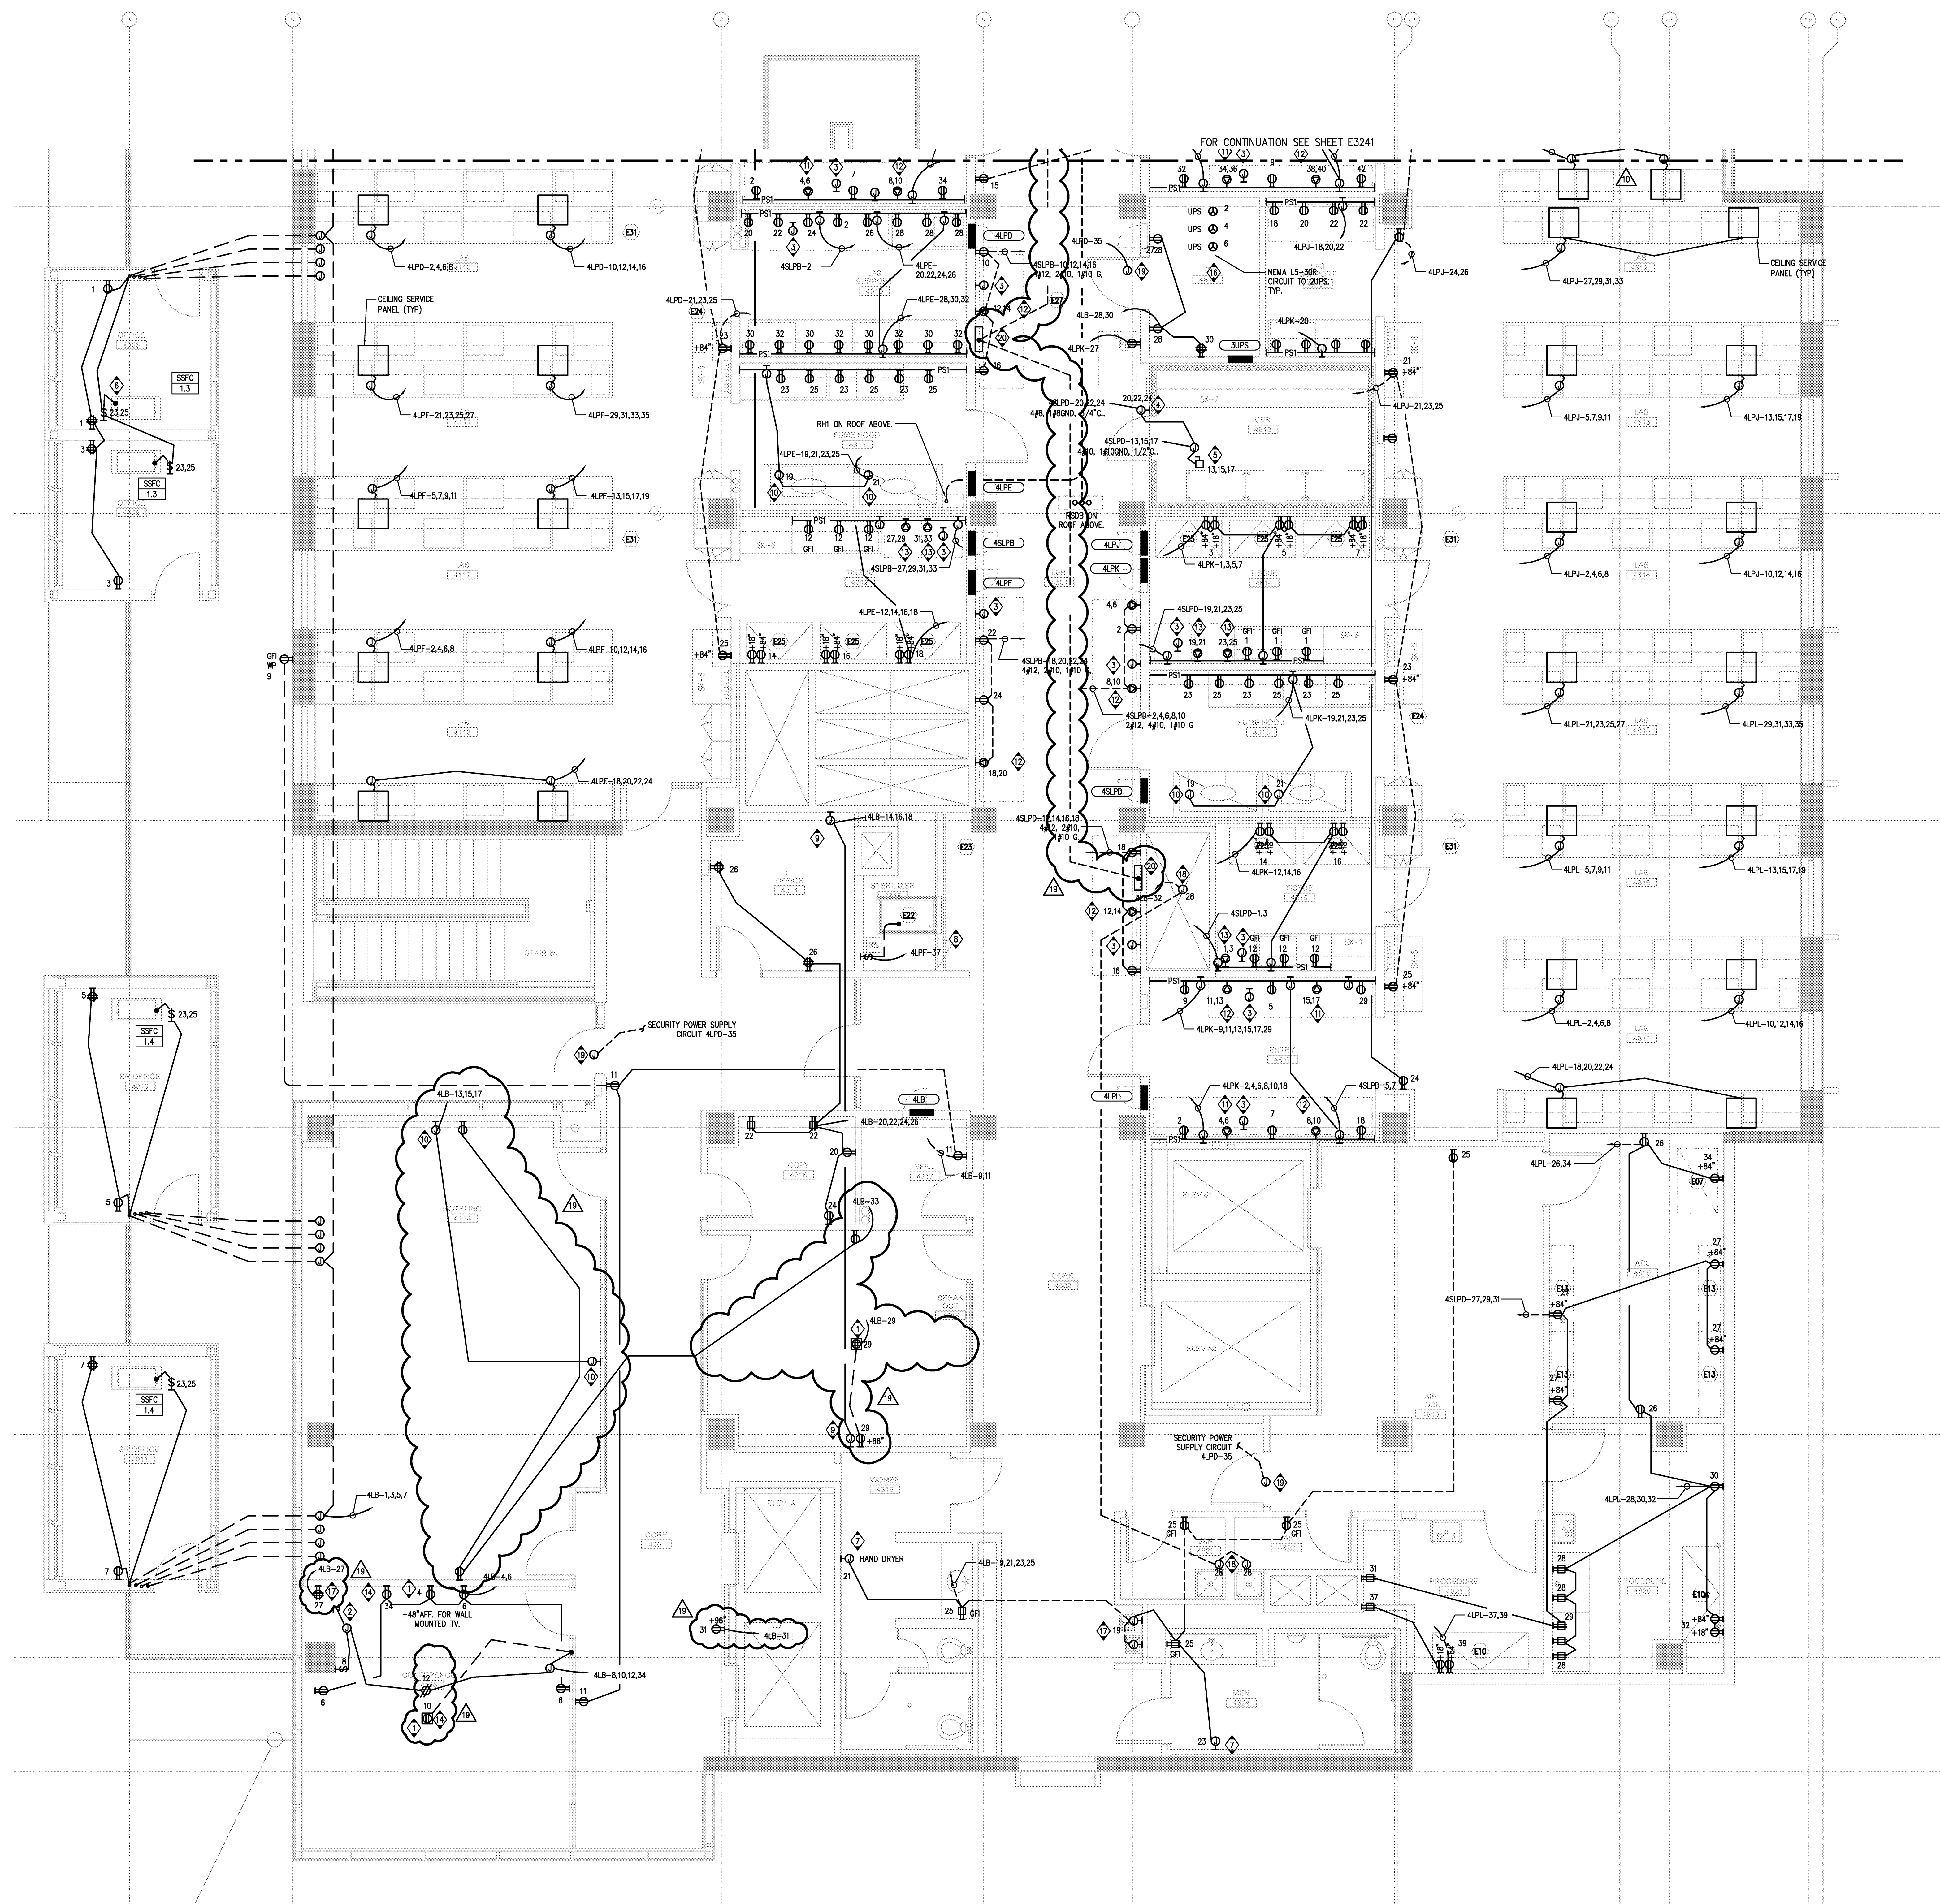

- GENERAL NOTES:
1. SEE AV DRAWINGS FOR ADDITIONAL CONDUIT REQUIREMENTS.
 2. MOUNT ELECTRICAL DEVICES IN LER AT 42" AFF.
- KEY NOTES:
1. INSTALL IN AV BOX.
 2. CONNECT TO MOTORIZED SCREEN.
 3. PROVIDE JUNCTION BOX AND (1) 1" FC FOR BMS ALARM MONITORING. STUB INTO ACCESSIBLE CEILING SPACE. TYP. FOR EQUIPMENT SPACE.
 4. CONNECT TO CER CONTROLS.
 5. CONNECT TO CER CONDENSER UNIT.
 6. PROVIDE SWITCH IN CEILING FOR DISCONNECTING MEANS. TYPICAL FOR POD SPLIT SYSTEM.
 7. CONNECT TO HAND DRYER.
 8. CONNECT TO STERILIZER CONTROLLER.
 9. CONNECT TO SYSTEMS FURNITURE.
 10. CONNECT TO FUME HOOD.
 11. NEMA 6-20R.
 12. NEMA 6-30R. PROVIDE 2#10, 1#10G.
 13. NEMA 5-20R.
 14. PROVIDE ISOLATED GROUND.
 15. NOT USED.
 16. PROVIDE UNISTRUT MOUNTING. TYP.
 17. CONNECT TO DRINKING FOUNTAINS.
 18. CONNECT TO SMOKE FIRE DAMPERS.
 19. CONNECT TO SECURITY POWER SUPPLY.
 20. CONNECT TO BMS CONTROLS. COORDINATE EXACT LOCATION WITH CONTROLS CONTRACTOR.

Copyright ©
Fentress Architects

ISSUED FOR DATE
Pre-Schematic Design 07/14/2008
Schematic Design 07/28/2008
BID PK #1 10/08/2008
50% Progress 10/24/2008
BID PK #1 80 CD 12/01/2008
BID PK #1 100 CD 02/16/2009
BID PK #2 100 CD 03/26/2009
100% CD 05/08/2009
CD 4 01/07/2010
COB 1 02/26/2010
COB 2 02/26/2010
CD 4 04/15/2010
RVI PERMIT 05/05/2010
ASIM008 RL 07/01/2010
ASIM009 07/06/2010
ASIM015 07/09/2010
ASIM004 07/12/2010
ASIM005 07/19/2010
ASIM010 08/13/2010

SANFORD CONSORTIUM FOR REGENERATIVE MEDICINE

2880 TORREY PINES SCENIC DRIVE
LA JOLLA, CALIFORNIA 92037

Consultant
xrth
xRTH Inc. (San Diego, CA)
3070 Torrey Pines Rd., Suite 100
San Diego, CA 92037
619.594.8884
www.xrth.com

Sanford/Phelps Consortium LLC
400 Broadway, Denver, CO 80202
303.733.0000
www.sanfordphelps.com

FENTRESS ARCHITECTS
400 Broadway, Denver, CO 80202
303.733.0000
www.fentress.com

DAVIS ARCHITECTS
3001 Park Avenue, San Mateo, CA 94403
650.594.8884
www.davisarchitects.com

STAMP
FENTRESS ARCHITECTS
Professional Engineer
No. 100000000
Exp. 06-30-11
ELECTRICAL
STATE OF CALIFORNIA

SHEET NAME
PARTIAL POWER FOURTH
FLOOR PLAN - ZONE 2

DRAWN BY: Author
PROJECT # 200725.000
SHEET NUMBER

E3242

SCALE
1/4" = 1'-0"

1