



1/22/2008 4:52:10 PM  
File Path  
\\sfs\csl\proj\200725\000\dwg\4003.dwg

Warning: It is a violation of the law for any person, unless acting under the direction of a licensed architect, to alter an item in any way. If an item in this document is altered, the altering architect, if other than the architect of record, shall affix to the item his seal and the notation "altered by" followed by his signature and the date of such alteration, and the specific description of the alteration.

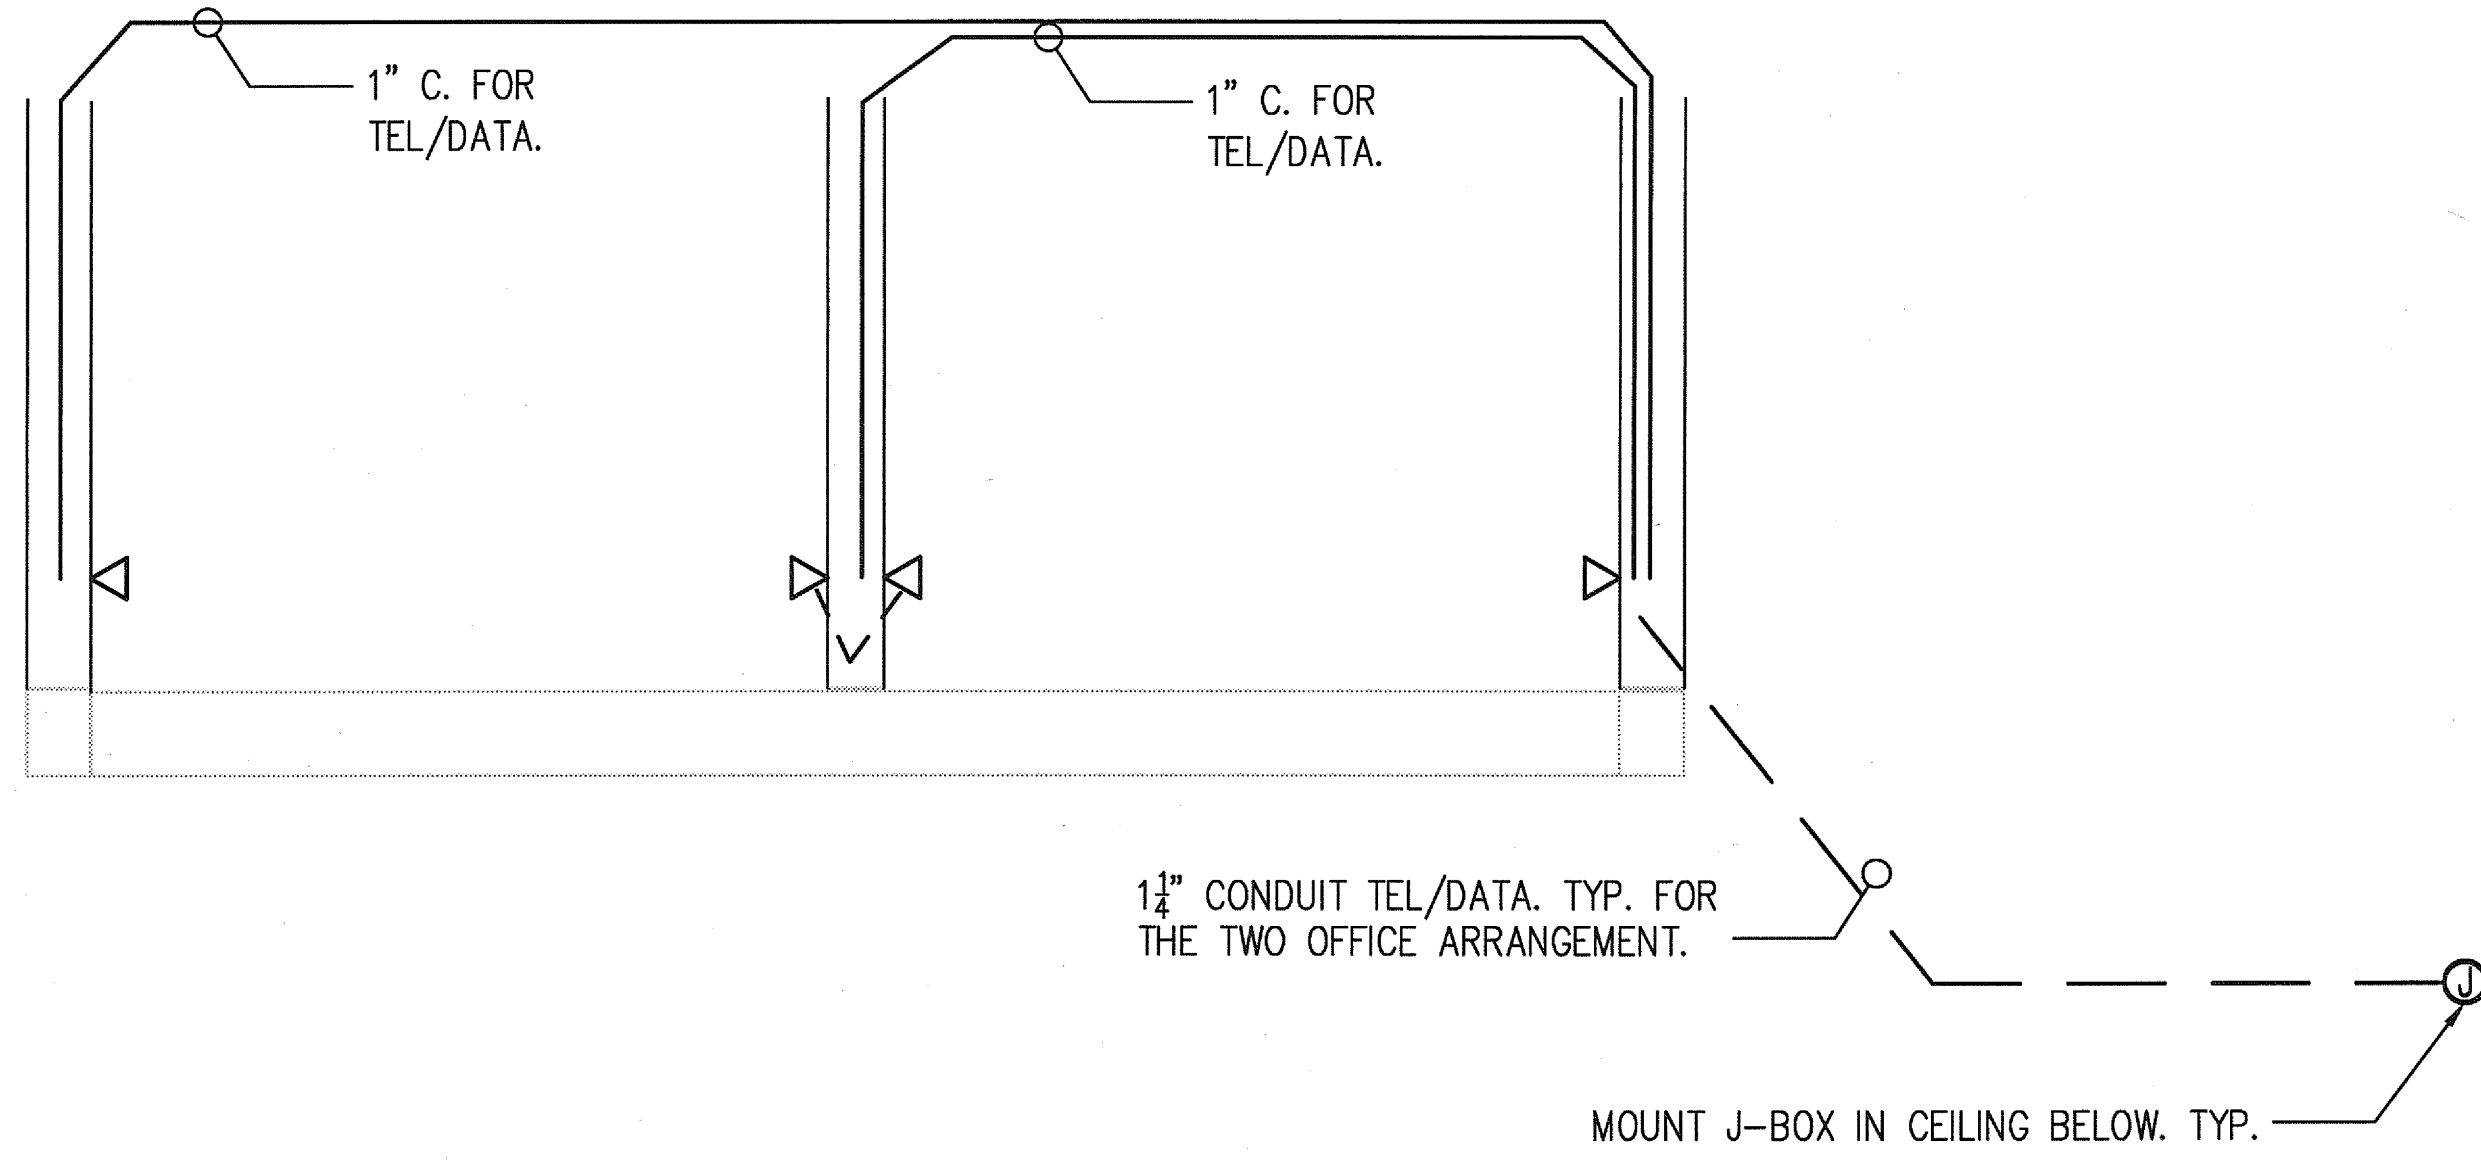


TEL/DATA TYPICAL FOR THE ONE OFFICE ARRANGEMENT

SCALE  
NONE 4

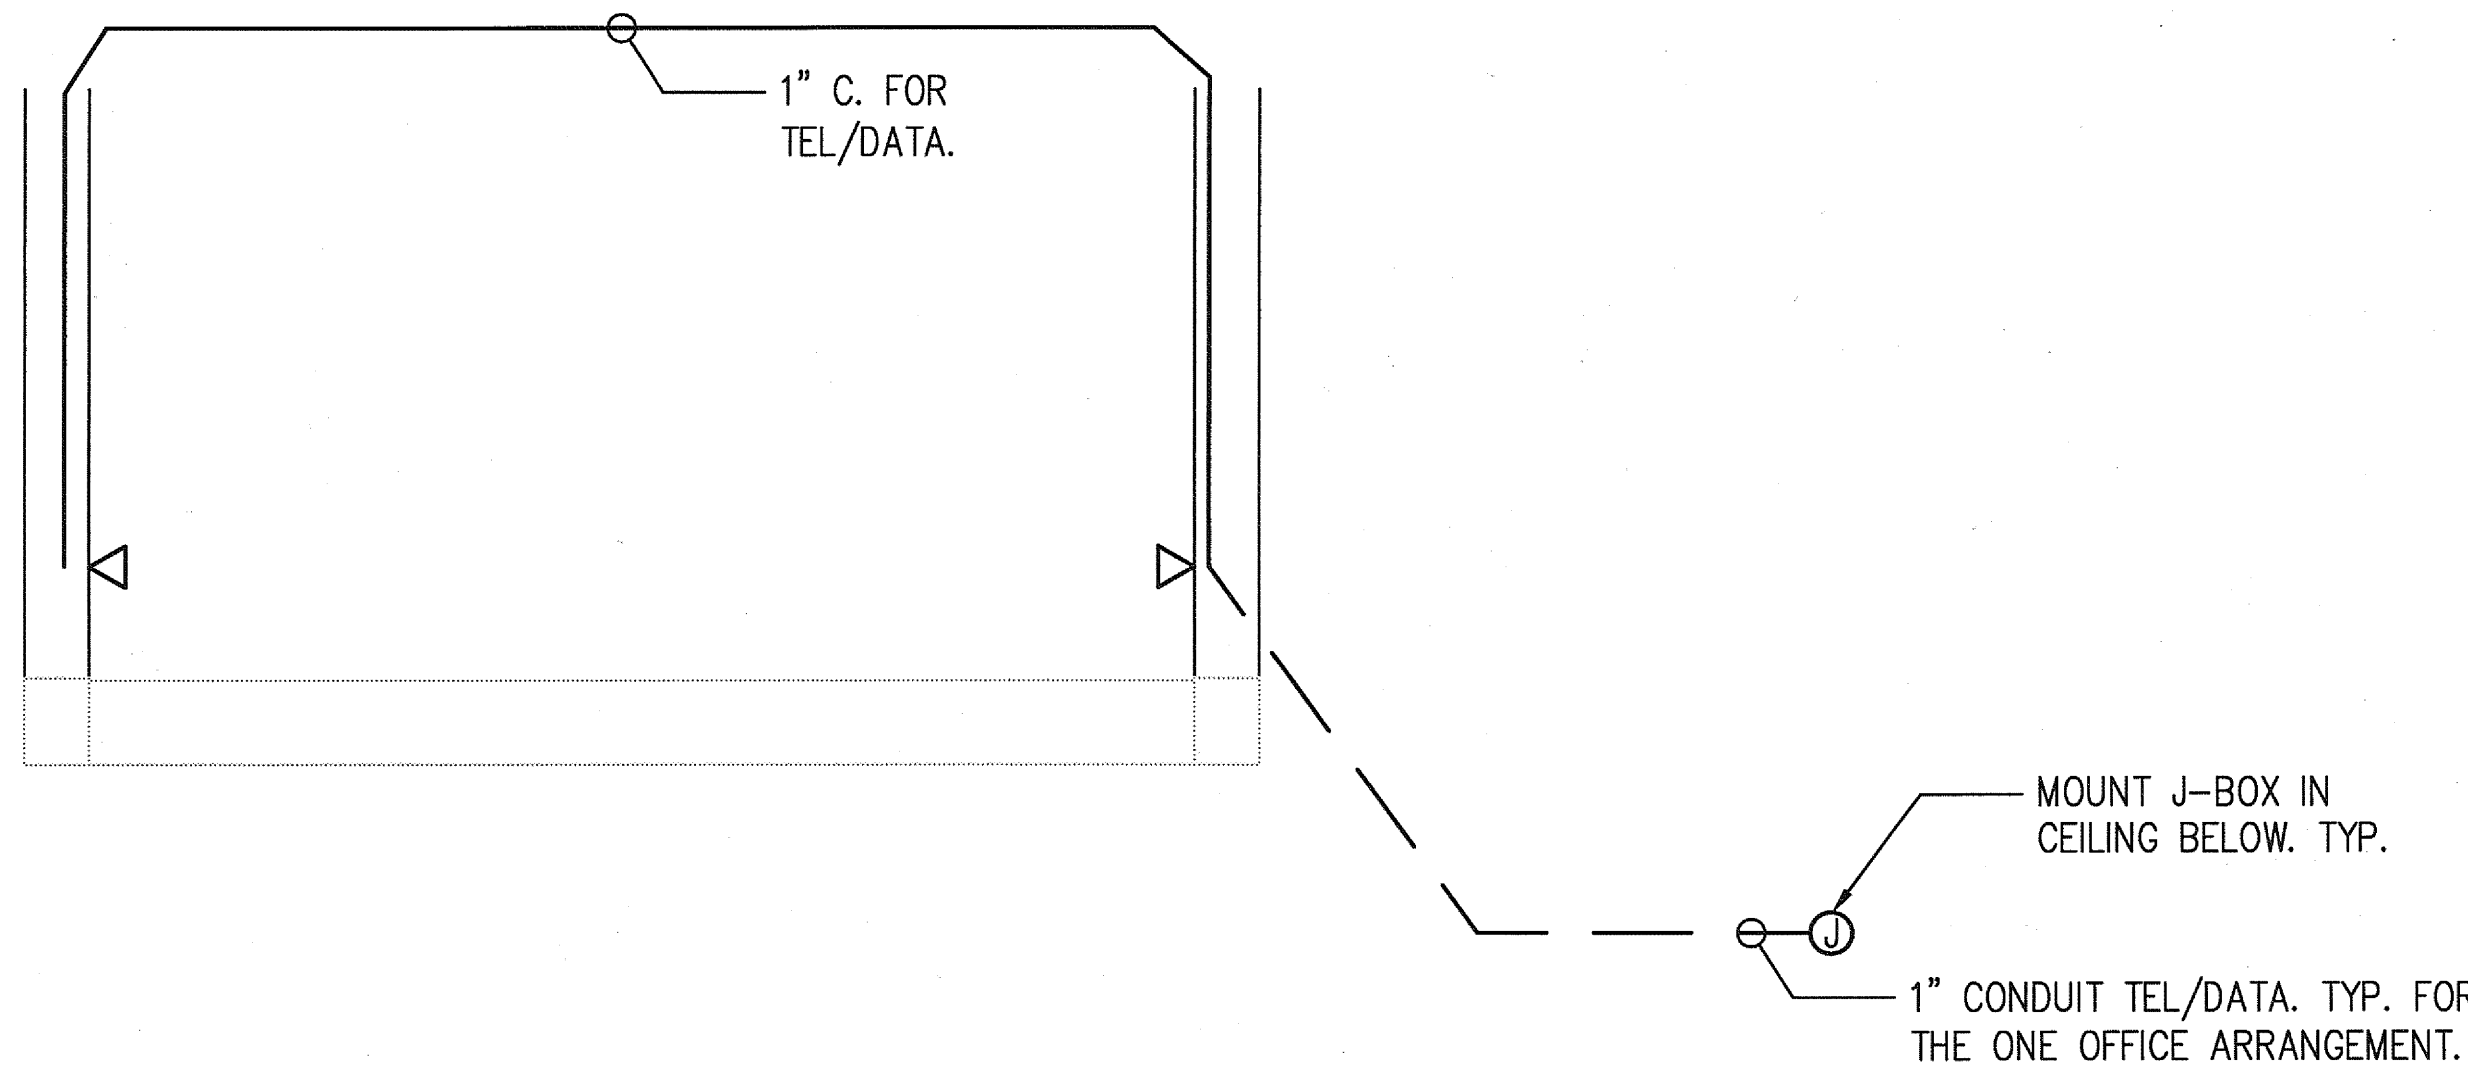


TEL/DATA TYPICAL FOR THE ONE OFFICE ARRANGEMENT

SCALE  
NONE 5

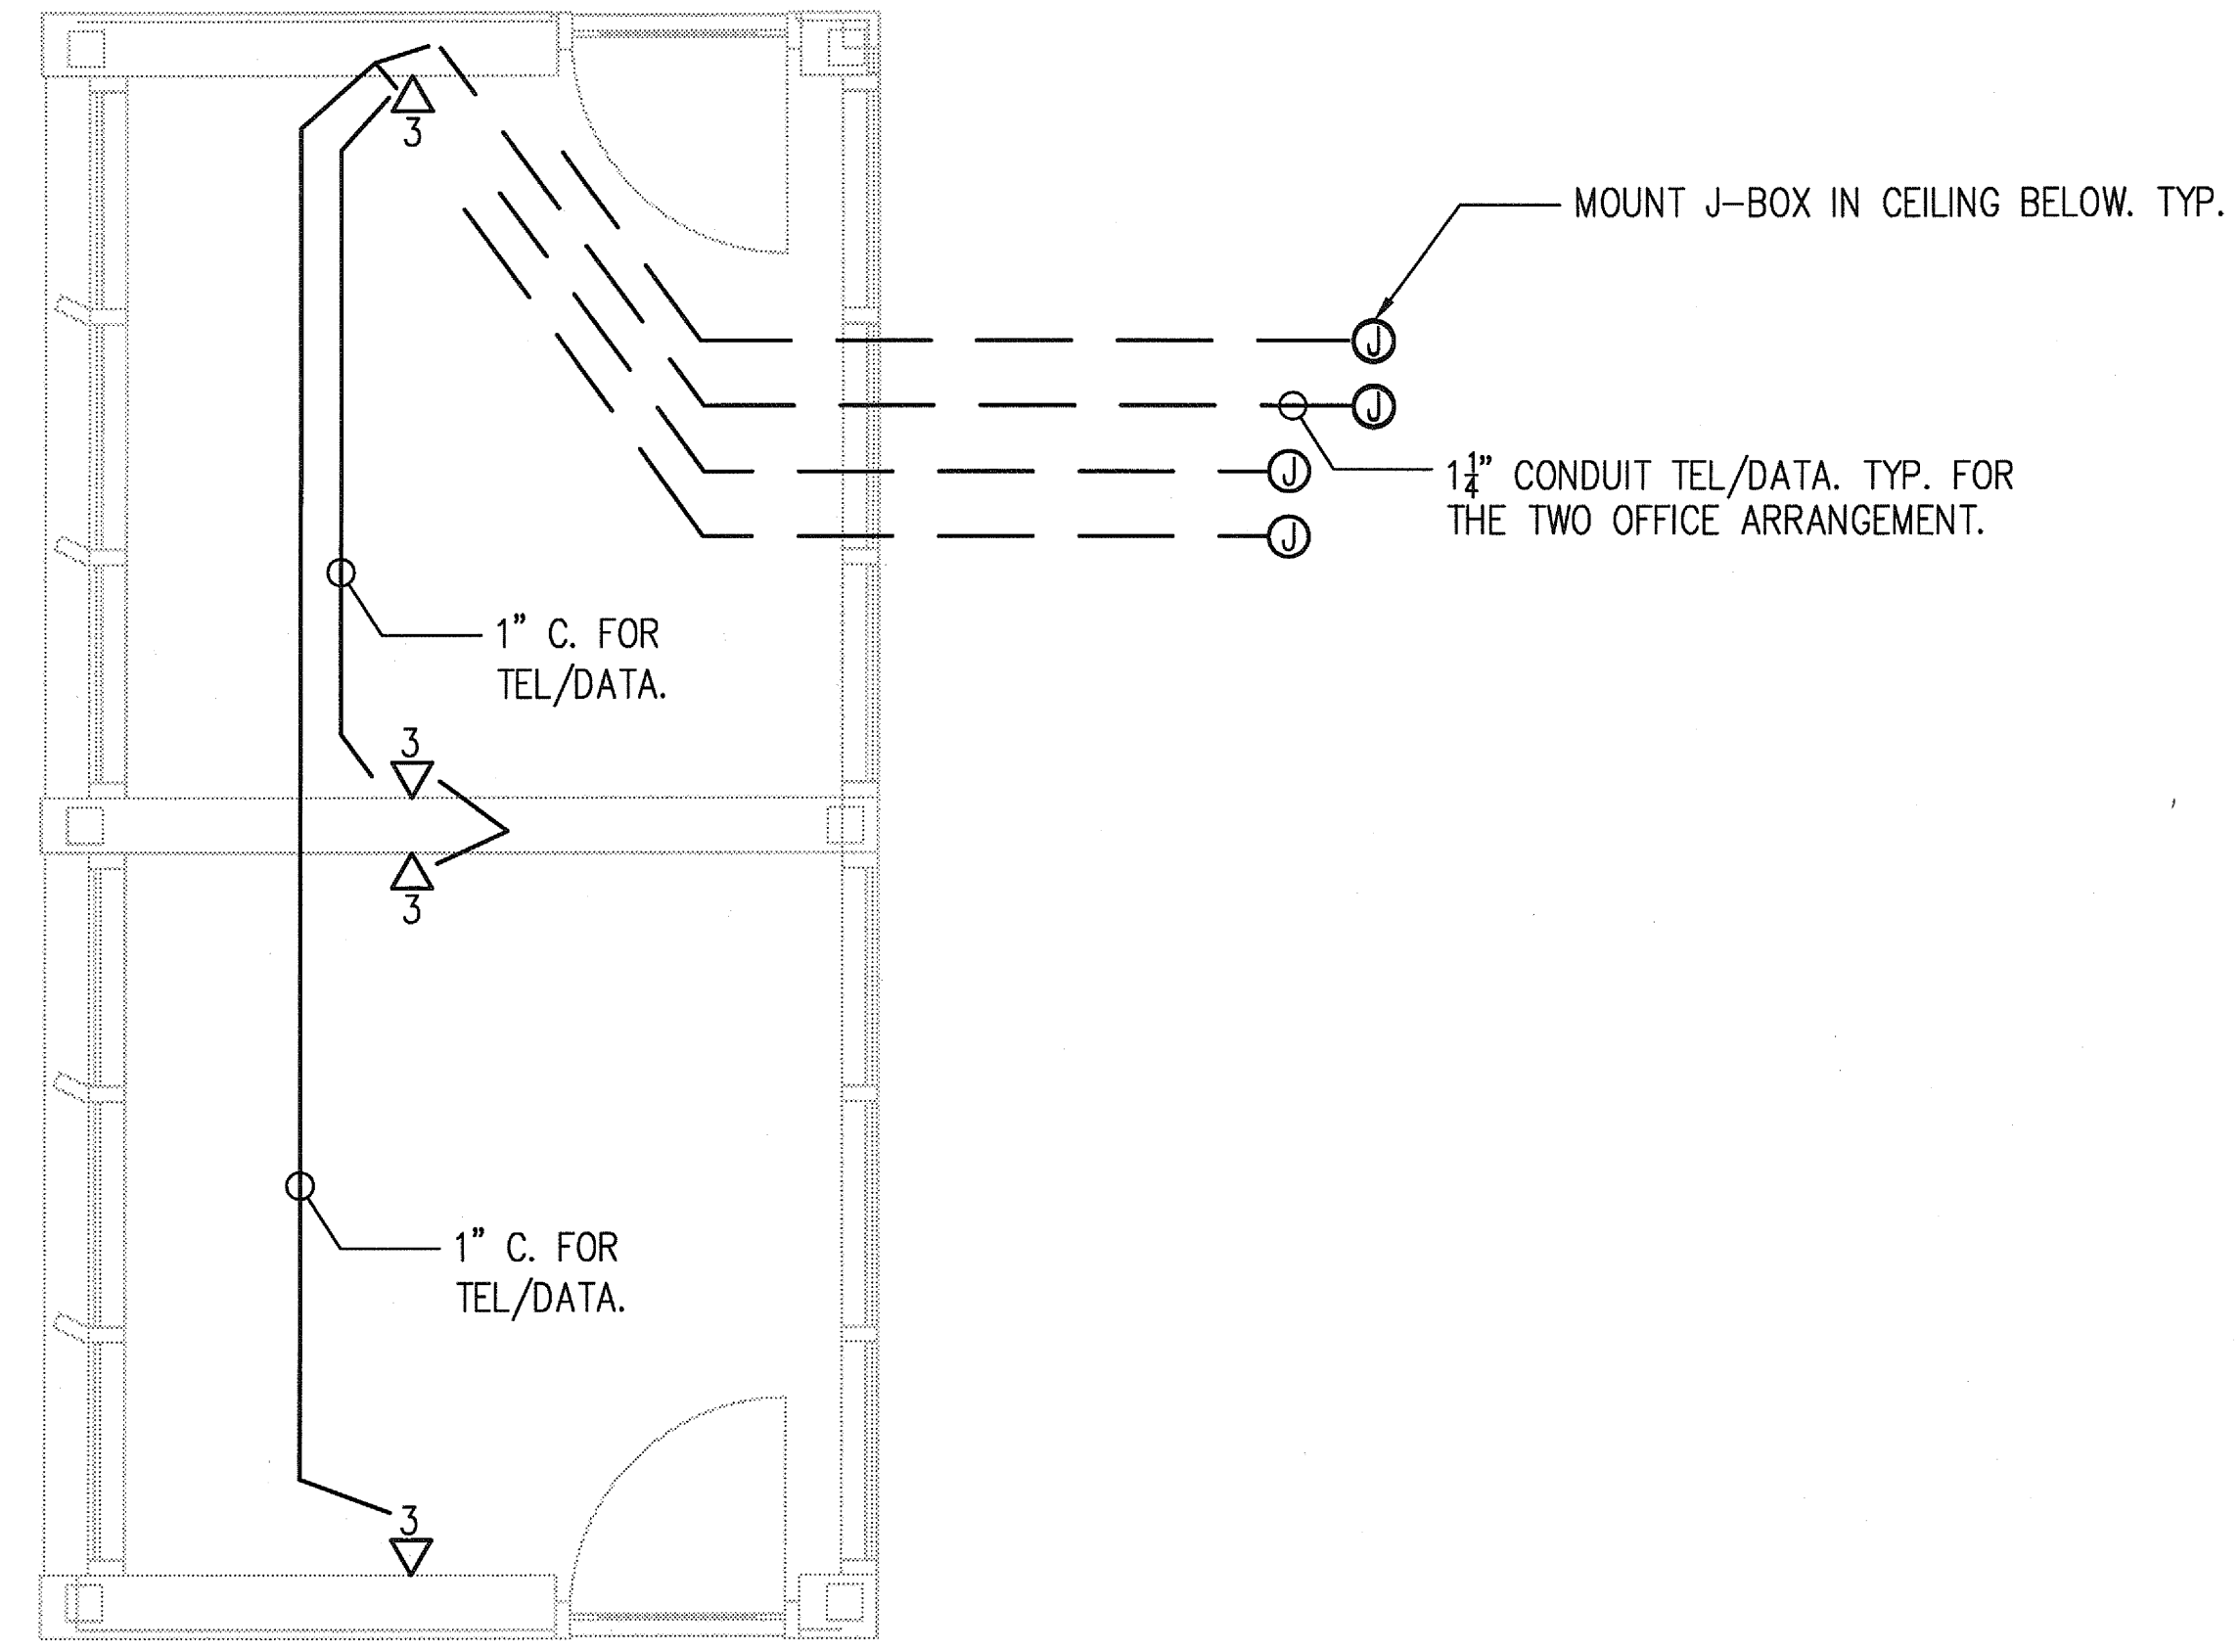

TEL/DATA TYPICAL FOR THE ONE OFFICE ARRANGEMENT


SCALE  
NONE 1

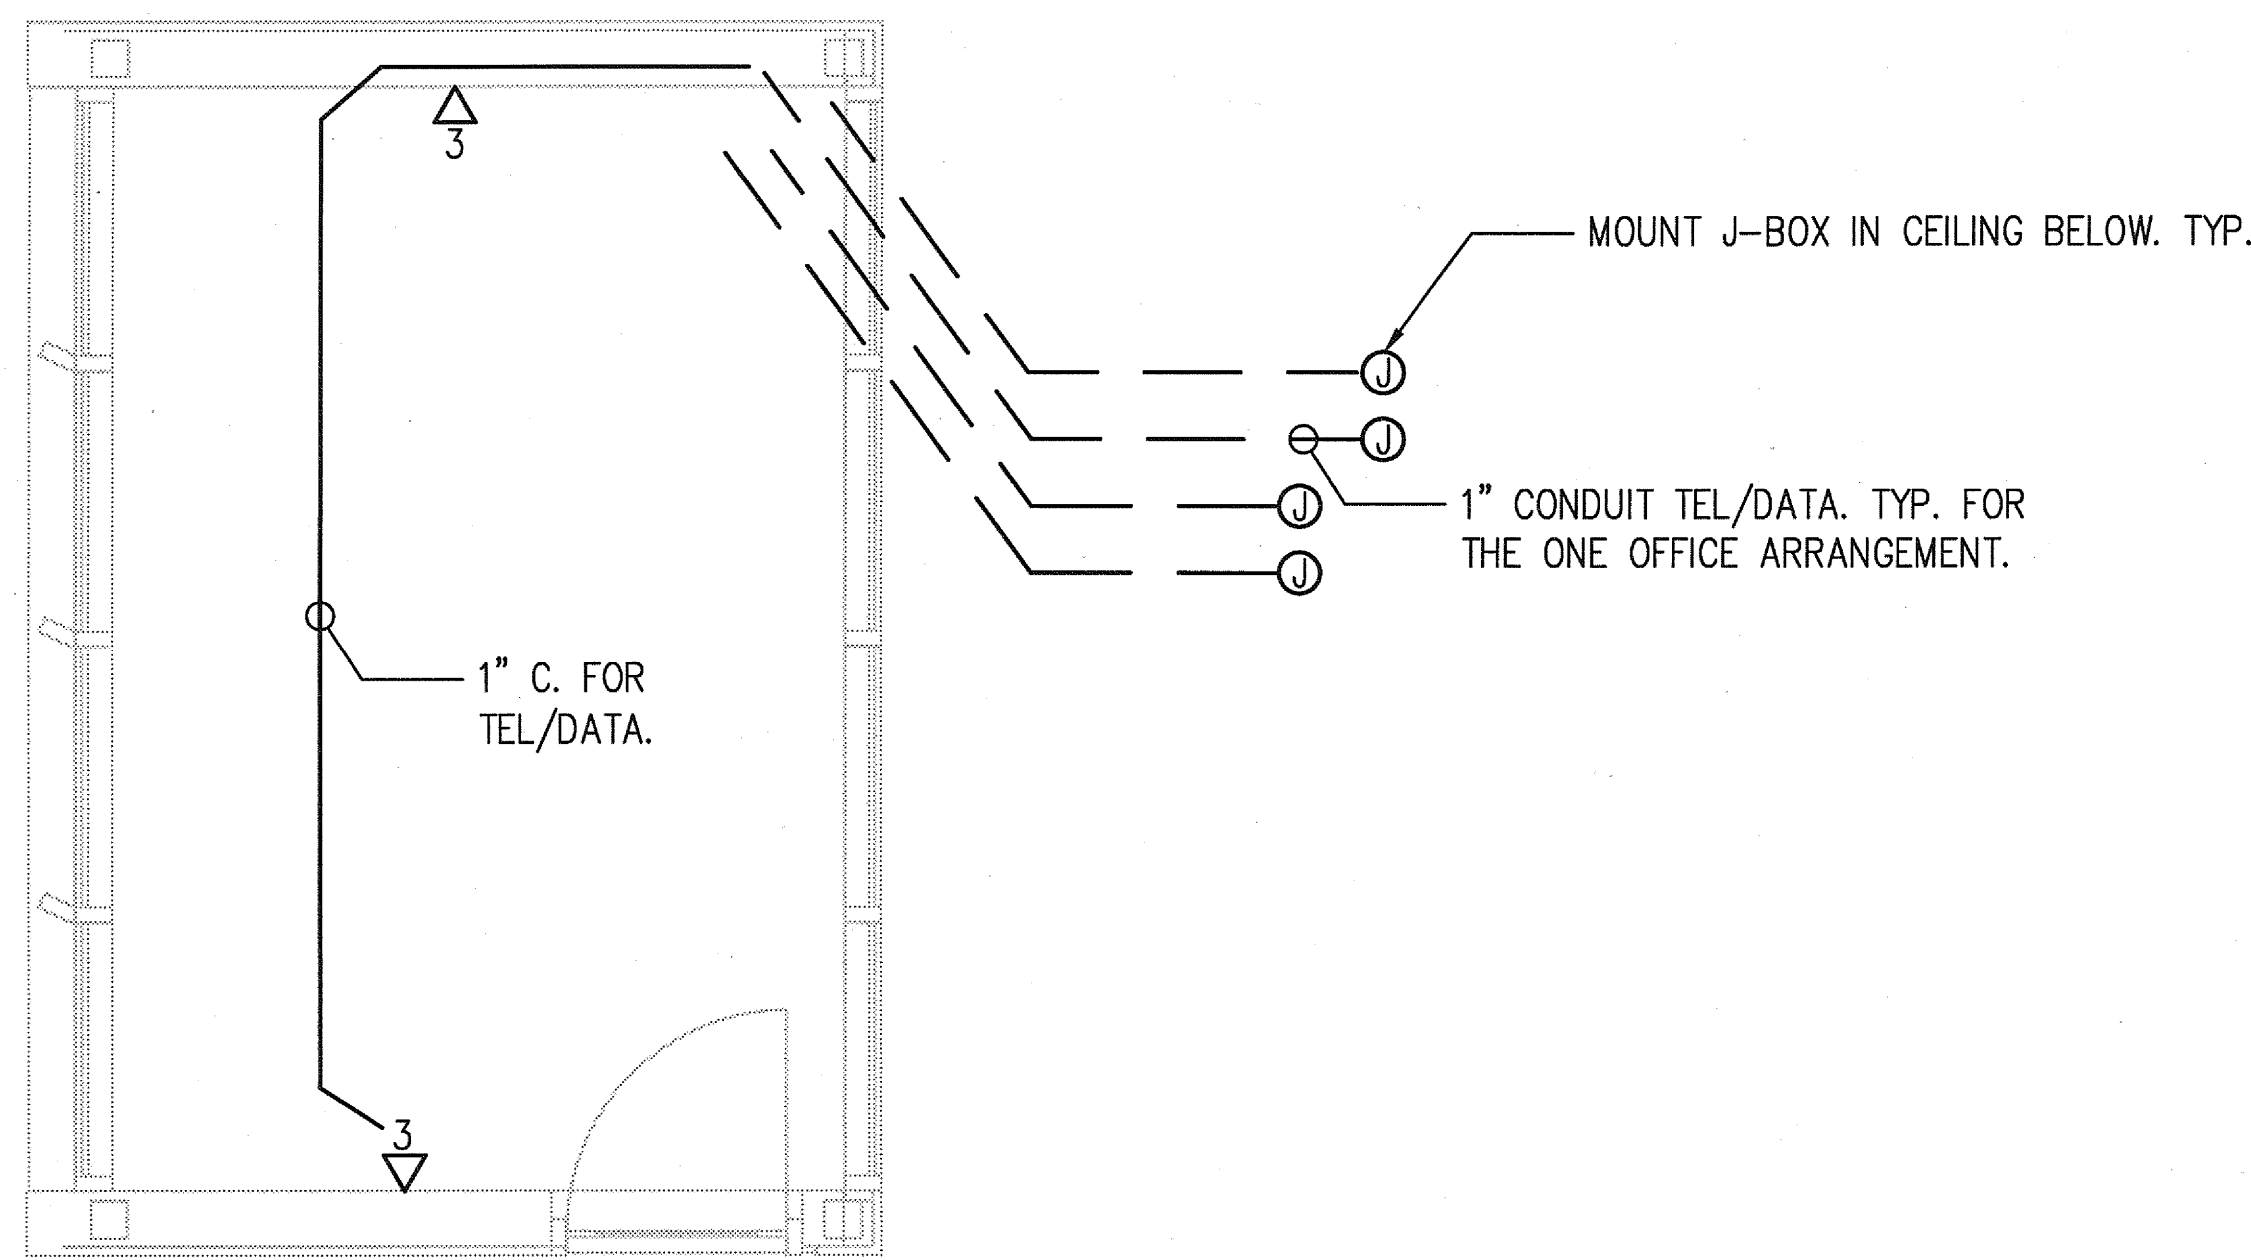

TEL/DATA TYPICAL FOR THE ONE OFFICE ARRANGEMENT

SCALE  
NONE 2





U.C.S.D.	
PRELIMINARY DRAWINGS	<input type="checkbox"/>
PROGRESS DRAWINGS	<input type="checkbox"/>
REVIEW DRAWINGS	<input type="checkbox"/>
CONSTRUCTION DRAWINGS	<input checked="" type="checkbox"/>

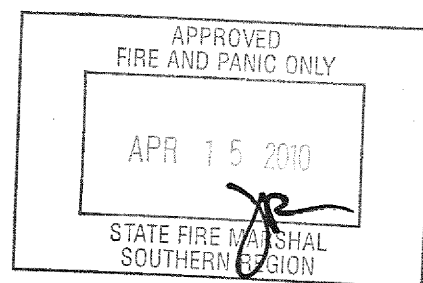

ISSUED FOR	DATE
Pre-Schematic Design	07/16/2008
Schematic Design	07/28/2008
BID PK #1	10/06/2008
80% Progress	10/24/2008
BID PK #1 80 CD	12/01/2008
BID PK #1 100 CD	02/16/2009
BID PK #2 100 CD	03/26/2009
100% CD	04/06/2009
CD 4	01/07/2010
COB 1	02/26/2010
COB 2	02/26/2010
CD 4	04/15/2010

SANFORD CONSORTIUM FOR REGENERATIVE MEDICINE

2880 TORREY PINES SCENIC DRIVE  
LA JOLLA, CALIFORNIA 92037

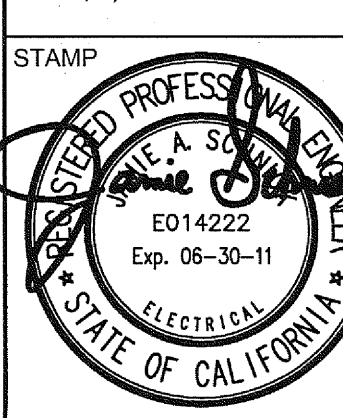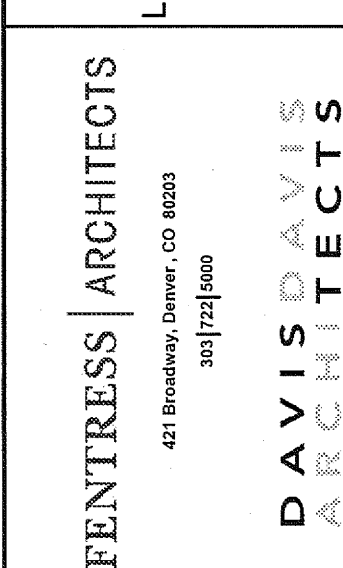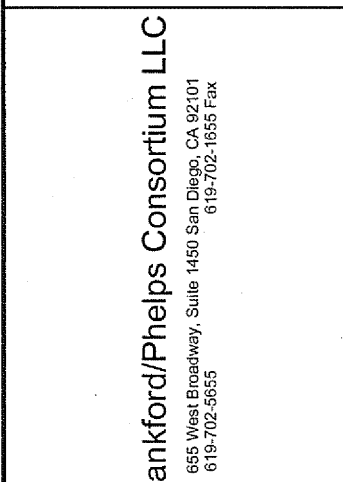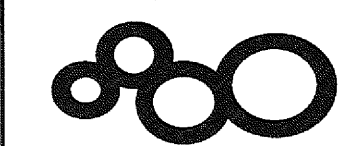

SHEET NAME  
ELECTRICAL DETAILS

DRAWN BY: Author

PROJECT # 200725.000

SHEET NUMBER

E4003