


12/20/2009 4:55:10 PM
P:\00000000\00000000\00000000.dwg
P:\00000000\00000000\00000000.dwg

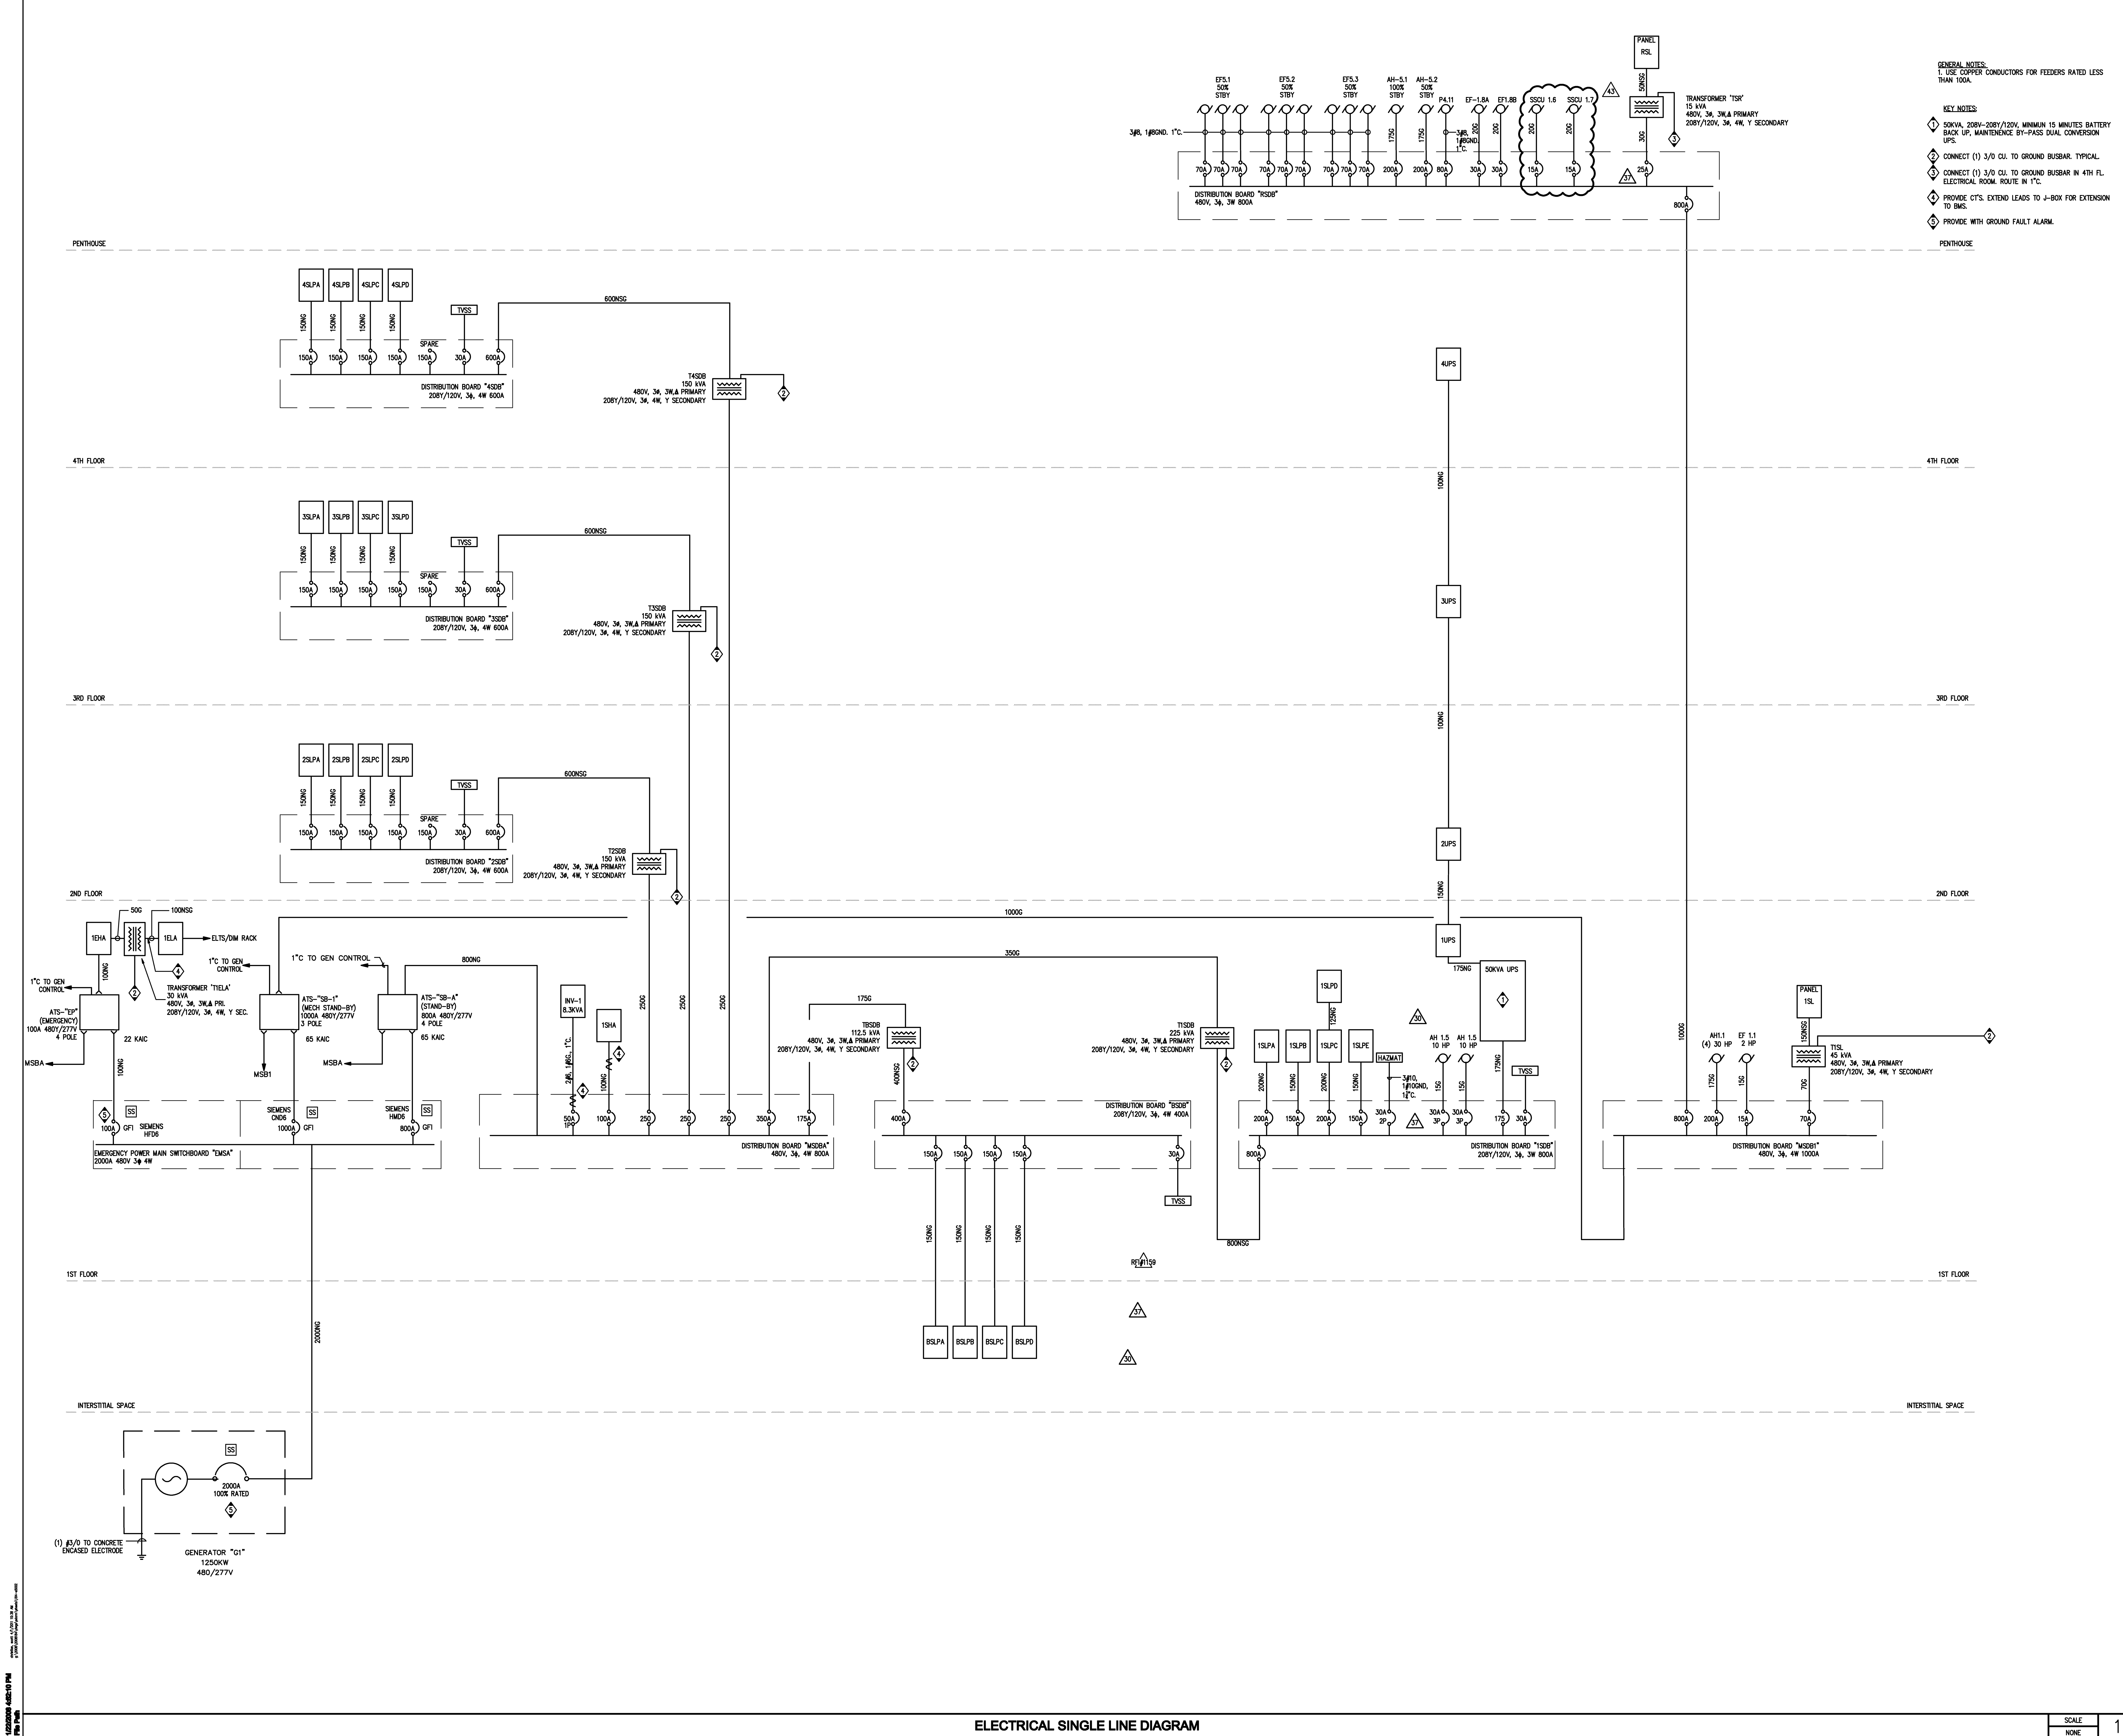

ISSUED FOR		DATE
REV PK #1	10/04/2009	
80% Progress	10/04/2009	
REV PK #1 80 CD	10/04/2009	
REV PK #1 100 CD	10/04/2009	
REV PK #1 100 CD	10/04/2009	
100% CD	06/08/2009	
CD 4	01/07/2010	
CD 5	02/28/2010	
CD 6	02/28/2010	
CD 7	04/15/2010	
CD 8	05/05/2010	
CD 9	07/01/2010	
CD 10	07/08/2010	
CD 11	07/08/2010	
CD 12	07/12/2010	
CD 13	07/12/2010	
CD 14	08/19/2010	
CD 15	08/27/2010	
CD 16	08/27/2010	
CD 17	11/17/2010	
CD 18	12/16/2010	
CD 19	01/14/2011	
CD 20	01/14/2011	
CD 21	01/26/2011	
CD 22	01/26/2011	
CD 23	02/16/2011	
CD 24	02/16/2011	
CD 25	02/16/2011	
CD 100	02/16/2011	

CLIENT
Sanford Consortium for Regenerative Medicine
2880 Torrey Pines Scenic Drive
La Jolla, California 92037

CONSULTANT
Fentress Architects
10000 La Jolla Village Drive, Suite 100
La Jolla, CA 92037
(619) 594-1000
www.fentressarchitects.com

ARCHITECTS
Fentress Architects
10000 La Jolla Village Drive, Suite 100
La Jolla, CA 92037
(619) 594-1000
www.fentressarchitects.com

DAVIS DAVIS ARCHITECTS
3801 La Jolla Village Drive, Suite 100
La Jolla, CA 92037
(619) 594-1000
www.davisdavisarchitects.com

STAMP
Professional Engineer
State of California
Exp. 06-30-11

SHEET NAME
ELECTRICAL SINGLE LINE DIAGRAM

DRAWN BY: Author

PROJECT #: 200708.000

SHEET NUMBER
E5002

SCALE
NONE

1

ELECTRICAL SINGLE LINE DIAGRAM