



1/22/2008 4:52:10 PM
\\nas1\cadd\proj\080725\080725.mcd
File Length

Warning: It is a violation of the law for any person, unless acting under the direction of a licensed architect, to alter an item in any way. If an item in this document is altered, the altering architect, if other than the architect of record, shall affix to the item his seal and the notation "altered by" followed by his signature and the date of such alteration, and the specific description of the alteration.

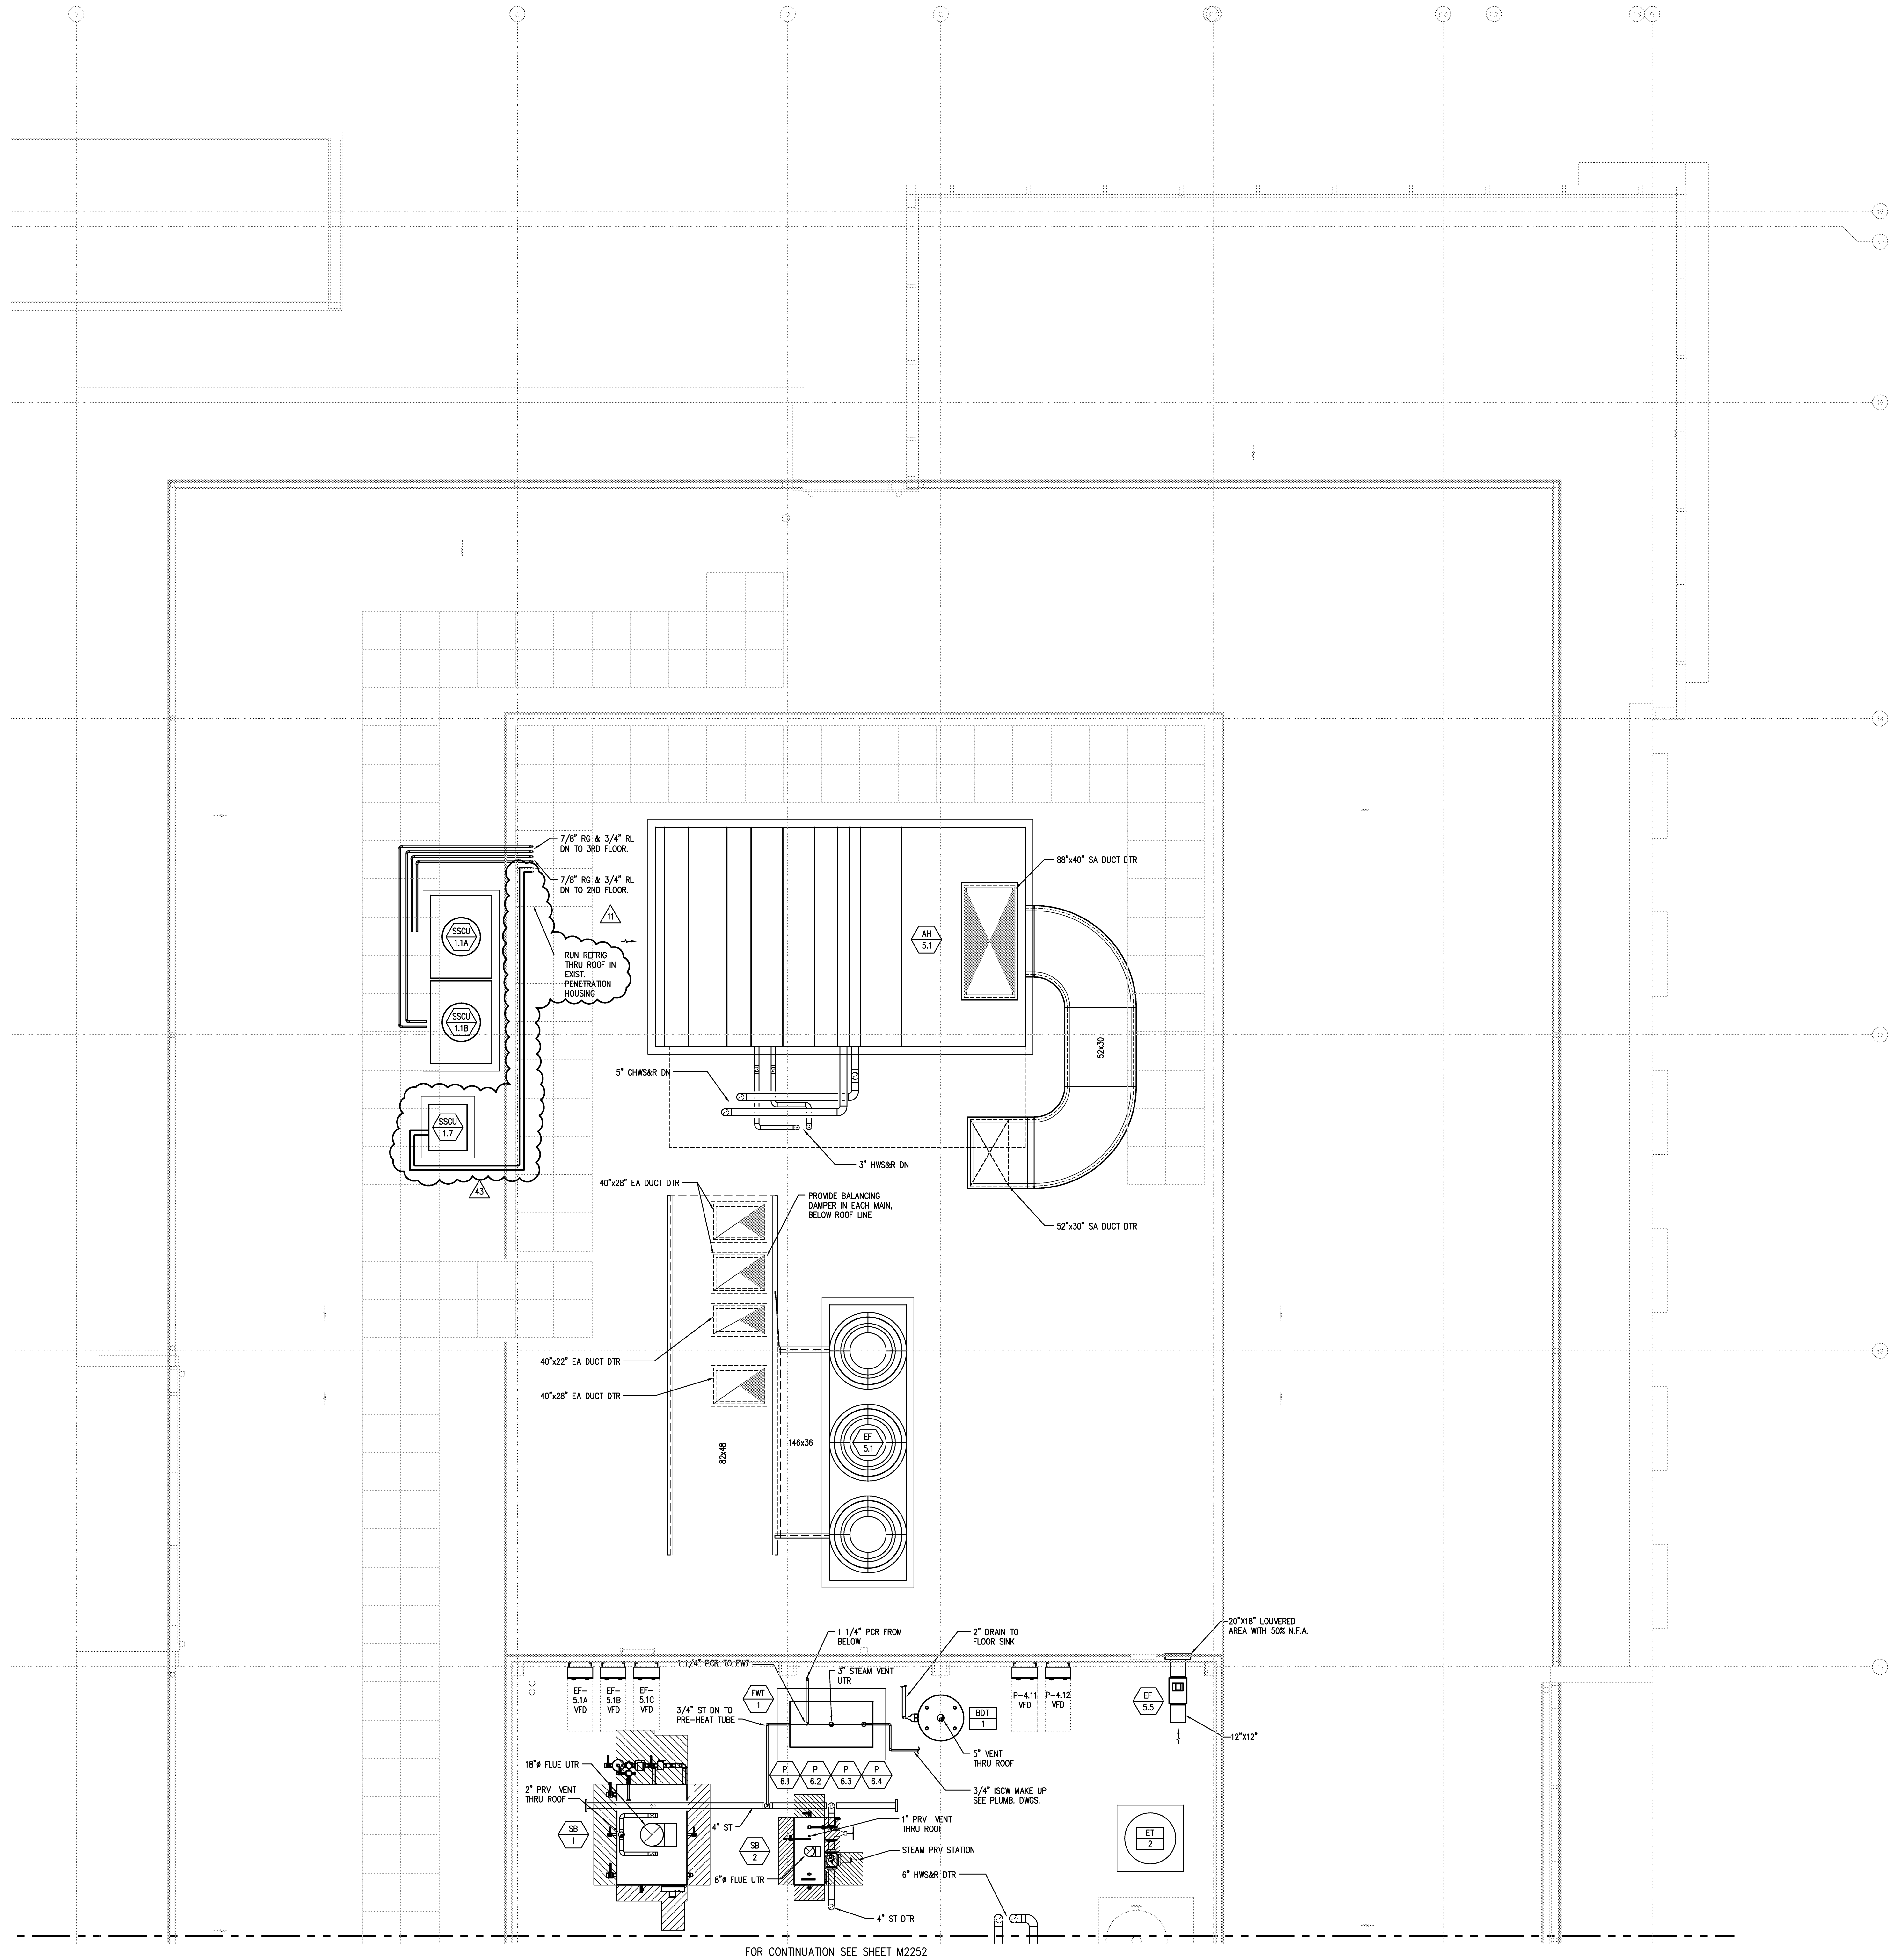

FOR CONTINUATION SEE SHEET M2252
PARTIAL MECHANICAL ROOF PLAN - ZONE 1

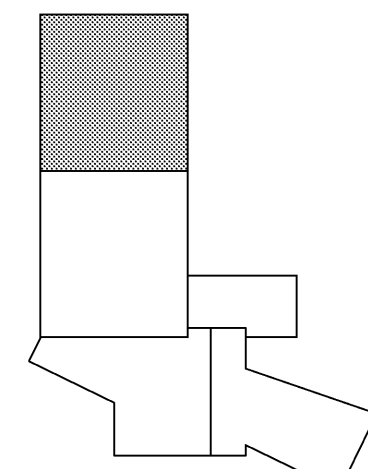


SCALE
1/4" = 1'-0"

1

ISSUED FOR		DATE
BID PK #1	50% Progress	10/06/2008
BID PK #1	50% Progress	10/24/2008
BID PK #1	60 CD	12/01/2008
BID PK #1	100 CD	02/16/2009
BID PK #2	100 CD	03/26/2009
100% CD		05/06/2009
CD 4		01/07/2010
COB 1		02/26/2010
COB 2		02/26/2010
CD 4		04/15/2010
RW PERMIT		05/05/2010
ASH#008 R1		07/01/2010
ASH#005		07/06/2010
ASH#015		07/09/2010
ASH#004		07/12/2010
ASH#008R2		07/19/2010
ASH#010		08/13/2010
ASH#011		08/27/2010
ASH#020		09/20/2010
ASH#018		11/17/2010
ASH#026		12/15/2010
ASH#028R2		01/14/2011
ASH#028		01/21/2011
ASH#028R1		01/28/2011
ASH#018R1		02/16/2011
RFP#1203		02/16/2011
ASH#031		04/01/2011

SANFORD CONSORTIUM FOR REGENERATIVE MEDICINE


2880 TORREY PINES SCENIC DRIVE
LA JOLLA, CALIFORNIA 92037

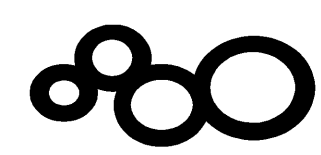

CONSULTANT
Xrith
Xrith Inc./San Diego - North
3870 La Jolla Village Drive, Suite 201
San Diego, CA 92121
619.592.0551 fax 619.592.0555
www.xrith.com

Lankford/Phelps Consortium LLC
1400 La Jolla Village Drive, Suite 201
San Diego, CA 92121
619.592.0551 fax 619.592.0555

FENTRESS ARCHITECTS
441 Broadway, Denver, CO 80202
(303) 733-6800
FENTRESS ARCHITECTS
DAVIS DAVIS ARCHITECTS
3001 Fifth Avenue San Diego, CA 92107

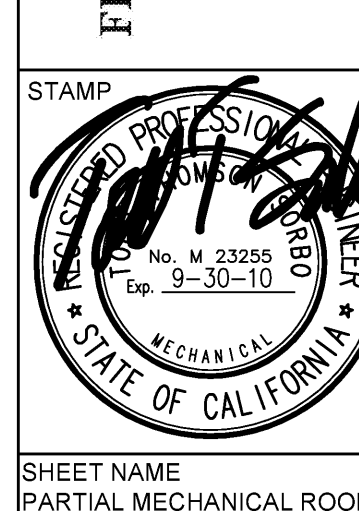

SHEET NAME
PARTIAL MECHANICAL ROOF
PLAN - ZONE 1
DRAWN BY: Author
PROJECT #: 200725.000
SHEET NUMBER

M2251