



COPYRIGHT © FENTRESS ARCHITECTS	
ISSUED FOR DATE	07/14/2009
Pre-Schematic Design	07/28/2008
Schematic Design	10/08/2008
BID PK #1	10/24/2008
BID PK #1 80 CD	12/01/2008
BID PK #1 100 CD	02/16/2009
BID PK #2 100 CD	03/26/2009
100% CD	05/08/2009
CD 4	01/07/2010
COB 1	02/26/2010
COB 2	02/26/2010
CD 4	04/15/2010
RVP PERMIT	05/05/2010
ASIM008 RT	07/01/2010
ASIM009	07/06/2010
ASIM015	07/09/2010
ASIM004	07/12/2010
ASIM005	07/19/2010
ASIM010	08/13/2010

SANFORD CONSORTIUM FOR REGENERATIVE MEDICINE
2880 TORREY PINES SCENIC DRIVE
LA JOLLA, CALIFORNIA 92037

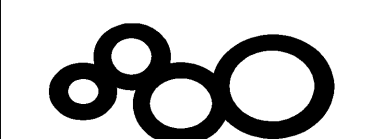

CONSULTANT
Xyth
3701 Torrey Pines Drive, Suite 100
La Jolla, CA 92037
Tel: (619) 597-5555
Fax: (619) 597-5555


FENTRESS ARCHITECTS
418 Broadway, Denver, CO 80202
303.733.0000
303.733.0001
303.733.0002
303.733.0003
303.733.0004
303.733.0005
303.733.0006
303.733.0007
303.733.0008
303.733.0009
303.733.0010
303.733.0011
303.733.0012
303.733.0013
303.733.0014
303.733.0015
303.733.0016
303.733.0017
303.733.0018
303.733.0019
303.733.0020

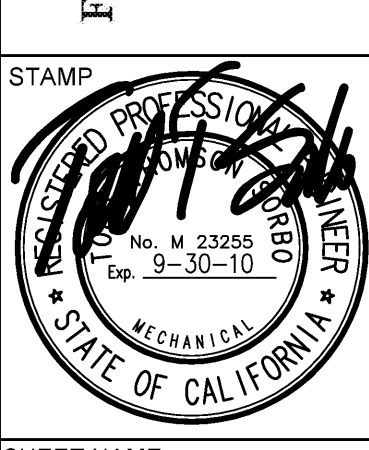

SHEET NAME
PARTIAL MECHANICAL PIPING
SECOND FLOOR PLAN - ZONE 1
DRAWN BY: Author
PROJECT # 200725.000
SHEET NUMBER

MP2221

- KEYNOTES:**
- 1/2" RG & 1/4" RL DN TO 1ST FLOOR.
 - 1/2" RG & 1/4" RL UP TO 3RD FLOOR.
 - 3/4", 5/8", & 3/8" RL OR RG PIPE UP TO 3RD FLOOR AND DOWN TO 1ST FLOOR.
 - 5/8" RG & 3/8" RL DN TO 1ST FLOOR.
 - NOT USED.
 - 7/8" RG & 3/4" RL UP TO 500 ON ROOF.
 - BC PANEL.

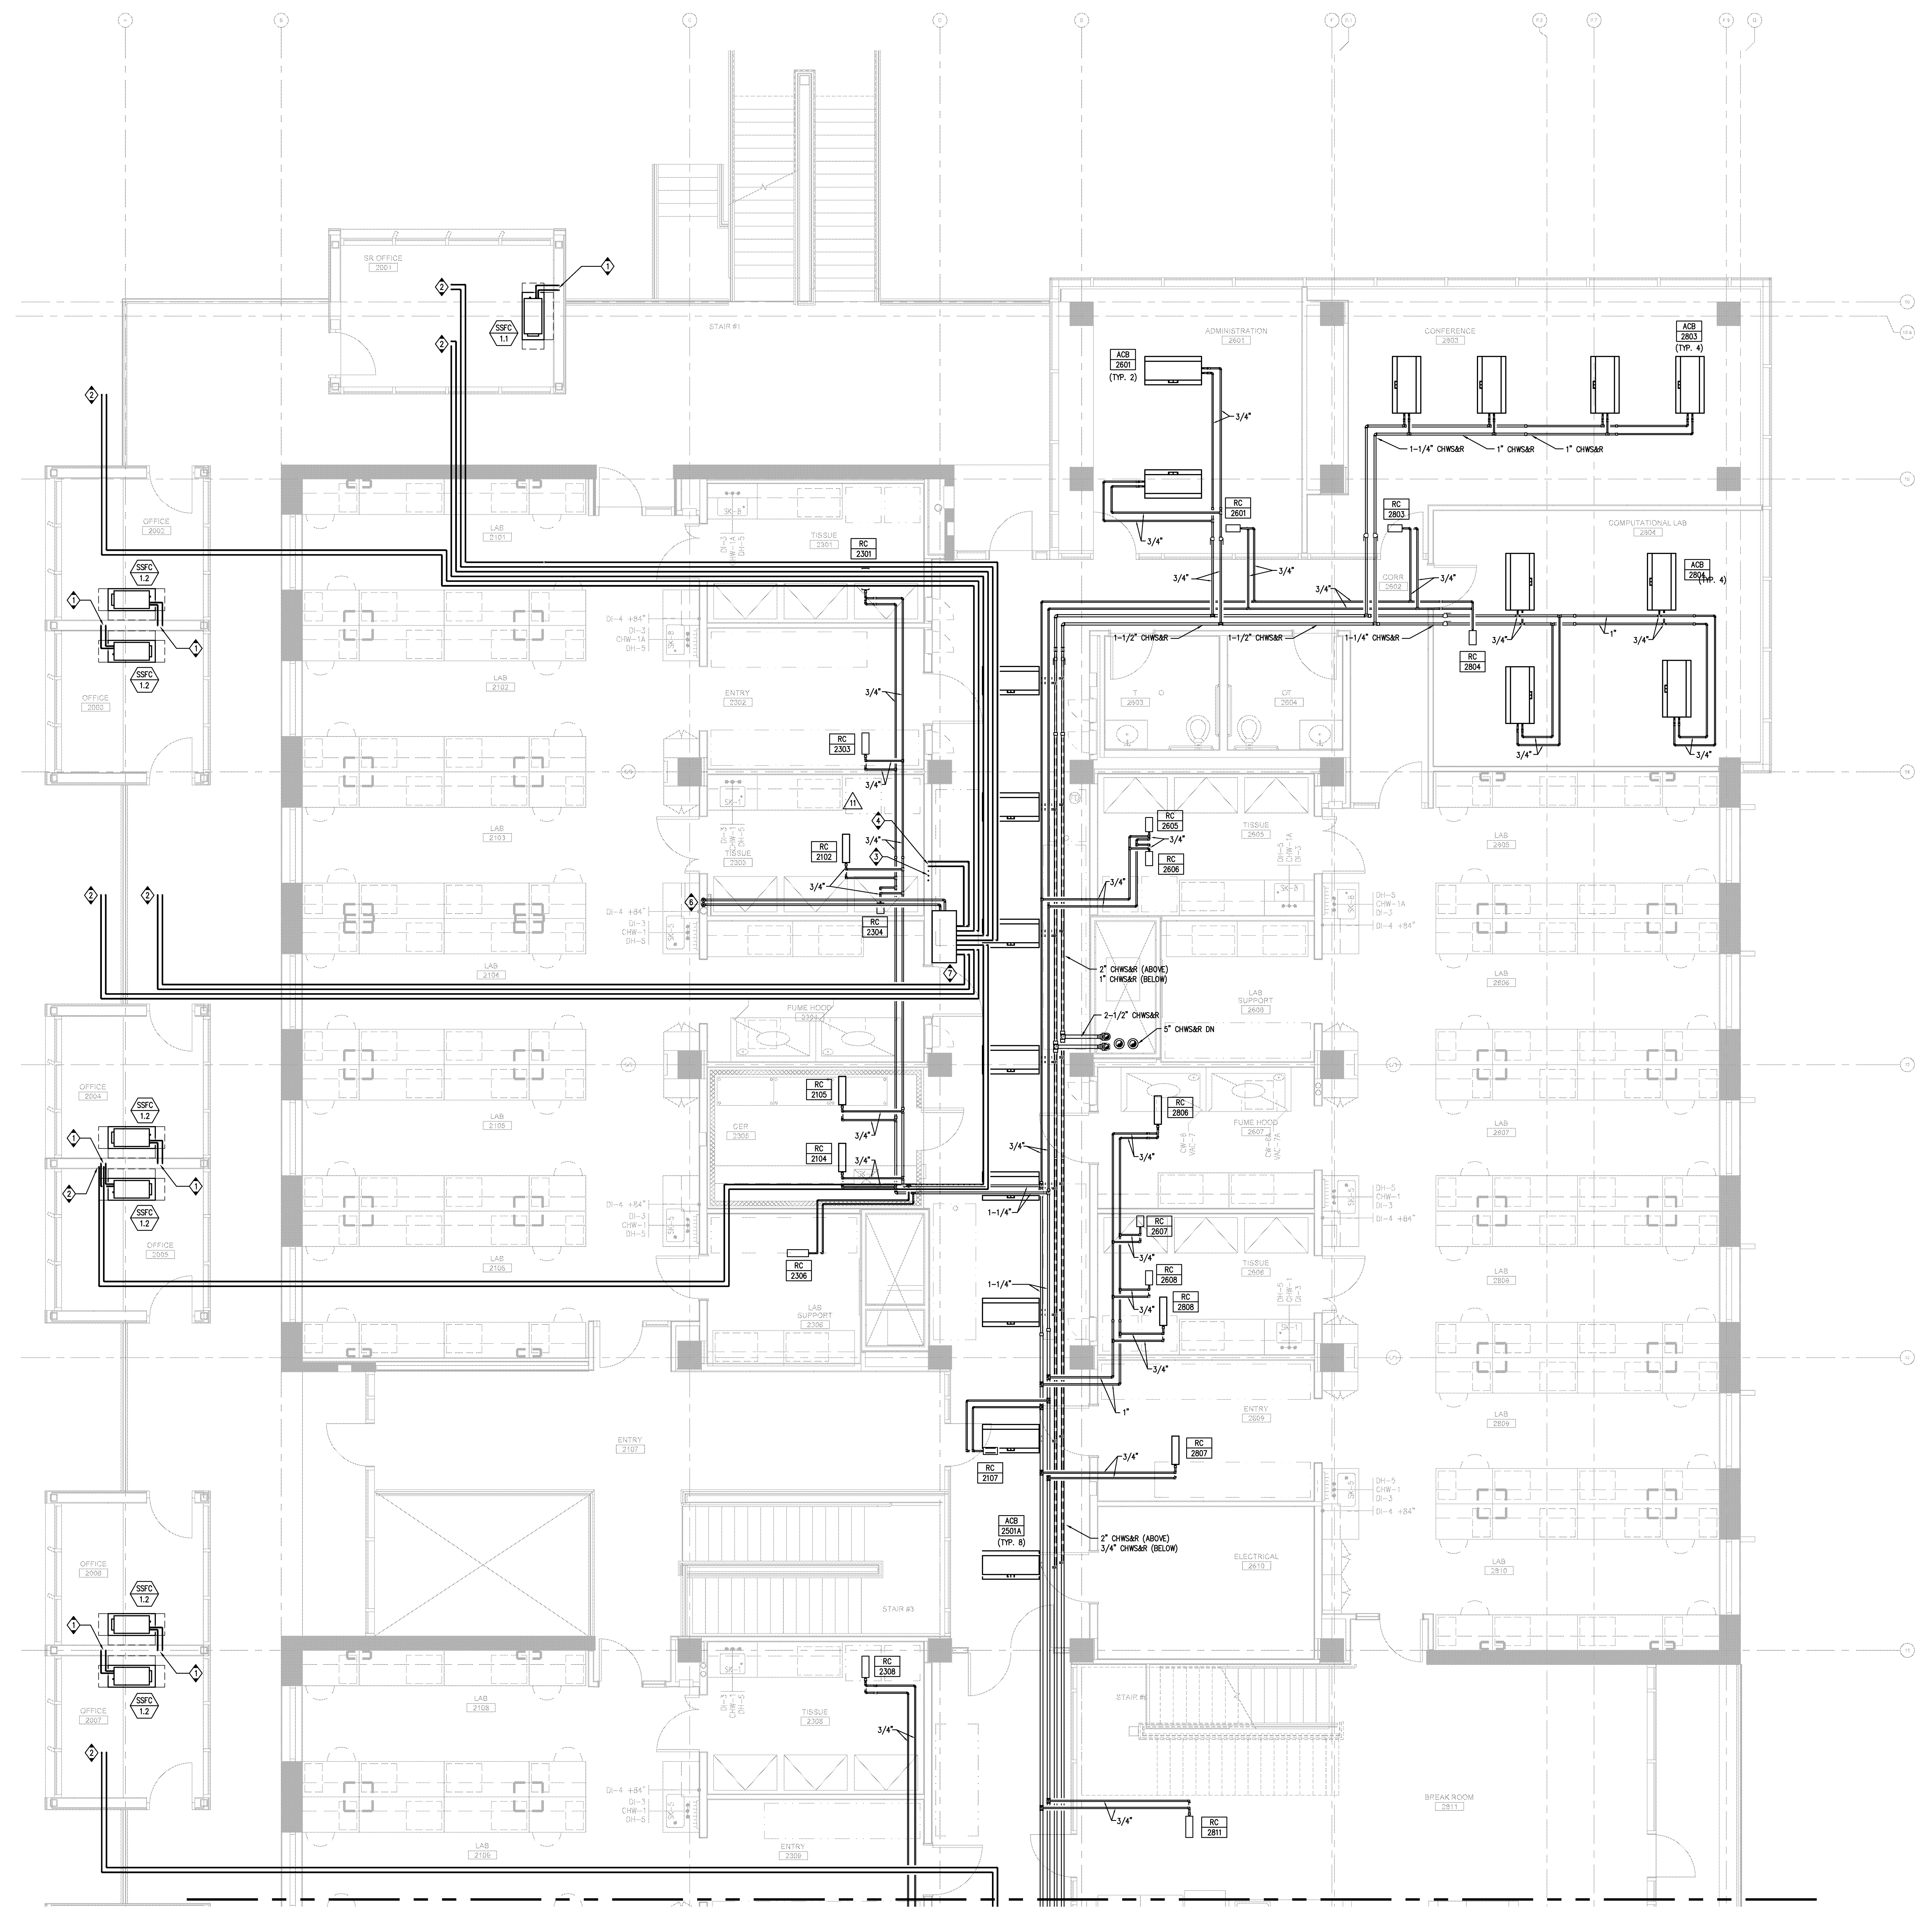

PARTIAL MECHANICAL PIPING SECOND FLOOR PLAN - ZONE 1

SCALE 1/4" = 1'-0" 1

10/2/2009 4:42:10 PM
F:\2007\25\000\MP2221.dwg
File Path

Warning: It is a violation of the law for any person, unless acting under the direction of a licensed architect, to alter an item in any way. If an item in this document is altered, the altering architect, if other than the architect of record, shall affix the item his seal and the notation "altered by" followed by his signature and the date of such alteration, and the specific description of the alteration.