


A.H. UNIT HEATING/COOLING COIL PIPING

SCALE NONE


16

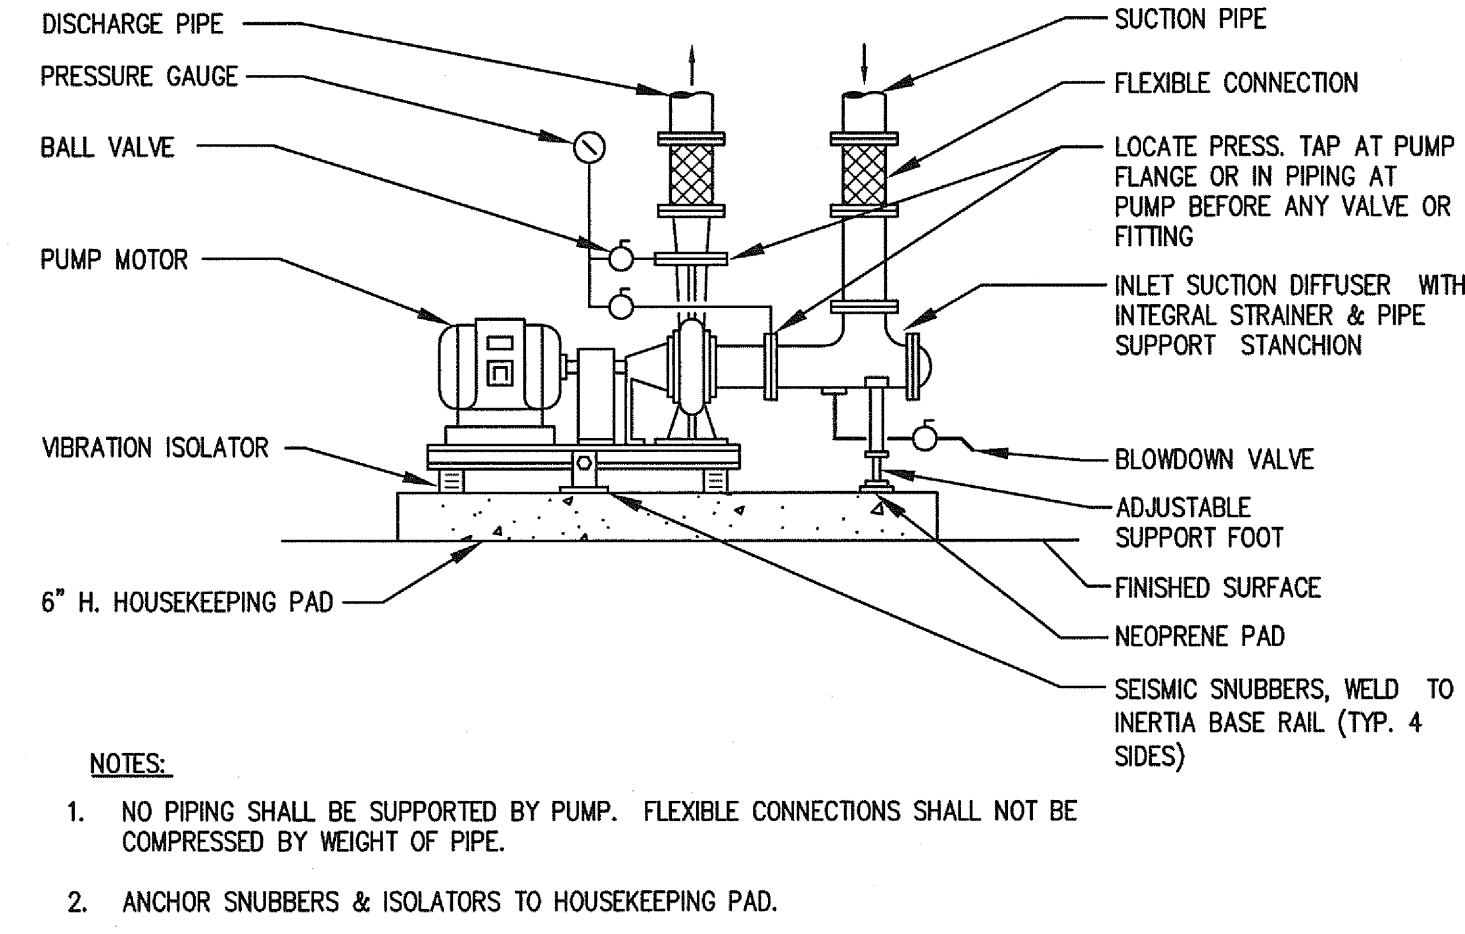

PUMP DETAIL

SCALE NONE


11

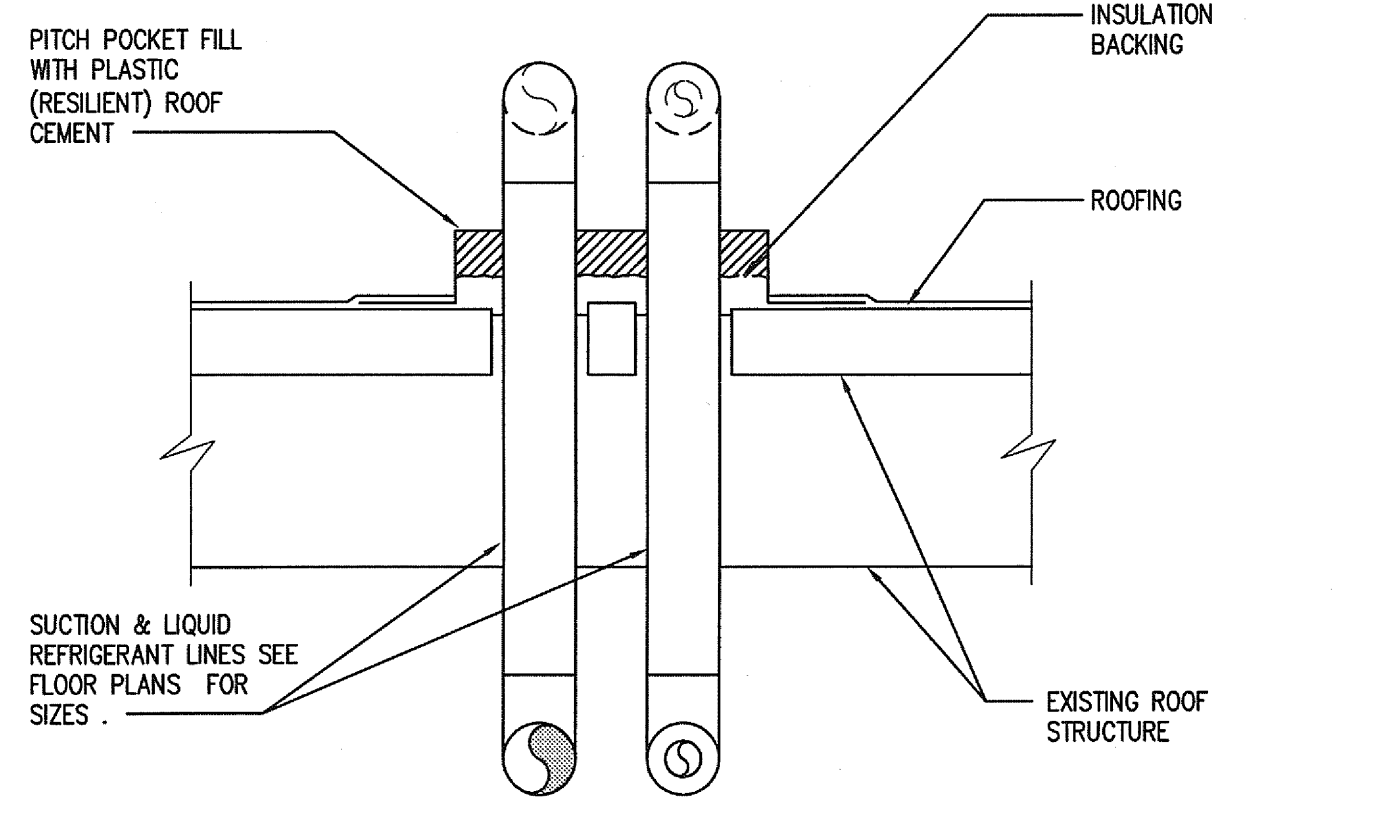

REFRIGERANT PIPING THRU ROOF

SCALE NONE


6

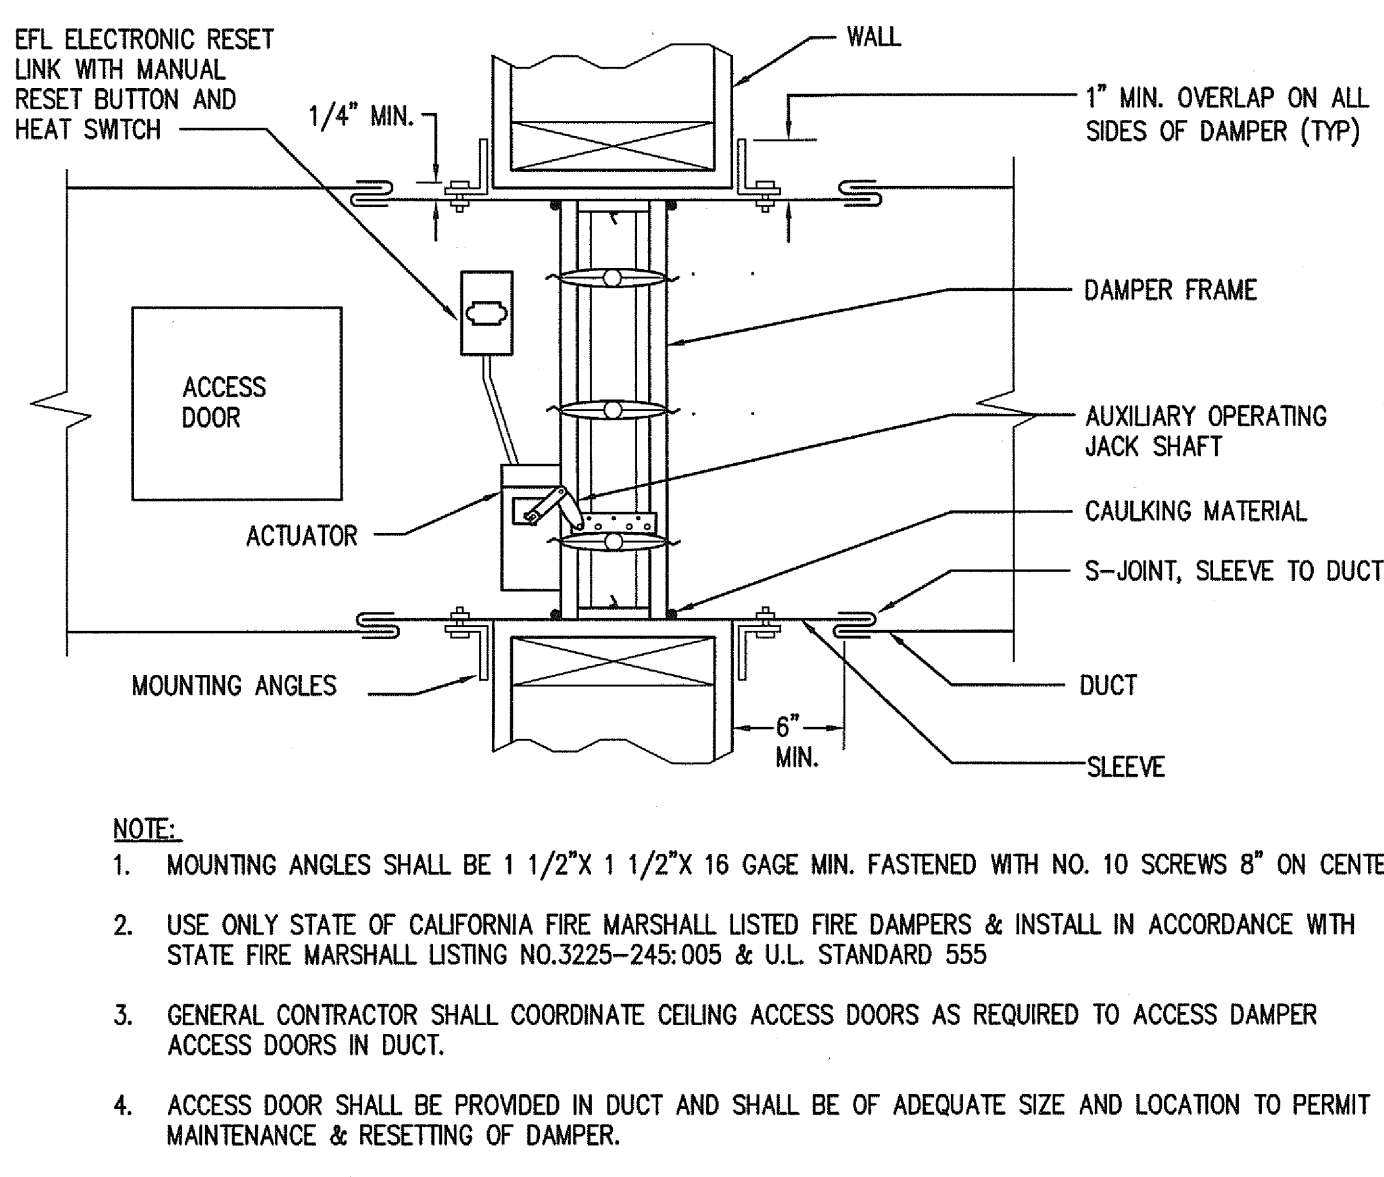

COMBINATION SMOKE / FIRE DAMPER

SCALE NONE


1

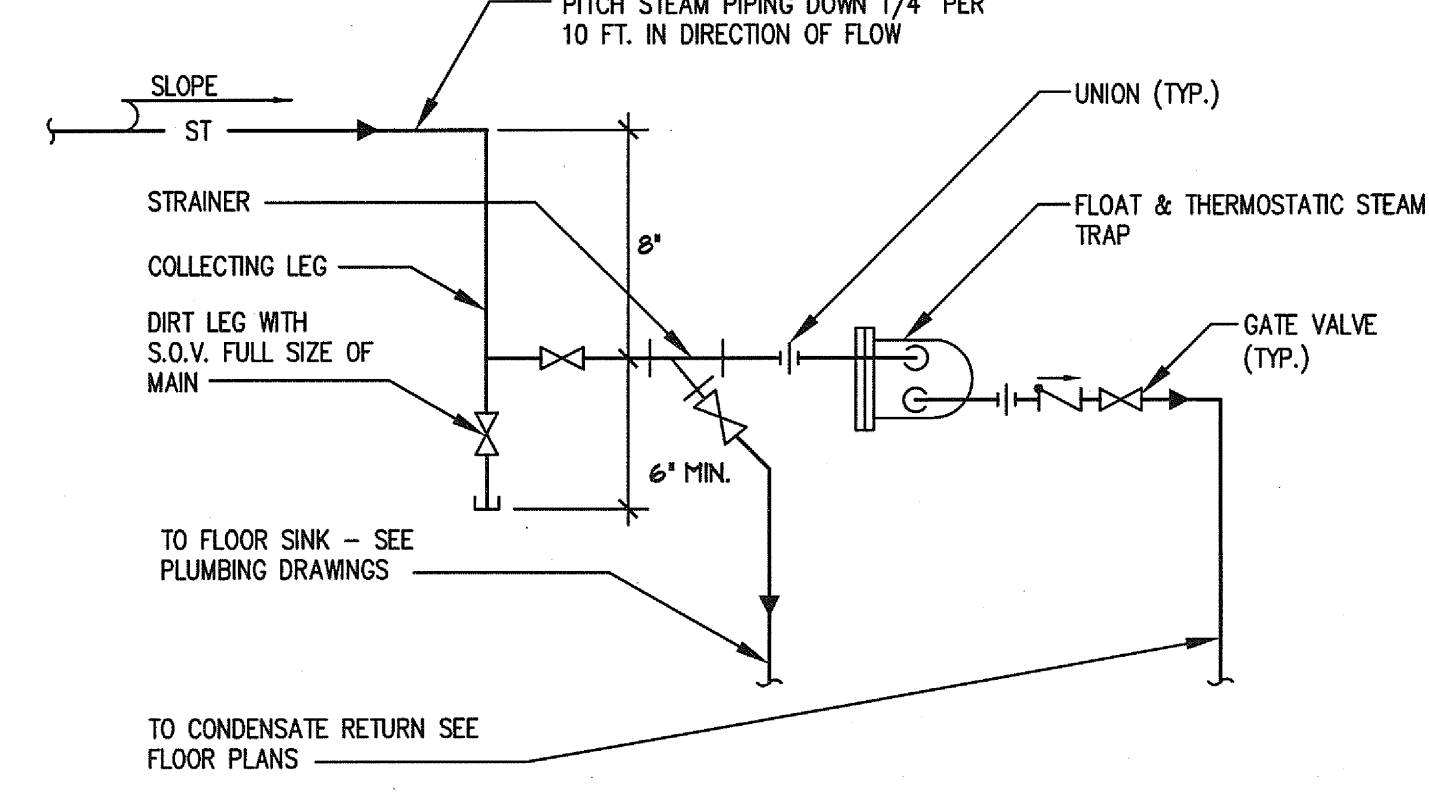

STEAM MAIN TRAP PIPING

SCALE NONE


17

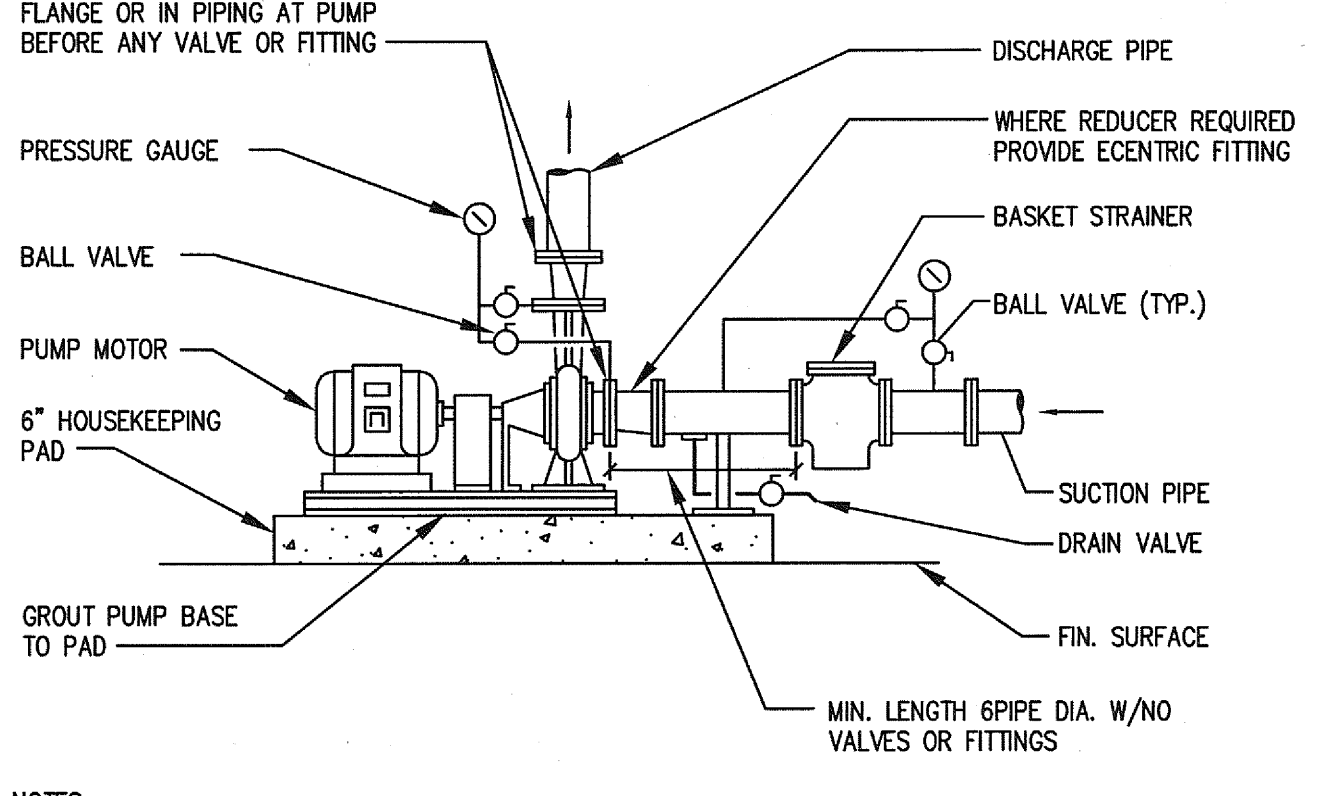

CONDENSER WATER PUMP DETAIL

SCALE NONE


12

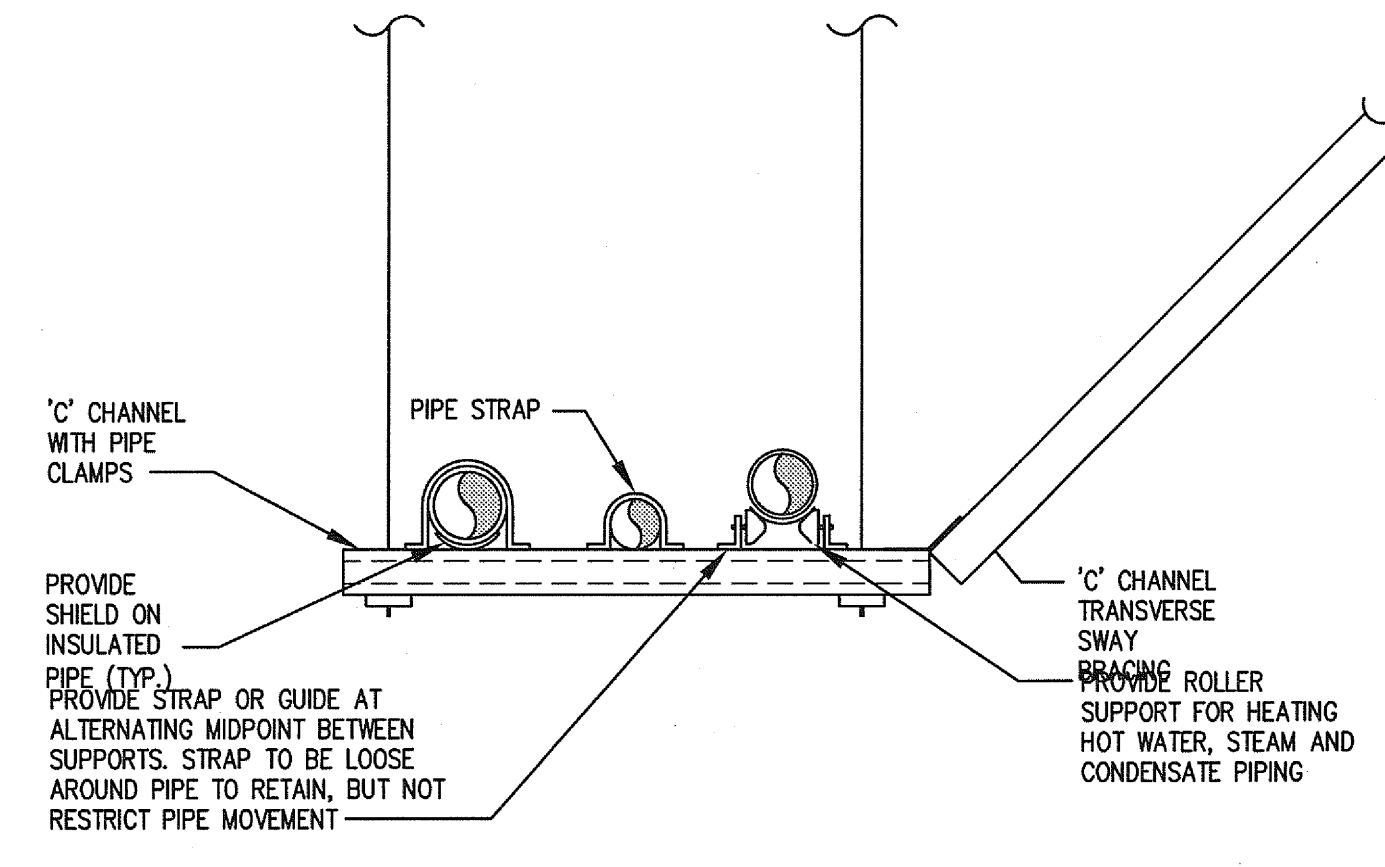

TRAPEZE PIPE SUPPORT

SCALE NONE


7

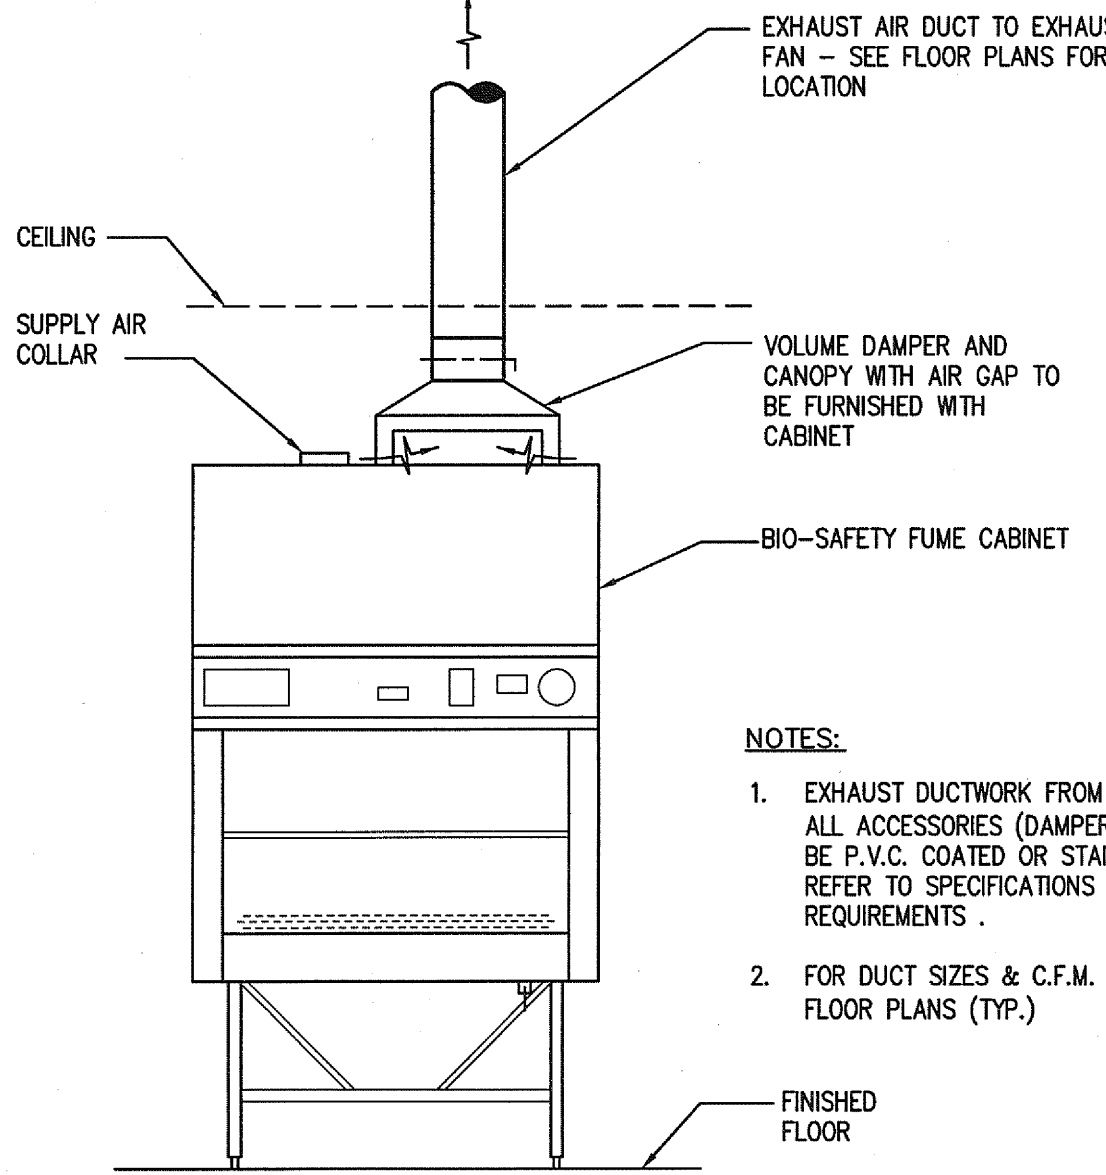

BIO-SAFETY FUME CABINET (WITH AIR GAP)

SCALE NONE


2

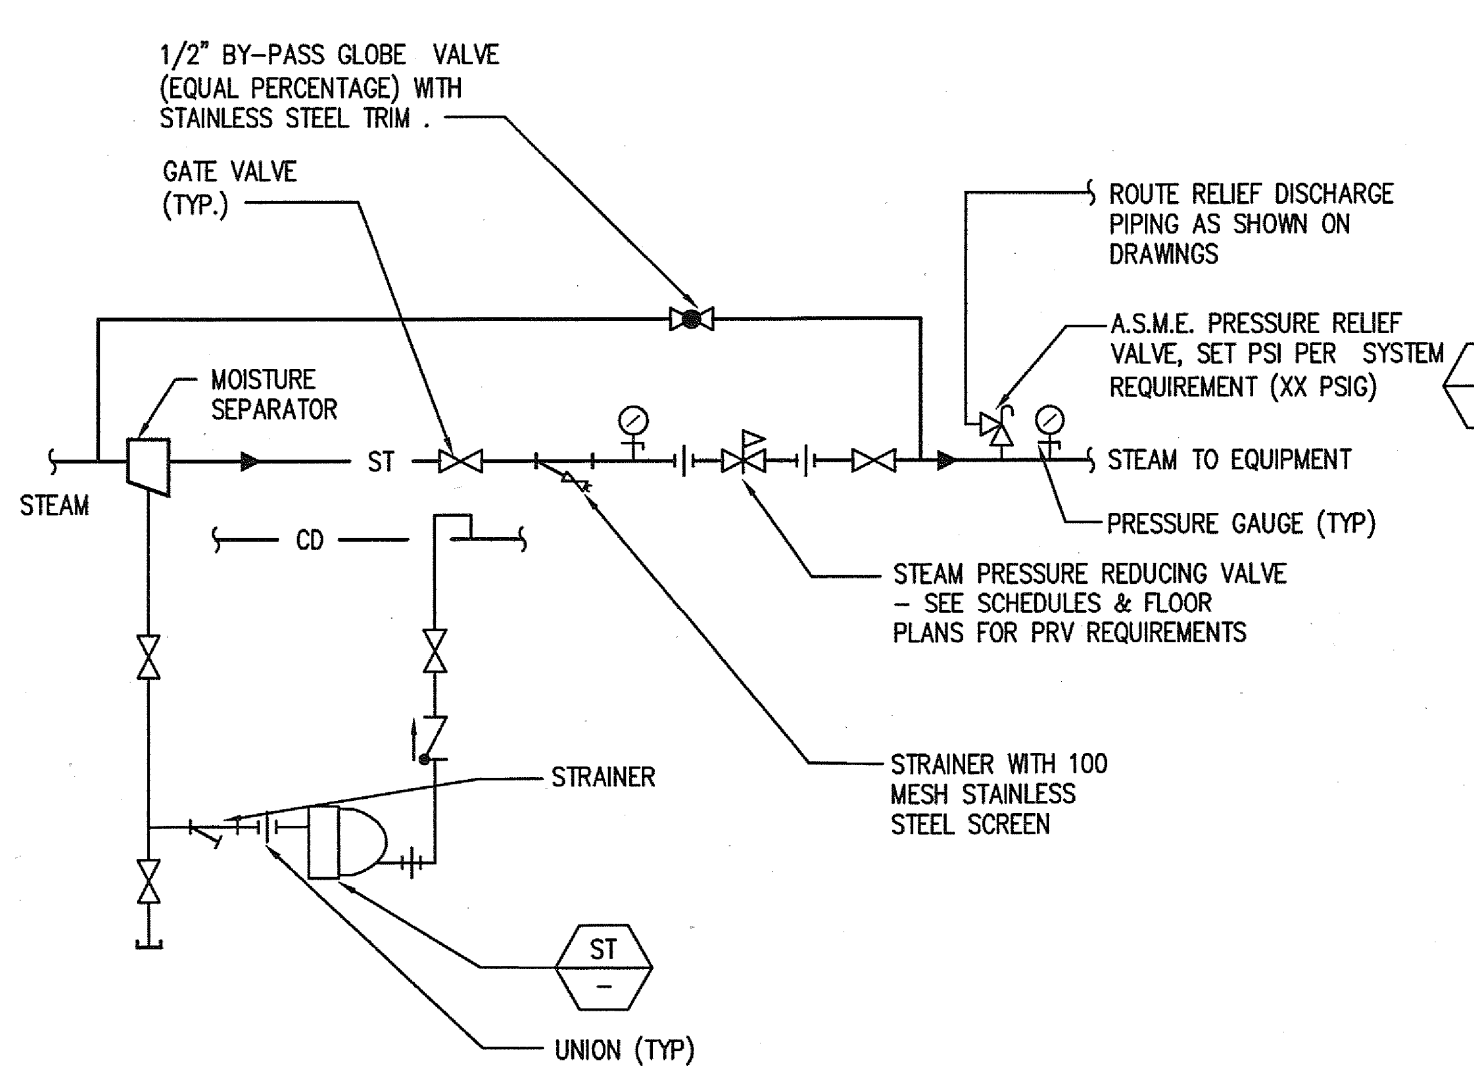

STEAM PRESSURE REDUCING STATION

SCALE NONE


18

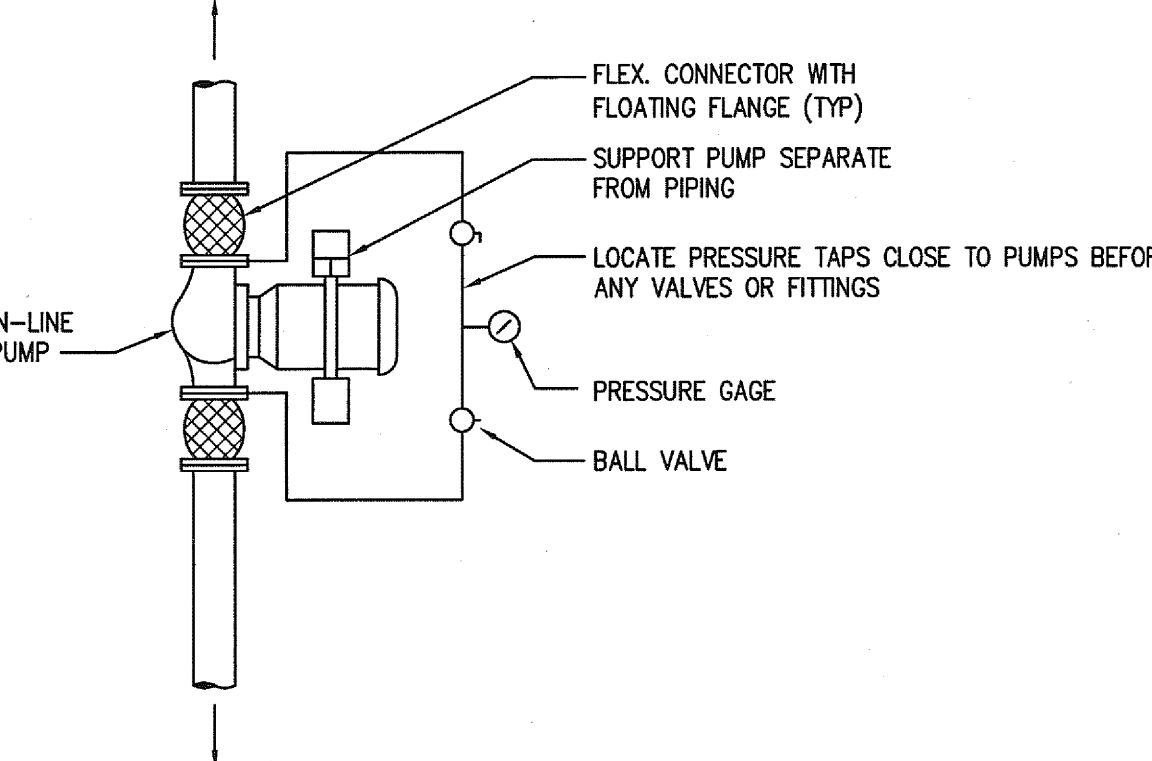

IN-LINE PUMP PIPING DETAIL

SCALE NONE


13

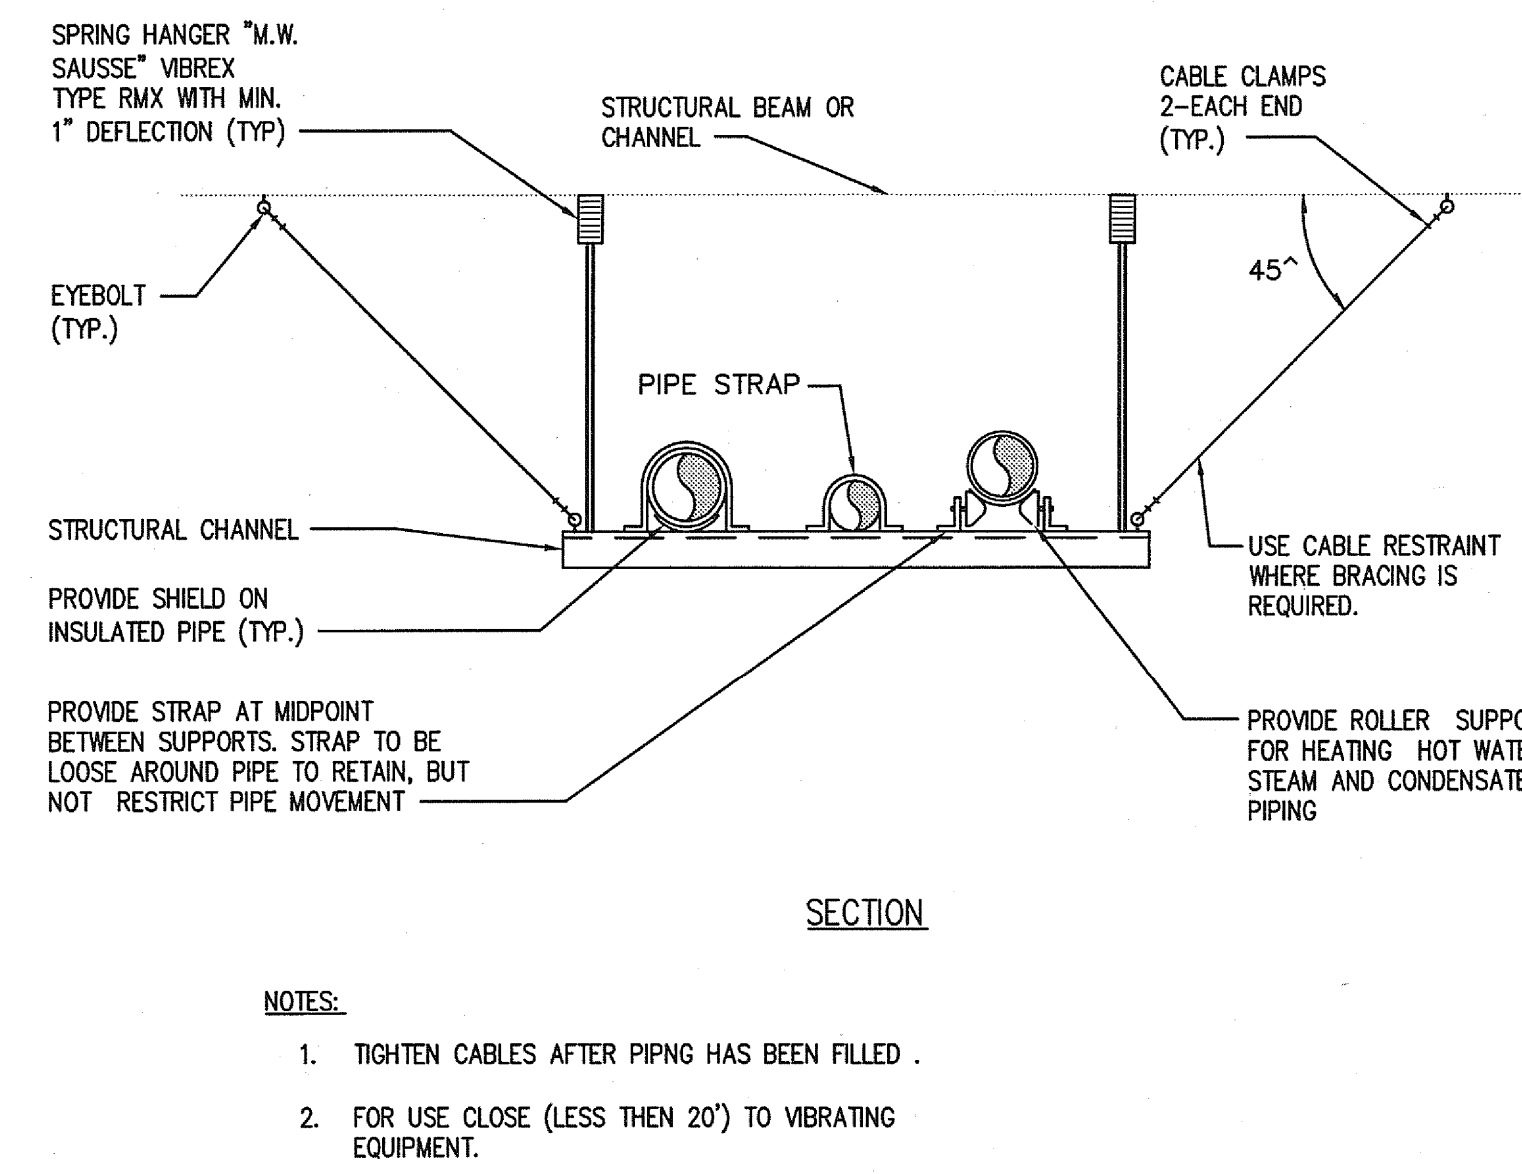

SUSPENDED PIPE SUPPORTS

SCALE NONE


8

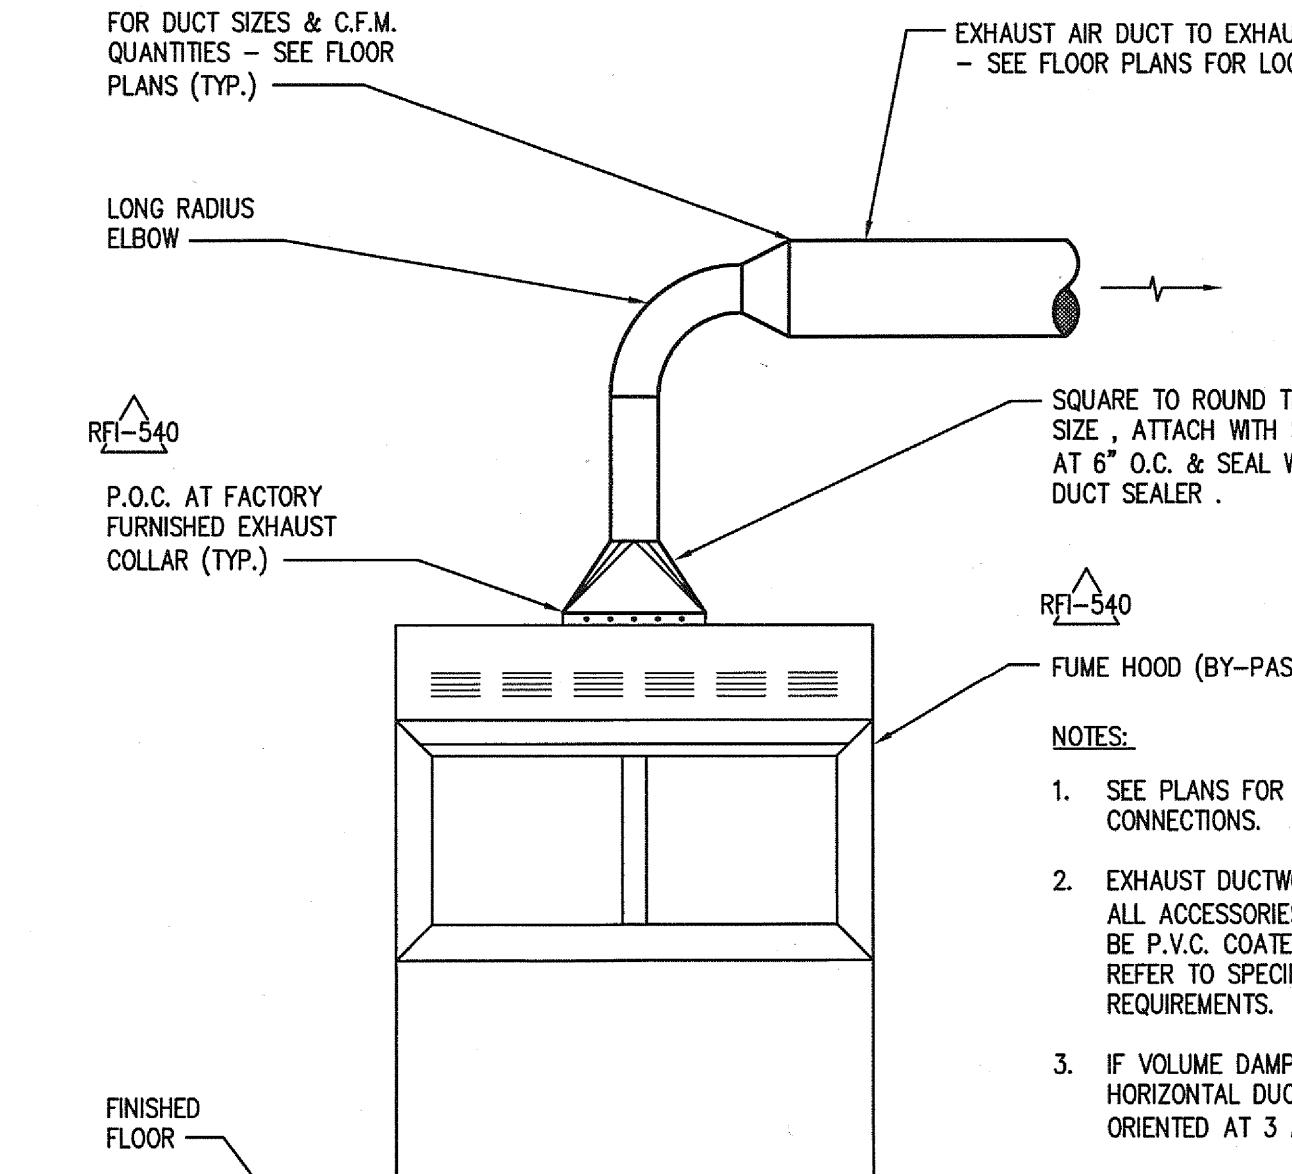

FUME HOOD CONNECTION (SINGLE)

SCALE NONE


3

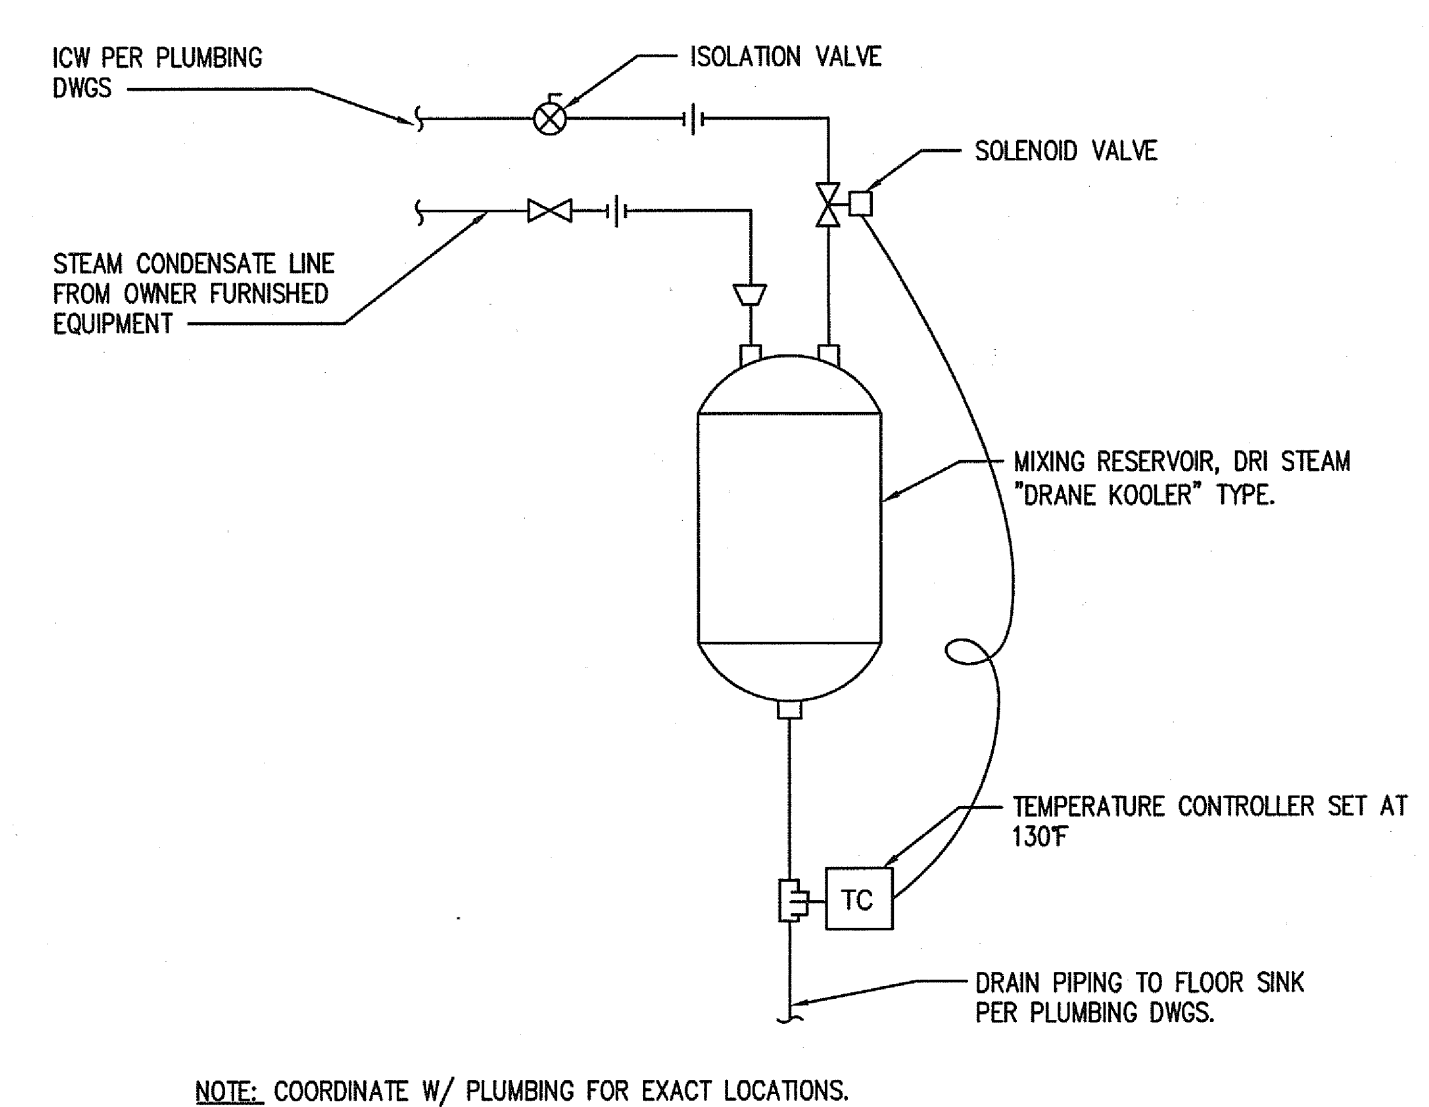

STEAM CONDENSATE COOLER DRAIN PIPING

SCALE NONE


19

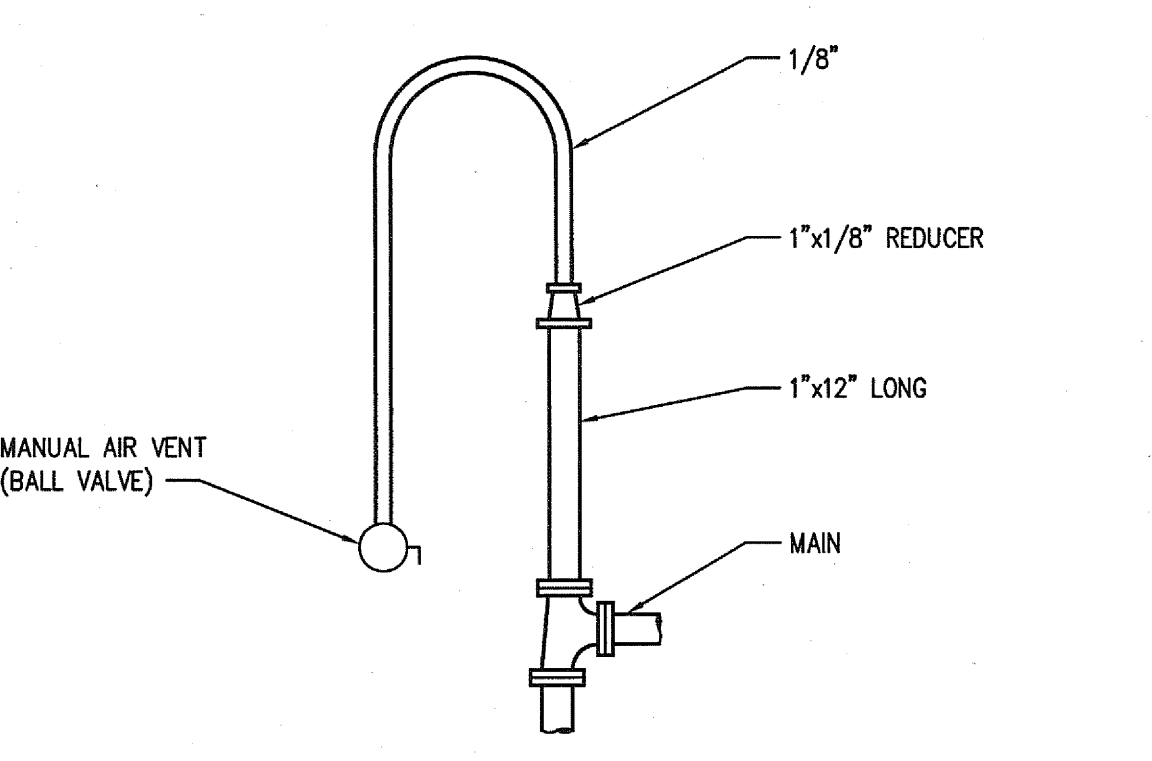

TYPICAL AIR CHAMBER

SCALE NONE


14

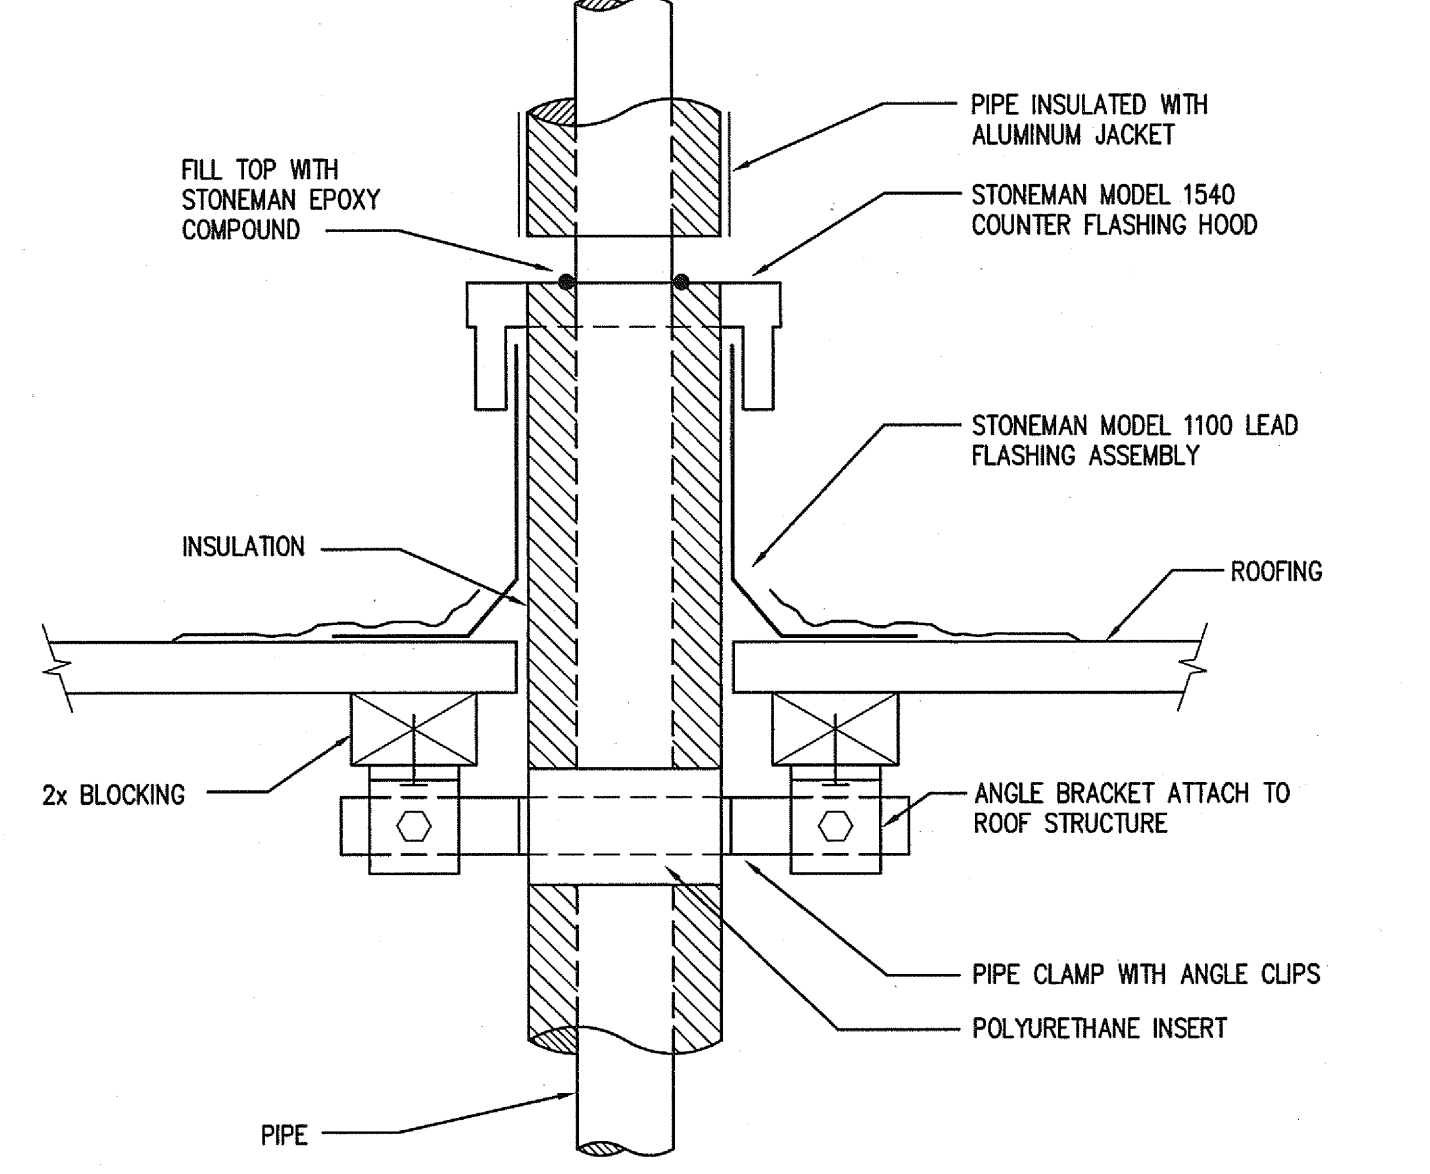

INSULATED PIPE THRU ROOF DETAIL

SCALE NONE


9

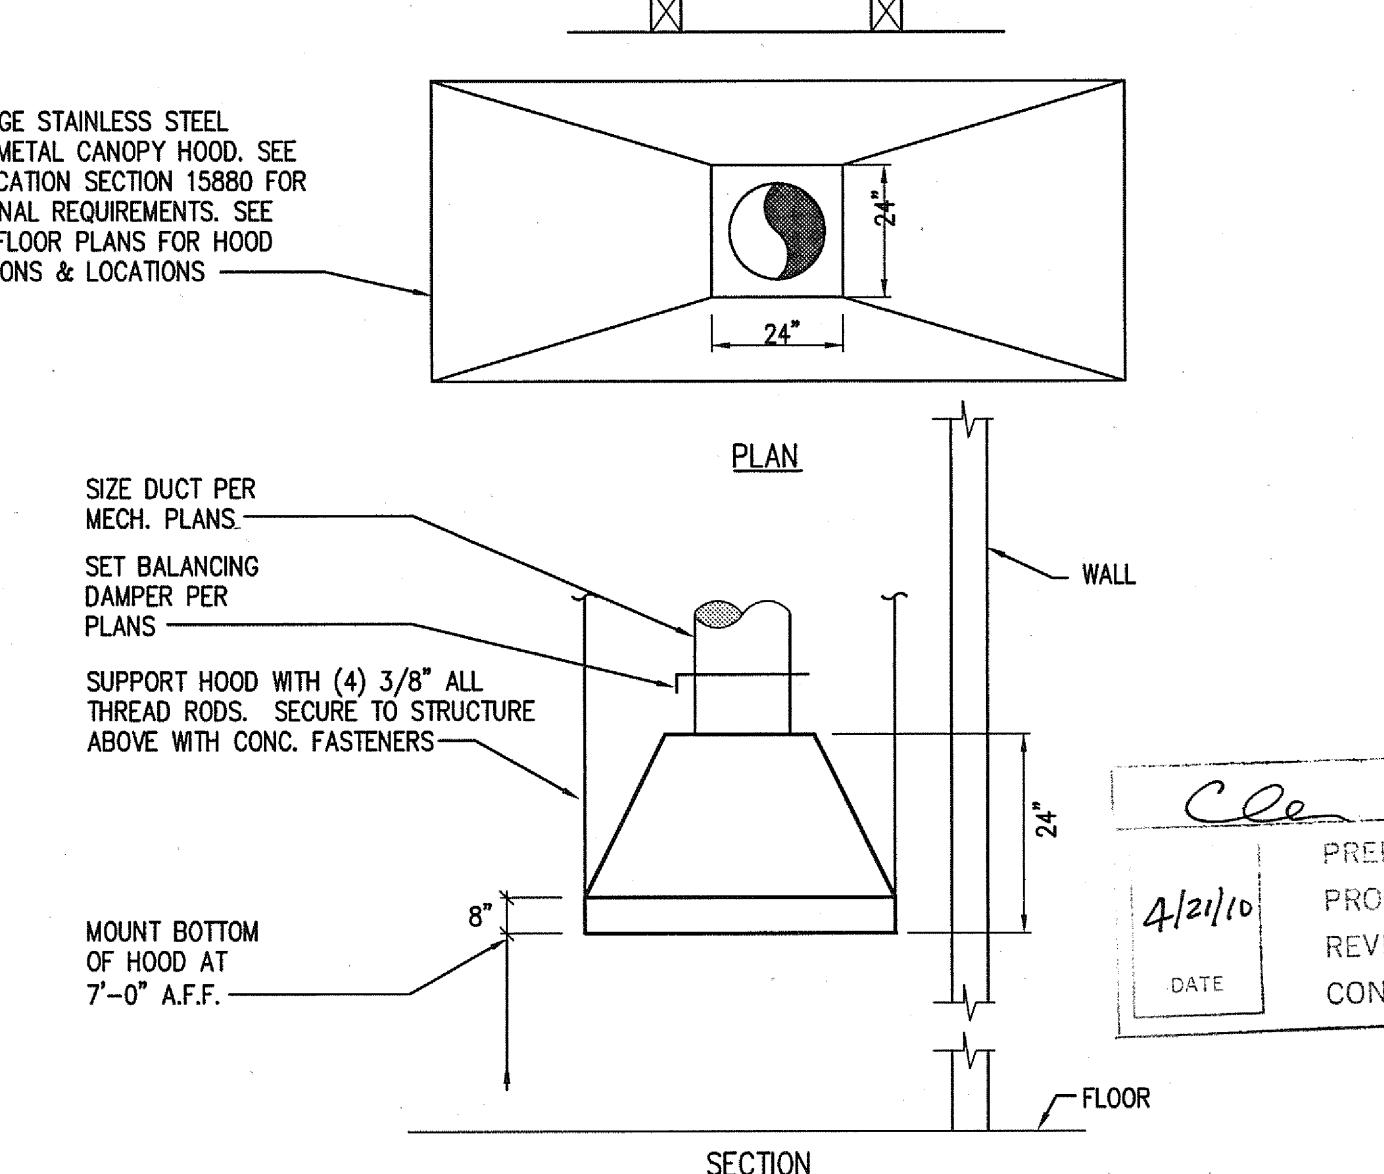

CANOPY HOOD

SCALE NONE


4

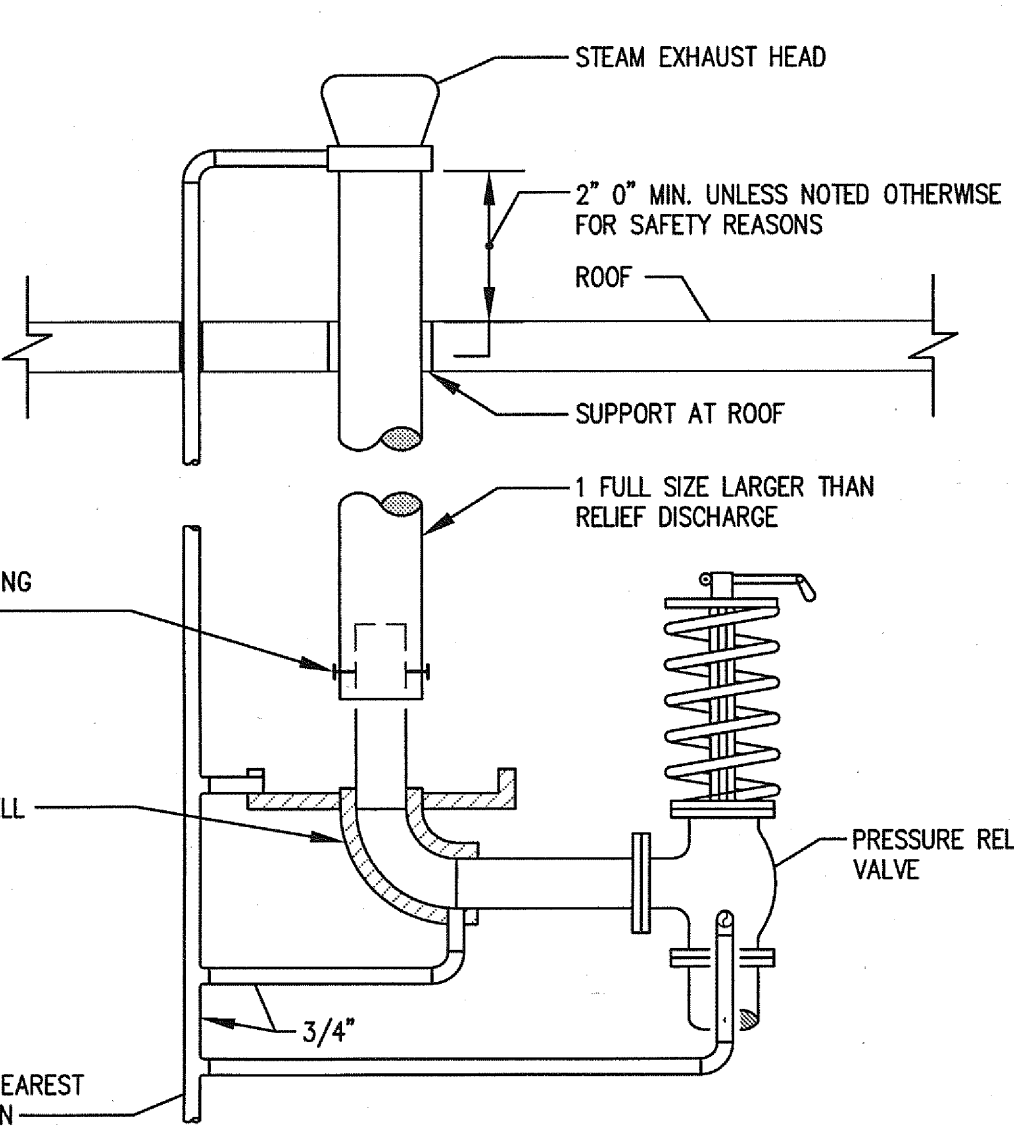

RELIEF VALVE PIPING DETAIL

SCALE NONE


20

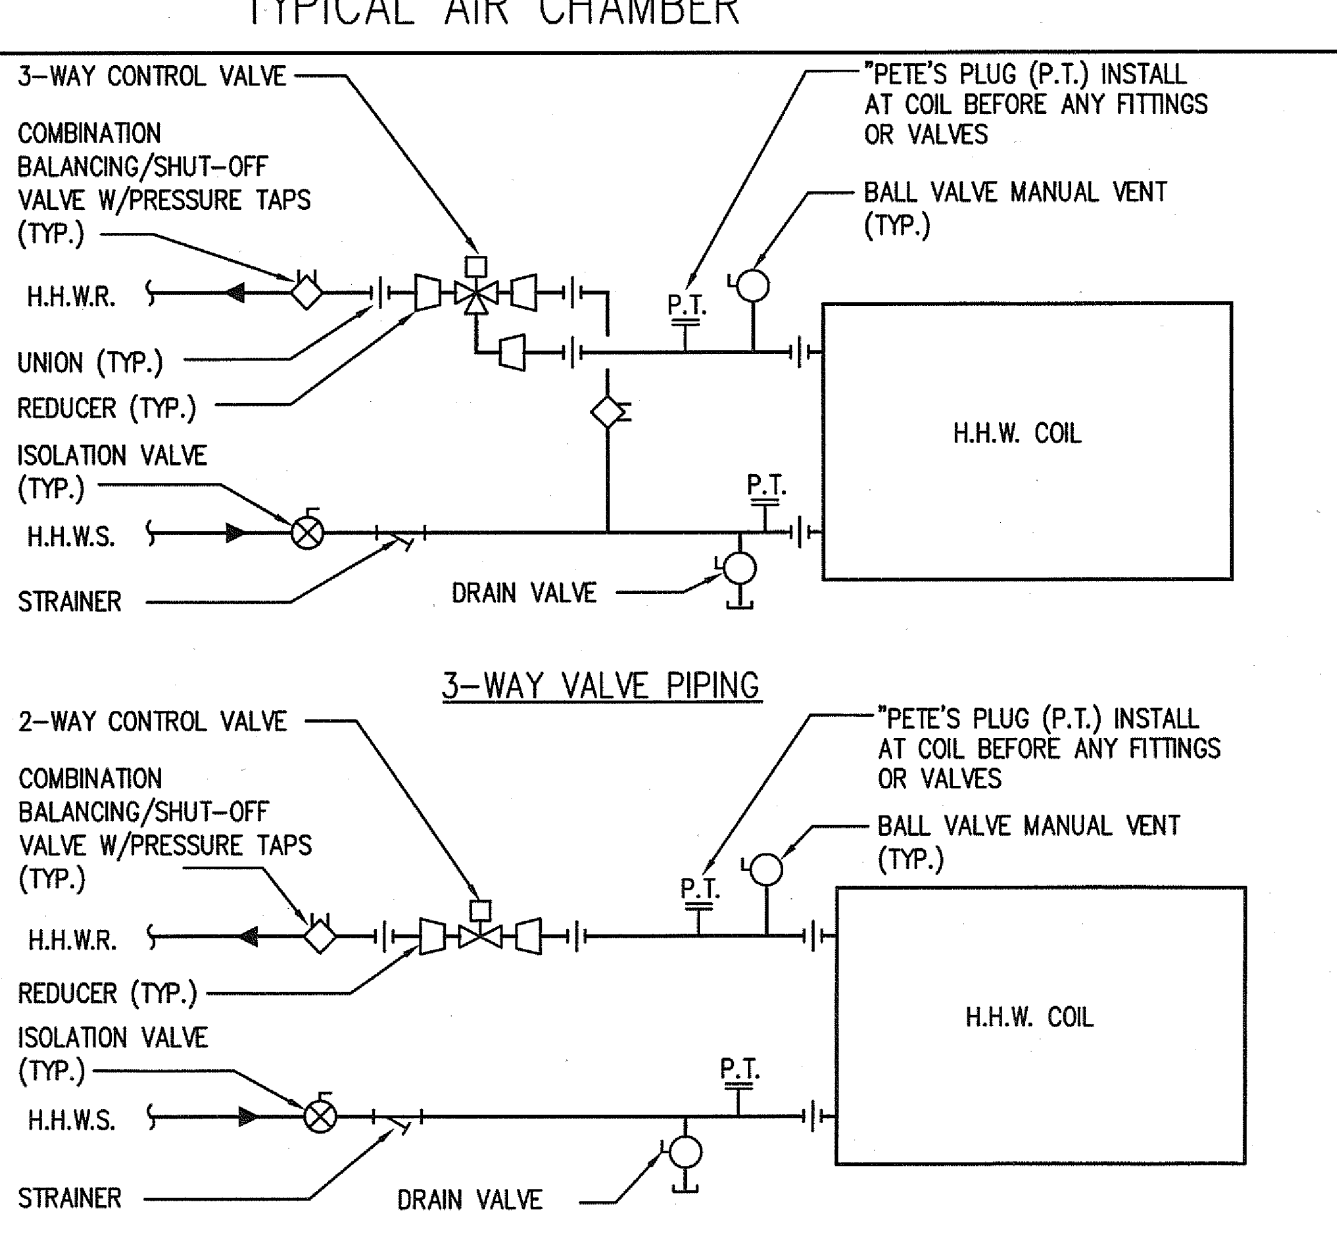

UNITARY HEATING/COOLING COIL PIPING

SCALE NONE


15

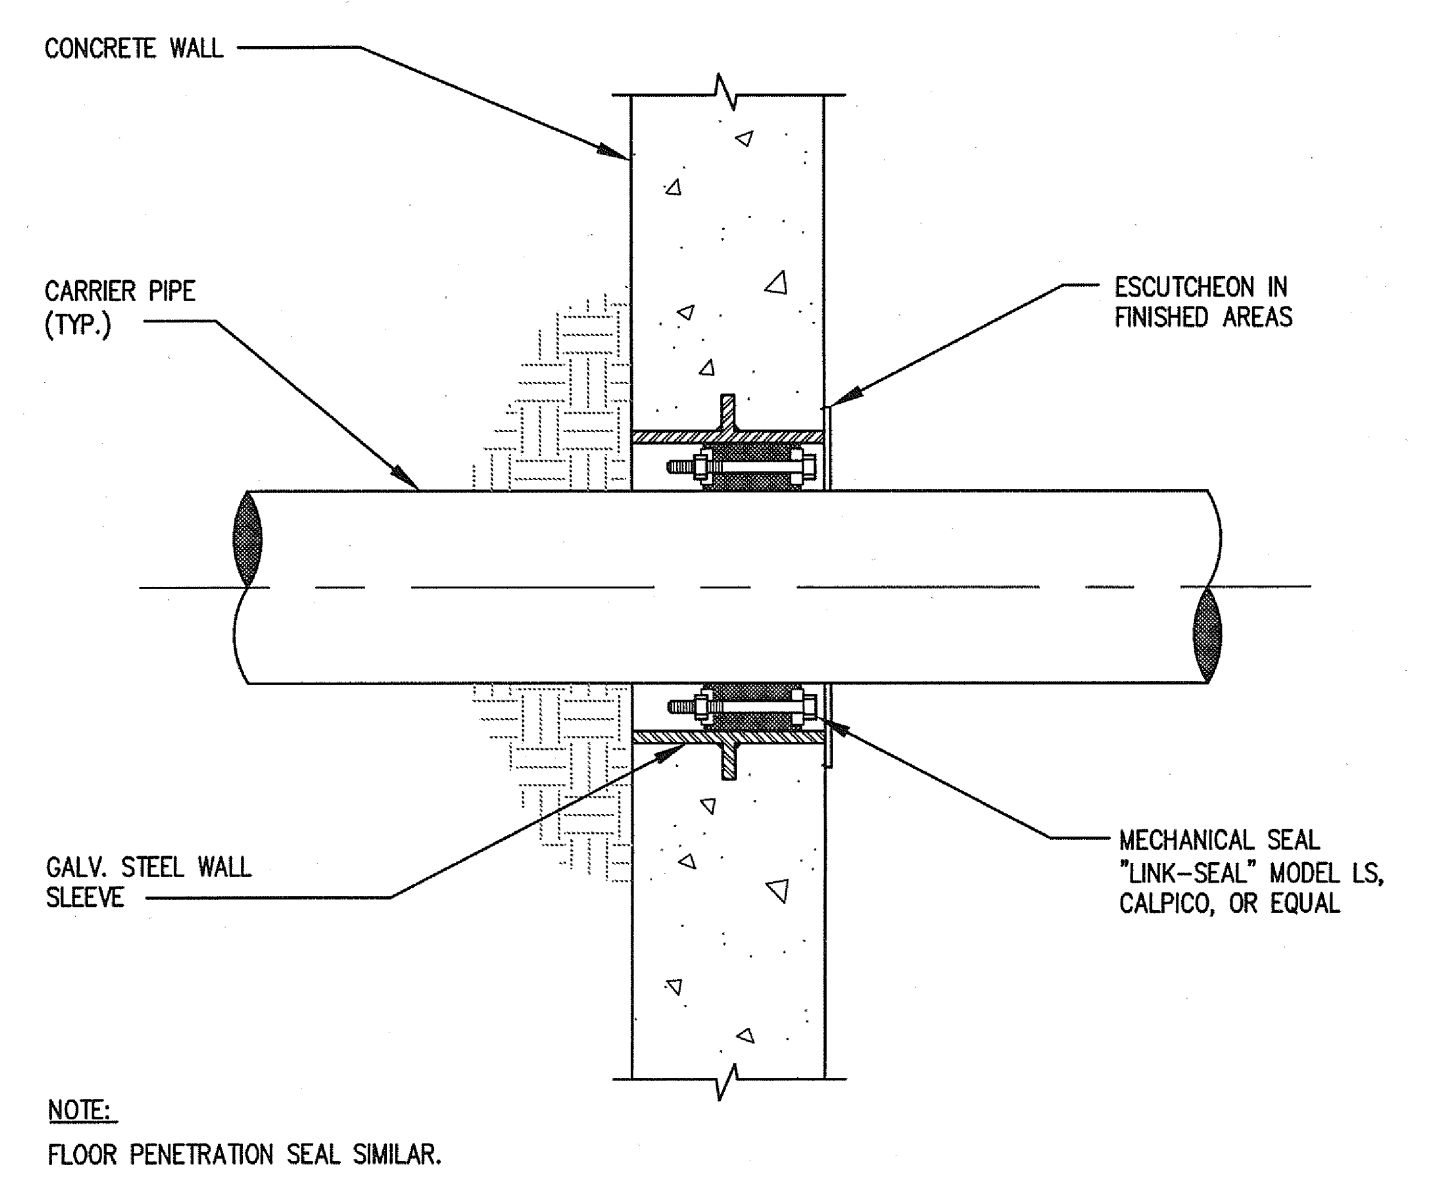

PIPE THRU CONCRETE EXTERIOR BELOW GRADE WALL

SCALE NONE

10

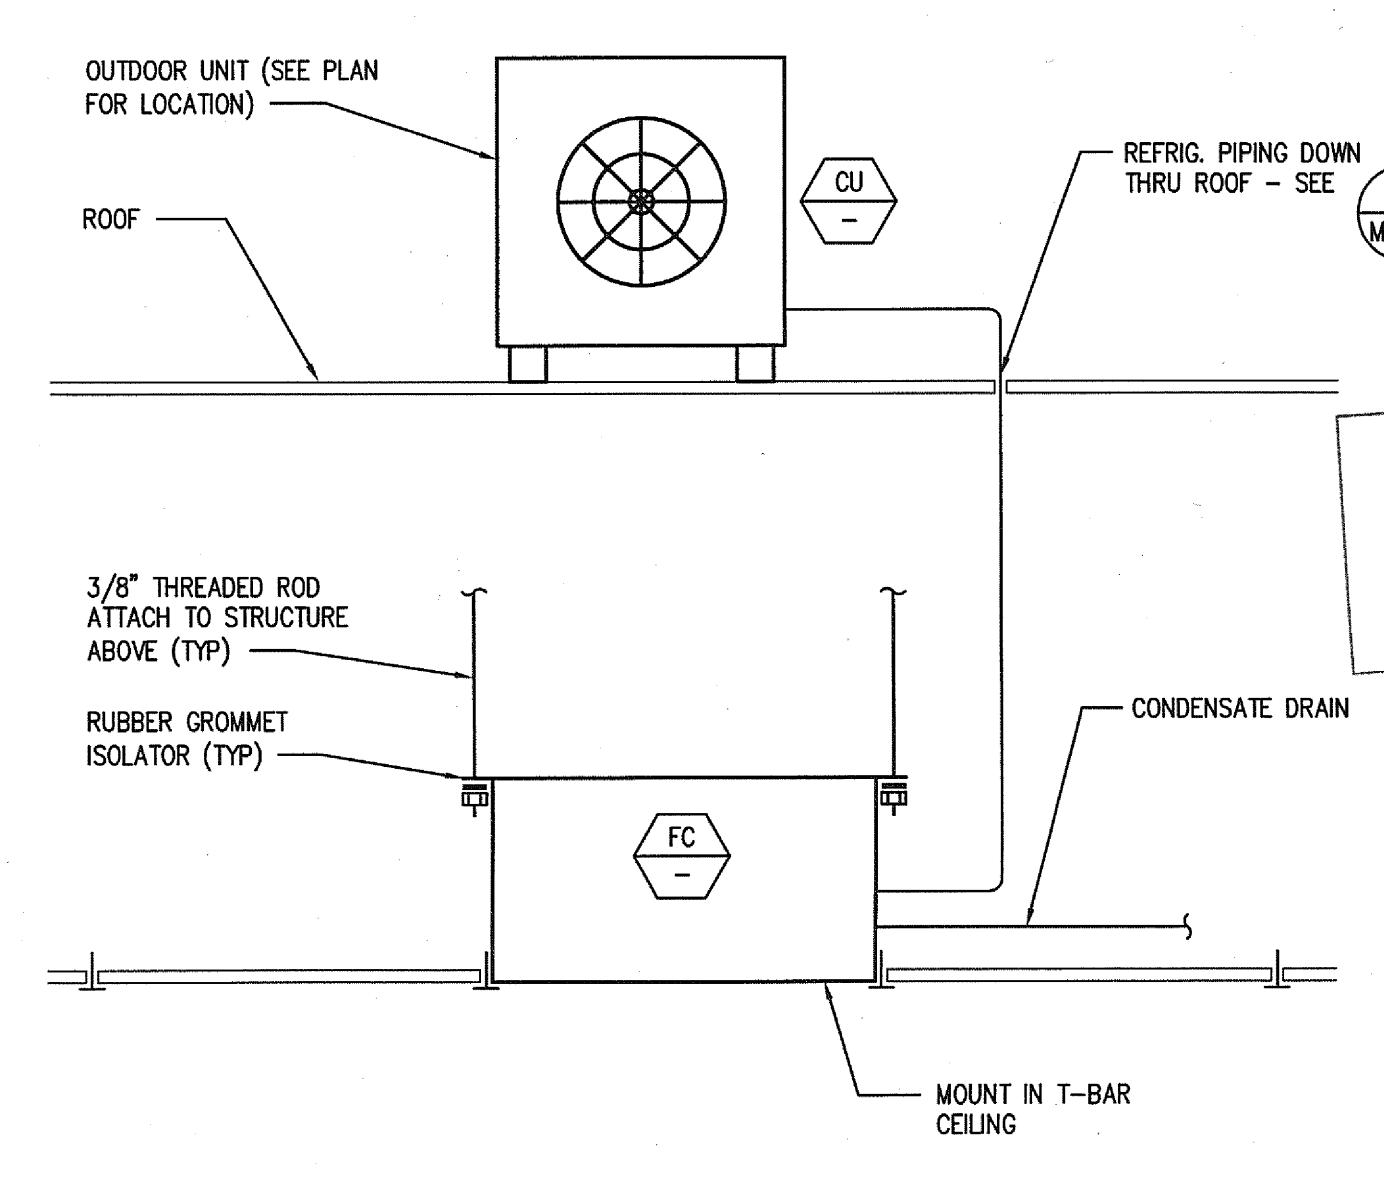

SPLIT SYSTEM A/C UNIT


SCALE NONE

5

COPYRIGHT © FENTRESS ARCHITECTS	
ISSUED FOR	DATE
Pre-Schematic Design	07/14/2009
Schematic Design	07/28/2009
BID PK #1	10/09/2009
50% Progress	11/04/2009
BID PK #1 80 CD	12/01/2009
BID PK #1 100 CD	02/16/2009
BID PK #2 100 CD	13/26/2009
100% CD	05/08/2009
CD 4	01/07/2010
CD 5	02/26/2010
CD 6	03/26/2010
CD 7	04/15/2010

SANFORD CONSORTIUM FOR REGENERATIVE MEDICINE

2880 TORREY PINES SCENIC DRIVE
LA JOLLA, CALIFORNIA 92037

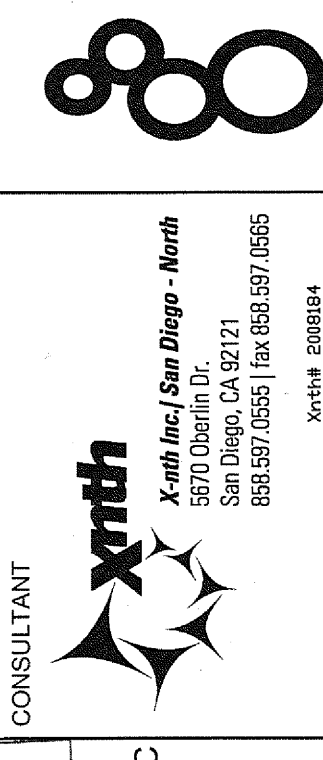

CONSULTANT
Architectural Group
San Diego, CA 92108
(619) 594-1000
www.sanfordconsortium.com

Landford/Phelps Consortium LLC
PRELIMINARY DRAWINGS
PROGRESS DRAWINGS
REVIEW DRAWINGS
CONSTRUCTION DRAWINGS

FENTRESS ARCHITECTS
400 Broadway Street, 10th Floor
San Francisco, CA 94111
(415) 774-1000
www.fentress.com

DAVIS
2001 Third Avenue, San Francisco, CA 94107

STAMP
FENTRESS ARCHITECTS
APR 15 2010
STATE FIRE MARSHAL
SOUTHERN REGION

SHEET NAME
MECHANICAL DETAILS
DRAWN BY: Author
PROJECT # 200725.000
SHEET NUMBER
M5002