



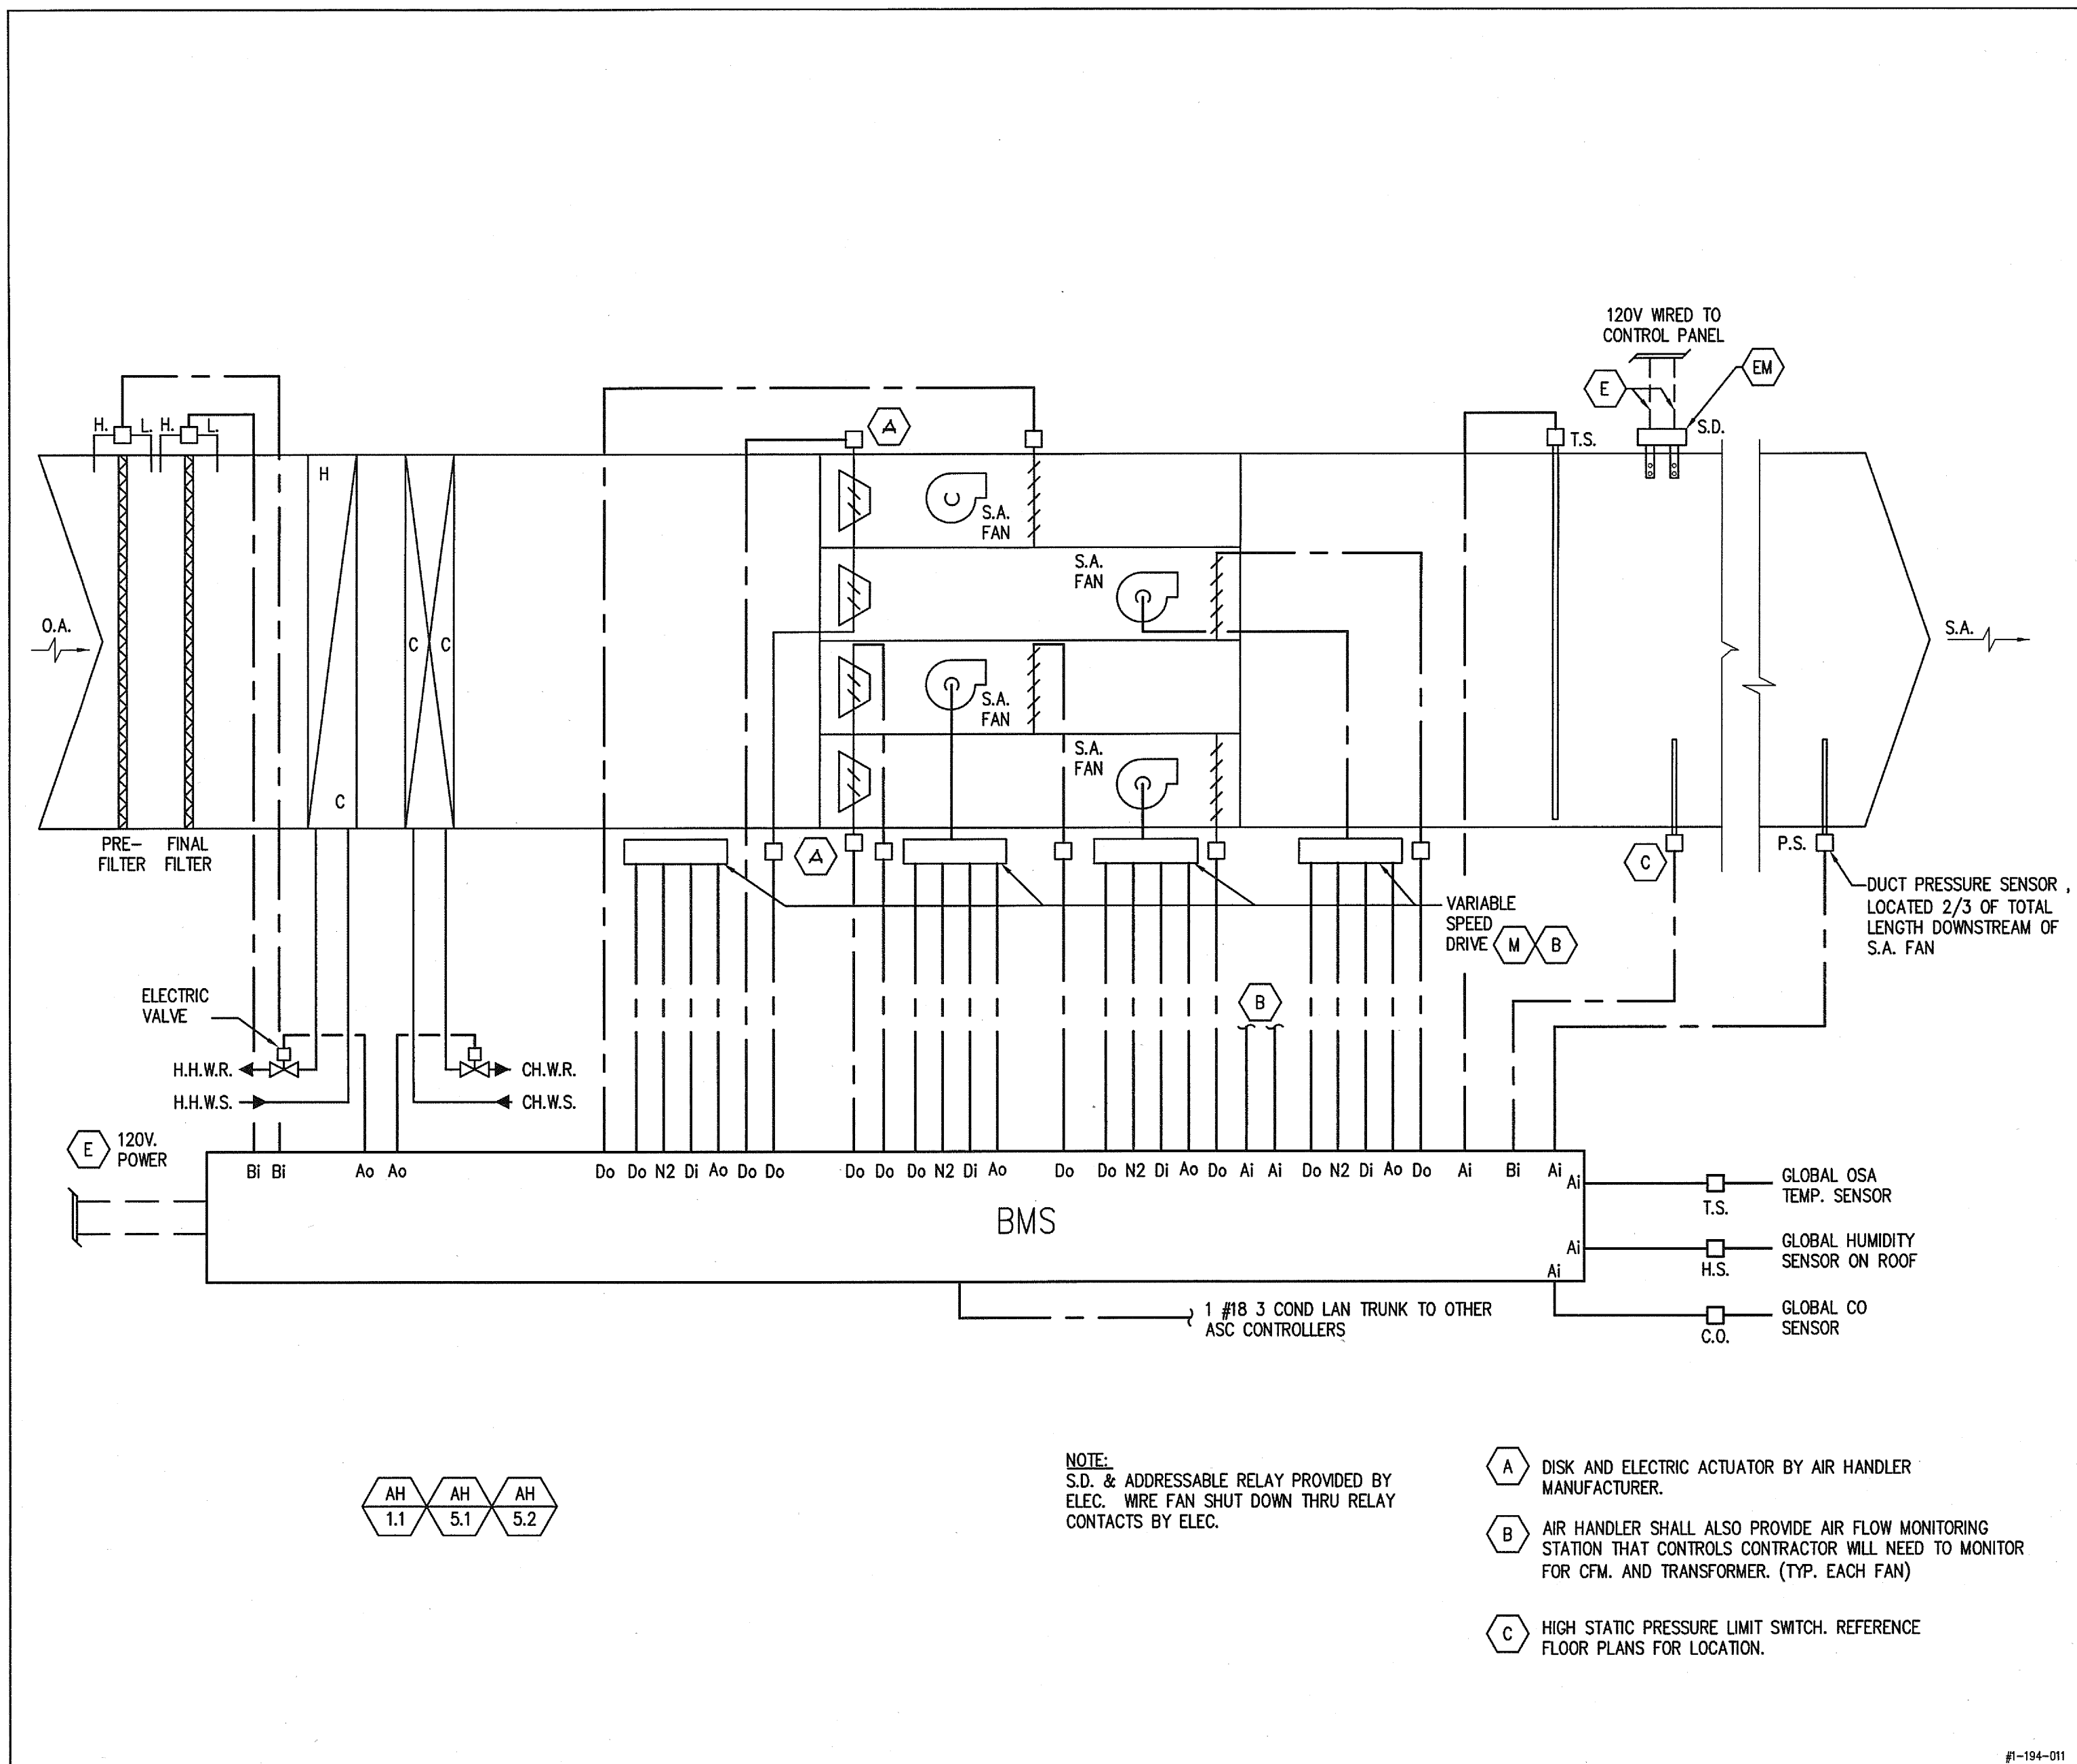


LABORATORY AND VIVARIUM AIR HANDLER CONTROL W/ V.F.D.

SCALE NONE 9

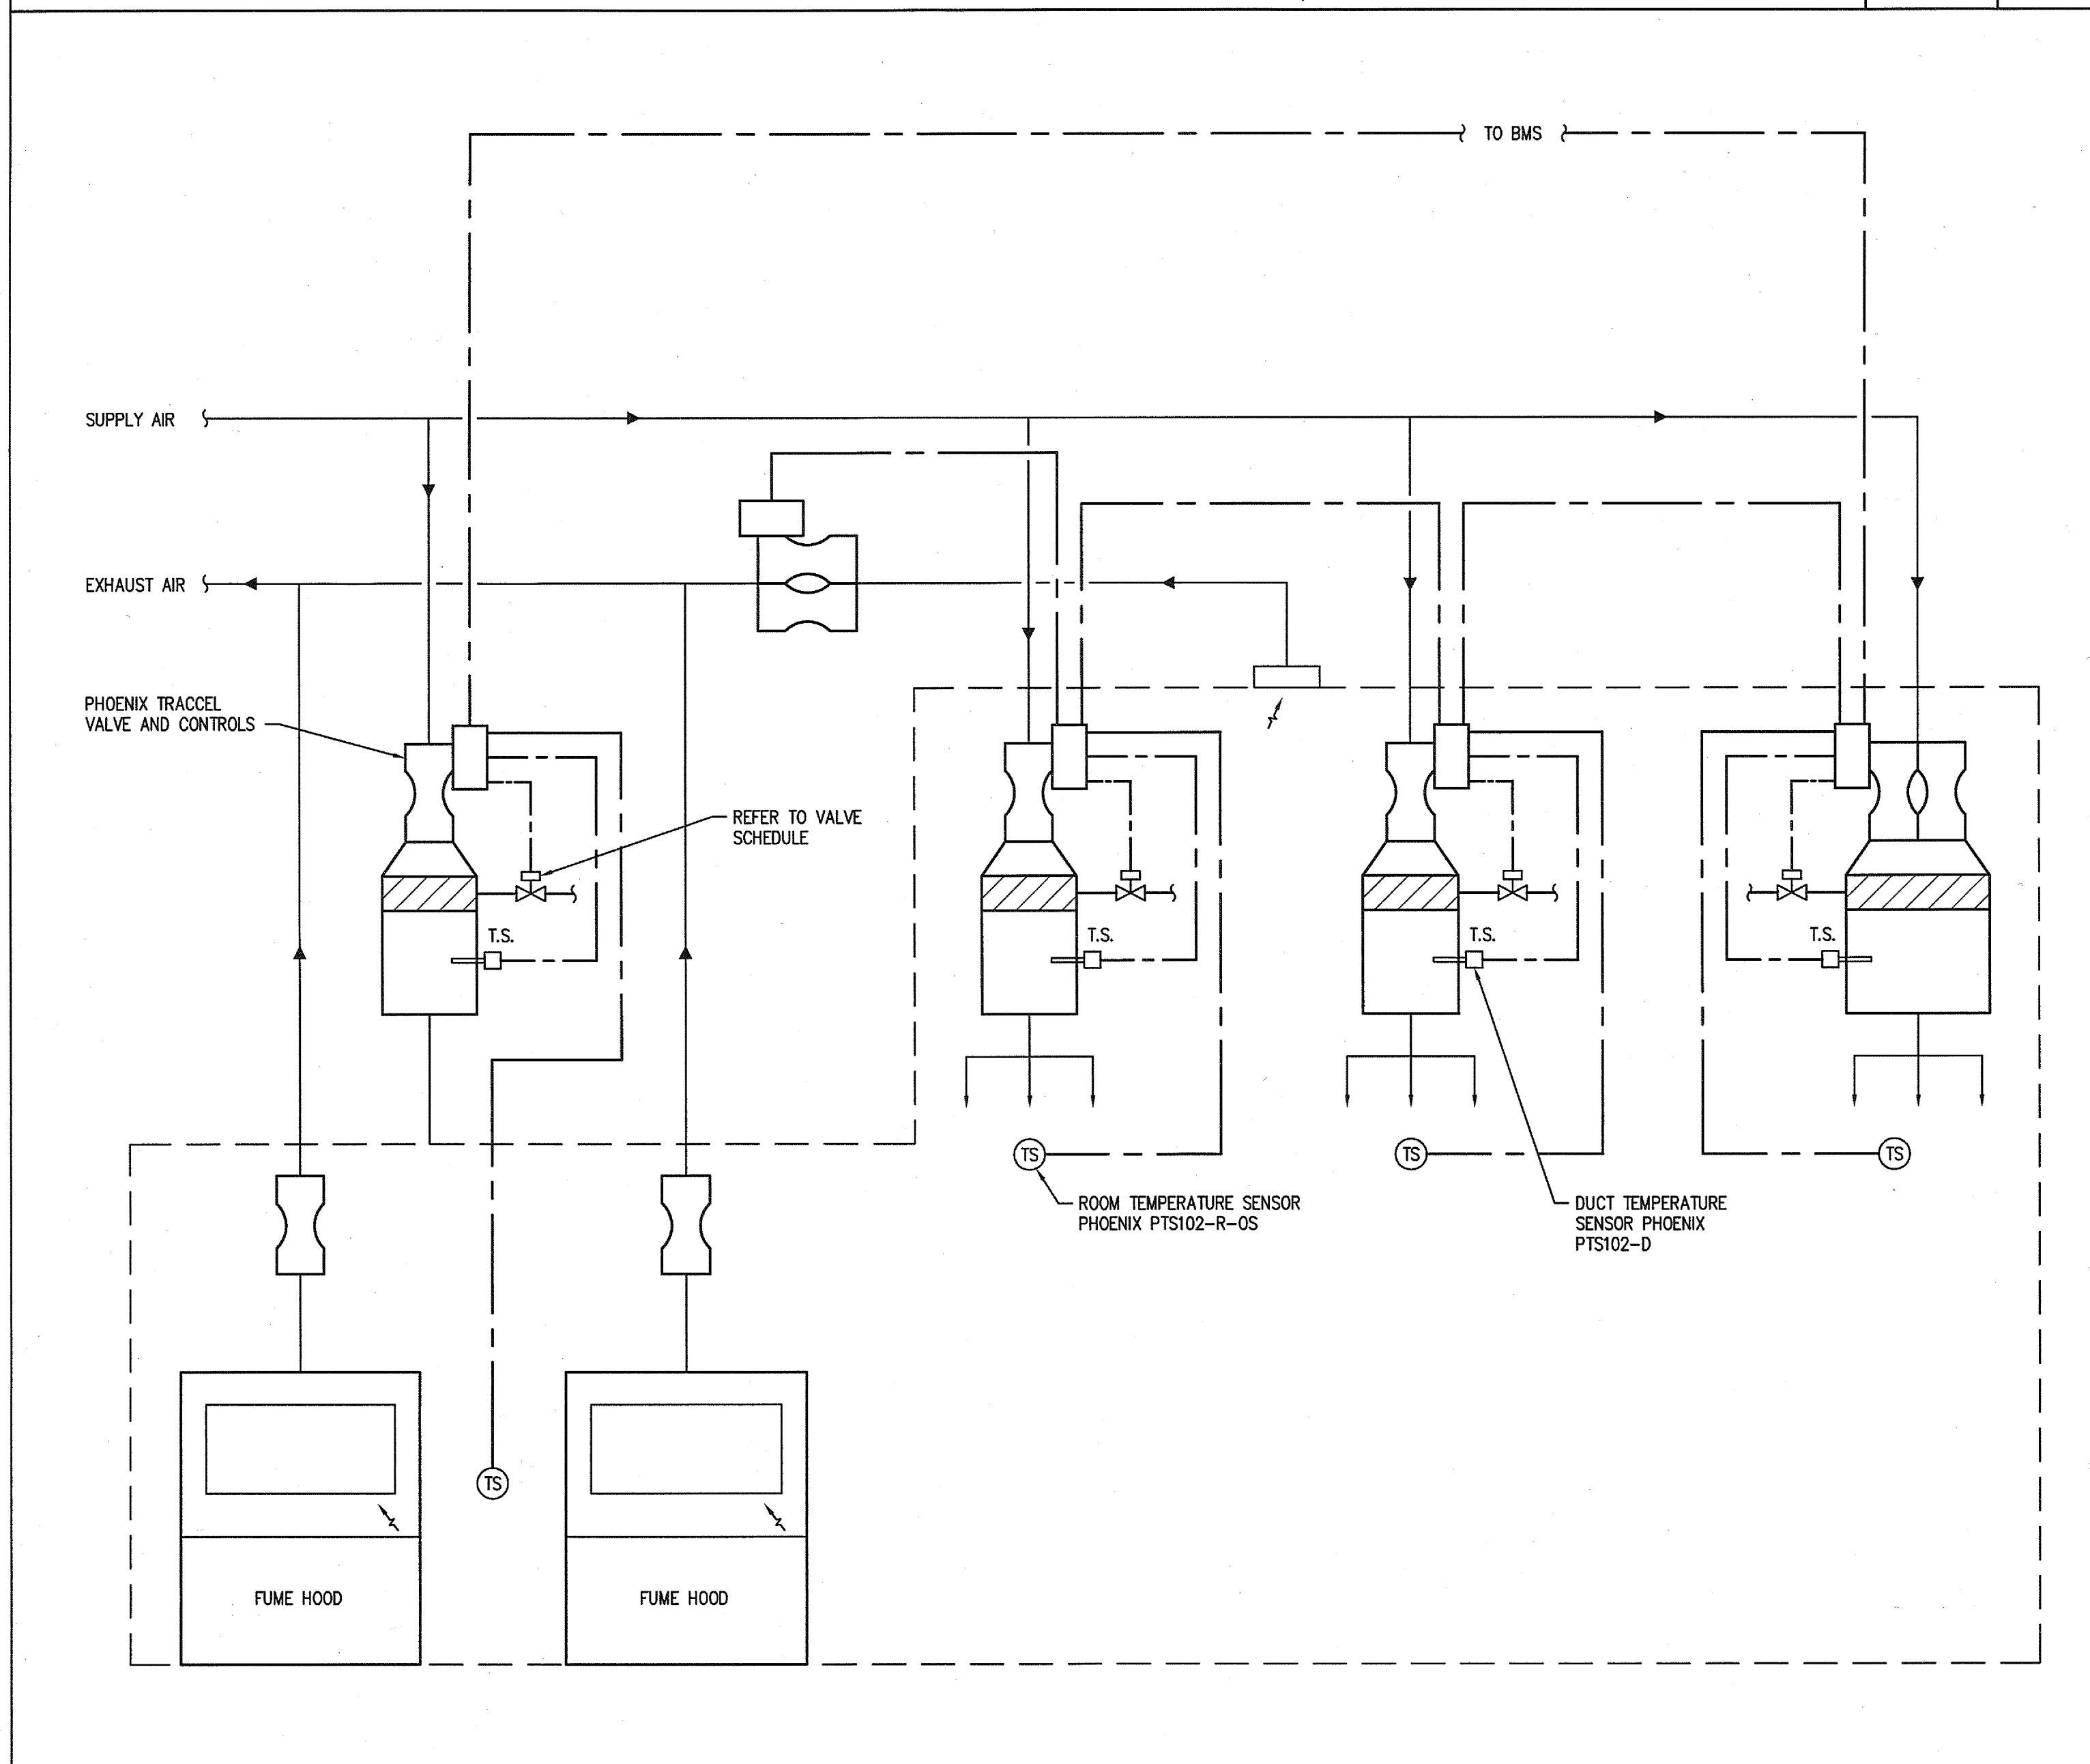


TYPICAL LAB/FUME HOOD ROOM CONTROLS (TYP.)

SCALE NONE 10

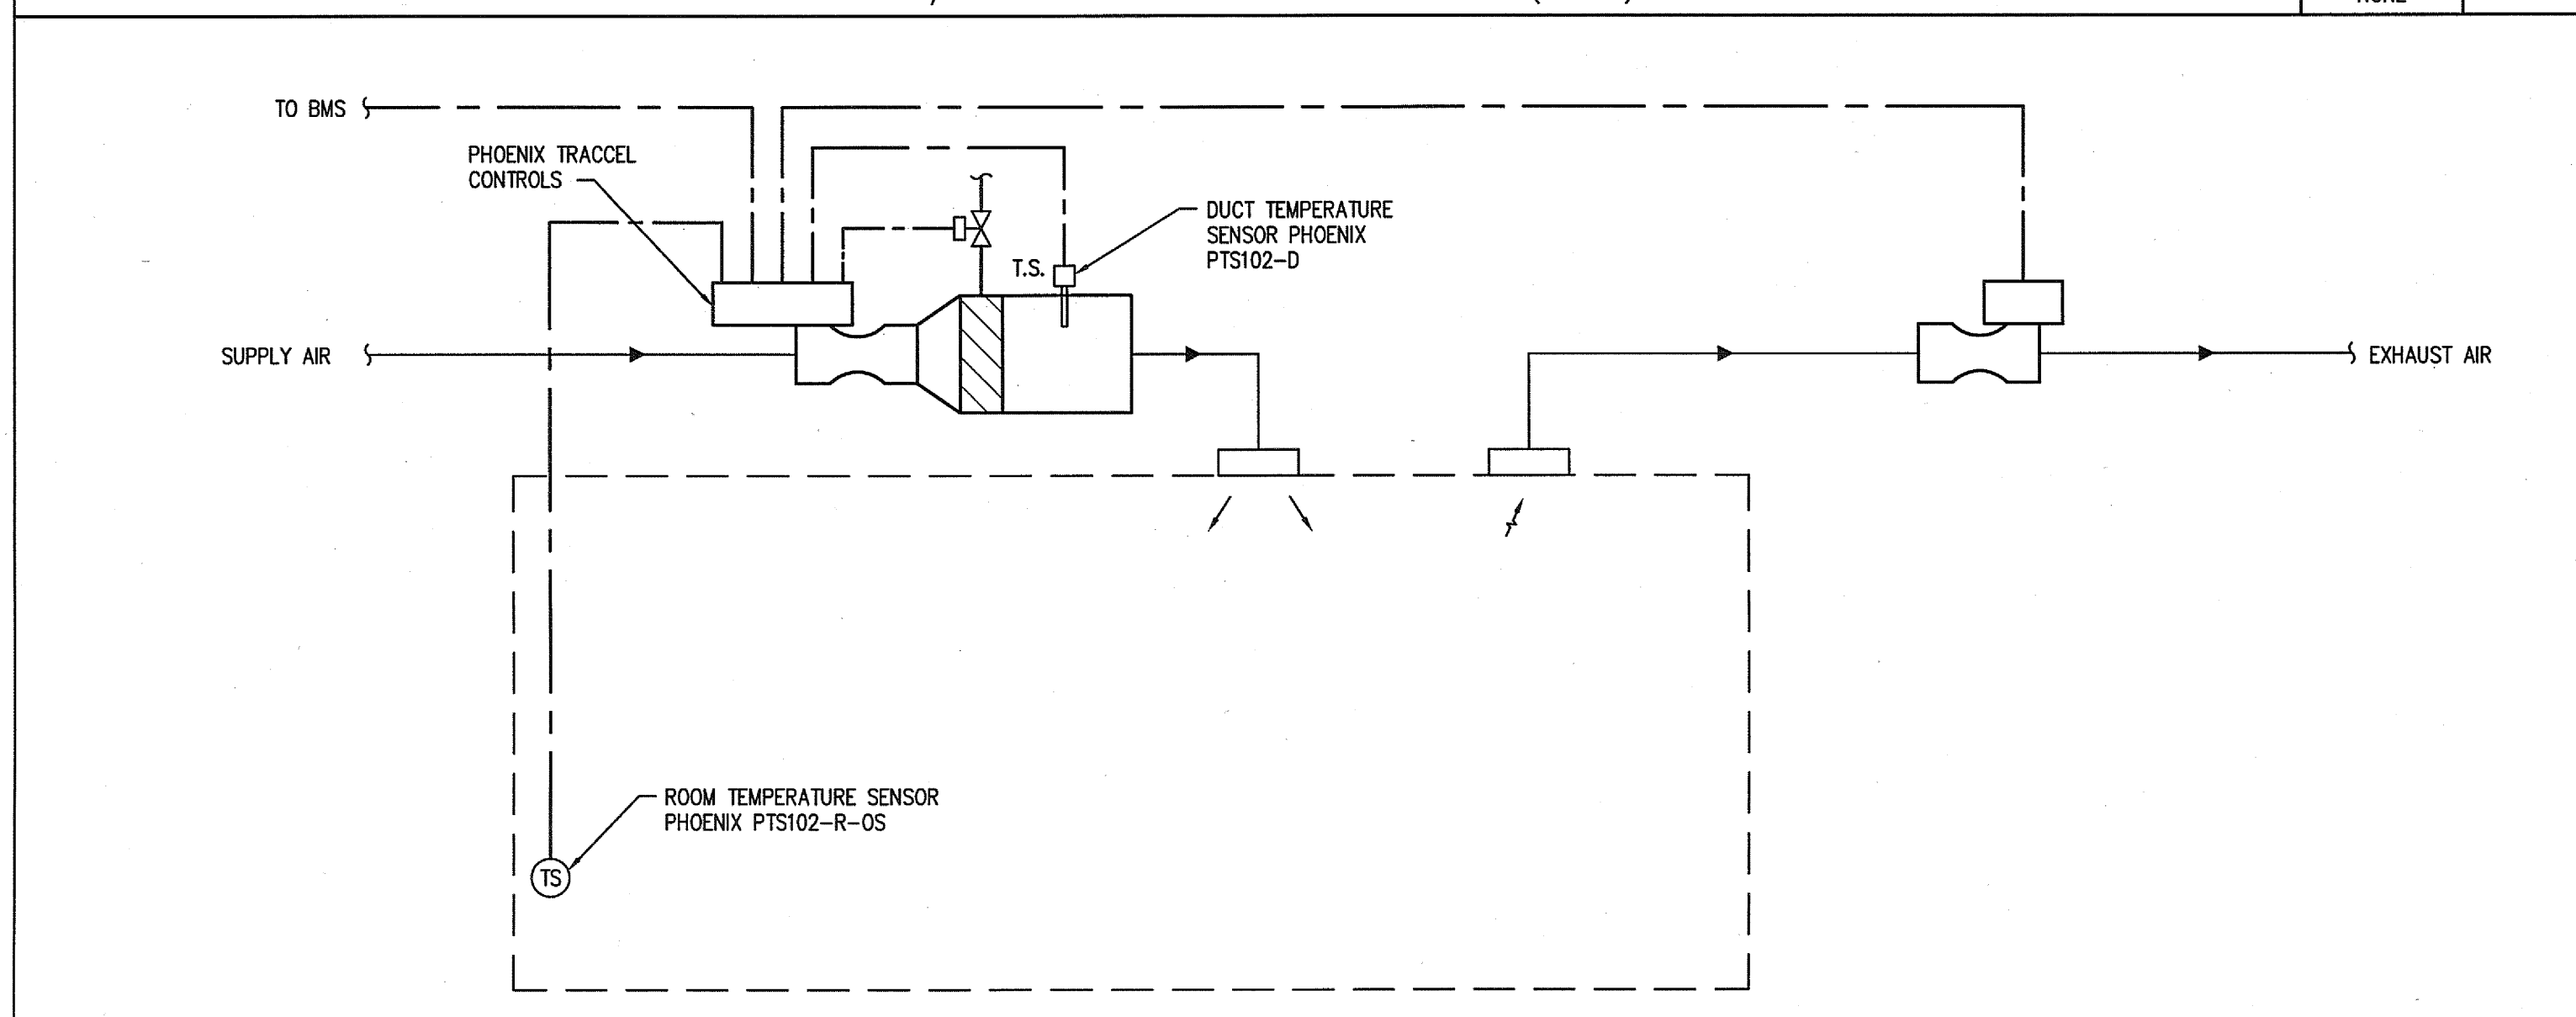


TYPICAL LAB SUPPORT ROOM CONTROL

SCALE NONE 11

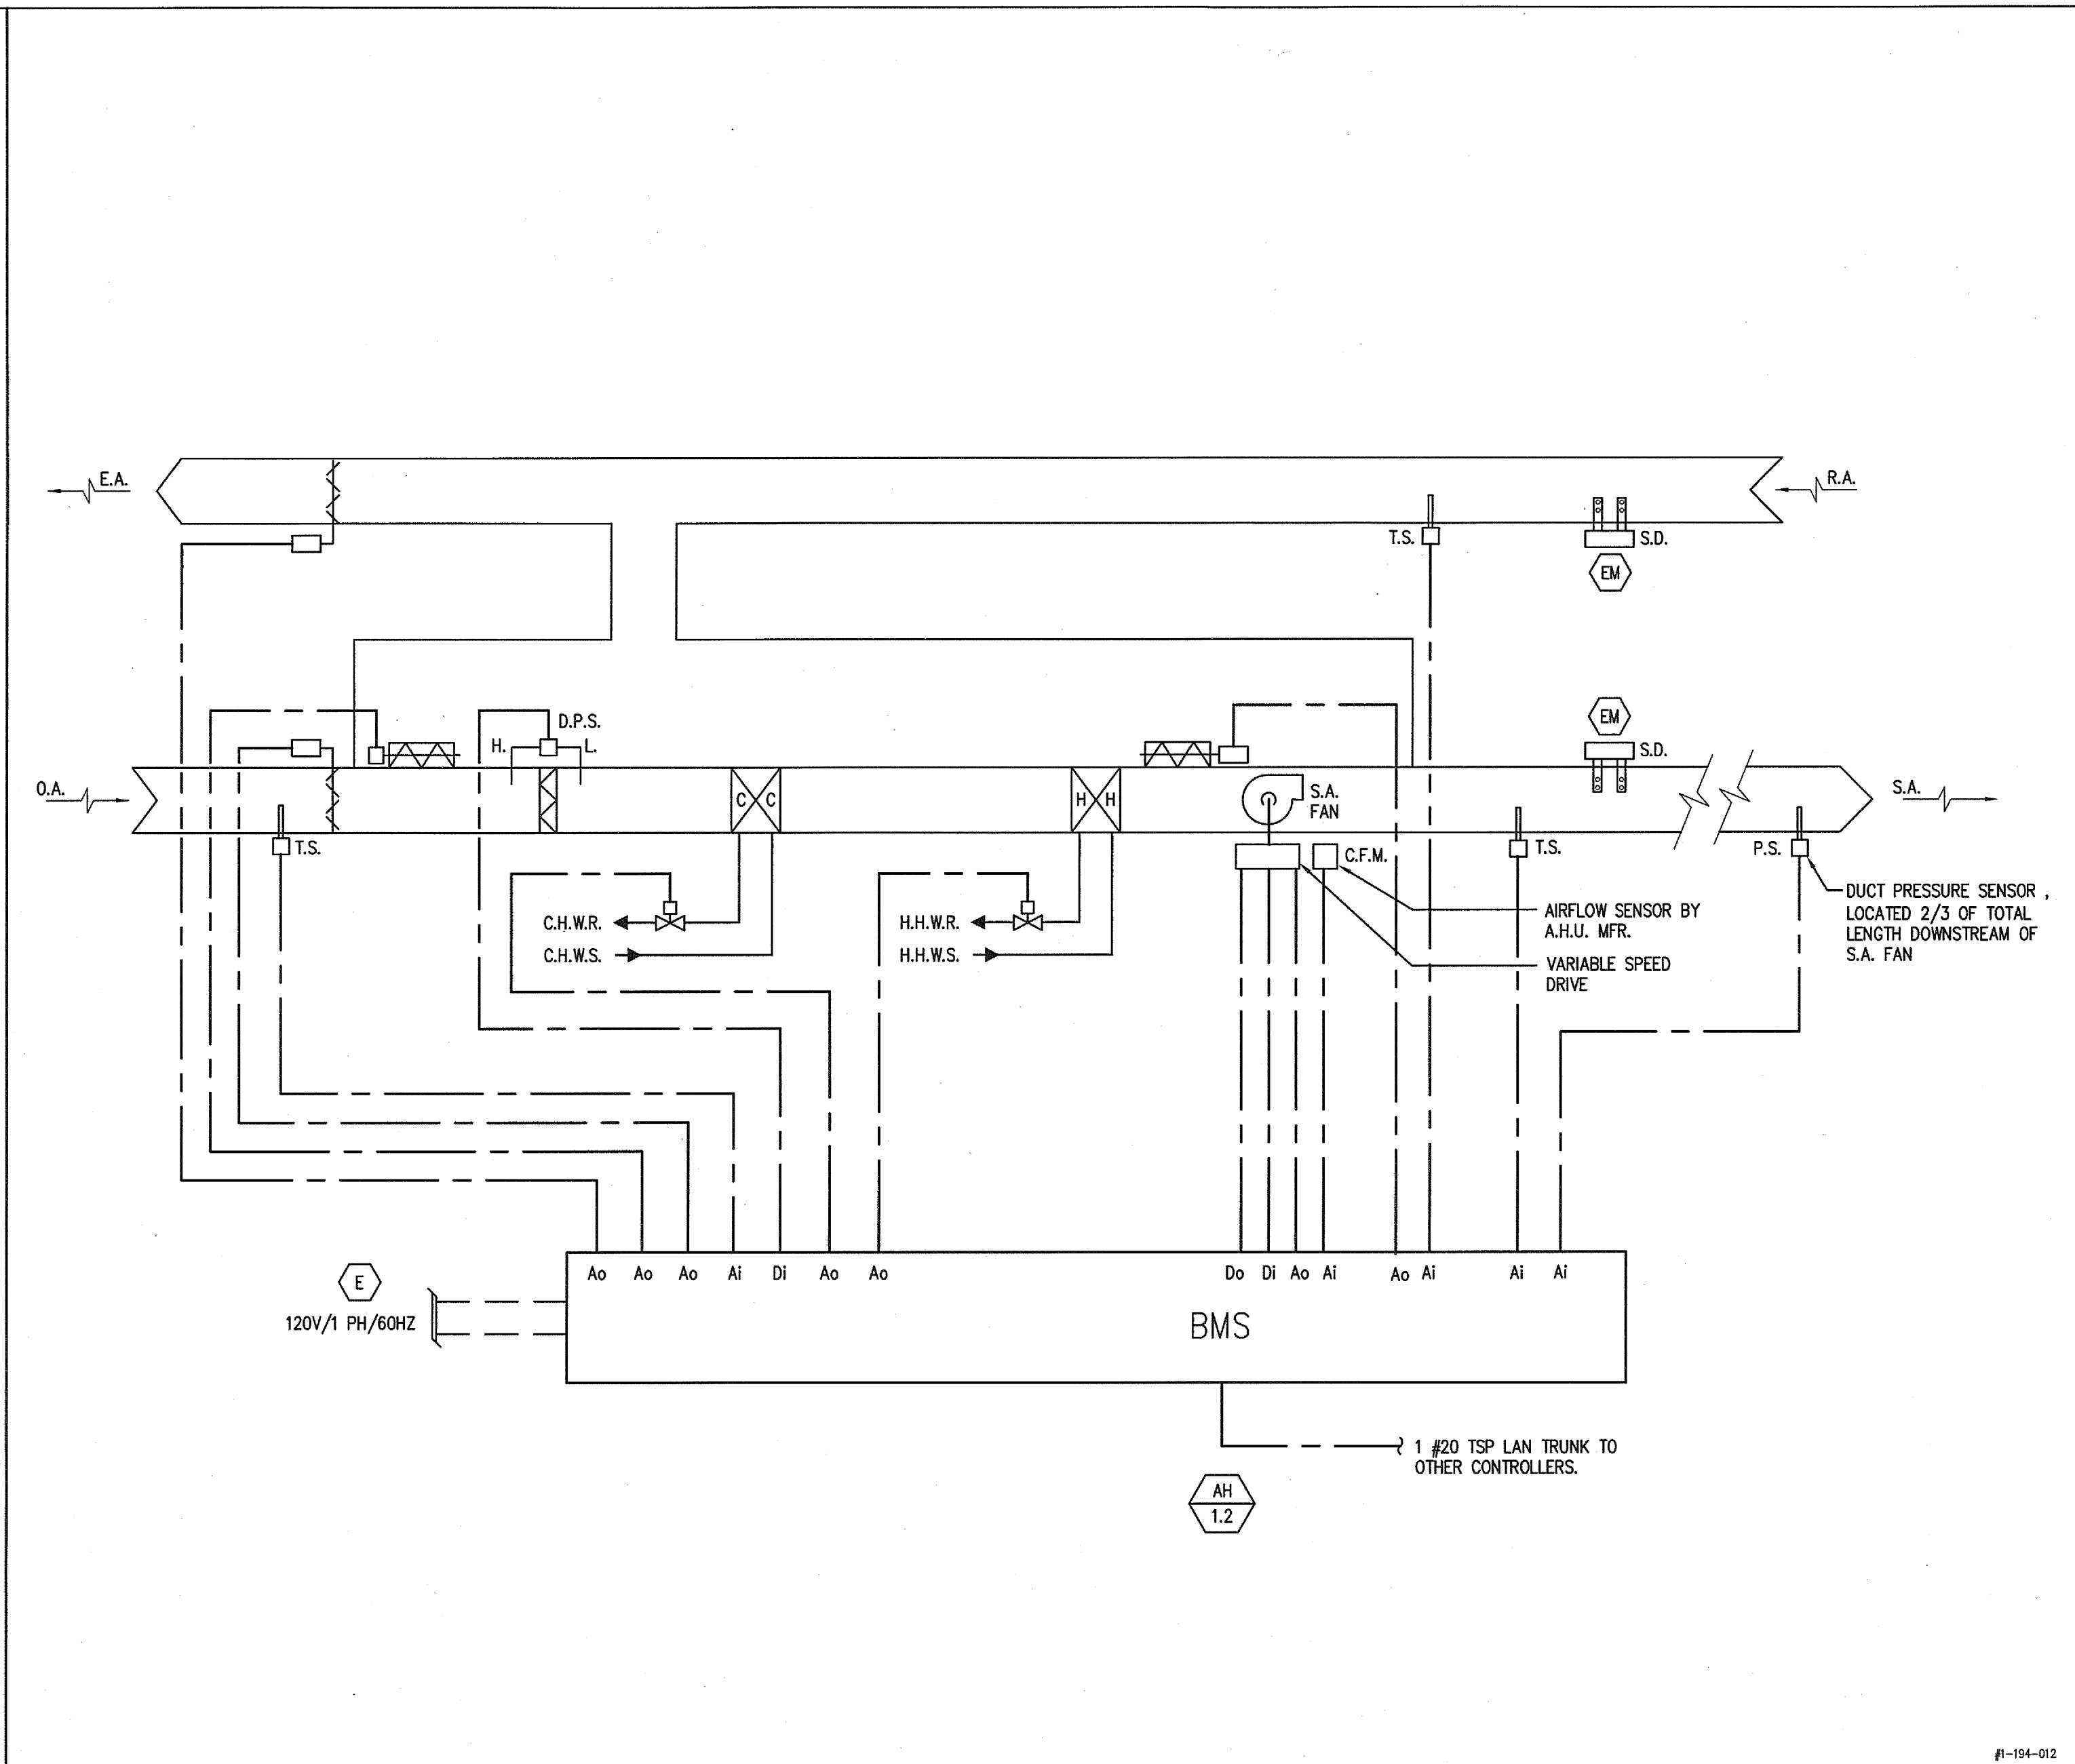


AUDITORIUM VAV A.H. UNIT (W/ FAN V.F.D.) CONTROL

SCALE NONE 6

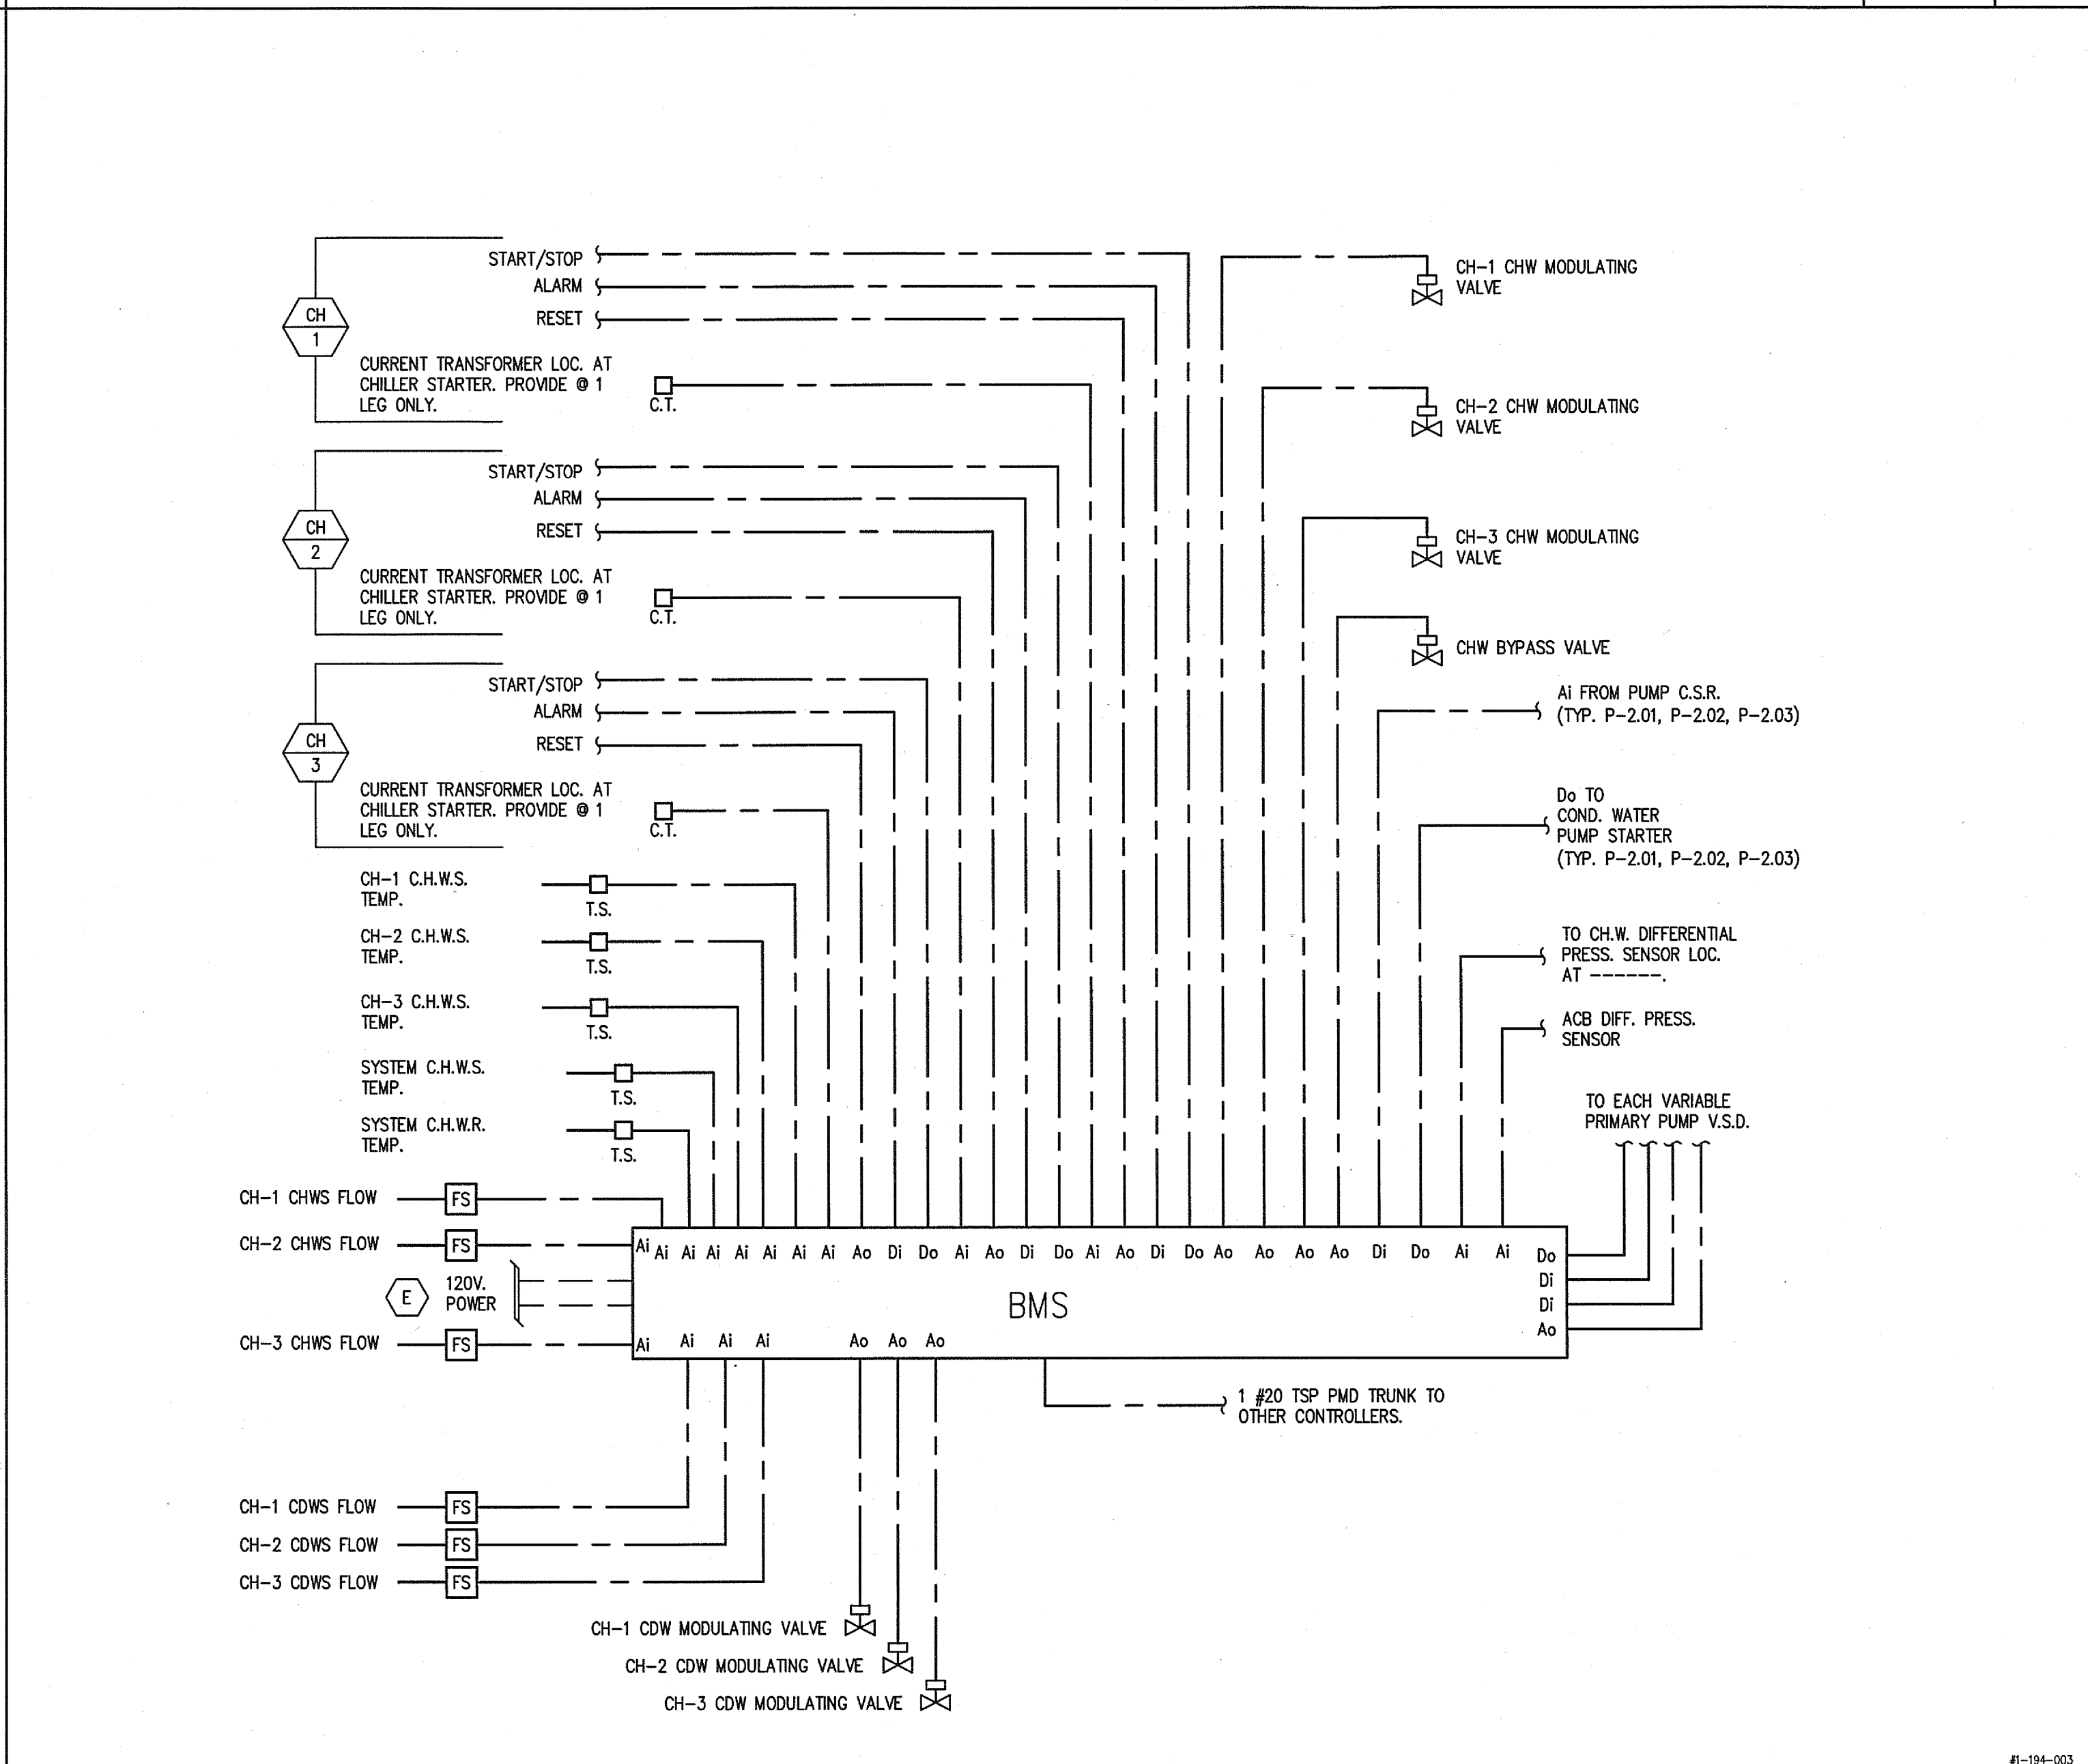


VARIABLE PRIMARY CHW SYSTEM CONTROL

SCALE NONE 7

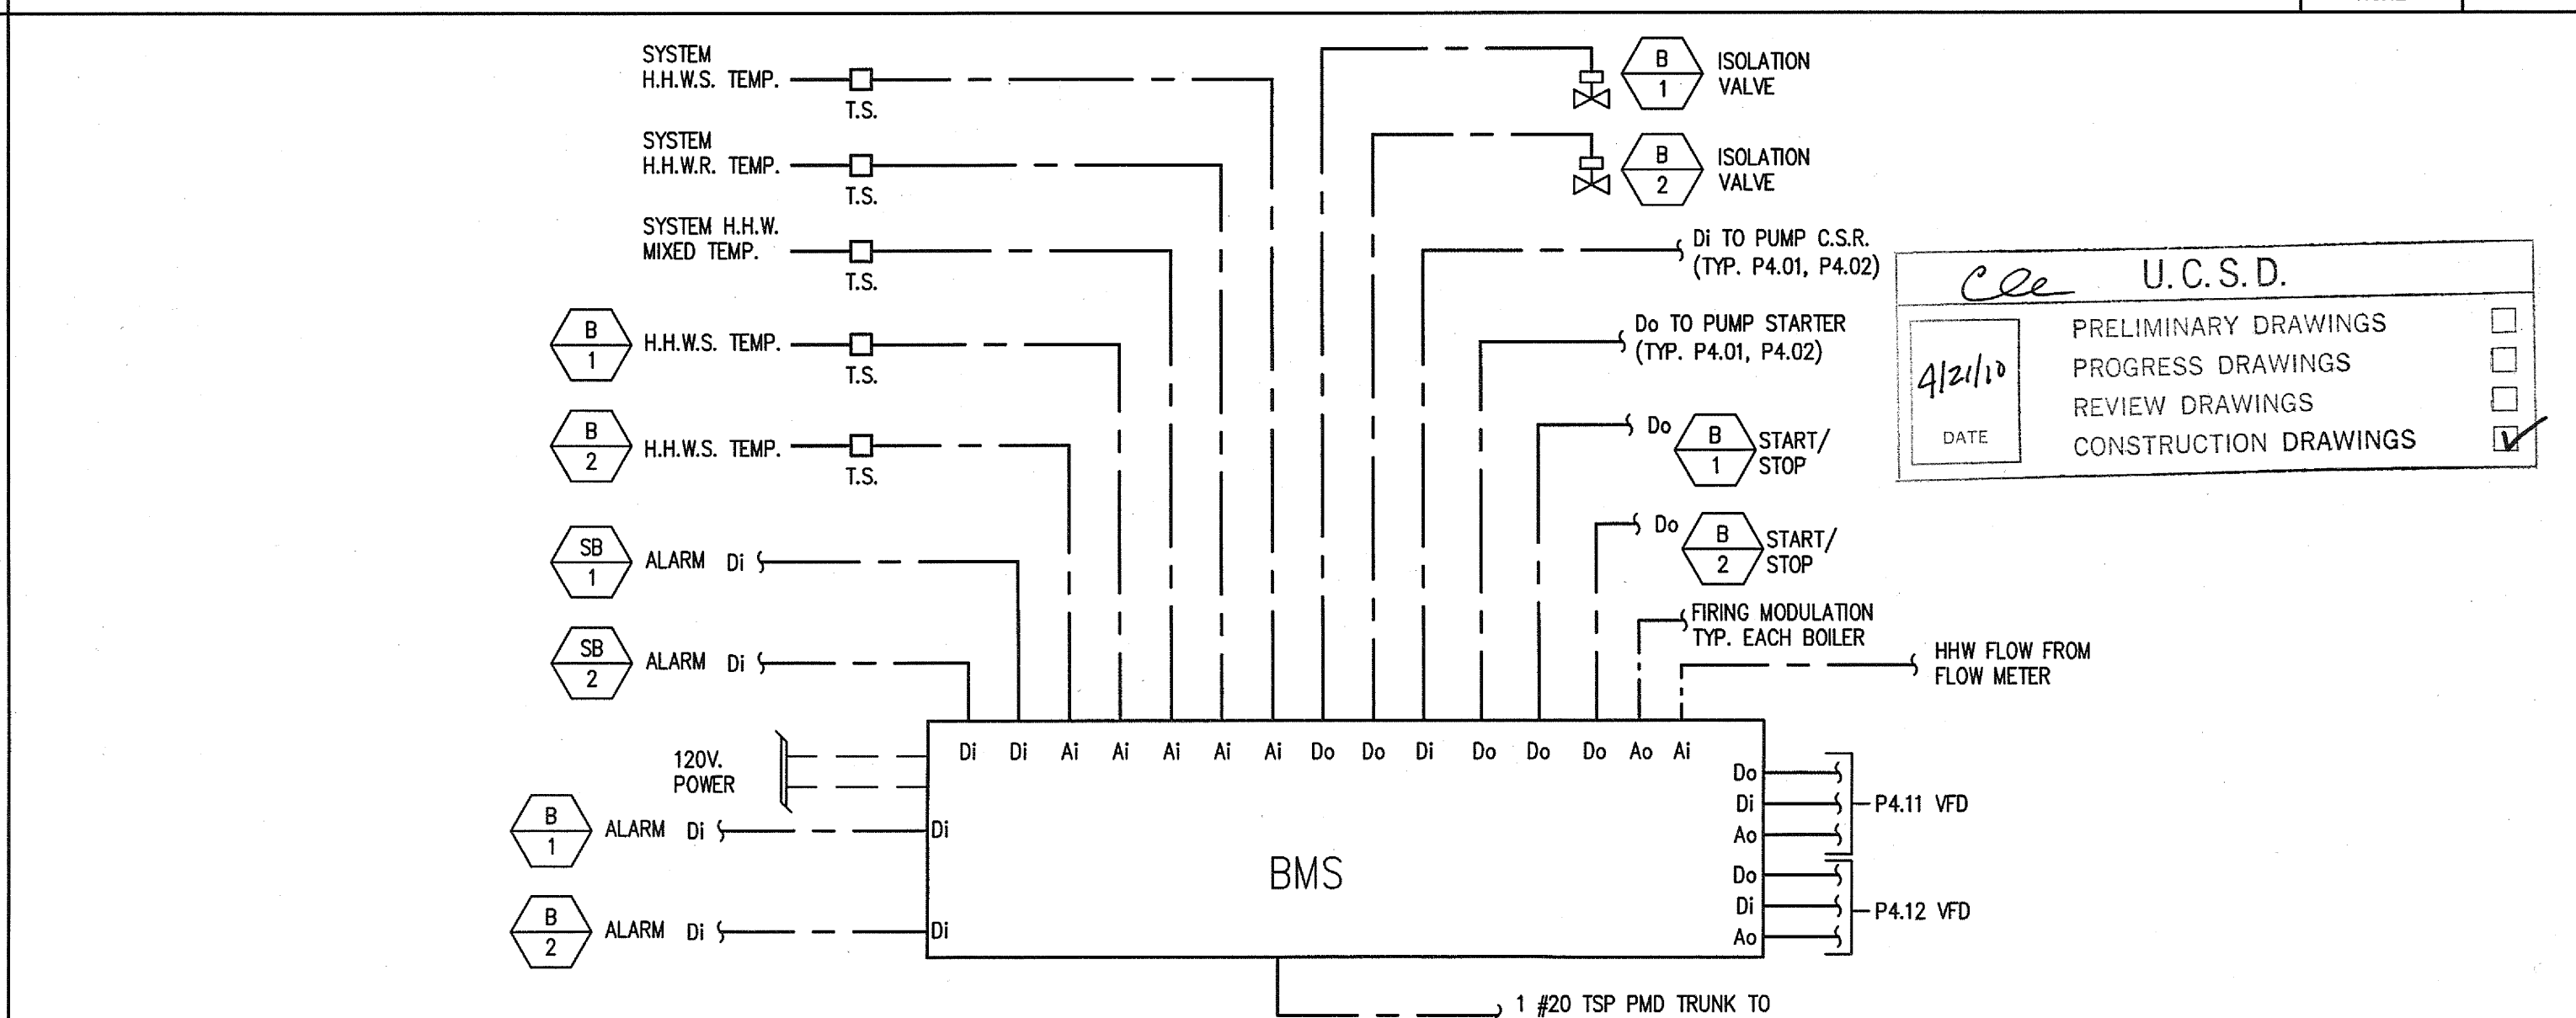


STEAM / HEATING HOT WATER CONTROLS

SCALE NONE 8

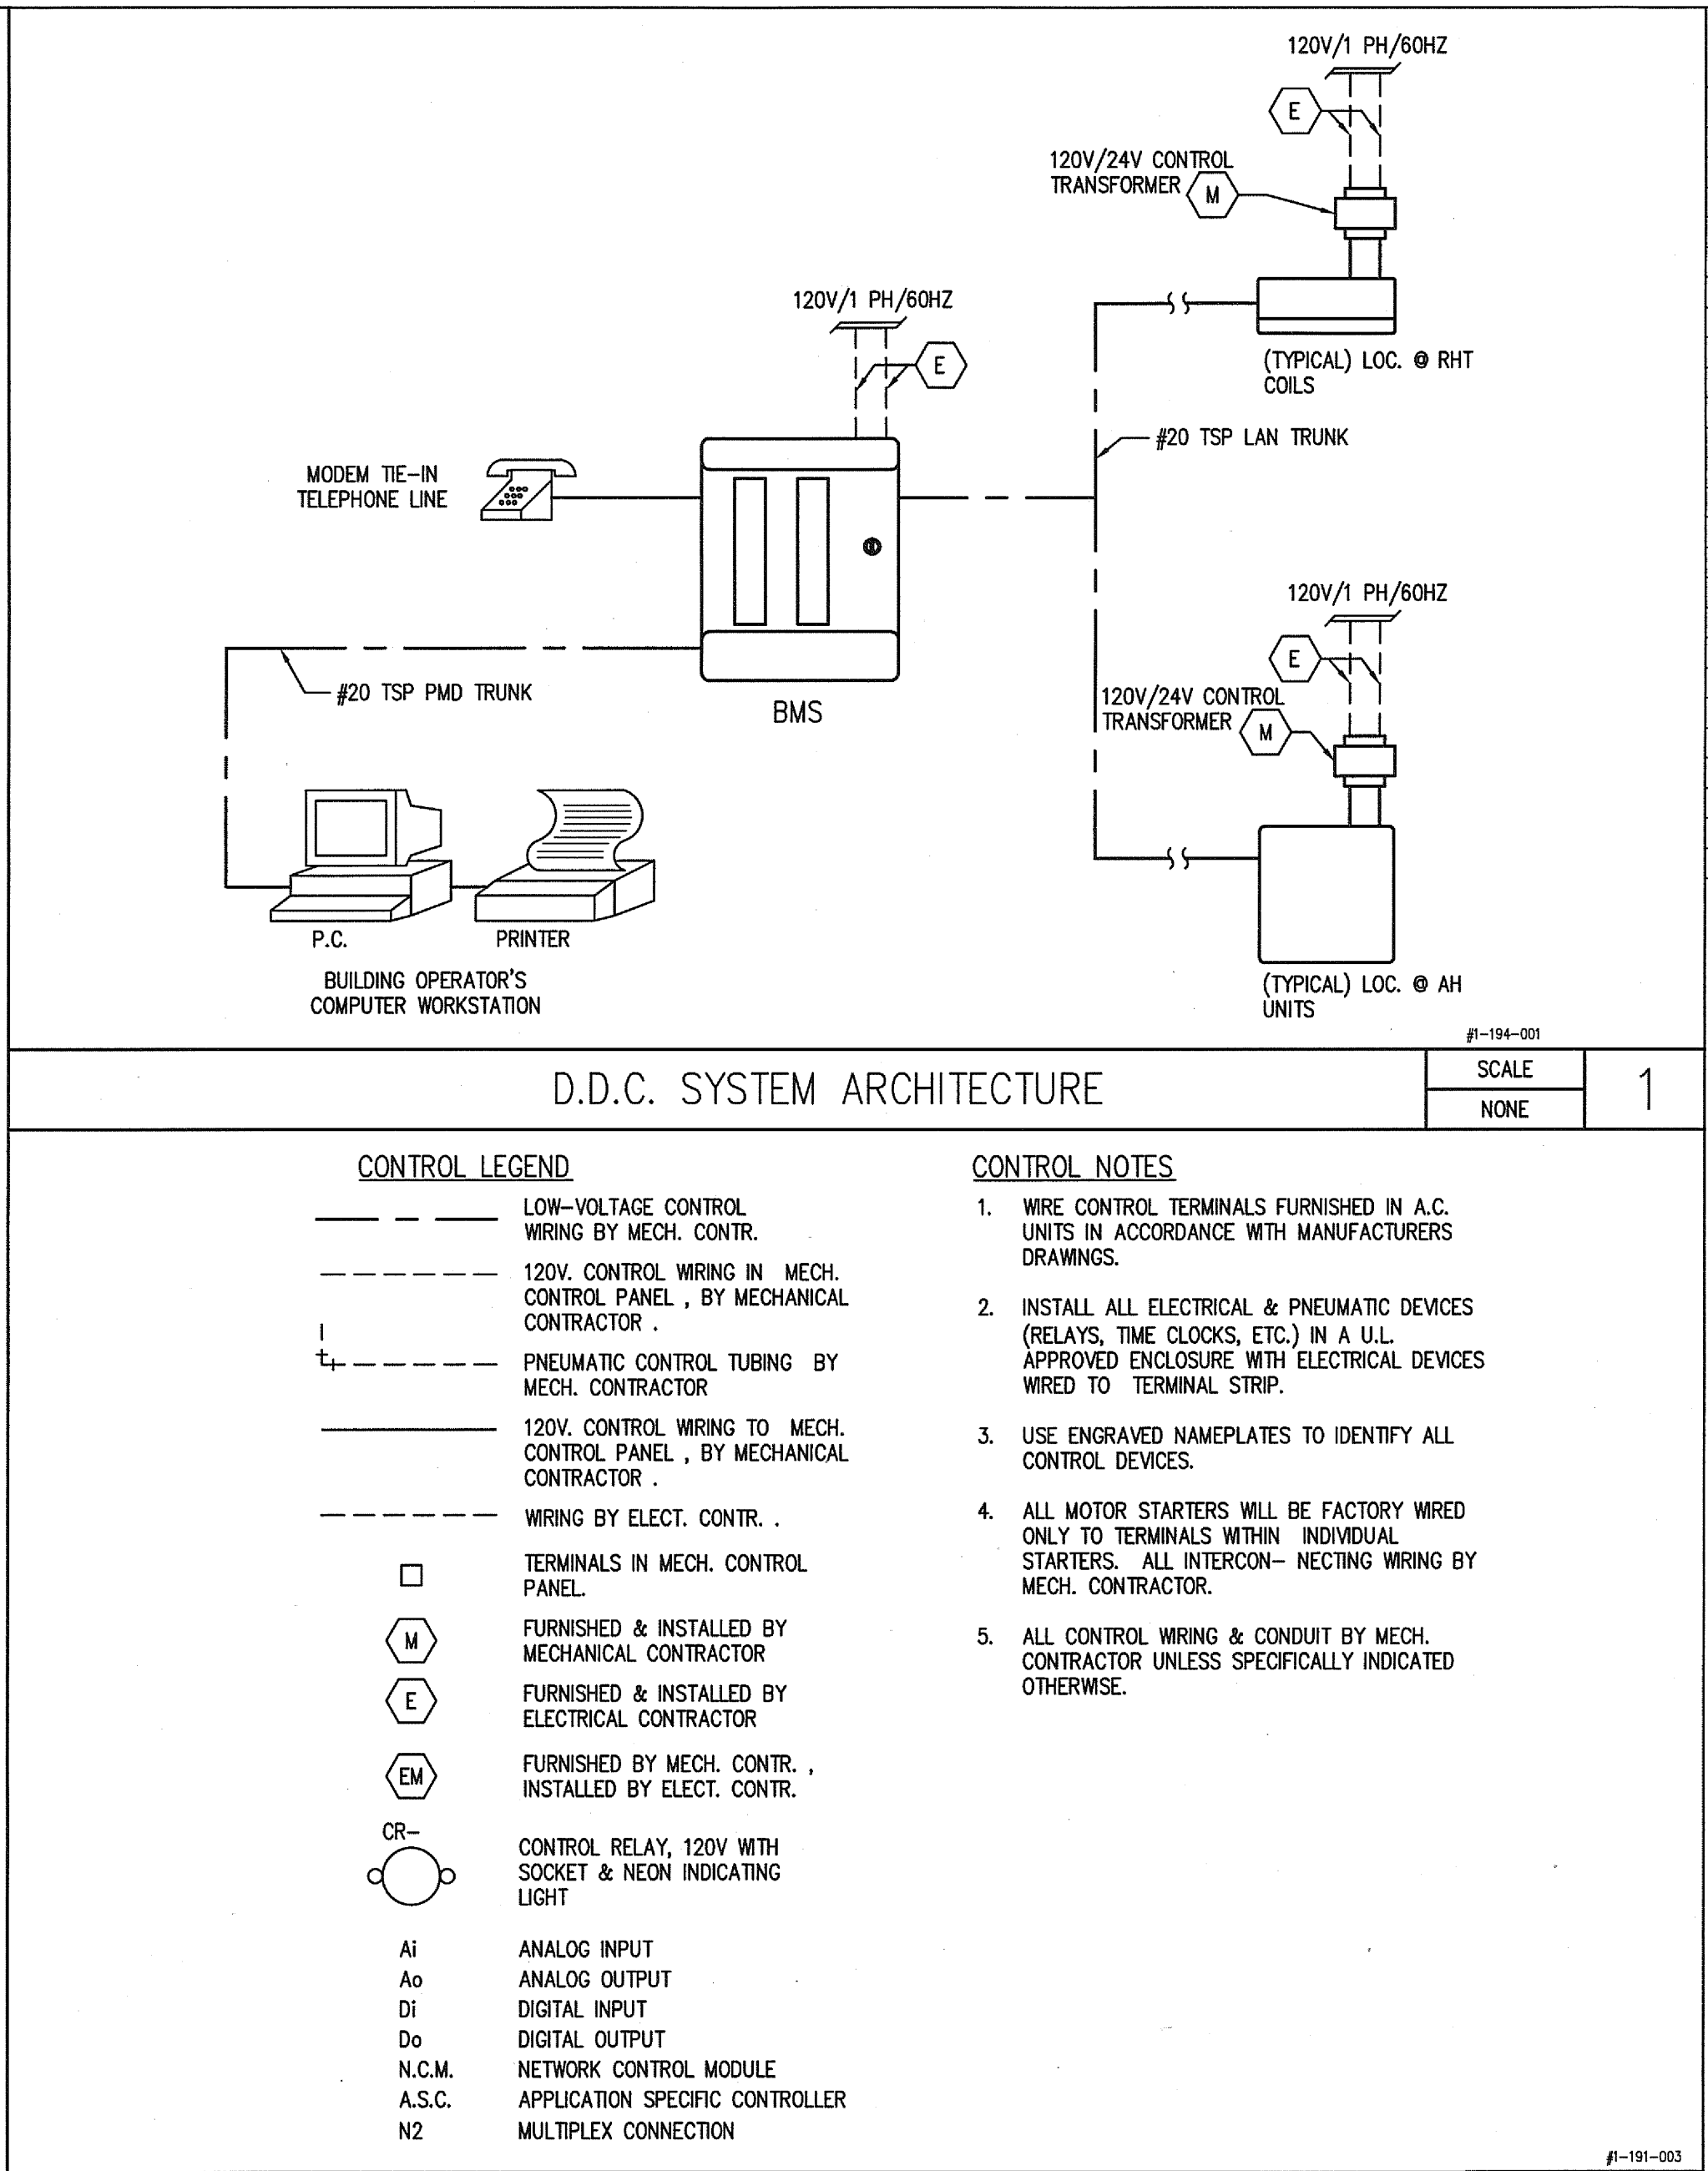


D.D.C. SYSTEM ARCHITECTURE

SCALE NONE 1

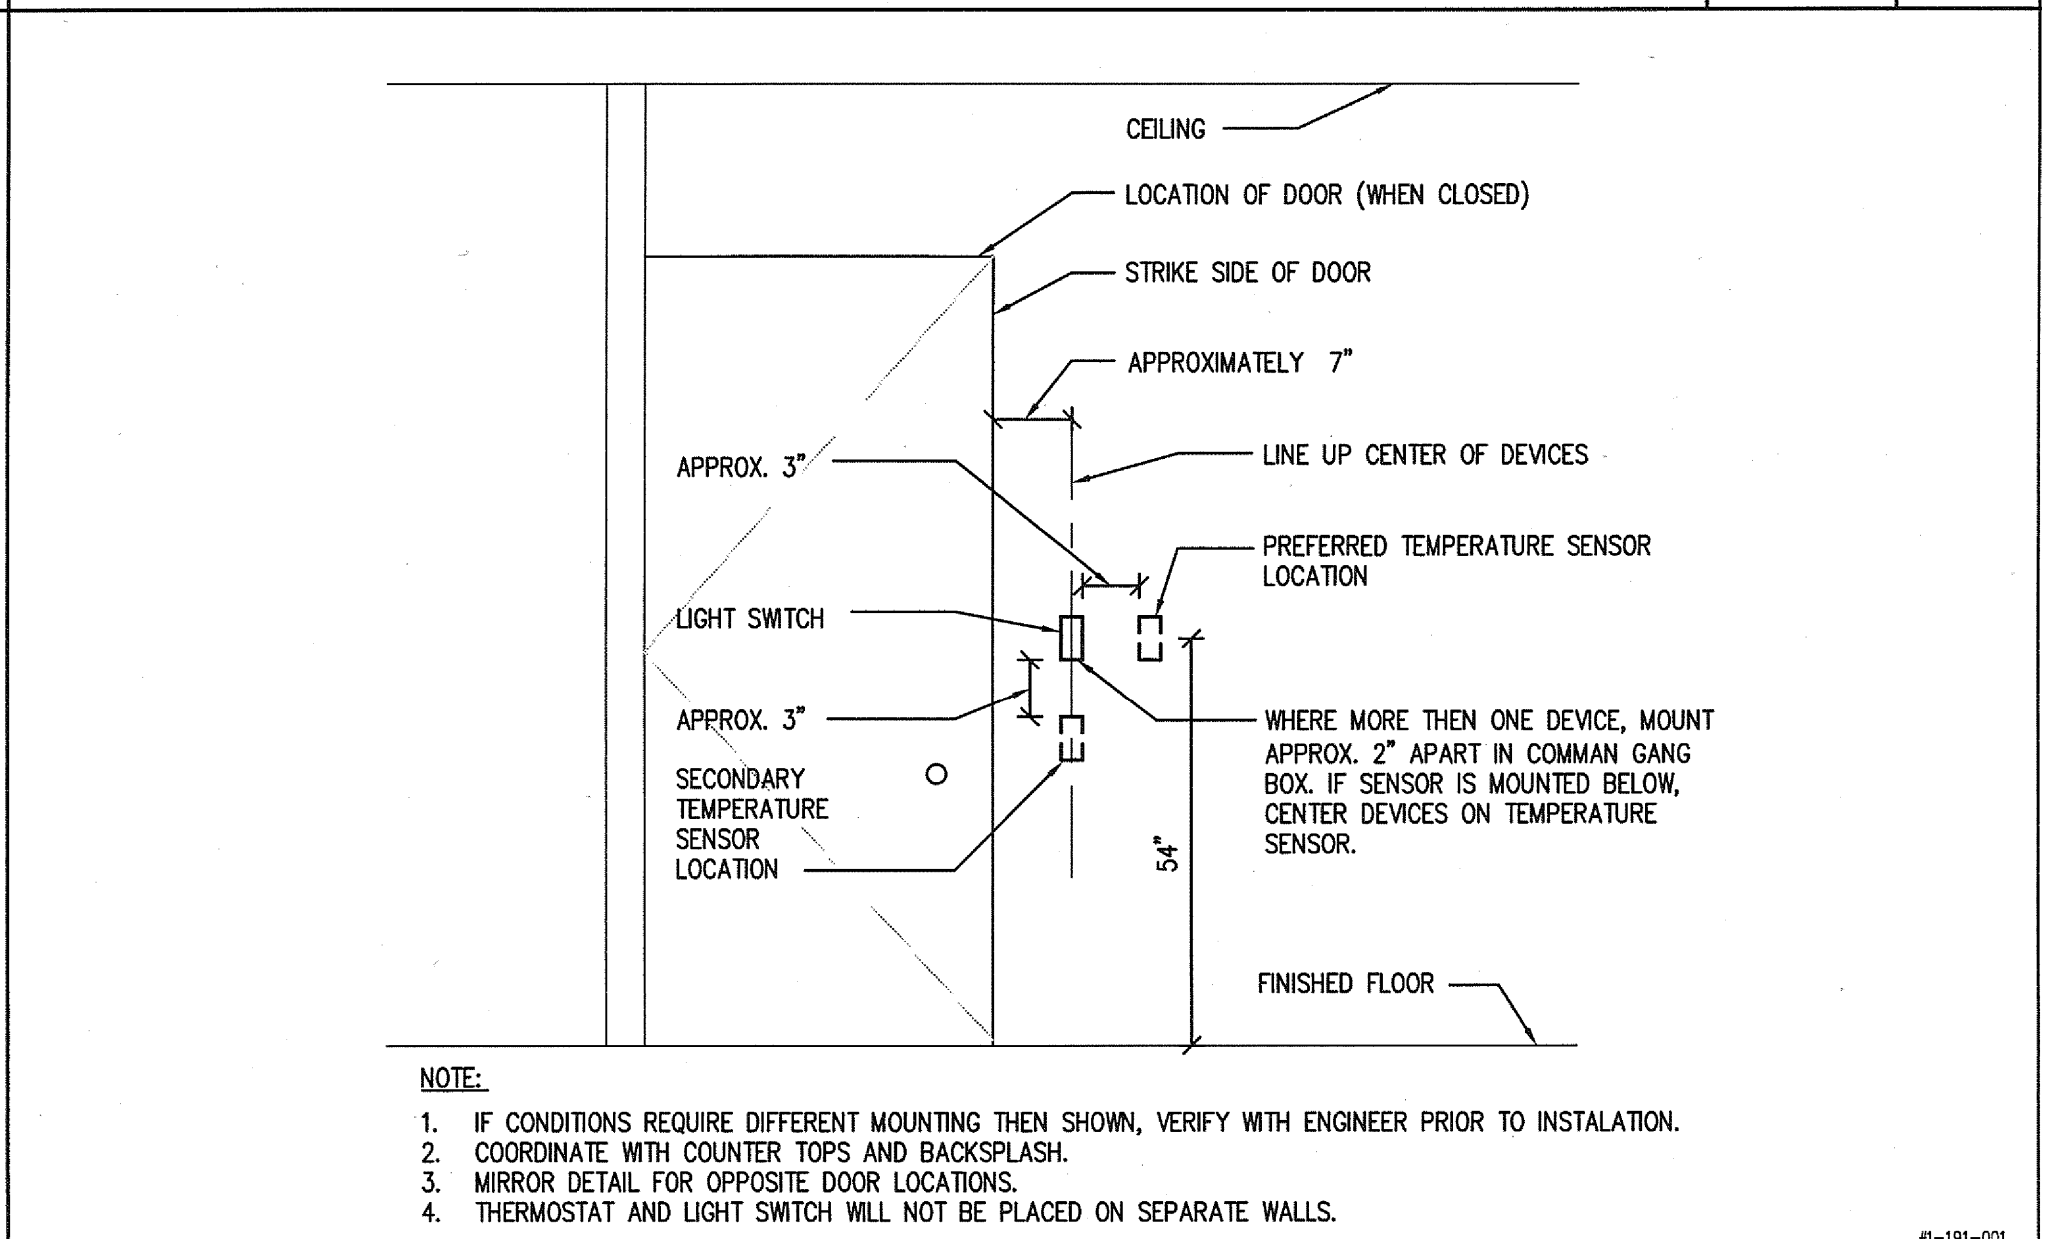


WALL DEVICE LOCATION

SCALE NONE 3

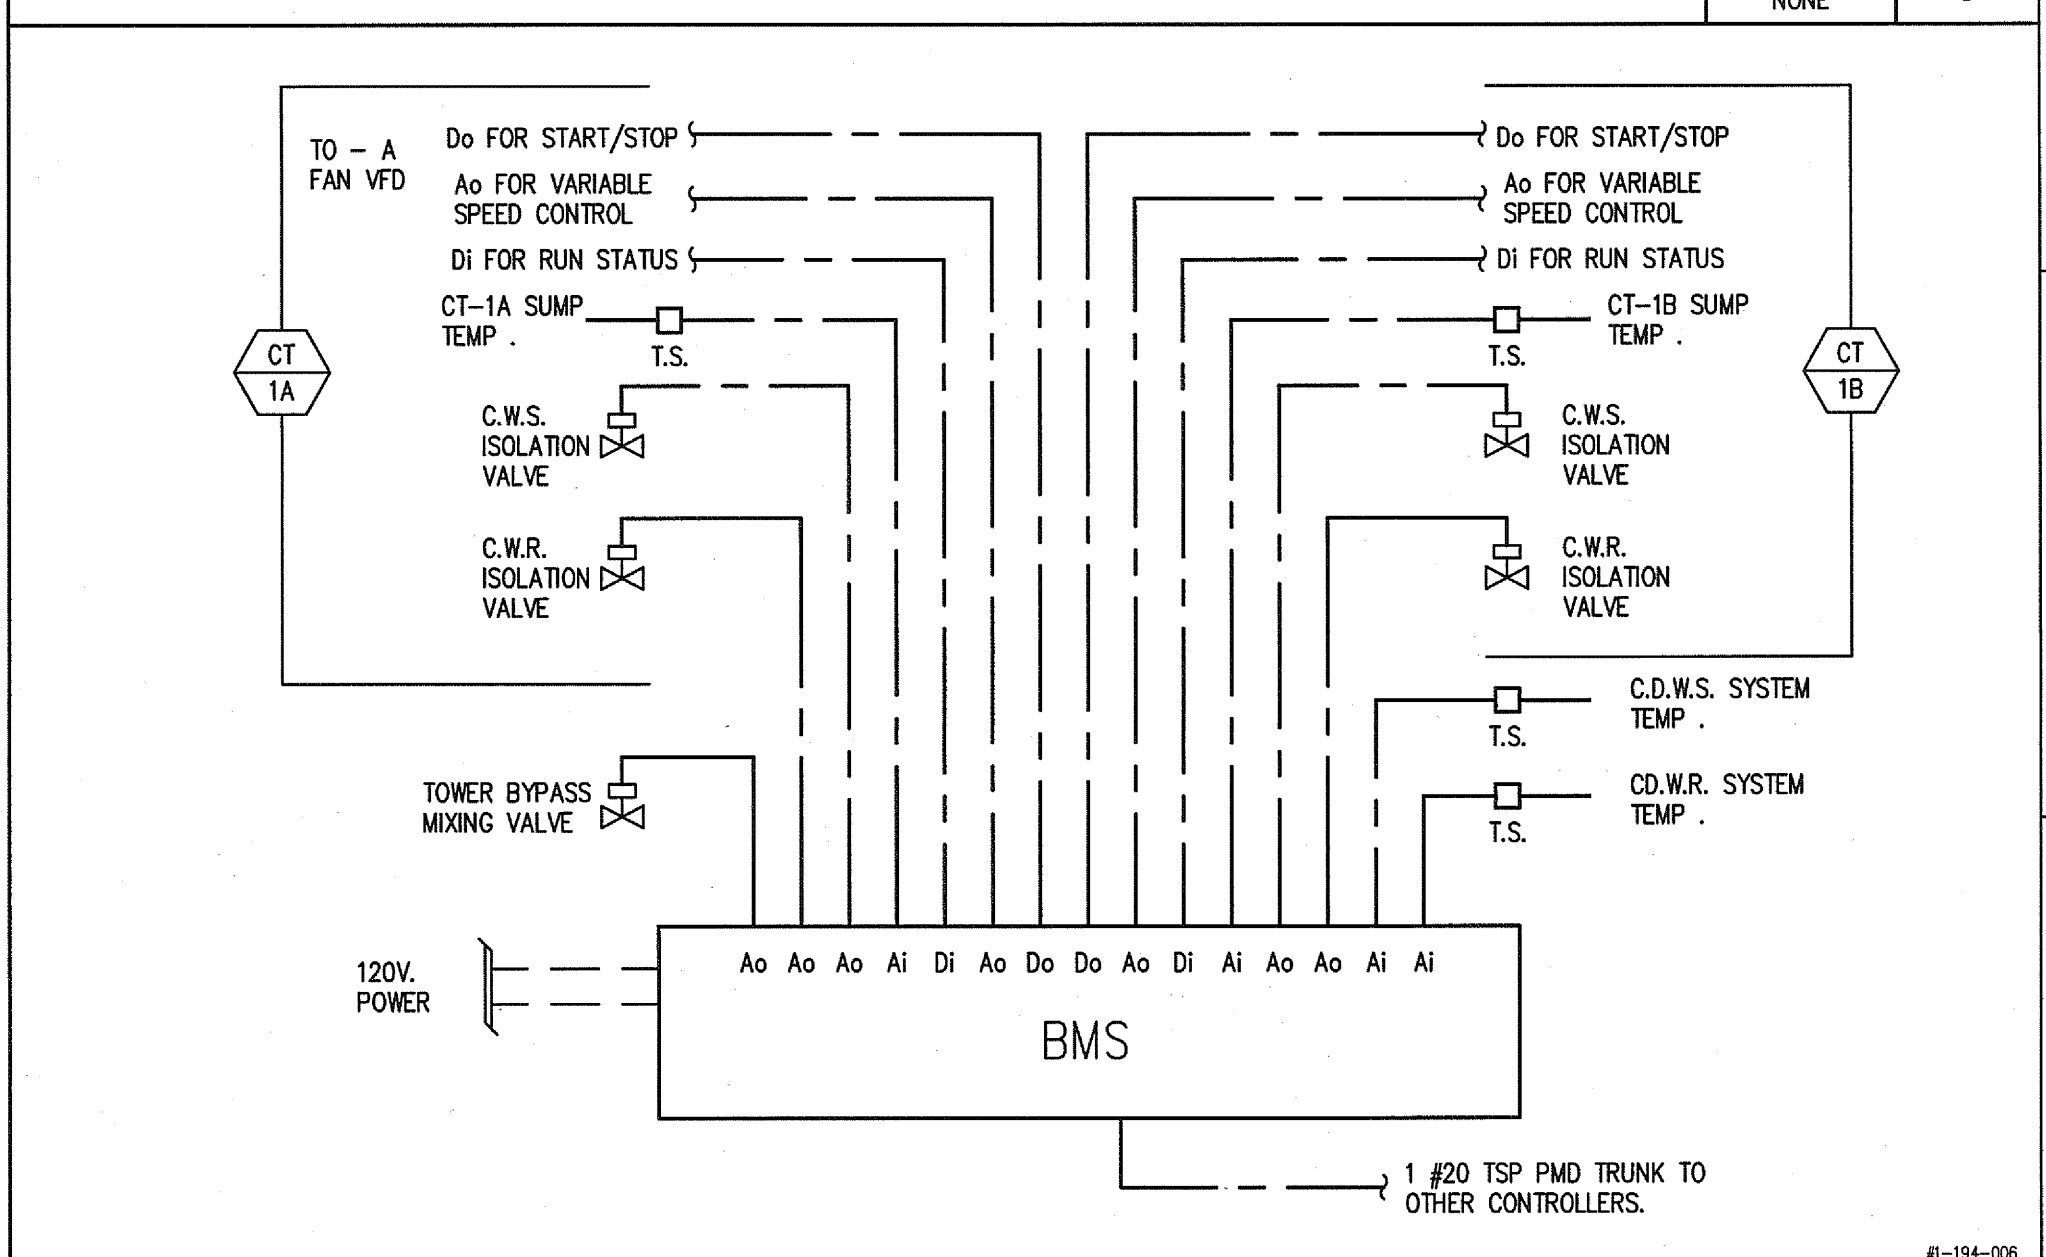

COOLING TOWER CONTROLS

SCALE NONE 4

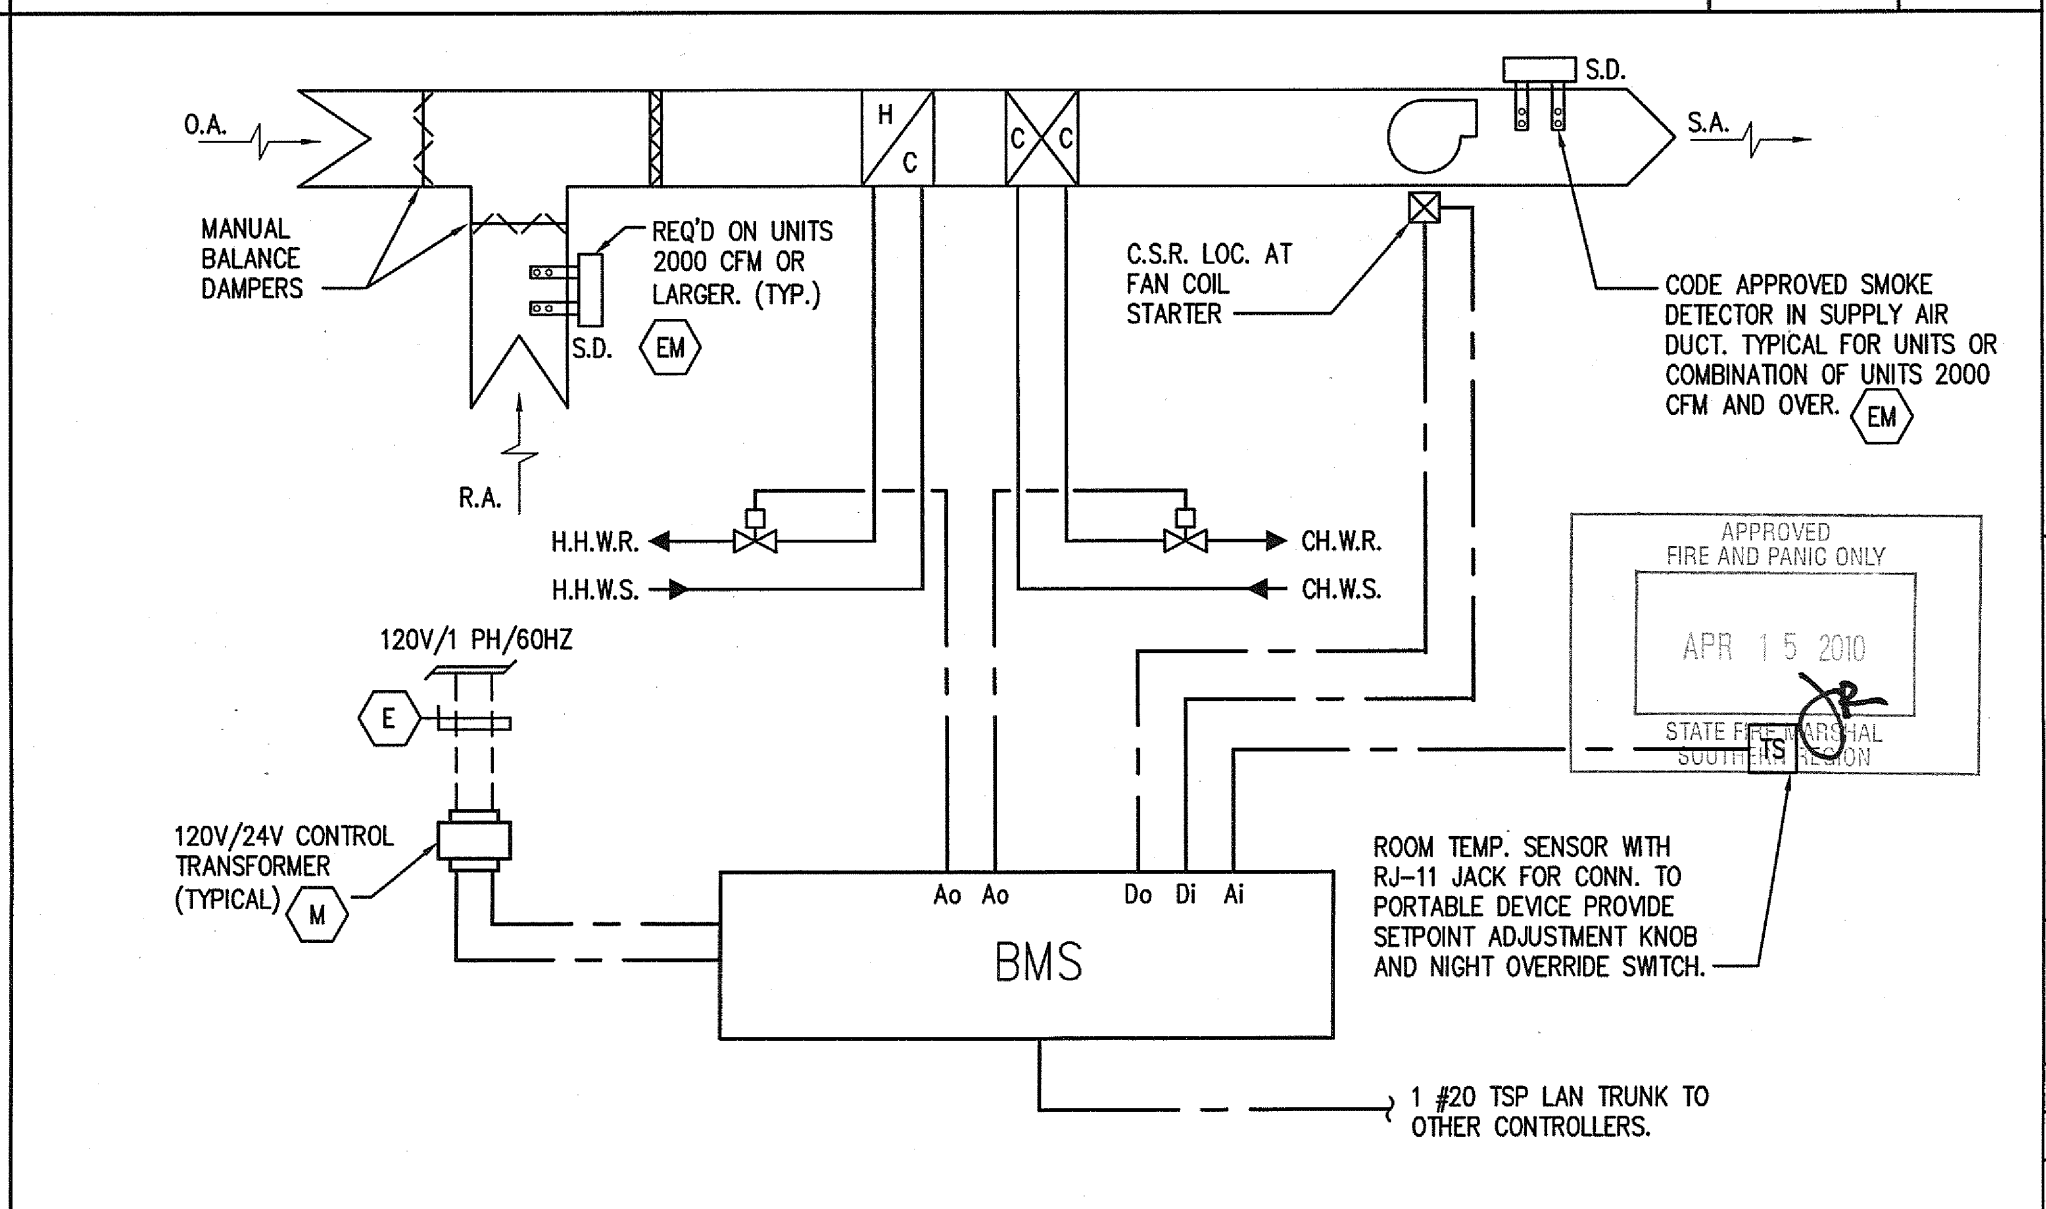

FAN COIL UNIT CONTROL

SCALE NONE 5

COPYRIGHT © FENTRESS ARCHITECTS

ISSUED FOR	DATE
Pre-Schematic Design	07/14/2008
Schematic Design	07/28/2008
BID PK #1	10/06/2008
50% Progress	10/24/2008
BID PK #1 80 CD	12/01/2008
BID PK #1 100 CD	02/16/2009
BID PK #2 100 CD	03/26/2009
100% CD	05/08/2009
CD 4	01/07/2010
CD 1	02/26/2010
CD 2	02/26/2010
CD 4	04/15/2010

PROJECT INFORMATION:
 PROJECT: 2880 TORREY PINES SCENIC DRIVE
 LA JOLLA, CALIFORNIA 92037

CONSULTANT:
 FENTRESS ARCHITECTS
 2880 Torrey Pines Scenic Drive
 La Jolla, CA 92037
 (619) 594-1000
 www.fentress.com

ARCHITECTS:
 DAVIS DAVIS ARCHITECTS
 2880 Torrey Pines Scenic Drive
 La Jolla, CA 92037
 (619) 594-1000
 www.davis-davis.com

STATE OF CALIFORNIA:
 FENTRESS ARCHITECTS
 DAVIS DAVIS ARCHITECTS

SHEET NAME: WIRING AND CONTROL DIAGRAMS
PROJECT #: 200725.000
SHEET NUMBER: M6002