

ISSUED FOR DATE	
BID PK #1	10/09/2009
50% Progress	10/24/2009
BID PK #1 80 CD	12/01/2009
BID PK #1 100 CD	02/16/2010
BID PK #2 100 CD	03/26/2010
100% CD	05/08/2010
CD 4	01/07/2010
COB 1	02/26/2010
COB 2	02/26/2010
CD 4	04/15/2010
RAW PERMIT	05/05/2010
ASIM008 R1	07/01/2010
ASIM005	07/08/2010
ASIM015	07/09/2010
ASIM004	07/12/2010
ASIM008R2	07/19/2010
ASIM010	08/13/2010
ASIM011	08/27/2010
ASIM020	09/20/2010
ASIM018	11/17/2010
ASIM026	12/15/2010
ASIM028R2	01/14/2011
ASIM028	01/21/2011
ASIM028R1	02/08/2011
ASIM018R1	02/16/2011
RFI#1203	02/16/2011

RW 2909

WORK ORDER NO. 431587

SANFORD CONSORTIUM FOR REGENERATIVE MEDICINE

2880 TORREY PINES SCENIC DRIVE
LA JOLLA, CALIFORNIA 92037

CONSULTANT

Architect

 3000 La Jolla Village Drive, Suite 100
 San Diego, CA 92161
 (619) 594-9000
 Fax: (619) 594-9001
 www.sanfordconsortium.com

Sanford/Phelps Consortium LLC
 415 Broadway, Denver, CO 80202
 (303) 733-0600
 Fax: (303) 733-0601
 www.sanfordphelps.com

FENTRESS ARCHITECTS
 415 Broadway, Denver, CO 80202
 (303) 733-0600
 Fax: (303) 733-0601
 www.fentressarchitects.com

DAVIS ARCHITECTS
 3000 La Jolla Village Drive, Suite 100
 San Diego, CA 92161
 (619) 594-9000
 Fax: (619) 594-9001
 www.davisarchitects.com


STAMP

 STATE OF CALIFORNIA
 PROFESSIONAL ENGINEER
 No. 12345
 Exp. 9-30-10

SHEET NAME: PARTIAL PLUMBING FIRST FLOOR PLAN - ZONE 1
 DRAWN BY: Author
 PROJECT #: 200725.000
 SHEET NUMBER

P2211

- KEY NOTES:**
- 2" LW DOWN, 1 1/2" LW RISE.
 - 1/2" CW, 1/2" HW, AND 1/2" CW DROP.
 - (2) 1 1/2" DN DROP.
 - 1/2" CO2 DROP WITH SOV AT 96" AFF FOR INC.
 - 3/4" LV, 1/2" LA, 1/2" G AND 1/2" CW DROP TO FUME HOOD.
 - 3/4" LV, 1/2" LA, AND 1/2" G DROP.
 - PRESSURE REGULATOR SET AT 20 PSI, x CFM CAPACITY, PROVIDE 1/2" CAPED ICE IMMEDIATELY UPSTREAM OF REGULATOR.
 - 3/4" LV AND 1/2" LA DROP AND CONNECT TO CEILING PANEL.
 - 1/2" G DROP.
 - 1/2" DN SOV AT 84" AFF FOR OWNER CONNECTION TO WATER POLISHER.
 - 2" CW, 2" CW, 2 1/2" LV, 1 1/2" LA, 1" G, 1 1/4" CO2, 3/4" HW, 2" HW, (3) 1 1/2" DN, 1 1/2" DN, 3" CW, 2 1/2" WG UP.
 - 3/4" CO DROP AND SPILL INTO FLOOR SINK.
 - RUN 1/2" CW TO VALVE IN RECESSED BOX FOR REFRIG. ICE MAKER.
 - 2" CW, 1 1/4" LV, 3/4" LA, AND 3/4" CO2 DOWN.
 - PRE-ACTION FIRE SPRINKLER VALVE ASSEMBLY FOR MOP ROOM AND IT ROOM, SEE FIRE PROTECTION PLANS.
 - LINE SIZE REDUCED PRESSURE TYPE BACKFLOW PREVENTER, ROUTE FUNNEL DRAIN TO FLOOR SINK. SEE DETAIL 13/P5002.

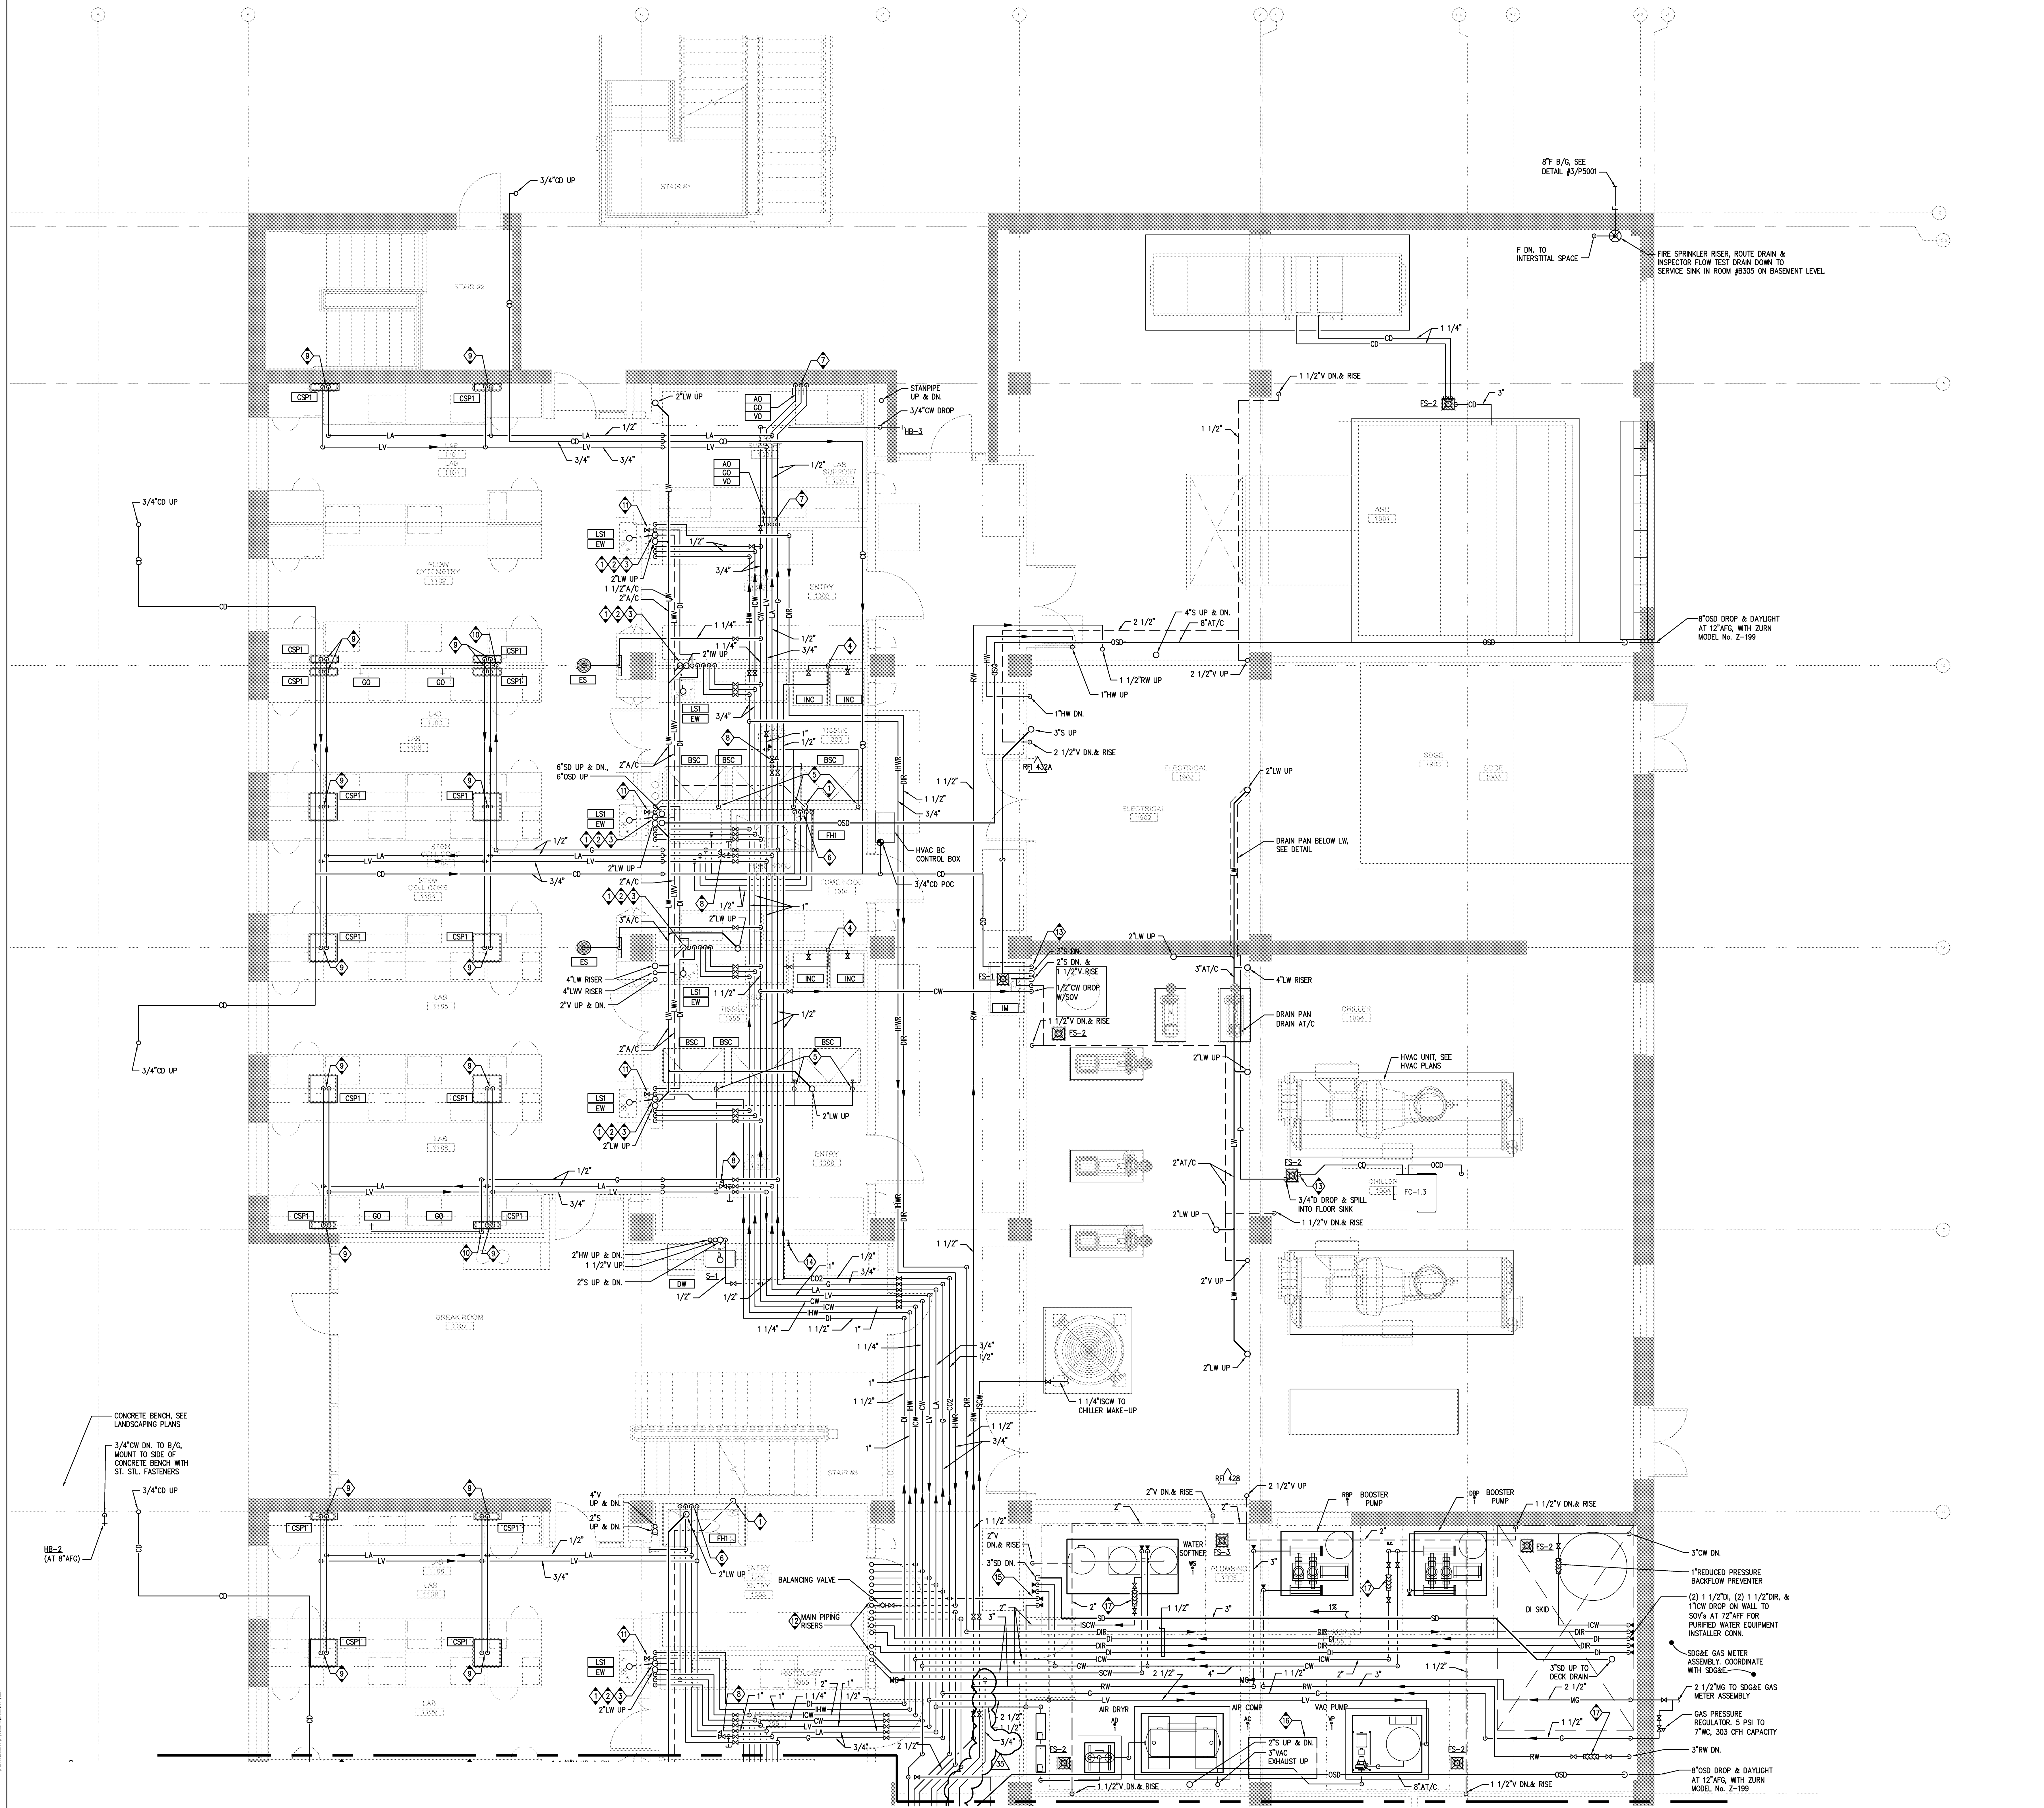

PARTIAL PLUMBING FIRST FLOOR PLAN - ZONE 1

SCALE
1/4" = 1'-0"

1

10/25/2009 4:42:10 PM
 F:\P\2909

Warning: It is a violation of the law for any person, unless acting under the direction of a licensed architect, to alter an item in any way. If an item in this document is altered, the altering architect, if other than the architect of record, shall affix the item his seal and the notation "altered by" followed by his signature and the date of such alteration, and the specific description of the alteration.