


1/22/2025 4:22:10 PM
P:\Sanford\Sanford_Consortium\DWG\Sanford_Consortium_2025.dwg
File Path:

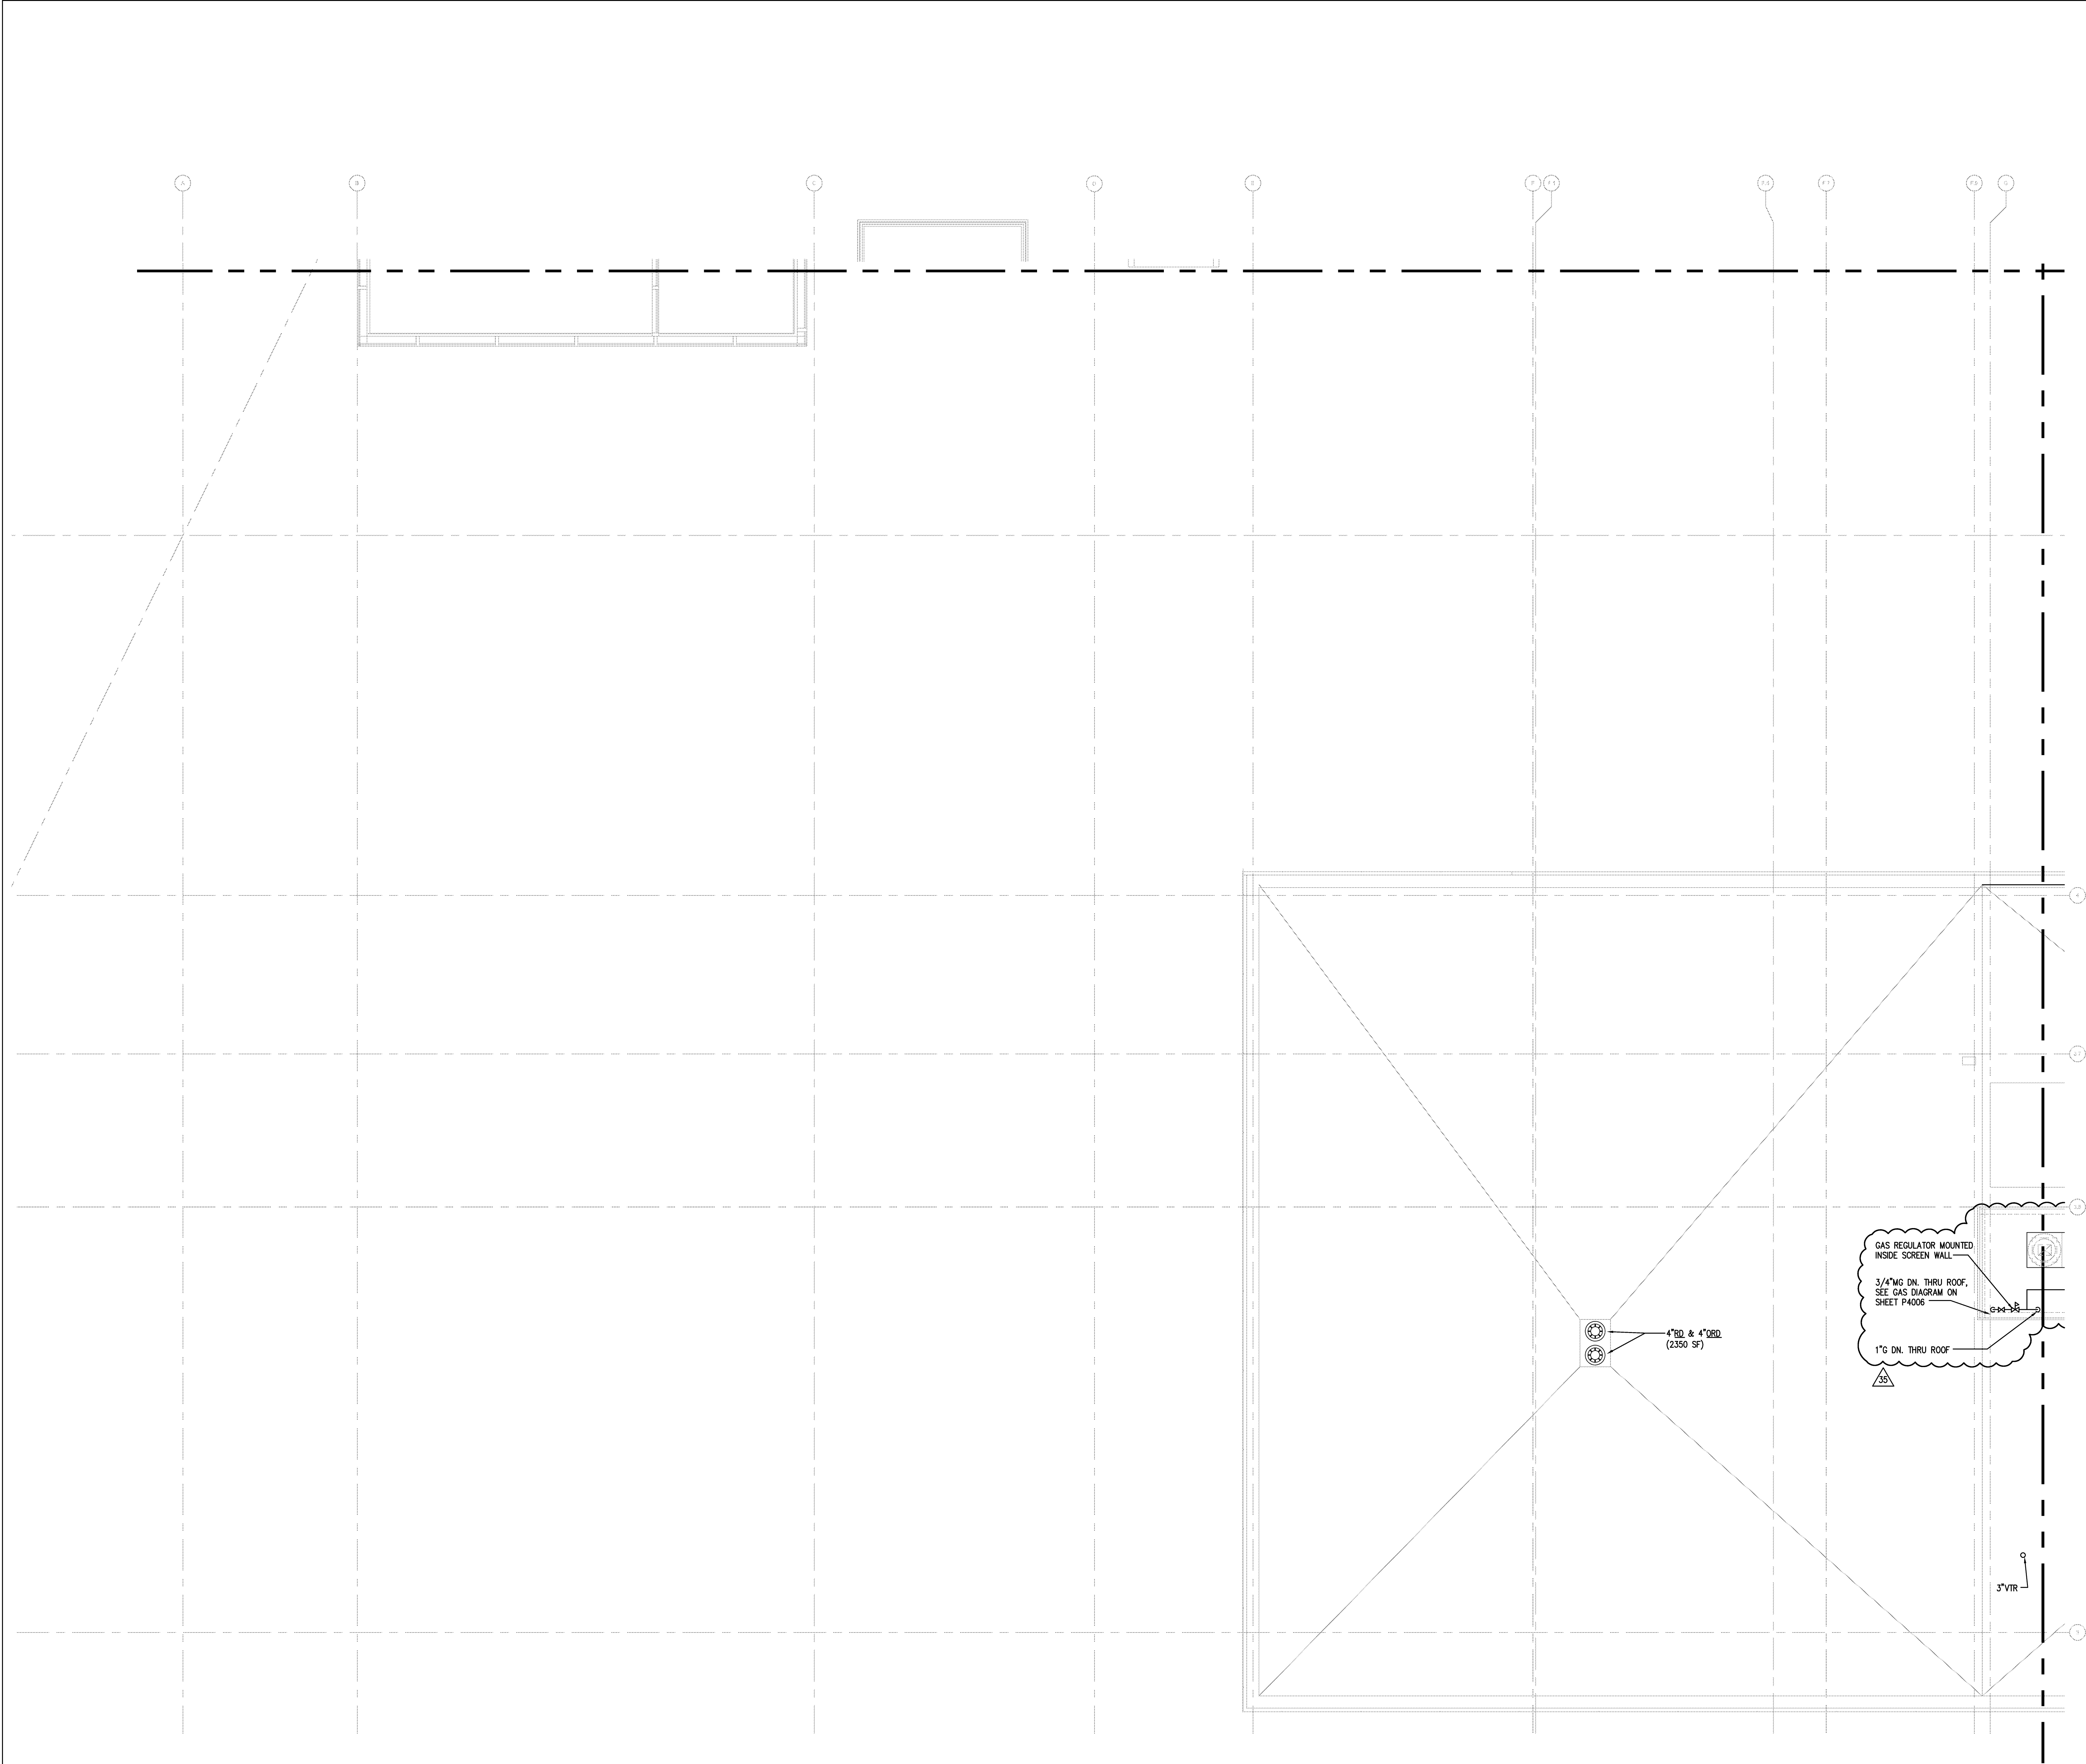

PARTIAL PLUMBING THIRD FLOOR PLAN – ZONE 3


Warning: It is a violation of the law for any person, unless acting under the direction of a licensed architect, to alter an item in any way. If an item in this document is altered, the altering architect, if other than the architect of record, shall affix the item his seal and the notation "altered by" follows by his signature and the date of such alteration, and the specific description of the alteration.



SCALE
1/4" = 1'-0"

1

APPROVED
FIRE AND RAIN ONLY
03 16 2011
DATE
FENTRESS ARCHITECTS
415 Broadway, Denver, CO 80202
303.733.0000
STATE FIRE MARSHAL
CONSTRUCTION SERVICES

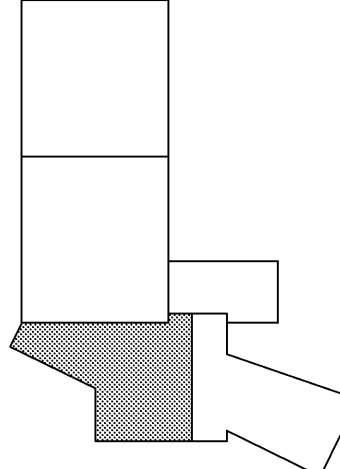

SHEET NAME
PARTIAL PLUMBING THIRD
FLOOR PLAN - ZONE 3

DRAWN BY: Author
PROJECT # 200725.000
SHEET NUMBER

P2233

FENTRESS ARCHITECTS
415 Broadway, Denver, CO 80202
303.733.0000
STATE FIRE MARSHAL
CONSTRUCTION SERVICES
P A V I S
ARCHITECTS
3001 Park Avenue, San Diego, CA 92103

Lanford/Phelps Consortium LLC
6100 16th Avenue, Suite 100, Boulder, CO 80501
303.440.1000
303.440.1001

CONSULTANT
Xyth
Xyth Architects, Inc.
3001 Park Avenue, Suite 100, Boulder, CO 80501
303.440.1000
303.440.1001
Xyth 200804



SANFORD CONSORTIUM FOR REGENERATIVE MEDICINE
2880 TORREY PINES SCENIC DRIVE
LA JOLLA, CALIFORNIA 92037

WORK ORDER NO. 431587

RW 2909

COPYRIGHT © FENTRESS ARCHITECTS	
ISSUED FOR	DATE
BID PK #1	10/07/2008
50% Progress	10/24/2008
BID PK #1 80 CD	12/01/2008
BID PK #1 100 CD	02/16/2009
BID PK #2 100 CD	03/26/2009
100% CD	05/08/2009
CD 4	01/07/2010
COB 1	02/26/2010
COB 2	02/26/2010
CD 4	04/15/2010
RAW PERMIT	05/05/2010
ASIM008 R1	07/01/2010
ASIM005	07/08/2010
ASIM015	07/08/2010
ASIM004	07/12/2010
ASIM008R2	07/19/2010
ASIM010	08/13/2010
ASIM011	08/27/2010
ASIM020	09/20/2010
ASIM018	11/17/2010
ASIM028	12/15/2010
ASIM028R2	01/14/2011
ASIM028	01/21/2011
ASIM028R2	01/28/2011
ASIM018R	02/16/2011
RFI#1203	02/16/2011