



1/22/2025 4:42:10 PM
P:\DWG\DWG\2025\25000\25000-04.dwg
File Path:


Warning: It is a violation of the law for any person, unless acting under the direction of a licensed architect, to alter an item in any way. If an item in this document is altered, the altering architect, if other than the architect of record, shall affix the item his seal and the notation "altered by" followed by his signature and the date of such alteration, and the specific description of the alteration.

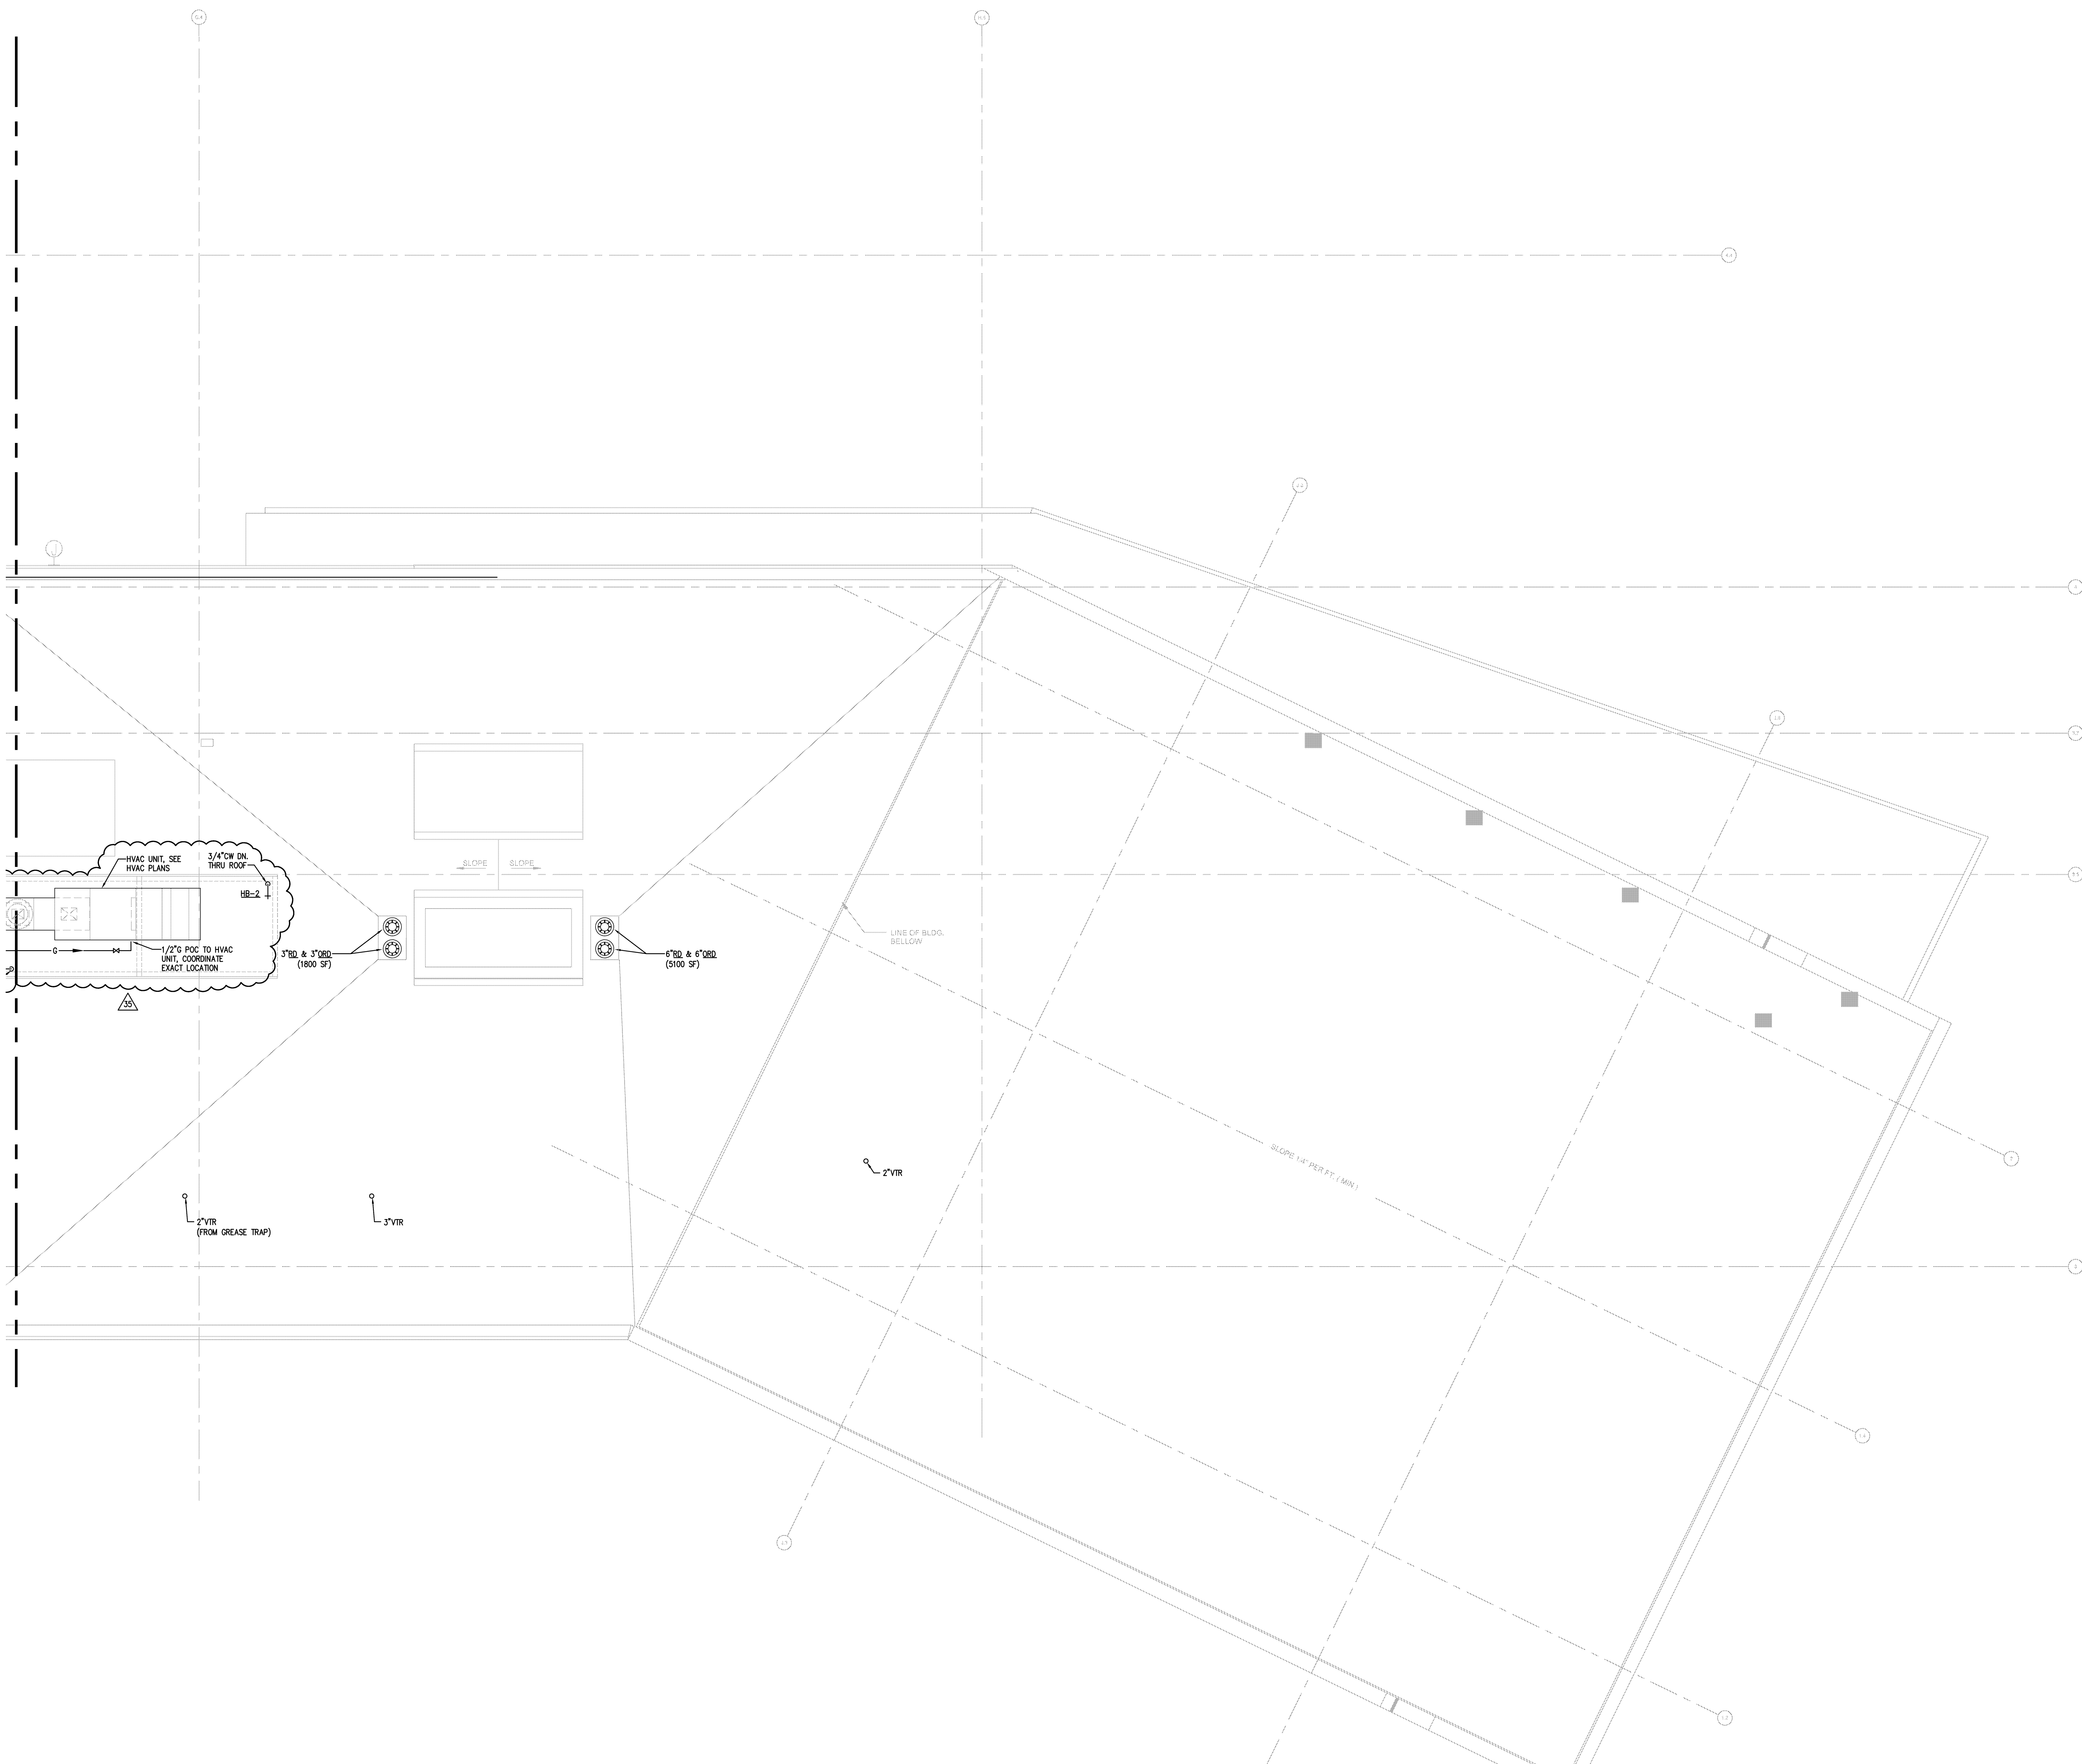

PARTIAL PLUMBING THIRD FLOOR PLAN - ZONE 4

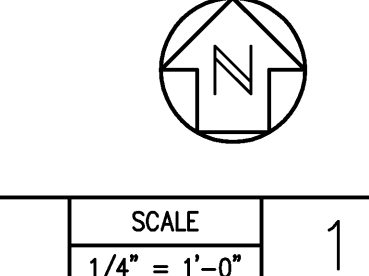

APPROVED
FIRE AND RAIN ONLY
03.16.2011
DATE
FENTRESS ARCHITECTS
CONSTRUCTION SERVICES

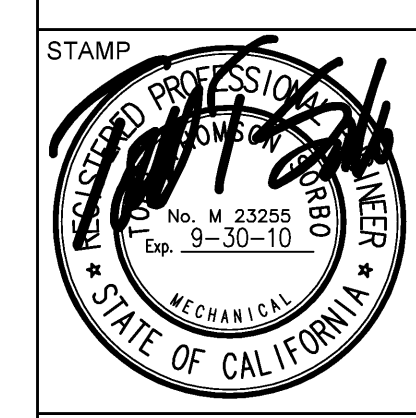


SHEET NAME
PARTIAL PLUMBING THIRD
FLOOR PLAN - ZONE 4
DRAWN BY: Author
PROJECT # 200725.000
SHEET NUMBER

P2234

FENTRESS ARCHITECTS
415 Broadway, Denver, CO 80202
(303) 733-0000
FENTRESS ARCHITECTS
415 Broadway, Denver, CO 80202
(303) 733-0000

Lanford/Phelps Consortium LLC
1010 17th Street, Suite 1000
San Francisco, CA 94103
(415) 774-1000

CONSULTANT
Xrth
Xrth
3071 17th St, Suite 1000
San Francisco, CA 94103
(415) 774-1000

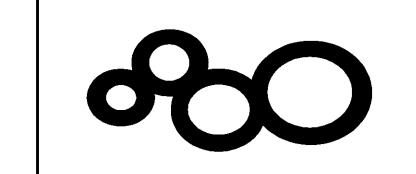

SANFORD CONSORTIUM FOR REGENERATIVE MEDICINE
2880 TORREY PINES SCENIC DRIVE
LA JOLLA, CALIFORNIA 92037

WORK ORDER NO. 431587

RW 2909

ISSUED FOR		DATE
BID PK #1	10/07/2008	
50% Progress	10/24/2008	
BID PK #1 80 CD	12/01/2008	
BID PK #1 100 CD	02/16/2009	
BID PK #2 100 CD	03/26/2009	
100% CD	05/08/2009	
CD 1	01/07/2010	
CD 2	02/26/2010	
CD 4	04/15/2010	
RAW PERMIT	05/05/2010	
ASIM008 R1	07/01/2010	
ASIM005	07/08/2010	
ASIM015	07/09/2010	
ASIM004	07/12/2010	
ASIM008R2	07/19/2010	
ASIM010	08/13/2010	
ASIM011	08/27/2010	
ASIM020	09/20/2010	
ASIM018	11/17/2010	
ASIM028	12/15/2010	
ASIM028R2	01/14/2011	
ASIM028	01/21/2011	
ASIM028R2	01/28/2011	
ASIM018R	02/16/2011	
RFI#1203	02/16/2011	