

NORMAL CONDITION:

DURING NORMAL OPERATION DOMESTIC COLD WATER BY-PASS LOCKABLE VALVE IS LOCKED OFF. CITY TO RETAIN POSSESSION OF KEY FOR LOCK VALVE.

RECYCLED WATER RUNS THRU REMOVABLE RECYCLED WATER METERS.

BY-PASS CONDITION:

DURING BY-PASSING, THE RECYCLED WATER REMOVABLE WATER METERS SHALL BE REMOVED AND THE REMOVABLE RPW PIPING SHALL BE INSTALLED.


CONNECT THE BY-PASS FIRE HOSE TO THE DOMESTIC COLD WATER LOOKALIKE VALVE AND TO THE RECYCLED WATER REMOVABLE PIPING SPOOL.

OPEN COLD WATER BY-PASS LOOKALIKE VALVE.

DOMESTIC COLD WATER RUNS THRU BY-PASS HOSE WITH BACKFLOW PREVENTER TO SERV RECYCLED WATER SYSTEM. SEE DETAILS ON SHEET P000.

RECYCLED WATER REMOVAL AND TEMPORARY CONNECTION ASSEMBLY WILL BE COORDINATED WITH THE CITY RECYCLED WATER DIVISION AND COUNTY DEPARTMENT OF ENVIRONMENTAL HEALTH.







PORTABLE BACKFLOW ON THE BY-PASS FIRE HOSE SHALL BE TESTED WITH THE CITY AND COUNTY PRESENT PRIOR TO USE IN THE TEMPORARY BY-PASS CONDITION.

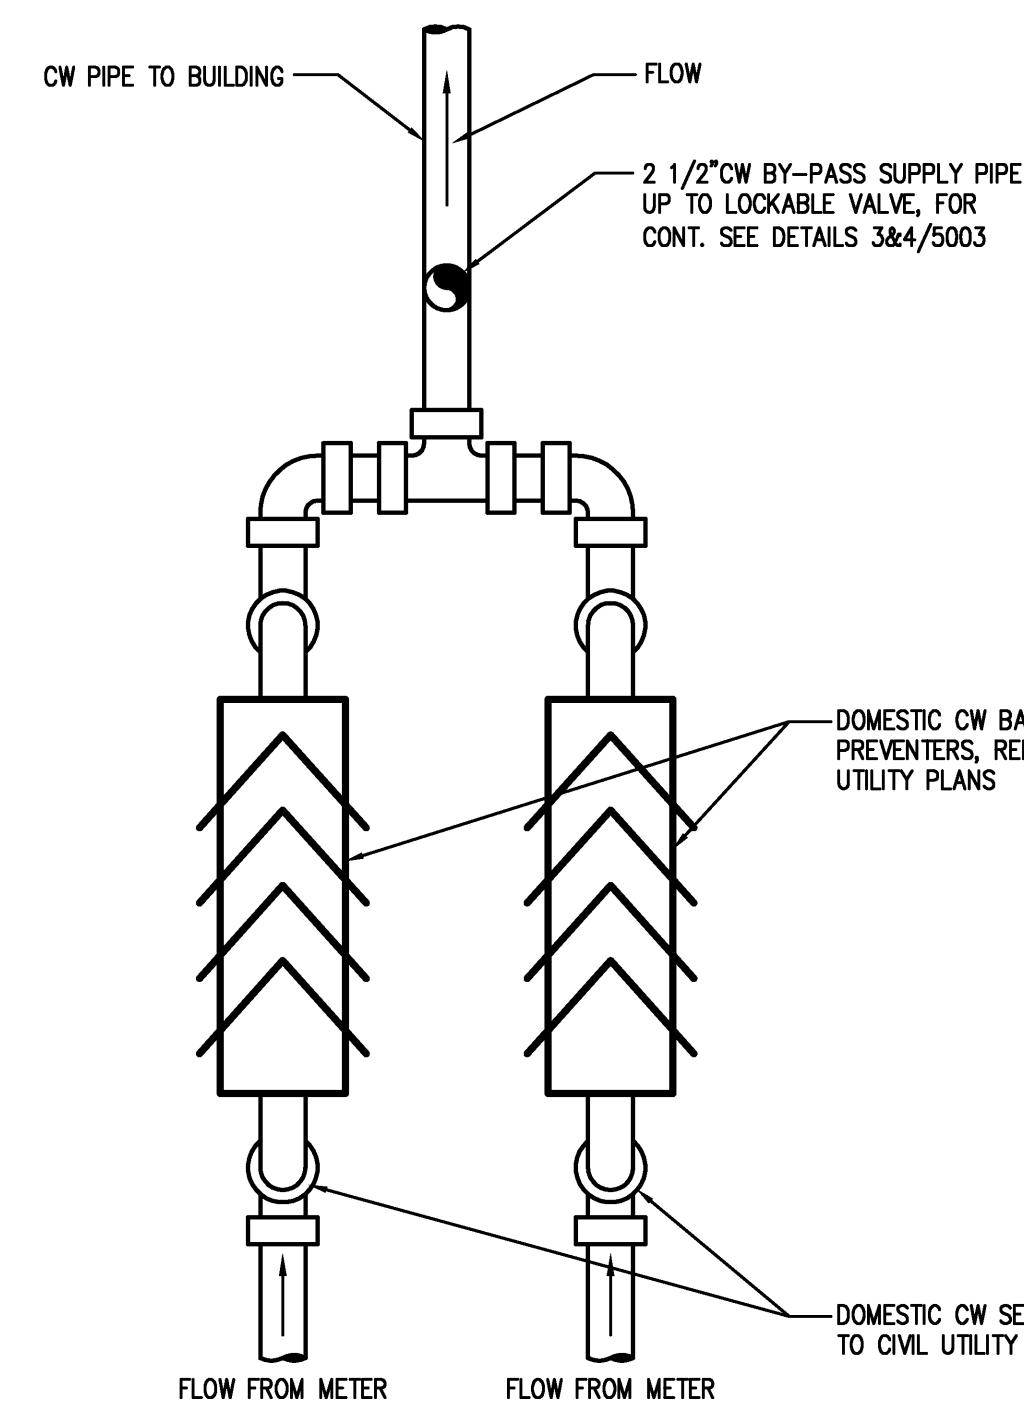

RW 2909

2880 TORREY PINES SCENIC DRIVE
LA JOLLA, CALIFORNIA 92037

WORK ORDER NO. 431587

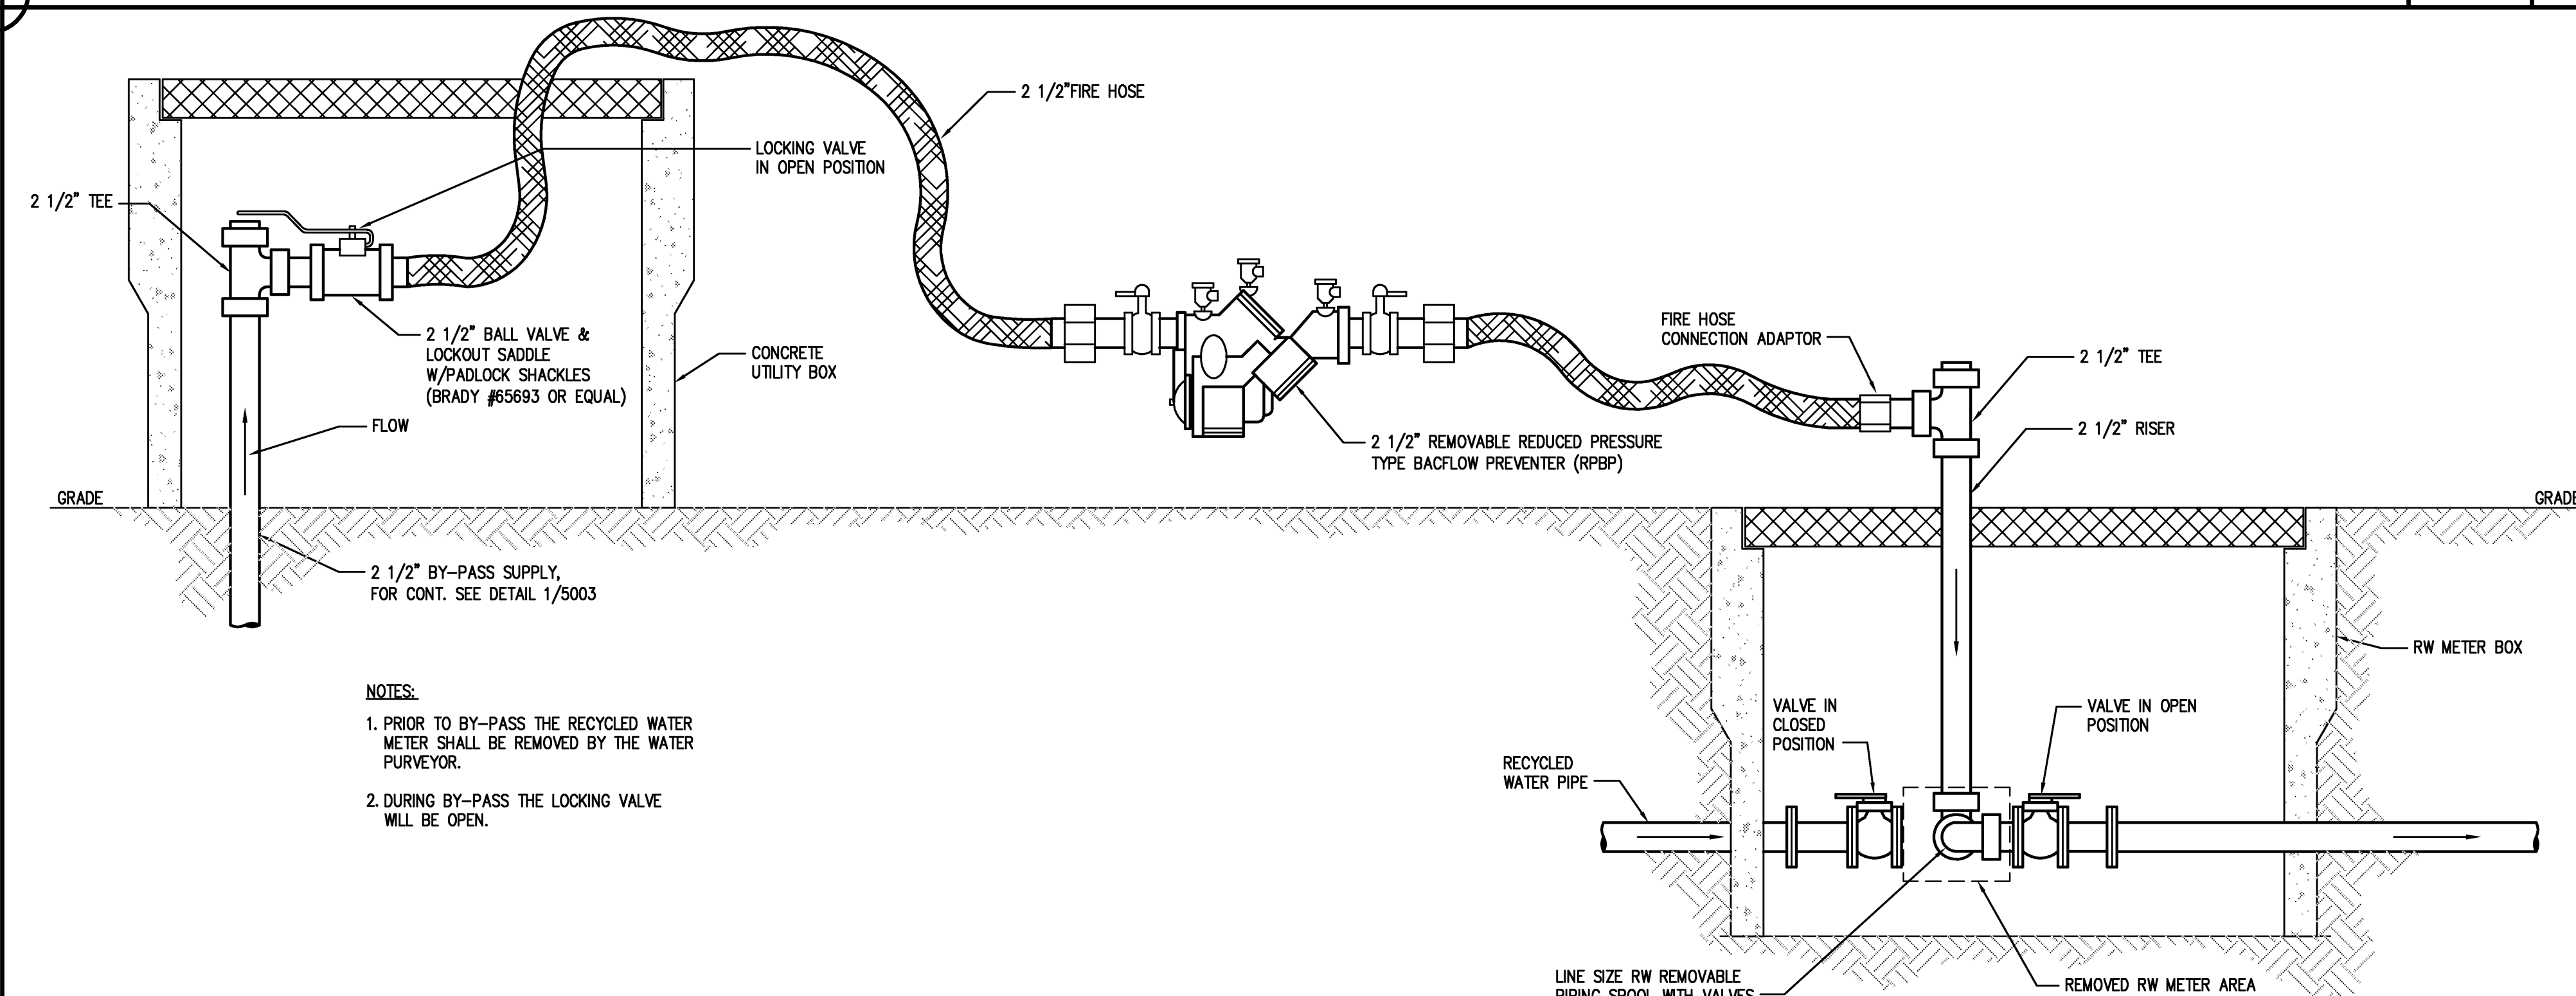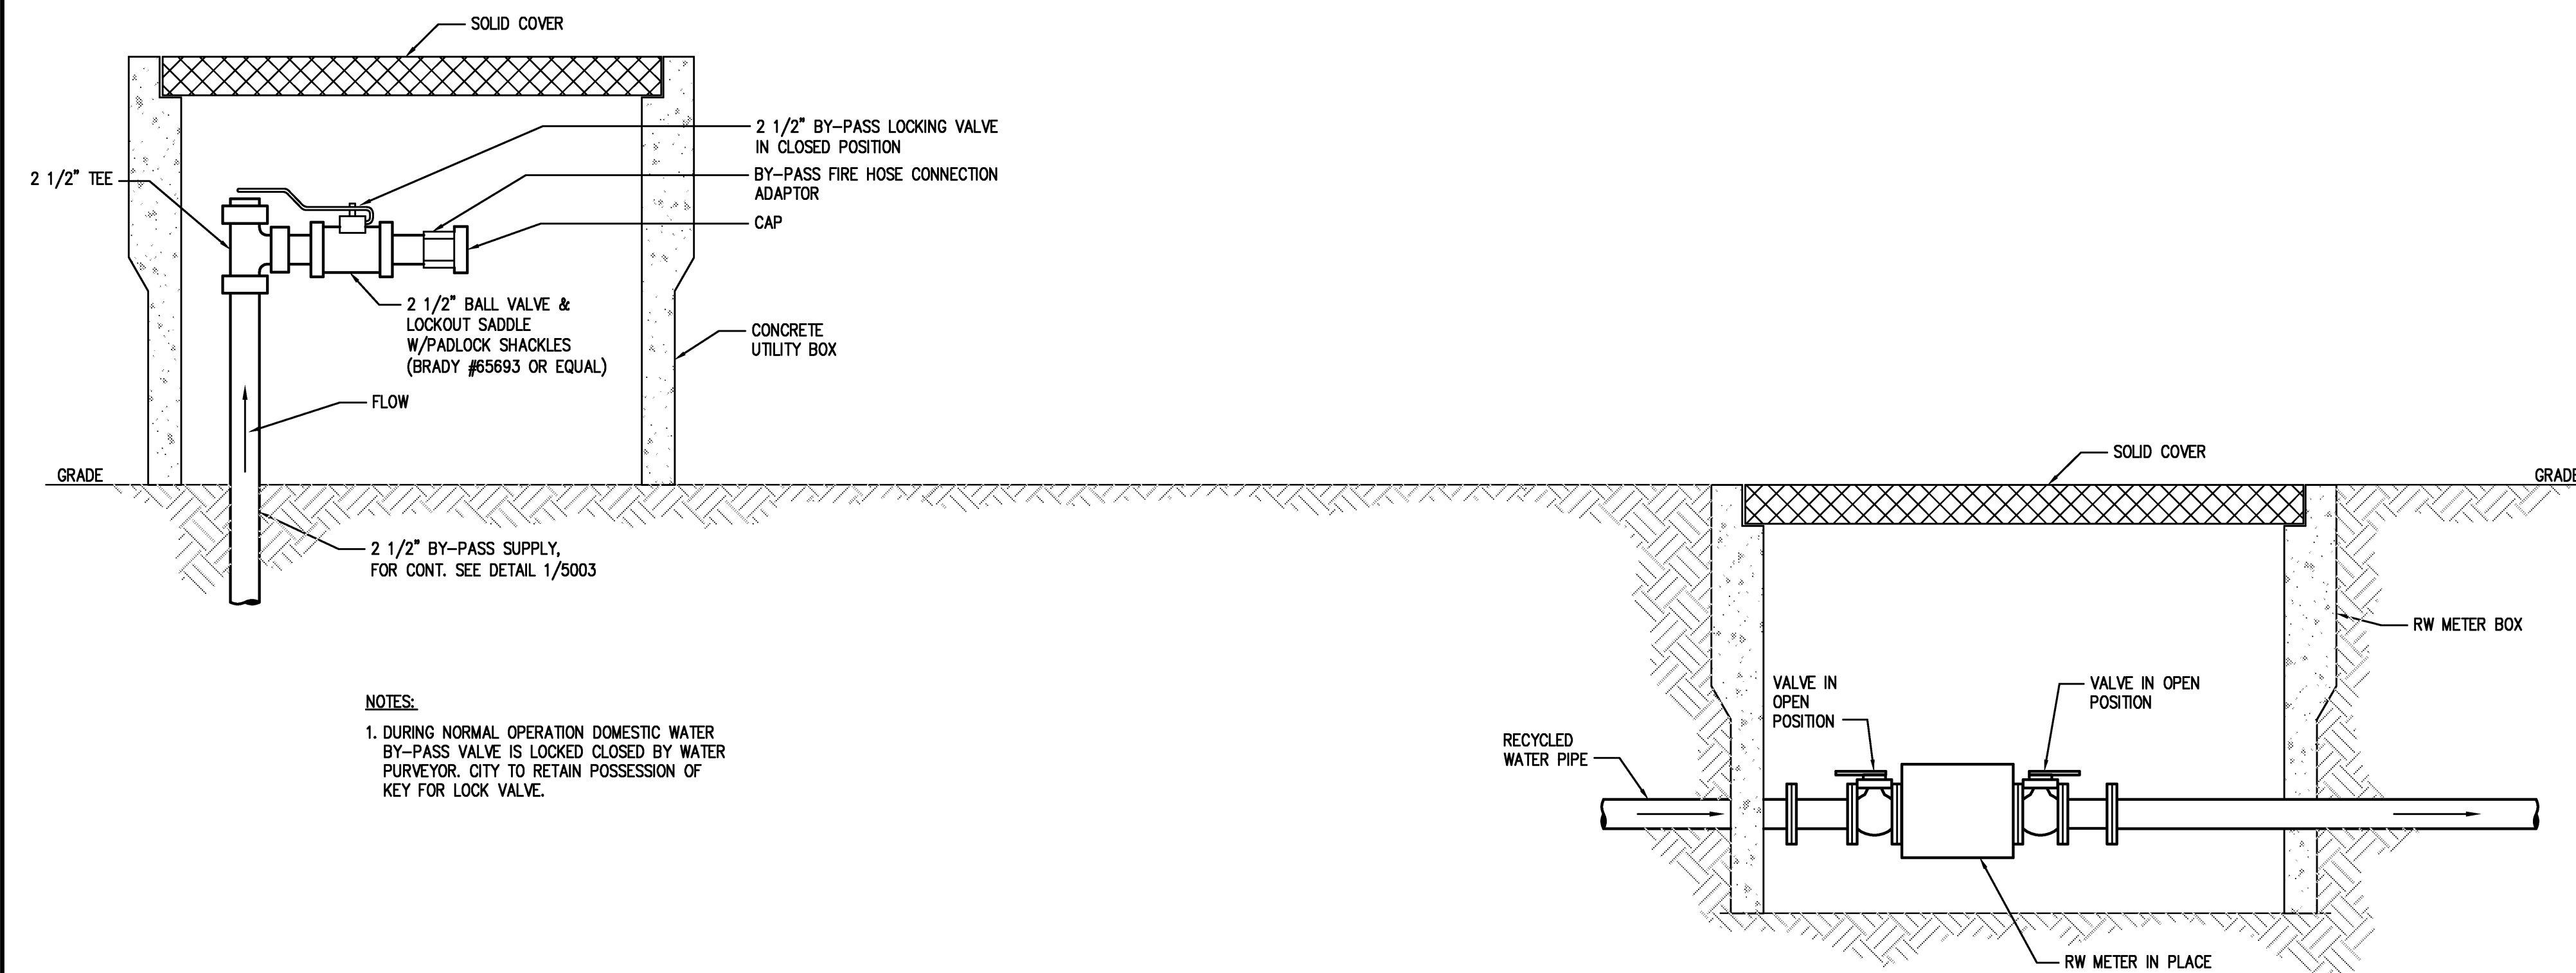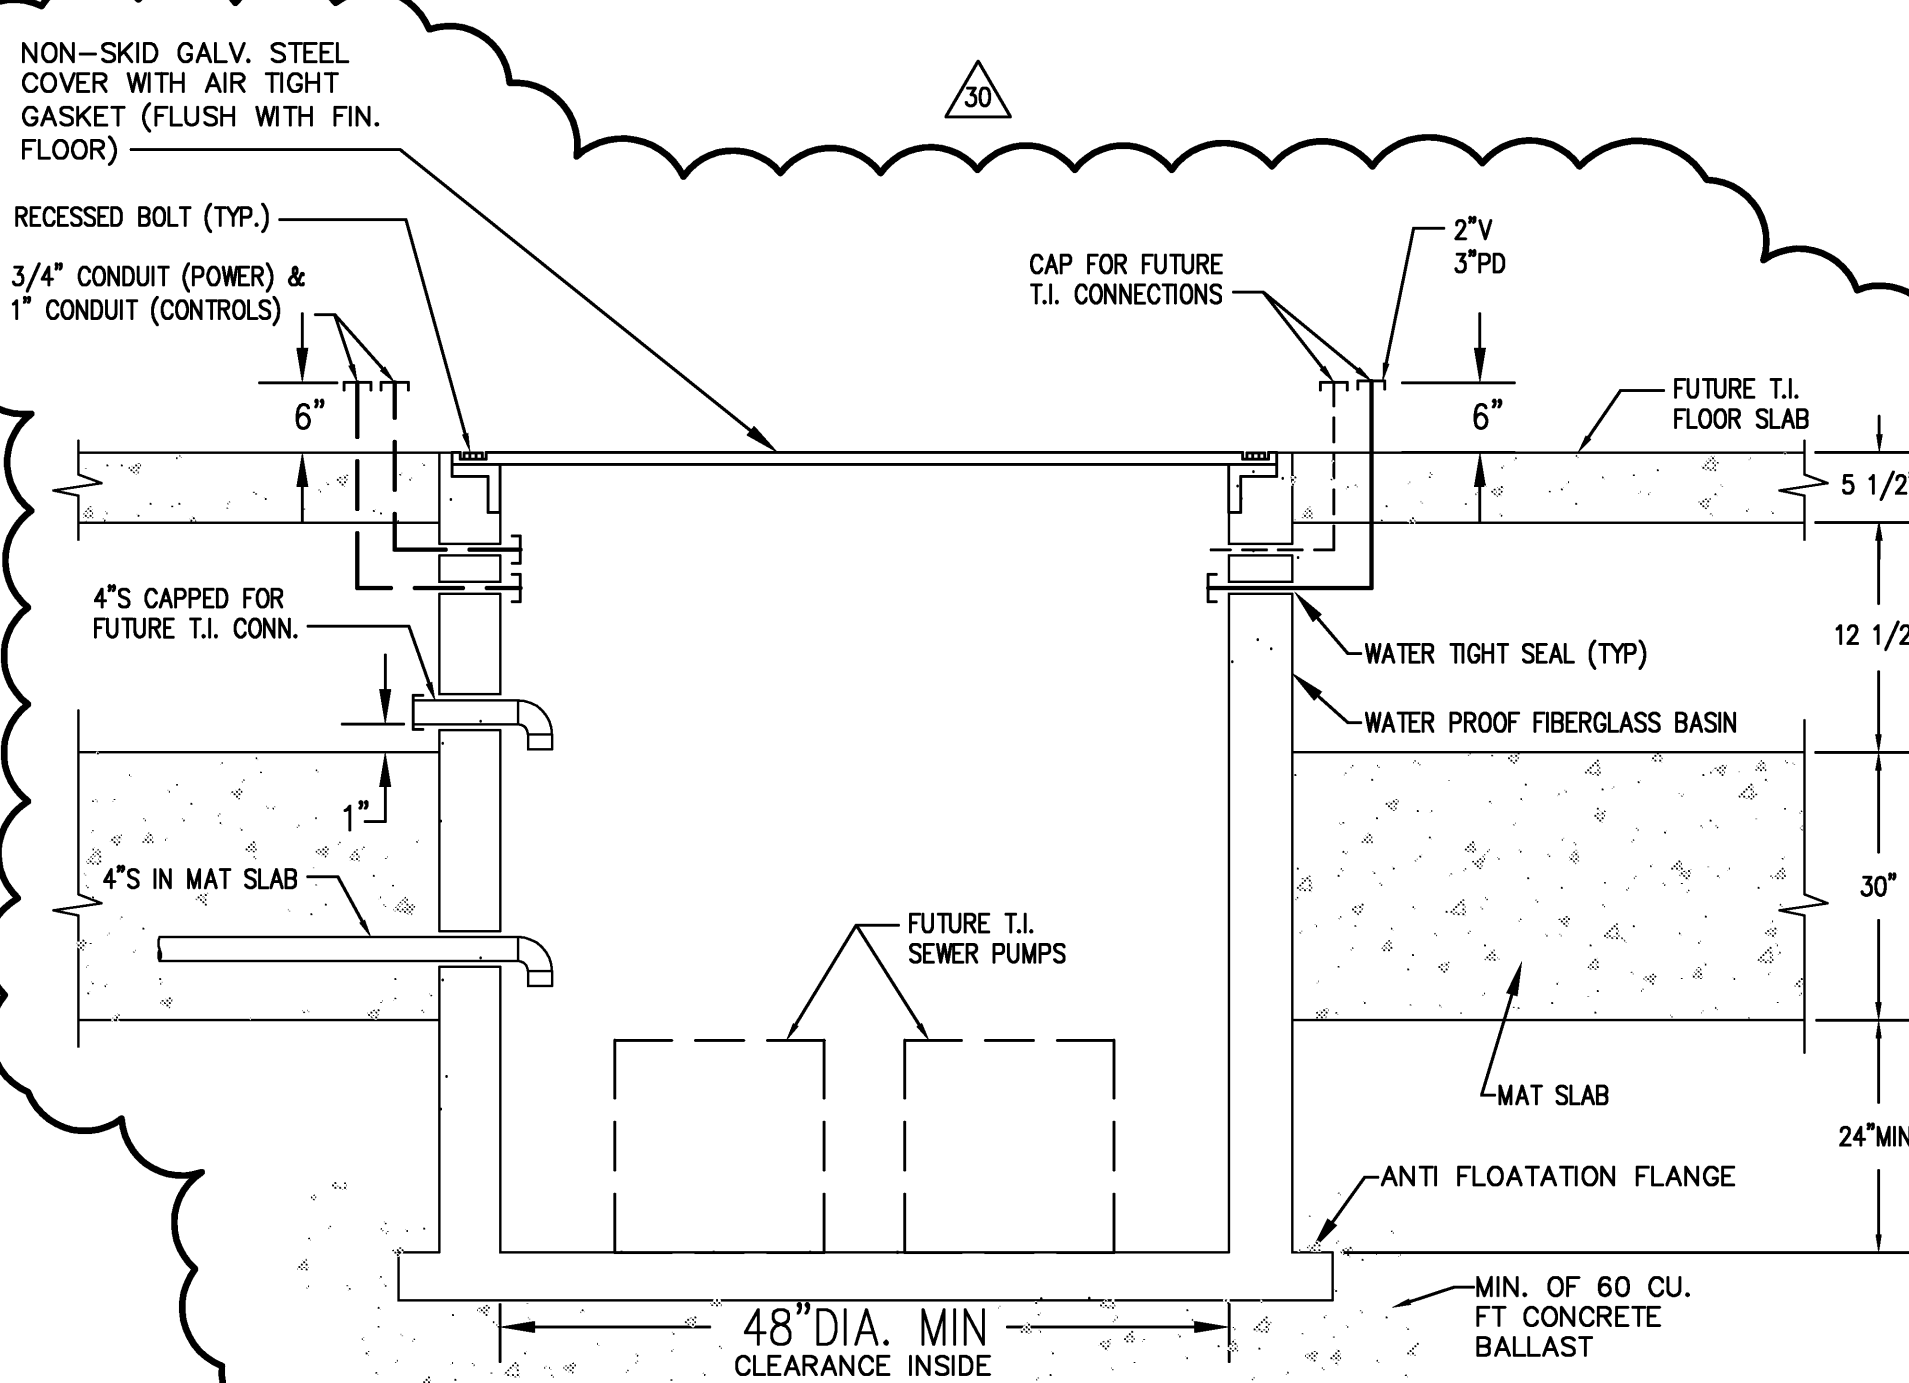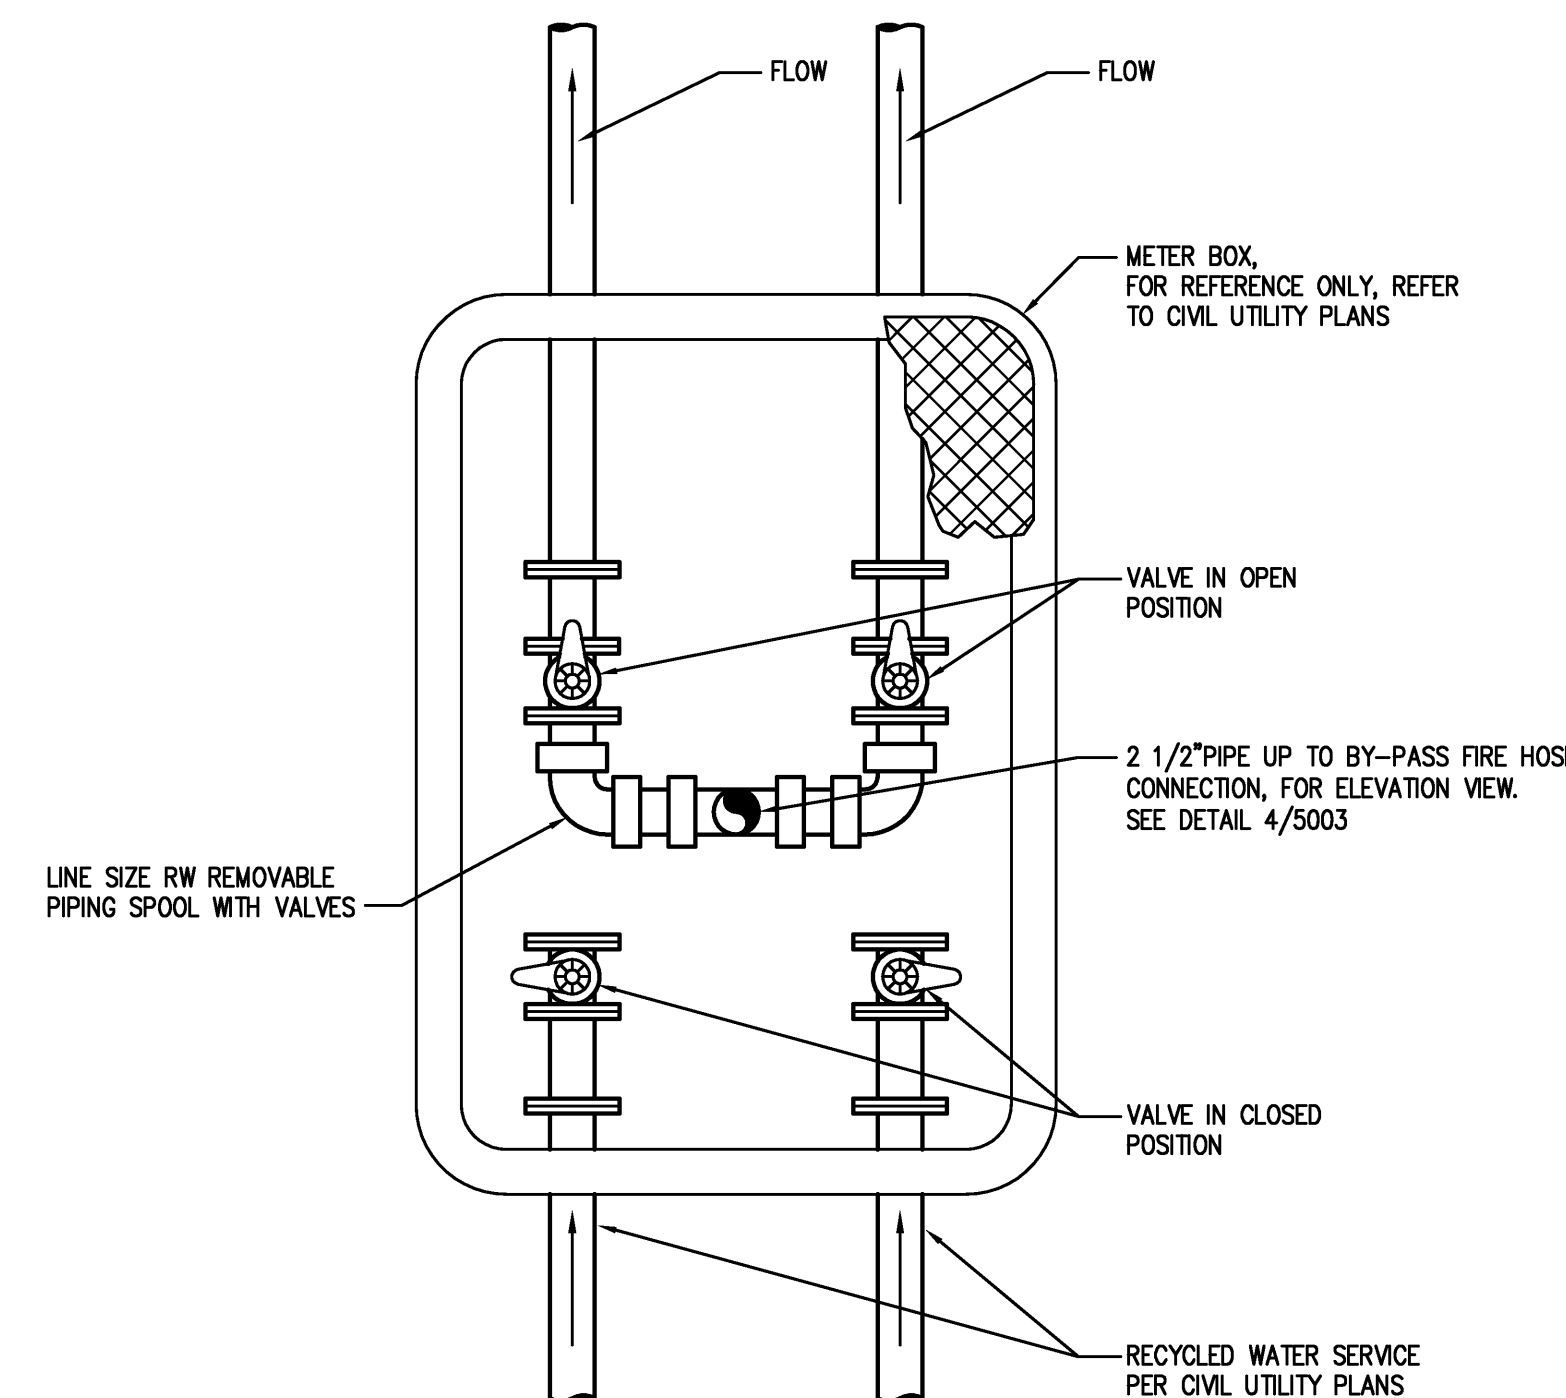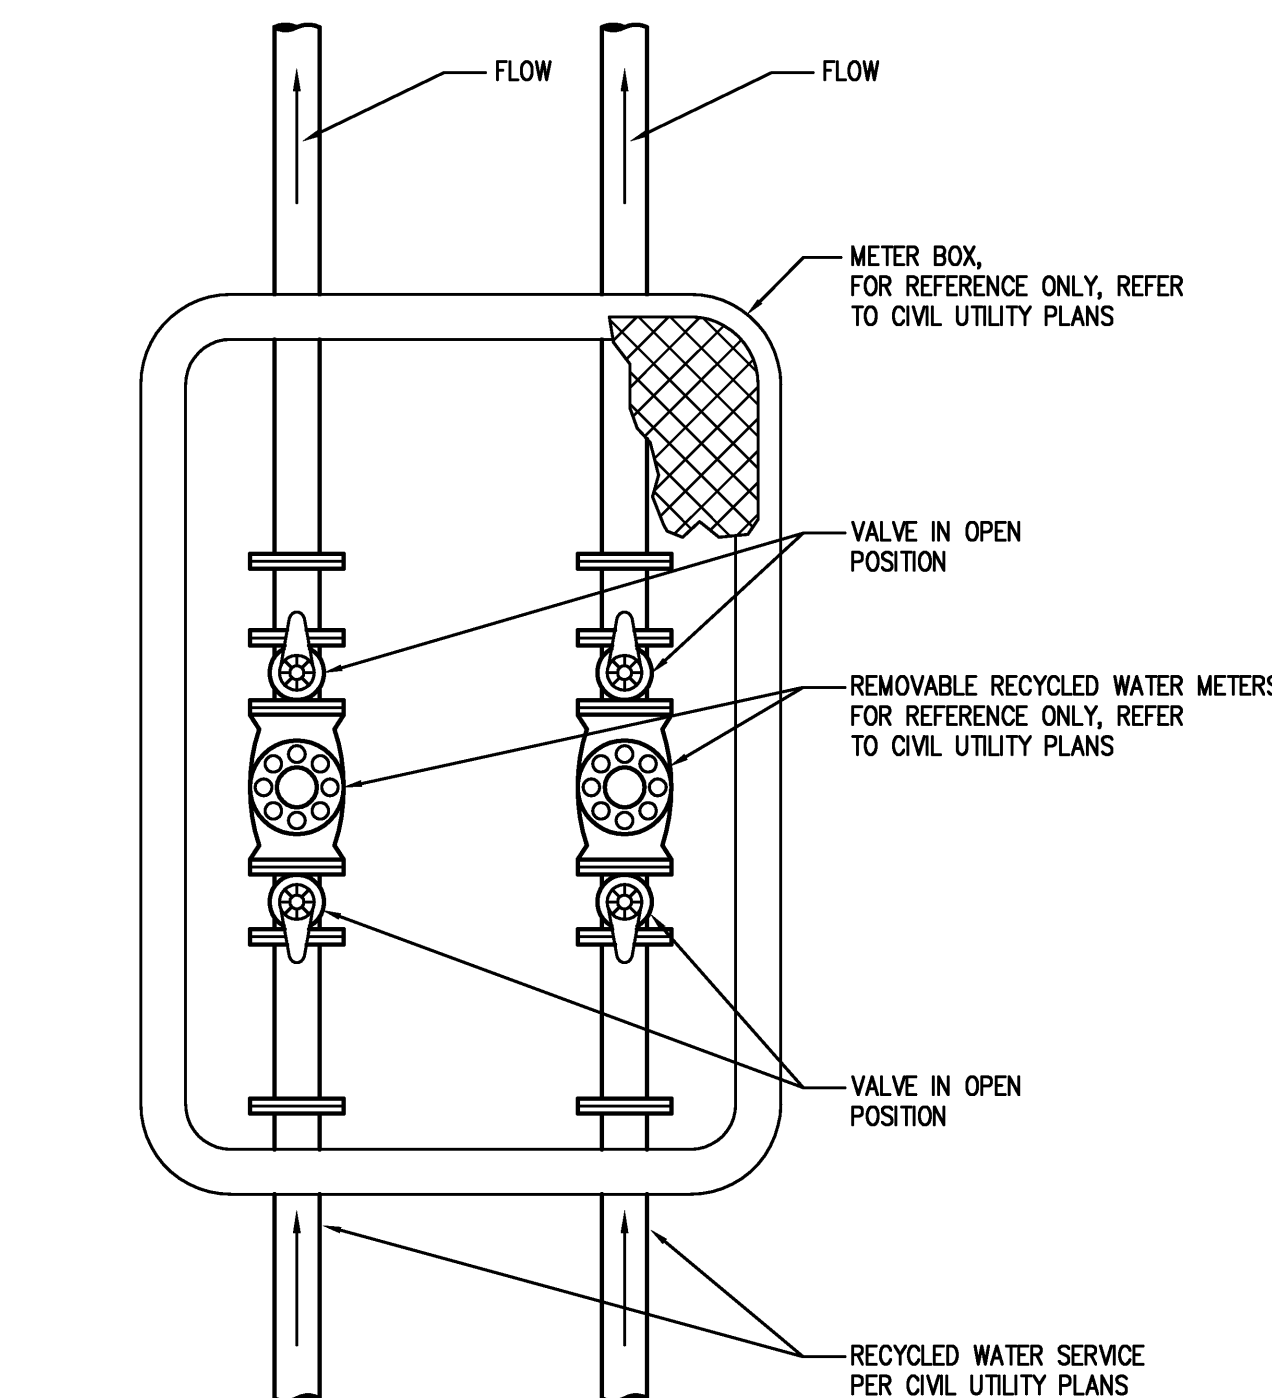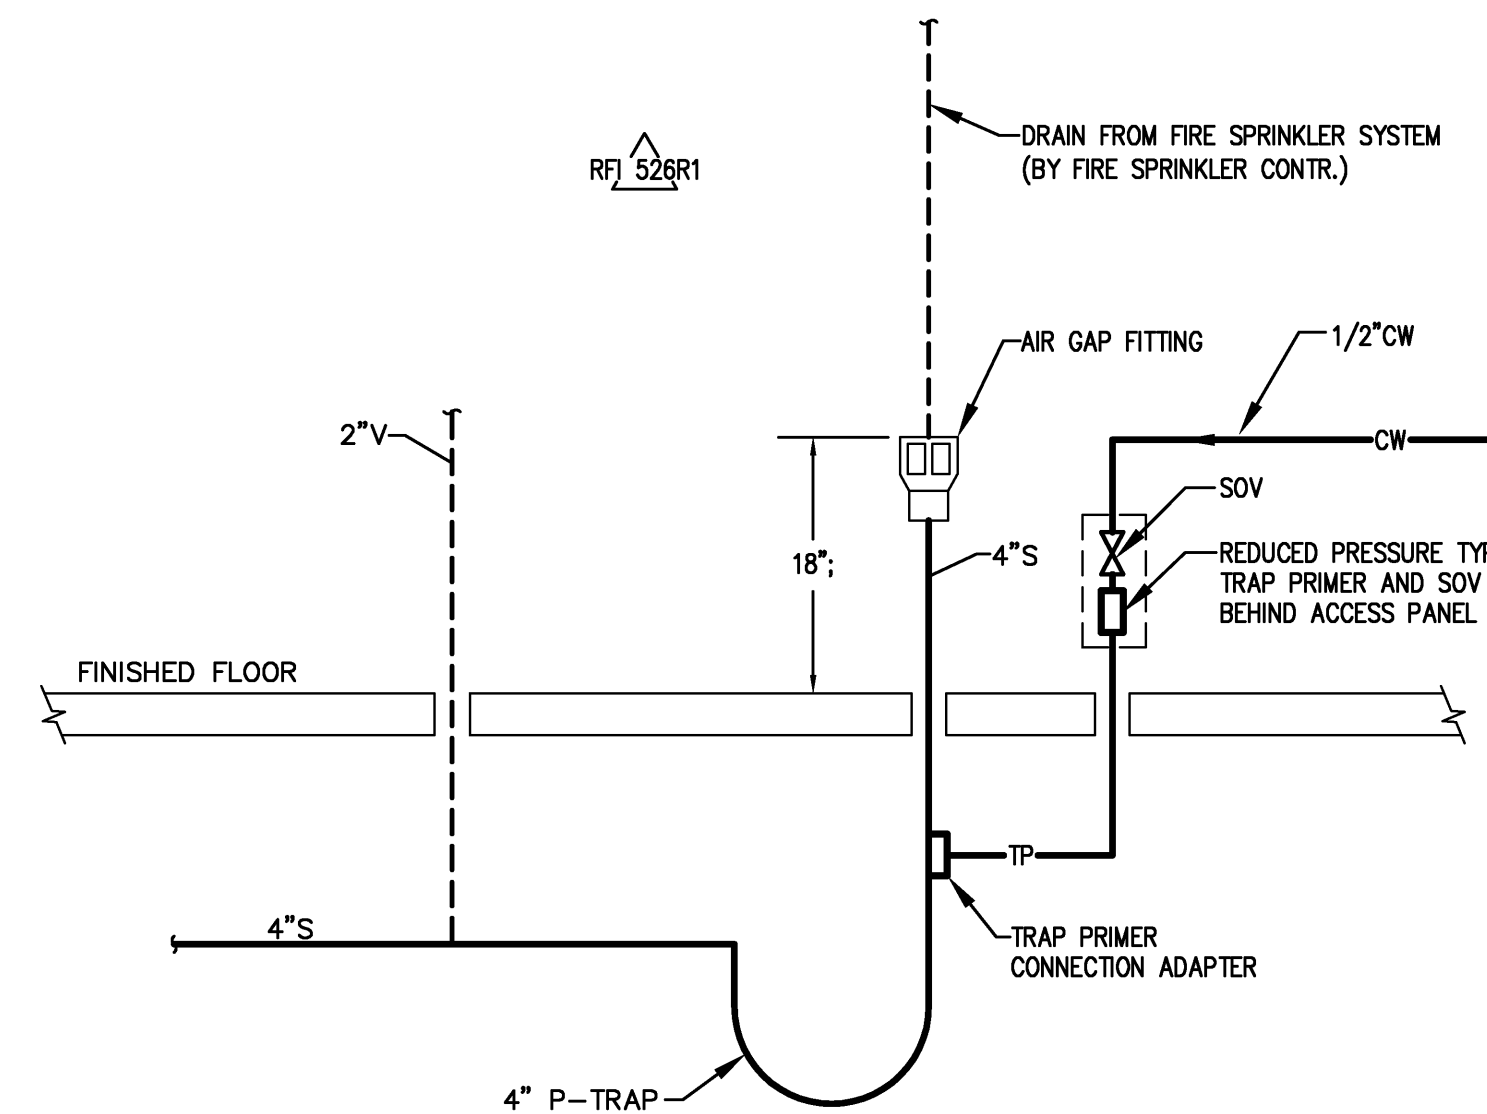

ISSUED FOR		DATE
Pre-Schematic Design		07/14/2022
Schematic Design		07/28/2022
BID PK #1		10/06/2022
50% Progress		10/24/2022
BID PK #1 80 CD		12/01/2022
BID PK #1 100 CD		02/16/2023
BID PK #2 100 CD		03/26/2023
100% CD		05/08/2023
CD 4		01/07/2024
COB 1	▲	02/28/2024
COB 2	▲	02/28/2024
CD 4		04/11/2025
RW PERMIT		05/05/2025
ASI#000 R1	▲	07/10/2022
ASI#005	▲	07/08/2022
ASI#006	▲	07/08/2022
ASI#009	▲	07/12/2022
ASI#009R2	▲	07/19/2022
ASI#010	▲	08/13/2022
ASI#011	▲	08/27/2022
ASI#020	▲	09/20/2022
ASI#021	▲	11/05/2022
ASI#018	▲	11/17/2022
ASI#026	▲	12/15/2022

2880 TORREY PINES SCENIC DRIVE
LA JOLLA, CALIFORNIA 92037

WORK ORDER NO. 431587

CONSULTANT

 **Xanth**

Xanth Inc./ San Diego - North
5870 Oberlin Dr.
San Diego, CA 92121
858.597.0535 / fax 858.597.0565

Xanth 0008184

Frankford/Phelps Consortium LLC
655 West Broadway, Suite 1450 San Diego, CA 92101
619-702-5655 619-702-1655 Fax

ANTRESS | ARCHITECTS
451 Broadway, Denver, CO 80203
303.732.1000

STAMP

RECEIVED PROSECUTOR
JUL 10 1980
MEON 422265
EX-10-10-11
REGISTRY/CAL
STATE OF CALIFORNIA

CHECK NAME

SHEET NAME PLUMBING DETAILS
DRAWN BY: Author
PROJECT #: 200725.000
SHEET NUMBER

P5003

11/22/2008 4:52:10 PM
 34 user 12/1/2008 4:20 PM
 at 12/01/2008 12:01:00 PM

Warning: It is a violation of the law for any person, unless acting under the direction of a licensed architect, to alter an item in any way. If an item in this document is altered, the altering architect, if other than the architect of record, shall affix to the item his seal and the notation "altered by" followed by his signature and the date of such alteration, and the specific description of the alteration.