



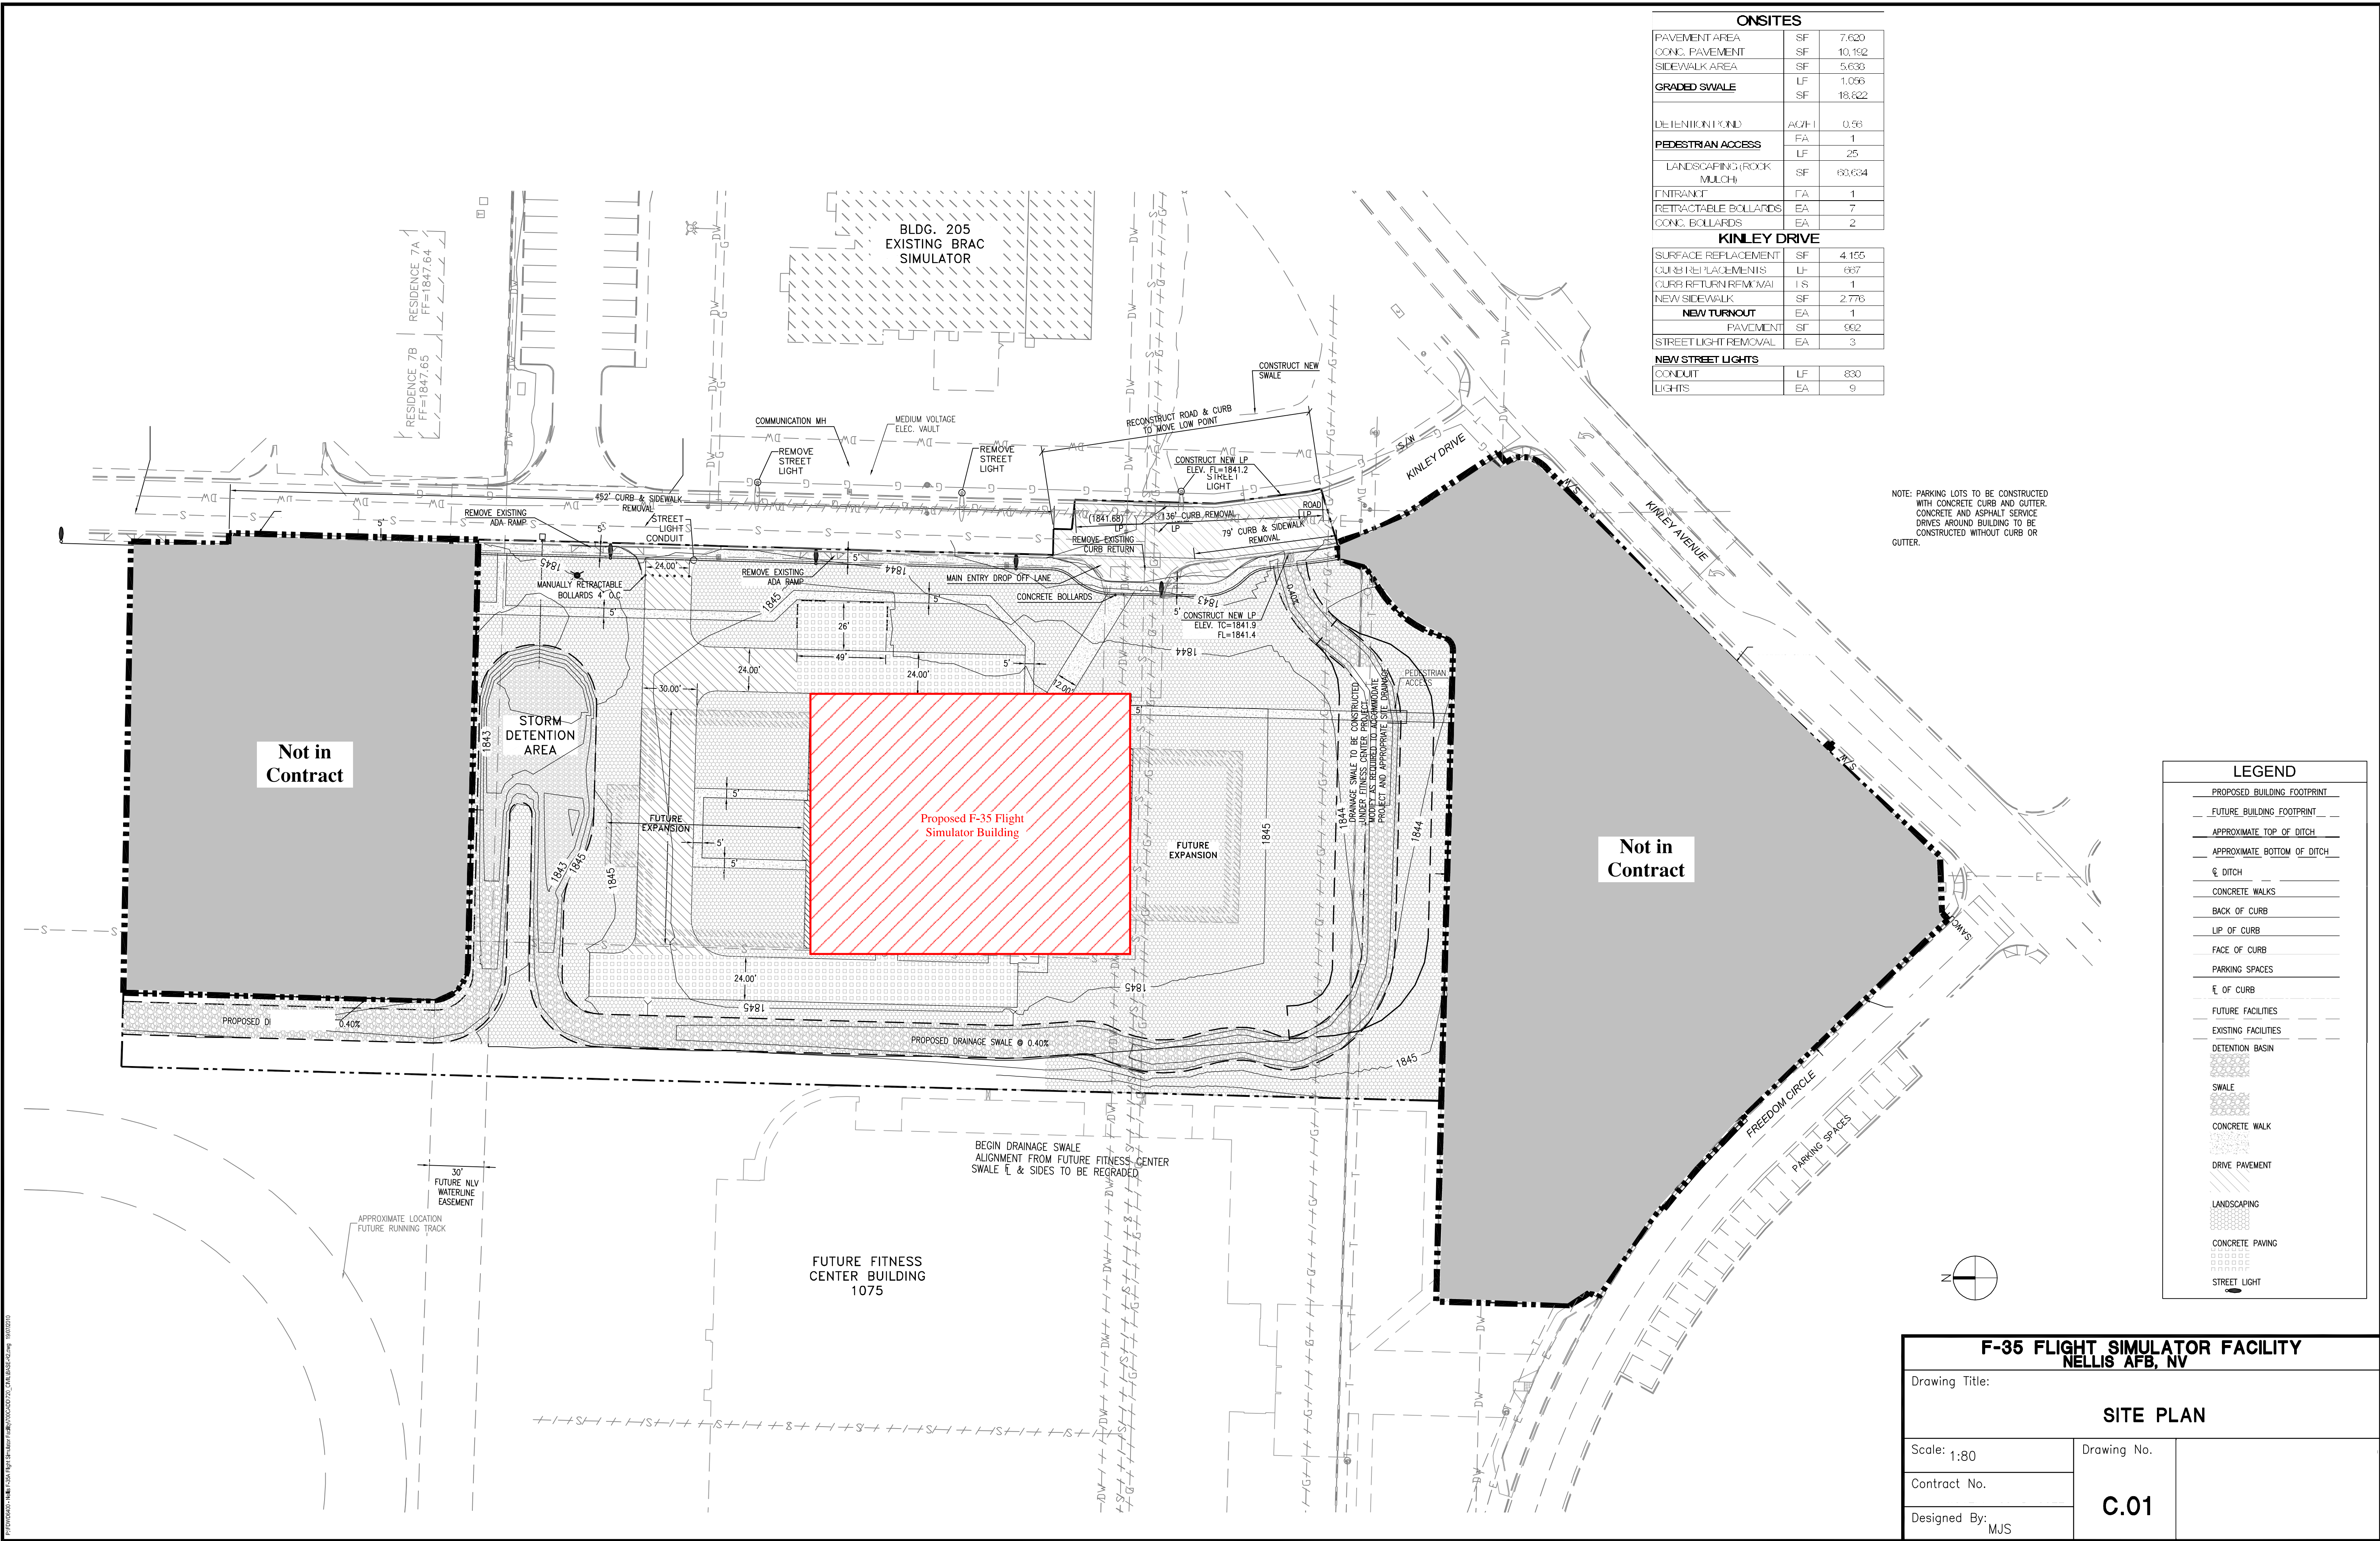

NOT FOR CONSTRUCTION

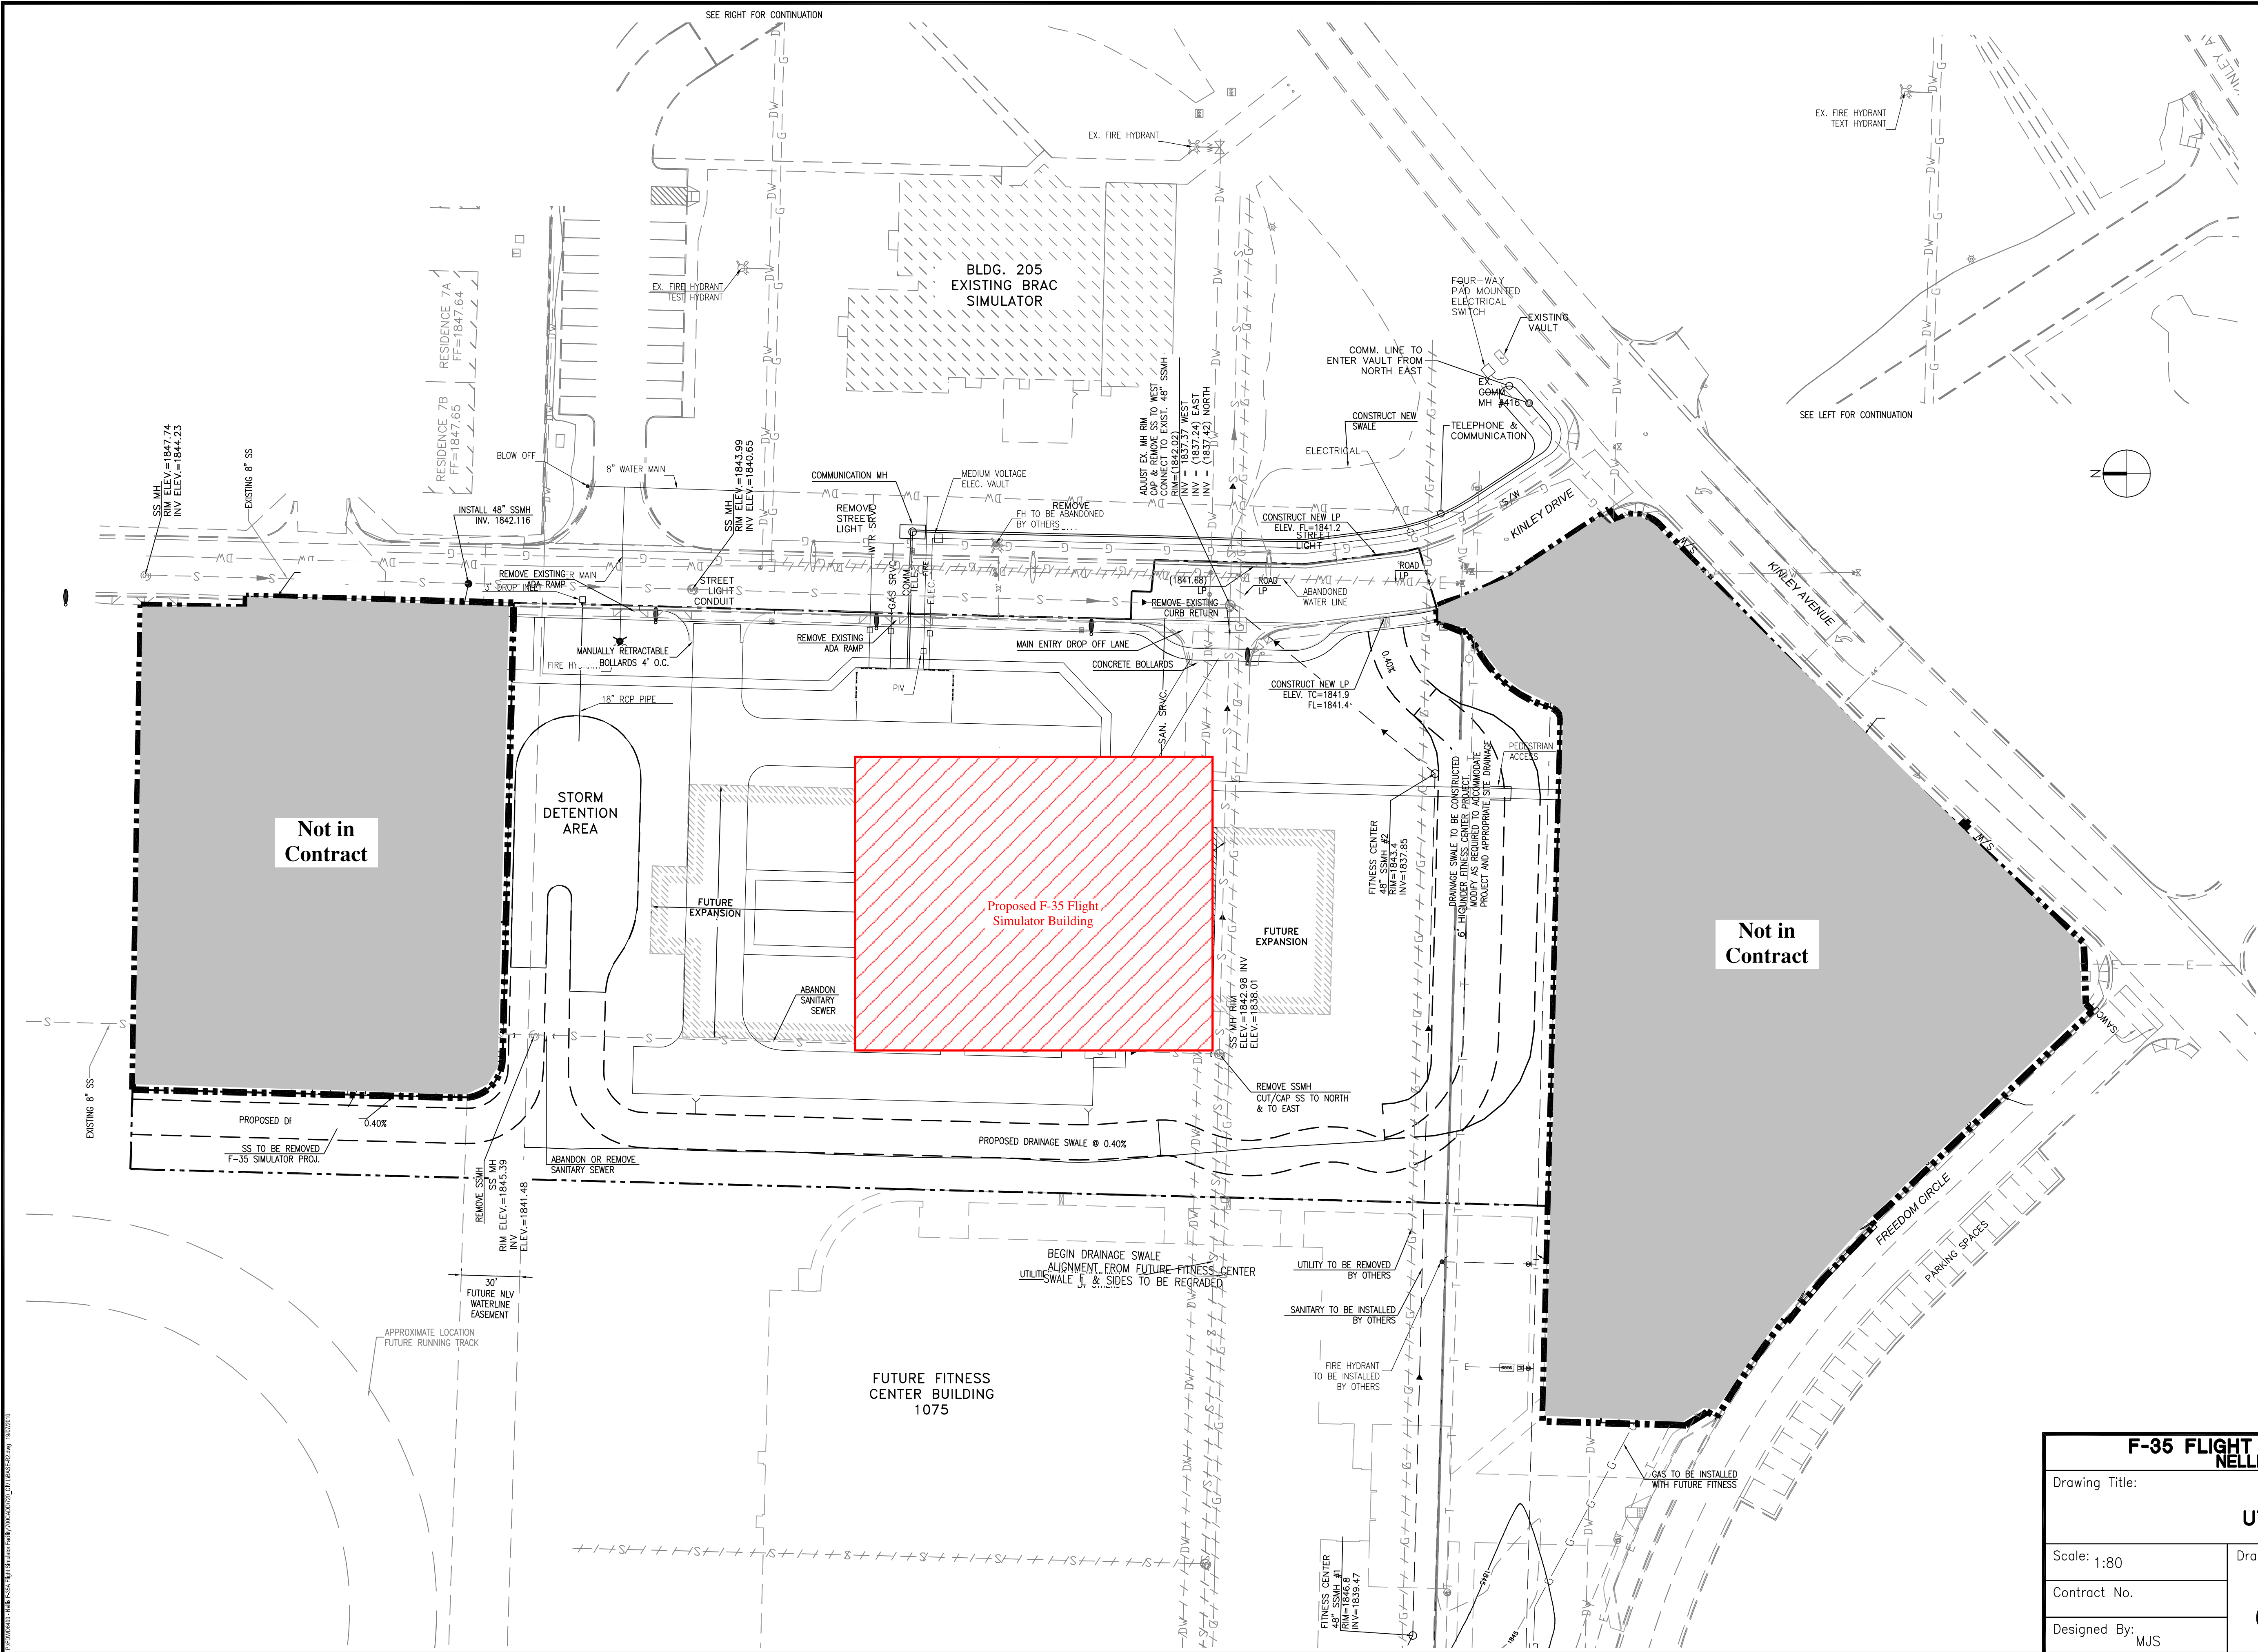

UTILITIES			
ELECTRIC			
CONDUIT	LF	457	
METER	EA	1	
VAULT	EA	1	
FOURWAY SWITCH	EA	1	
COMMUNICATION			
CONDUIT	LF	432	
METER	EA	1	
MANHOLE	EA	1	
GAS			
SERVICE LATERAL	LF	63	
METER	EA	1	
WATER			
FIRE SERVICE	LF	88	
P.V.	EA	1	
SERVICE LATERAL	LF	88	
METER	EA	1	
FIRE HYDRANT	EA	1	
BLOW OFF	EA	1	
WATER MAIN 8"	LF	163	
SANITARY			
SEWER MAIN	LF	234	
SEWER MANHOLE	EA	2	
SERVICE LATERAL	LF	114	
SEWER REMOVOL	LF	40	
MANHOLE REMOVOL	EA	2	
TELEPHONE			
CONDUIT	LF	432	
STORM SEWER			
3' DROP INLET	EA	1	
18" RCP PIPE	LF	71	

LEGEND	
PROPOSED BUILDING FOOTPRINT	
FUTURE BUILDING FOOTPRINT	
COMMUNICATION LINE	
ELECTRICAL LINE	
TELEPHONE LINE	
STREET LIGHT LINE	
APPROXIMATE TOP OF DITCH	
SANITARY SEWER	
FUT. FITNESS CTR 10" SAN. SWR	
WATER	
FUT. FITNESS CENTER WTR	
GAS	
FUT. FITNESS CENTER GAS MAIN	
CONCRETE WALKS	
BACK OF CURB	
LIP OF CURB	
FACE OF CURB	
PARKING SPACES	
E OF CURB	
FUTURE FACILITIES	
EXISTING FACILITIES	
EXISTING WATER	
EXISTING TELEPHONE	
EXISTING ELECTRICAL	
EXISTING SANITARY SEWER	
EXISTING GAS	
METER (SEE SPECIFIC UTILITY)	

F-35 FLIGHT SIMULATOR FACILITY NELLIS AFB, NV		
Drawing Title:		
UTILITY PLAN		
Scale: 1:80	Drawing No. C.02	
Contract No.		
Designed By: MJS		

NOT FOR CONSTRUCTION

