


ISSUE	DATE	DESCRIPTION
	09-06-00	DESIGN DEVELOPMENT
	10-13-00	PROGRESS SET
	11-10-00	PROGRESS SET
	12-20-00	BUDG. DEPT. ISSUE
	02-02-01	PROGRESS SET
	02-28-01	BUDG. DEPARTMENT RE-USE
	02-05-01	BUDG. DEPARTMENT RE-USE
	04-15-01	BID SET ISSUE
	06-29-01	BID SET ISSUE
	07-29-01	FINAL BID SET ISSUE
	10-05-01	OMAX SET
PROJECT:	8885	
DATE:	08-12-01	
DRAWN:	FR	CHECKED: MB

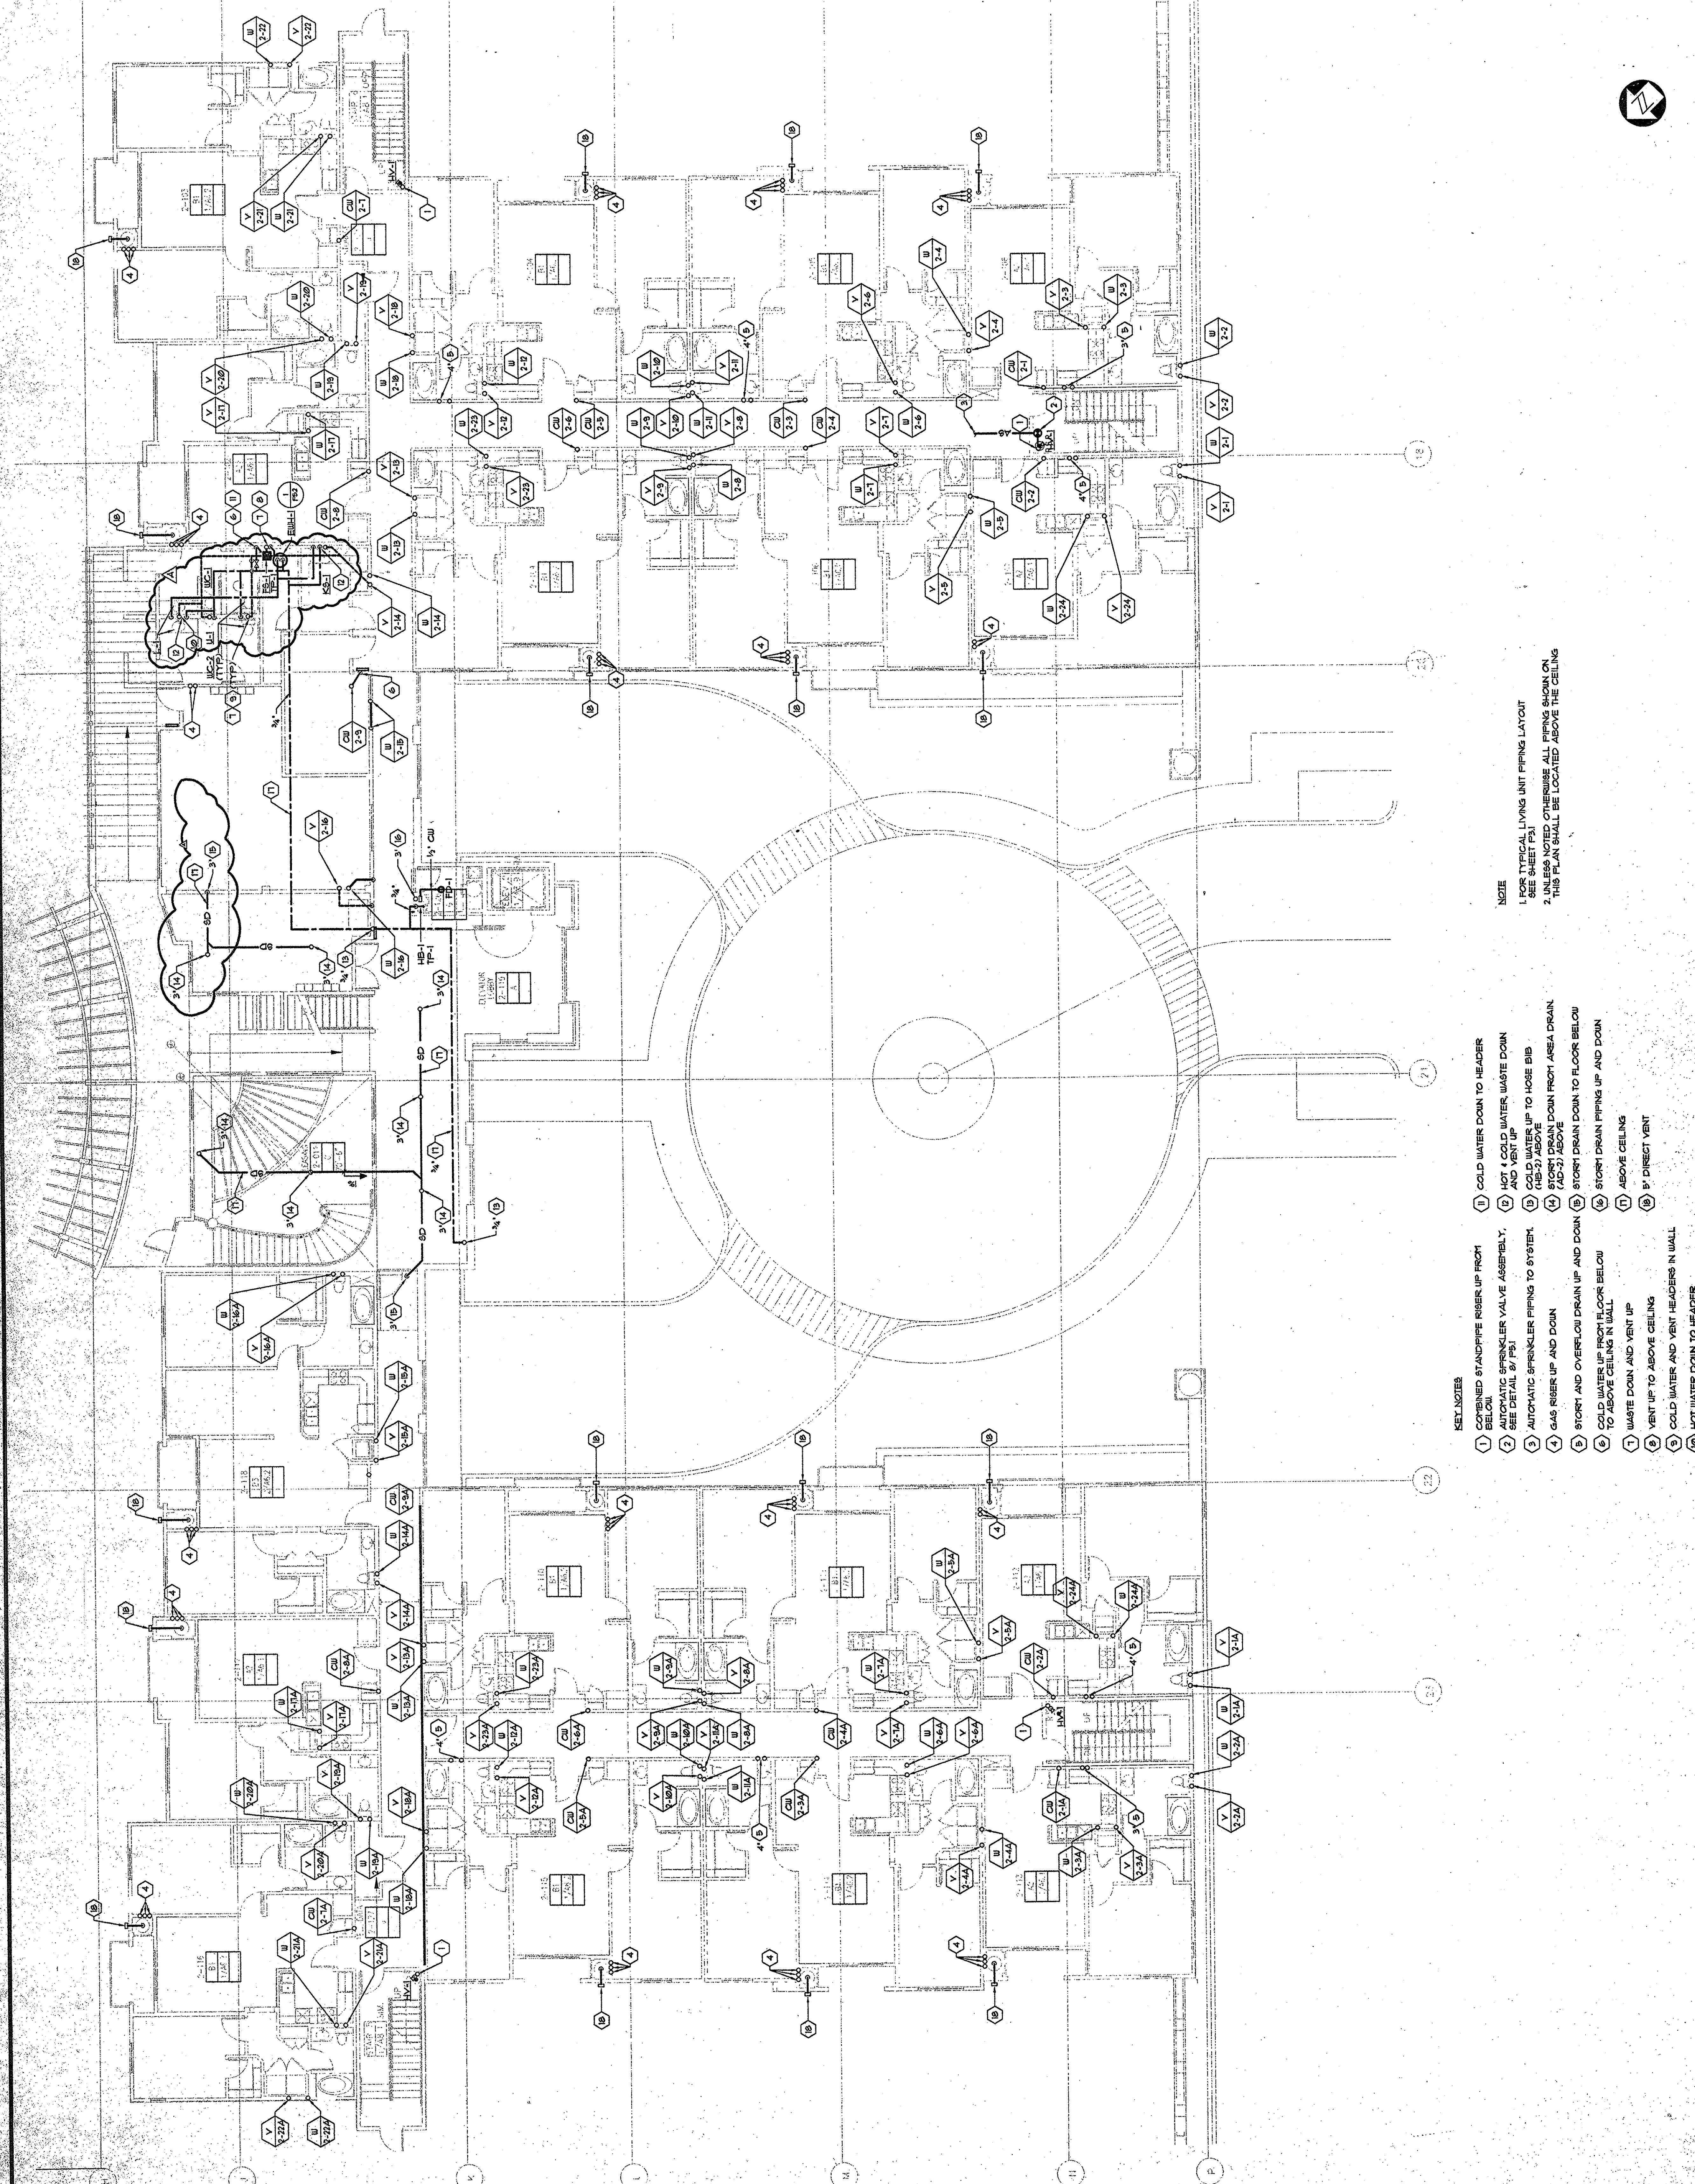

- KEY NOTES
- 1. COMPRESSED STANDOFF RISER UP FROM BELOW
 - 2. AUTOMATIC SPRINKLER VALVE ASSEMBLY, SEE DETAIL 81 P2.1
 - 3. AUTOMATIC SPRINKLER PIPING TO SYSTEM
 - 4. GAS RISER UP AND DOWN
 - 5. STORY AND OVERFLOW DRAIN UP AND DOWN
 - 6. COLD WATER UP FROM FLOOR BELOW TO ABOVE CEILING IN WALL
 - 7. WASTE DOWN AND VENT UP
 - 8. VENT UP TO ABOVE CEILING
 - 9. COLD WATER AND VENT HEADERS IN WALL
 - 10. HOT WATER DOWN TO HEADER IN WALL
 - 11. COLD WATER DOWN TO HEADER
 - 12. HOT & COLD WATER WASTE DOWN AND VENT UP TO HOSE BIB
 - 13. COLD WATER UP TO HOSE BIB
 - 14. STORY DRAIN DOWN FROM AREA DRAIN (AD-3) ABOVE
 - 15. STORY DRAIN DOWN TO FLOOR BELOW
 - 16. STORY DRAIN PIPING UP AND DOWN ABOVE CEILING
 - 17. 8" DIRECT VENT
- NOTE
- 1. FOR TYPICAL LIVING UNIT PIPING LAYOUT SEE SHEET P2.1
 - 2. UNLESS NOTED OTHERWISE ALL PIPING SHOWN ON THIS PLAN SHALL BE LOCATED ABOVE THE CEILING