


LIGHTING PLAN GENERAL NOTES

- 1 LIGHTING FIXTURES IN THESE AREAS WILL BE "ON" 24 HOURS A DAY, BYPASS PHOTO CELL AS REQUIRED.
- 2 POWER FOR MAGNETIC DOOR HOLDER "HIA-12"

ROOF PLAN SPECIFIC NOTES:

- 1 TYPICAL CONDENSING UNIT LOCATION AT EACH CONDENSING UNIT LOCATION PROVIDE THE FOLLOWING:
- A) UNIT SHALL BE DISCONNECT SWITCH WITH FUSES SIZED PER UNIT MANUFACTURER'S REQUIREMENTS.
- B) 1/2" CO. TO RESPECTIVE UNIT SUBPANEL.
- C) 1/2" CO. TO RESPECTIVE UNIT FAN COIL UNIT FOR CONTROL. REFER TO MECHANICAL DRAWINGS FOR SPECIFIC LOCATIONS, AS WELL AS UNIT SERVICED.
- 2 PROVIDE 1/2" CO. TO RESPECTIVE CONTROL DEVICE(S) FOR CONTROL WIRING. REFER TO THE EQUIPMENT CONTROL WIRING DIAGRAMS FOR ADDITIONAL INFORMATION.
- 3 PROVIDE 1/2" CO. AND WIRING FROM DUCT MOUNTED SMOKE DETECTOR TO HVAC SHUT DOWN CONTROL SYSTEM AND TO ANY REQUIRED MONITORING DEVICE IF ANY. CONNECT POWER SUPPLY FOR SMOKE DETECTOR AS REQUIRED. REFER TO THE SYSTEM SPECIFICATIONS FOR DEVICE REQUIREMENTS.

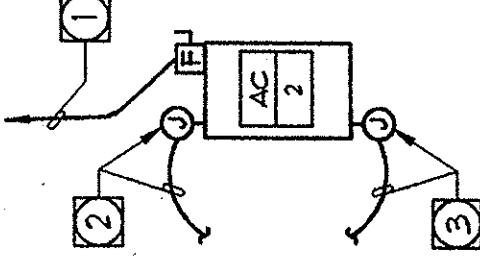


ROOF PLAN GENERAL NOTES:


- 1 ELECTRICAL CONTRACTOR SHALL REFER TO ALL SPECIFIC EQUIPMENT AND ARCHITECTURAL DRAWINGS FOR EXACT LOCATIONS AND CHARACTERISTICS OF ALL EQUIPMENT. ALL EQUIPMENT SHALL BE IDENTIFIED AND ANY ADDITIONAL WORK NECESSARY SHALL BE INCLUDED IN THE BASE BID.
- 2 ALL TEMPERATURE CONTROL AND INTERLOCK CONDUIT AND WIRING SHALL BE BY ELECTRICAL CONTRACTOR UNLESS NOTED OTHERWISE. SEE MECHANICAL/PLUMBING DRAWINGS FOR ALL INFORMATION.
- 3 ELECTRICAL CONTRACTOR SHALL VERIFY THE EXACT LOCATION OF ALL CONNECTION POINTS WITH THE EQUIPMENT INSTALLER PRIOR TO ROUGH-IN.
- 4 ELECTRICAL CONTRACTOR SHALL PROVIDE LOCAL REPORT DISCONNECTING MEANS FOR ALL ELECTRIC HEATING EQUIPMENT IF REQUIRED BY THE LOCAL ELECTRICAL CODE.
- 5 ELECTRICAL CONTRACTOR SHALL COORDINATE THE ROUTING OF POWER WIRING TO ROOF MOUNTED EQUIPMENT WITH MECHANICAL FIRE CURB ASSEMBLY. NO SEPARATE ROOF PENETRATIONS WILL BE PERMITTED. ALL WIRING SHALL BE BELOW THE ROOF IN AN ACCESSIBLE CEILING SPACE LOCATION.
- 6 ALL ROOF MOUNTED EQUIPMENT SHALL BE NEMA 3R RATED.

PLAYA DEL REY
8700 PERSHING DRIVE
PLAYA DEL REY, CALIFORNIA 90293

ARCHSTONE COMMUNITIES
217 Technology Drive, Second Floor
Irvine, California 92618

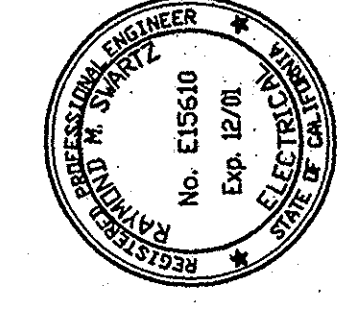


K1
KONSORTIUM 1
17001 Skyway, Suite 200, Irvine, CA 92614
(949) 261-4422 Fax: (949) 261-4400
E: K1@KONSORTIUM1.COM

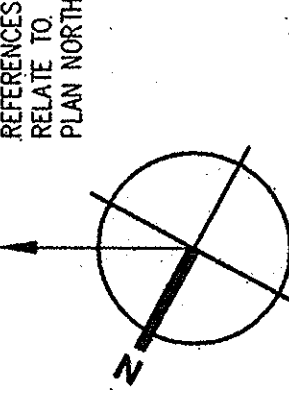

NOTE: ALL
DIRECTIONAL
DIMENSIONS
RELATE TO
PLAN NORTH.

KEY PLAN

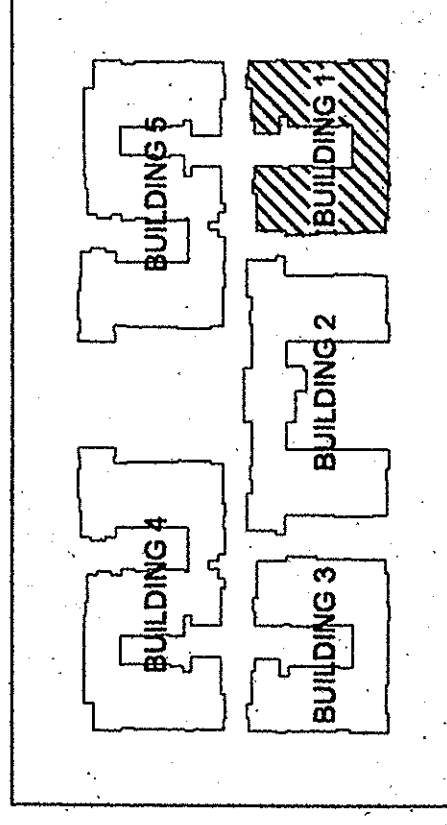

SCALE: 1/8" = 1' - 0"

ISSUE	DATE	DESCRIPTION
	09.06.00	DESIGN DEVELOPMENT
	10.17.00	PROGRESS SET
	11.10.00	BUILDING DEPT. SUBMITTAL
	04.18.01	REVIEW SET
	07.20.01	BID SET
	10.05.01	OMAX SET

PROJECT: 9885	CHECKED:
DRAWN:	
BUILDING 1 THIRD LEVEL ELECTRICAL PLAN	

E52