


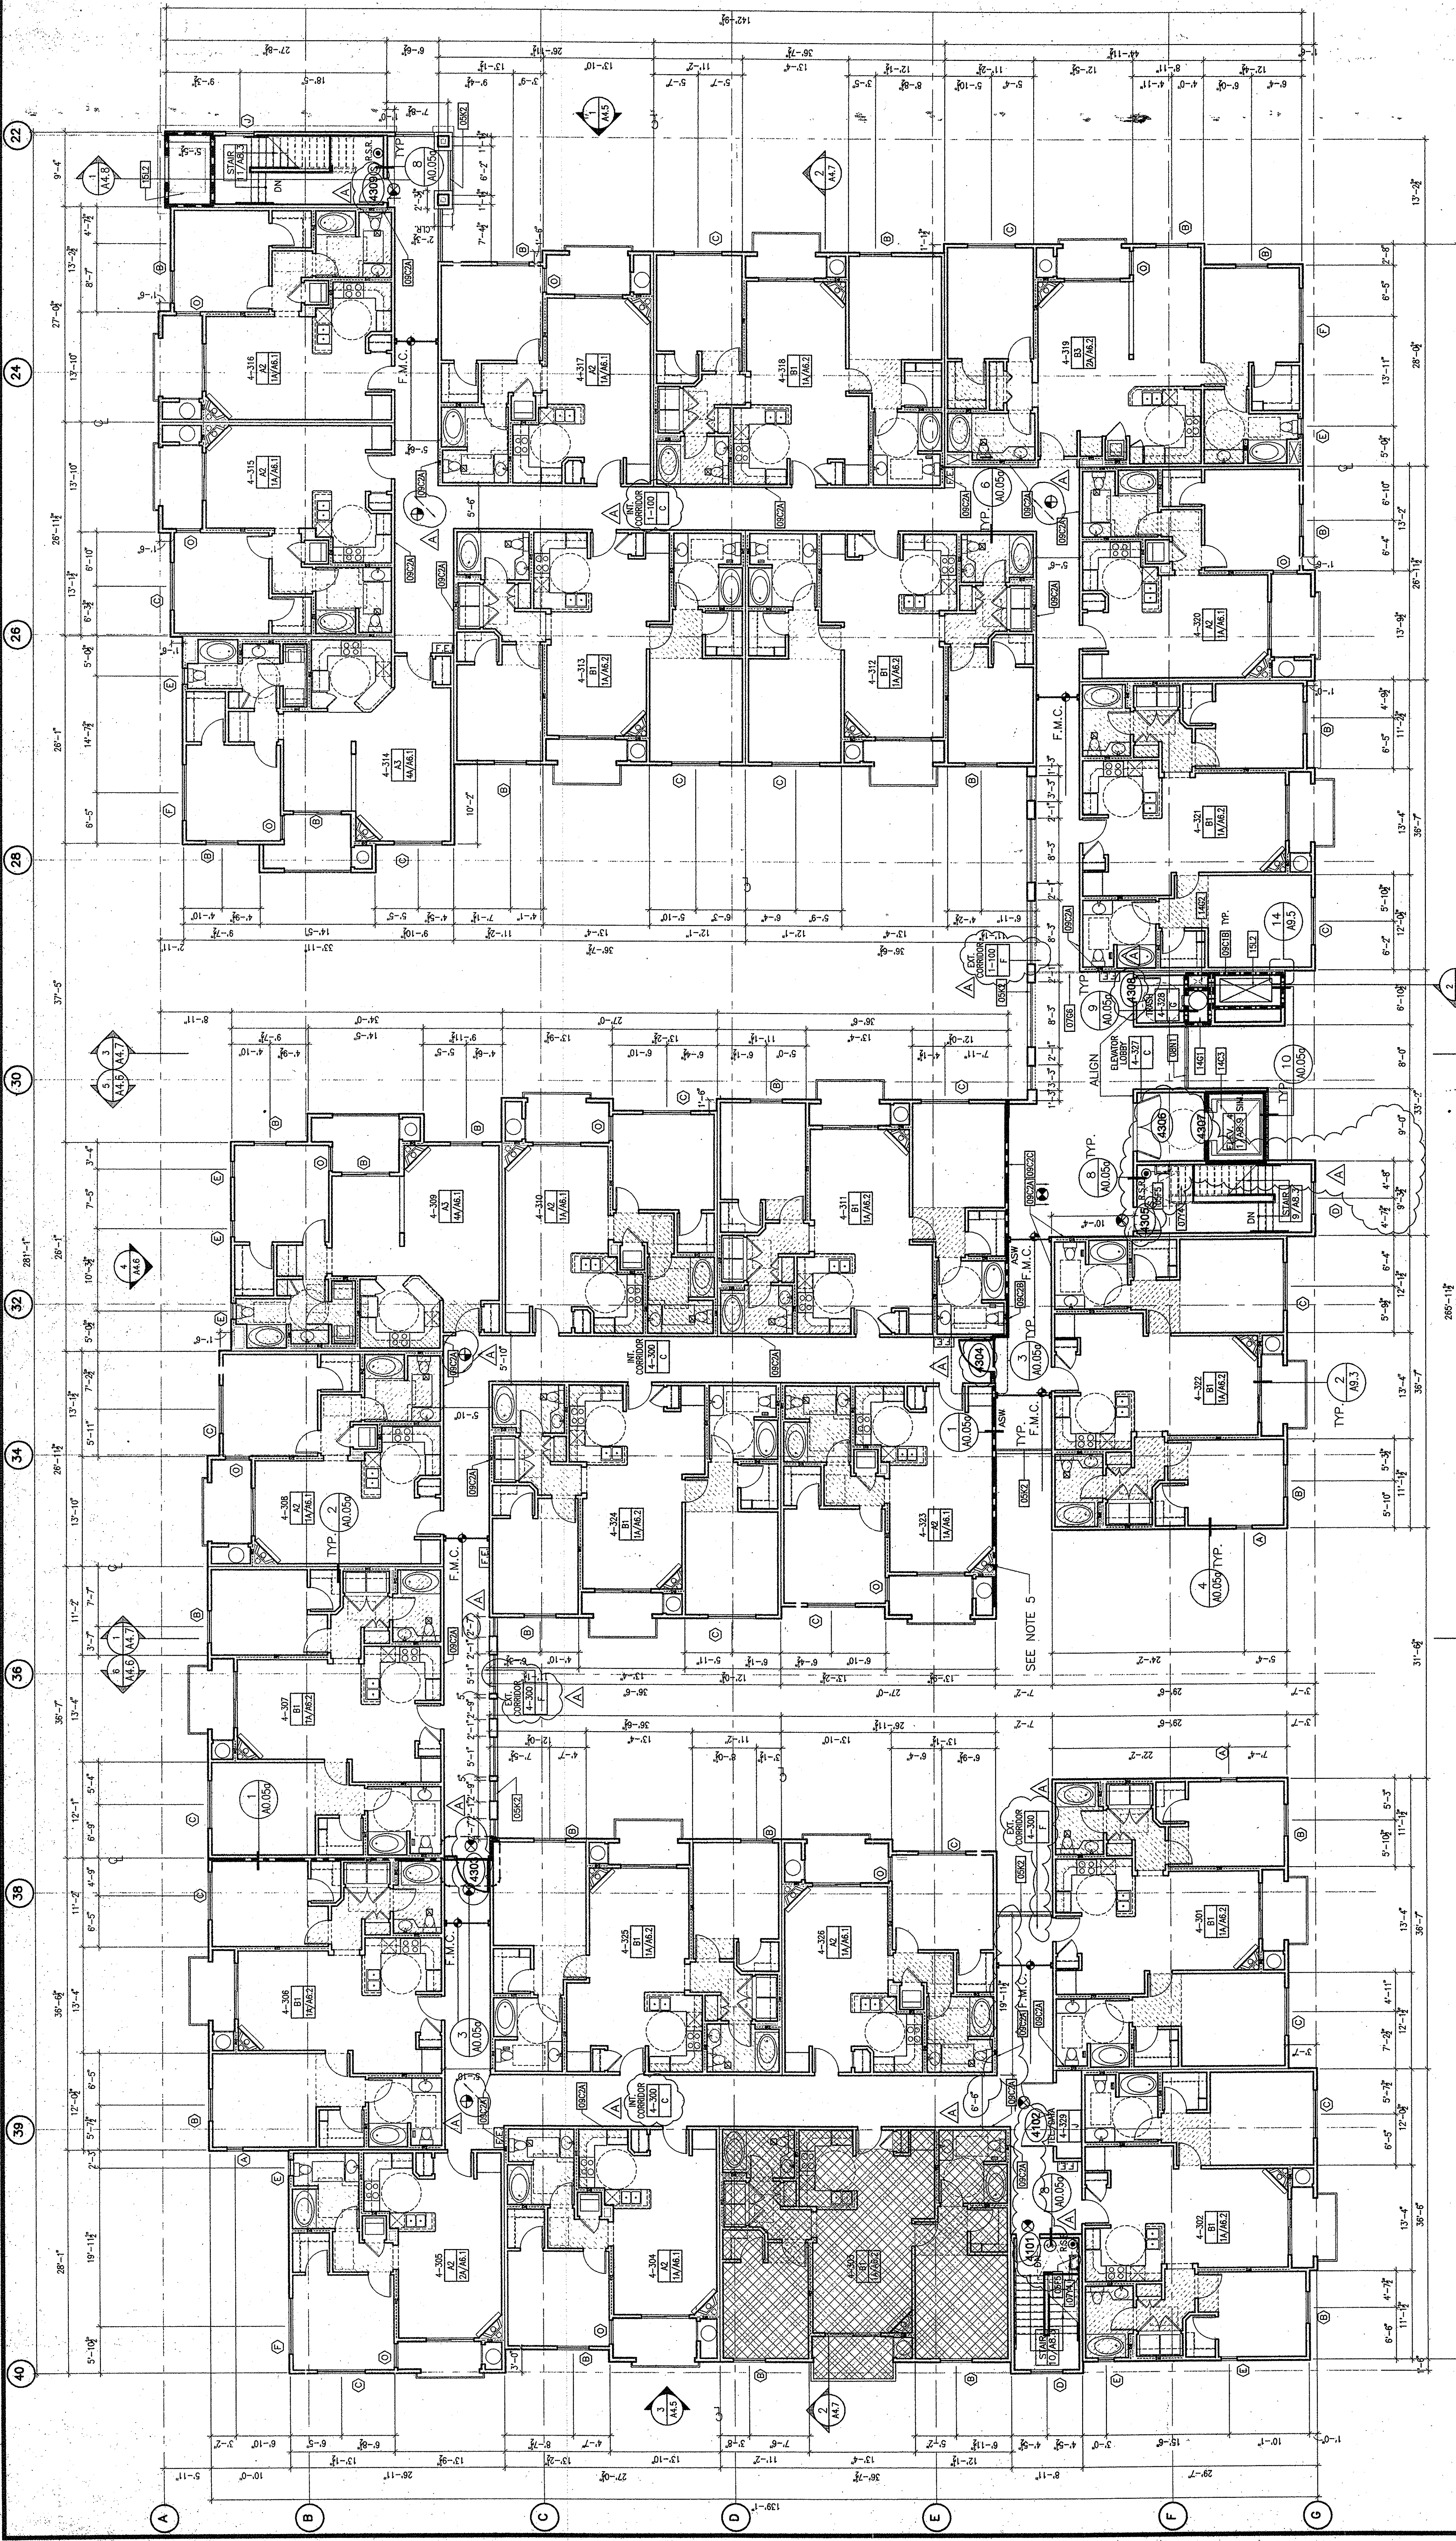


PLAYA DEL REY
8700 PERSHING DRIVE
PLAYA DEL REY, CALIFORNIA 90293

ARCHSTONE COMMUNITIES
217 Technology Drive, Second Floor
Irvine, California 92618

VAN TILBURG, BANYARD & SODERBERGH, AIA
ARCHITECTURE PLANNING INTERIORS
SUITE 170, 1960 BLAKE STREET
DUBLIN, CA 94568
TEL 303.676.0041 FAX 303.676.0042
PERMITS: 225 ARIZONA AVENUE
SANTA MONICA, CA 90401
TEL 303.942.0273 FAX 303.942.0264

A4.3

BUILDING FOUR - THIRD FLOOR PLAN
SCALE: 1/8"=1'-0"

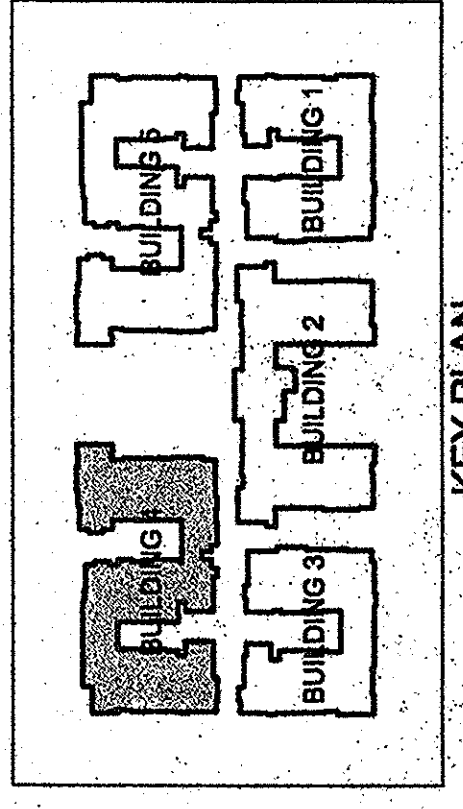

- PLAN NOTES**
1. SEE UNIT PLANS FOR TYPICAL INTERIOR AND BALCONY DIMENSIONS.
 2. SHADED AREA DENOTES HANDICAP ADAPTABLE UNITS. PROVIDE TWO 15" BREADBOARDS AT ALL UNIT KITCHENS WITH REPOSITIONABLE COUNTERTOPS.
 3. ALL THIRD FLOOR UNITS TO HAVE GAS FIREPLACE APPLIANCES. SEE MECHANICAL, PLUMBING AND ELECTRICAL PLANS FOR ADDITIONAL INFORMATION.
 4. INDICATED PLUMBING PARTITIONS OCCUR BETWEEN PERPENDICULAR FRAMED WALLS WHICH DEFINE EACH WALL LENGTH.
 5. SEE DETAIL 3A / A6.1 FOR VENT CONDITION THIS LOCATION

DRAWING KEYNOTE LEGEND	
05K2	ORNAMENTAL METAL RAILING - 3/A9.7
07G6	SEISMIC JOINT (4") - 5/A9.4, 14/A9.5, 67/A9.8
07Y4	ROOF HATCH 8/A9.4
08N1	ALUMINUM STOREFRONT SYSTEM-2.3.4/A0.08
09C2A	PLUMBING PARTITION - 1A/A0.05A
09C2B	PLUMBING PARTITION - 1B/A0.05A
09C2C	AREA SEPARATION WALL (TWO HOUR) - 1/A0.05A
14C3	HYDRAULIC ELEVATOR - 3500 LBS. - 1.2.4/A6.9
14C1	TRASH CHUTE W/LOCKING TRAP DOOR AT BOTTOM
14C2	TRASH CHUTE VENT
15L2	GARAGE VENTILATION SYSTEM DUCTWORK