


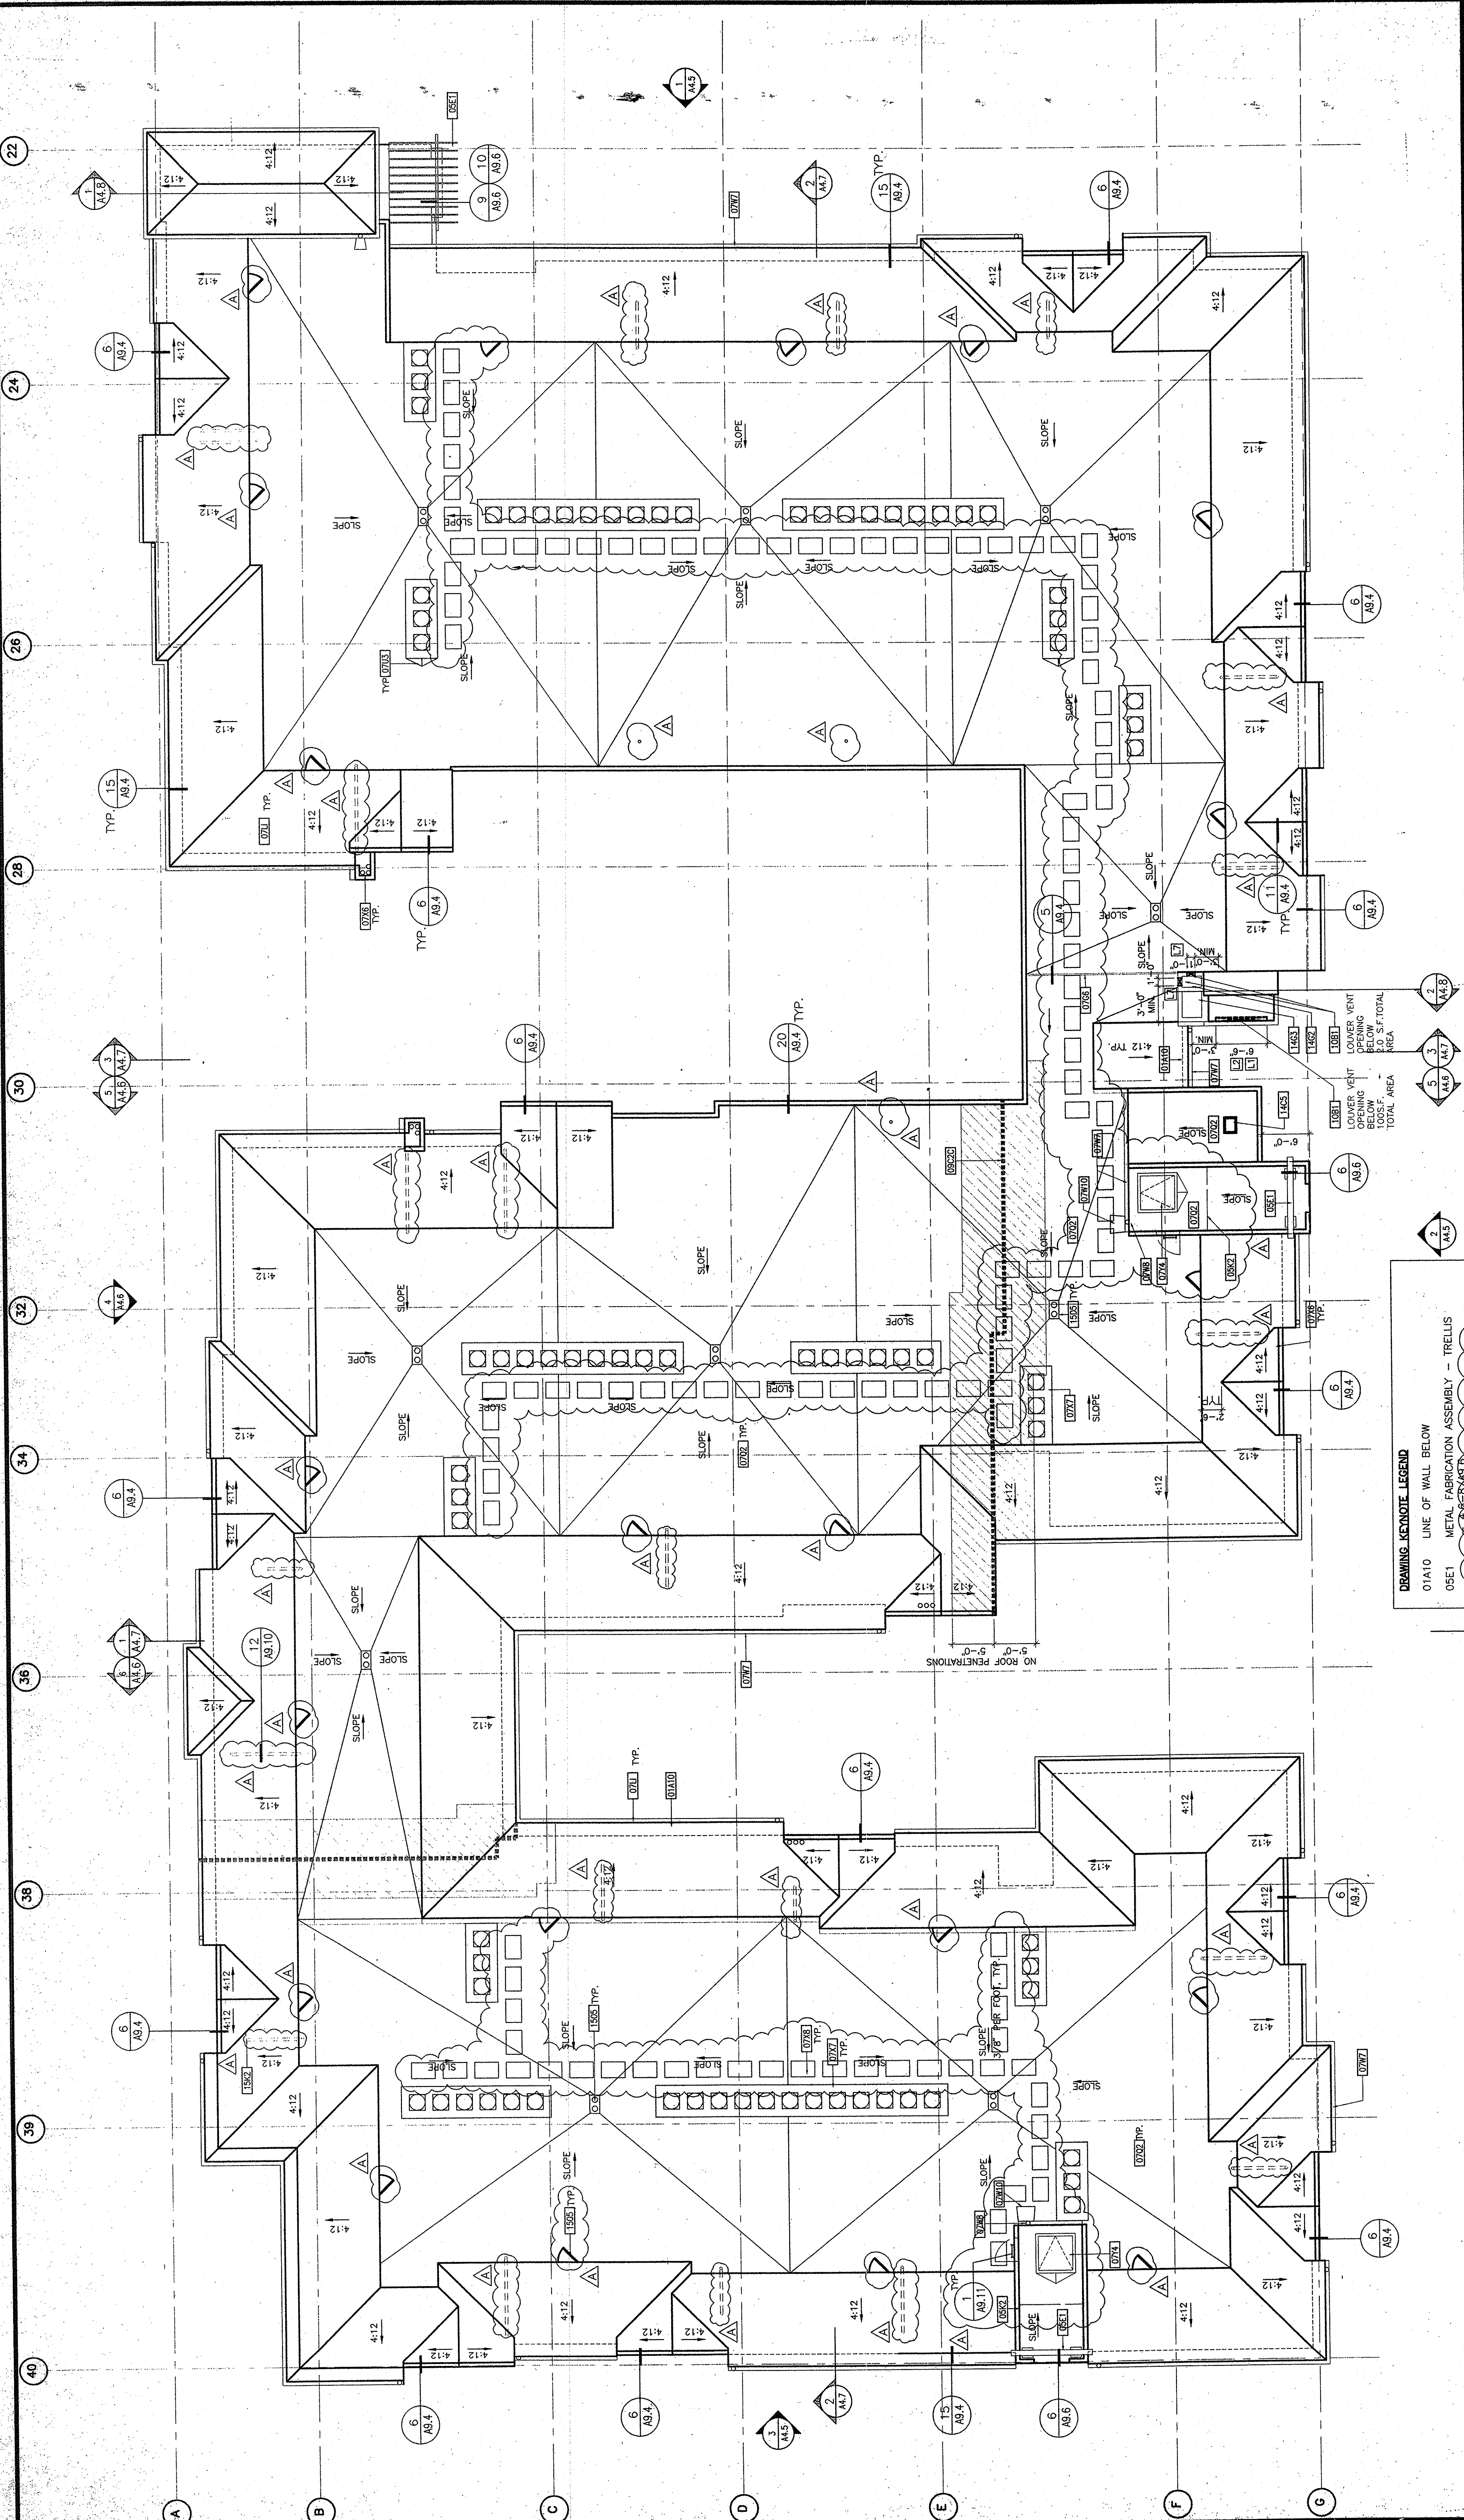

PROJECT: 8885

CHECKED:

DRAWN:

ROOF PLAN

ARCHSTONE COMMUNITIES

217 Technology Drive, Second Floor

Irvine, California 92618

PLAYA DEL REY

8700 PERSHING DRIVE

PLAYA DEL REY, CALIFORNIA 90293

06.00.00

DESIGN DEVELOPMENT

10.07.00

PROGRESS SET

11.00.00

BUILDING DEPT. SUBMITTAL

03.02.01

PROGRESS SET

04.18.01

REVIEW SET

05.28.01

REVIEW SET

07.20.01

REDACT

10.05.01

FINAL SET

SUITE 170, 1800 BLUE STREET

SANTA MONICA, CA 90401

TEL 310.376.0341 FAX 310.376.0352

PENTHOUSE, 225 ARDORA AVENUE

SANTA MONICA, CA 90401

TEL 310.394.0270 FAX 310.394.2424

VAN TILBURG, BANVARD & SODERBERGH, AIA

ARCHITECTURE PLANNING INTERIORS

DRAWING KEYNOTE LEGEND

01A10 LINE OF WALL BELOW

05E1 METAL FABRICATION ASSEMBLY - TRELLIS

05K2 ORNAMENTAL METAL RAIL - 3/ A9.7

07G6 SEISMIC JOINT (4") - 5/A9.4, 14/A9.5

07L1 CONCRETE ROOF FLEEC

07L2 CRICKET ROOF SYSTEM

07U3 CRICKET ASSEMBLY

07X6 ROOF VENT / DUCT PENETRATION

07W7 GUTTER - 1, 15 / A9.4

07W8 DOWNSPOUT LEADER

07W10 SPLASH PAN - 4/A9.4

07X2 ROOF SURFACE WALK PAD

07Y4 ROOF RATCH - 87/A9.4

08E1 30" (W) x 44" (H) MANSARD ACCESS HATCH

09C2C AREA SEPARATION WALL-(TWO) HOUR

10B1 LOUVER VENT-18.17/A9.1

14G2 TRASH CHUTE VENT

14G3 TRASH CHUTE TERMINATION (6'-2" AFF @ P1/ 4'-0" ABOVE ROOF - 7/A9.4

14C5 ELEVATOR SHAFT VENT-500 SQM. PER NIEC.

1505 ROOF DRAIN AND OVERFLOW - 17/A9.4

1

BUILDING FOUR - ROOF PLAN

SCALE: 1/8"=1'-0"

KEY PLAN

Building 1

Building 2

Building 3

NOTE: ALL REFERENCES RELATE TO PLAN NORTH.

A4.4