


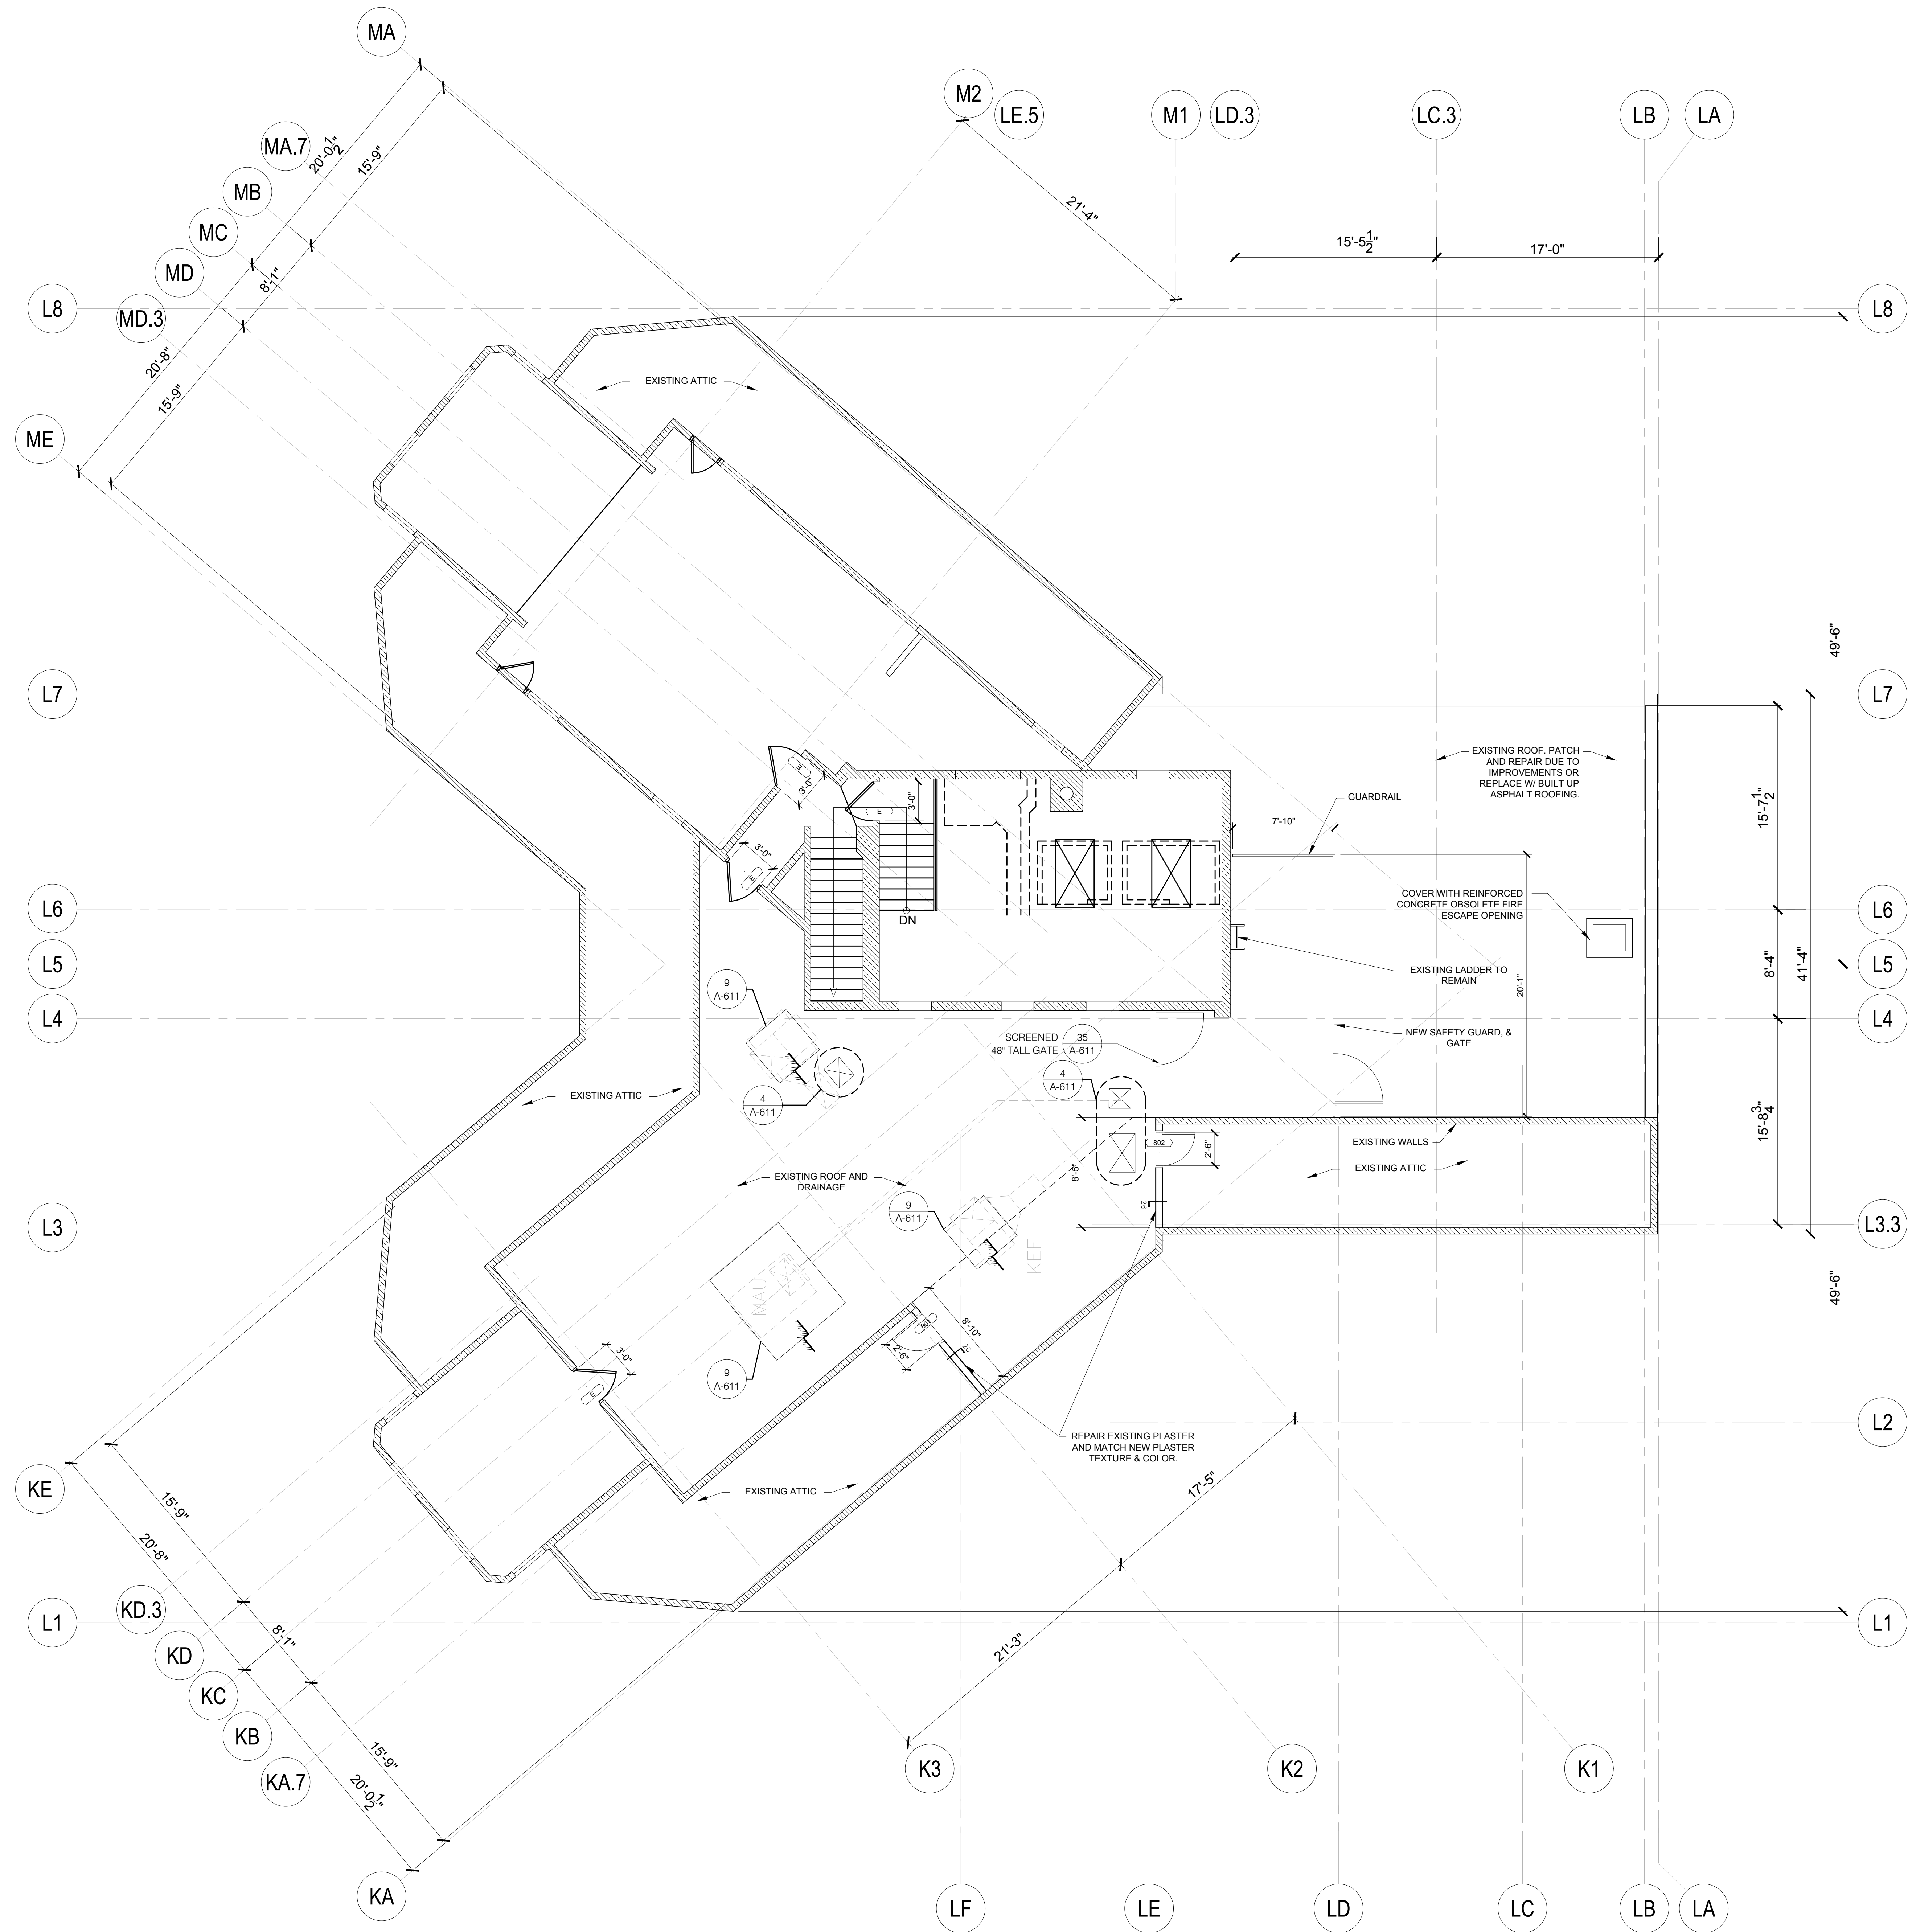

ENLARGED 7TH FLOOR MECHANICAL PLAN - LANDMARK BUILDING

3/16" = 1'-0"

REVISIONS	DATE	DESCRIPTION
	05/07/2013	MECHAN 02
	08/04/2013	MECHAN 03
	10/29/2013	MECHAN 04
	05/27/2016	MECHAN 05
hla		
howard laks architects		
1545 twelfth street, santa monica, ca 90401		
voice : 310-393-4465 fax : 310-393-2230		
CONSULTANTS		
710 WILSHIRE BOULEVARD MIXED-USE HOTEL PROJECT SANTA MONICA - CALIFORNIA 90401		
ENLARGED ATTIC PLANS		
DRAWN	SPH	
CHECKED	HLA	
APPROVED		
SCALE	NTS	
SHEET		
A-613		
DATE	June 25, 2013	
PROJECT NUMBER	HLA 0000000-00000	