


P:\2010\110229 710 Wilshire Hotel\DWG\SHEET\110229 C-141 GR.dwg May 26, 2016 - 3:07pm

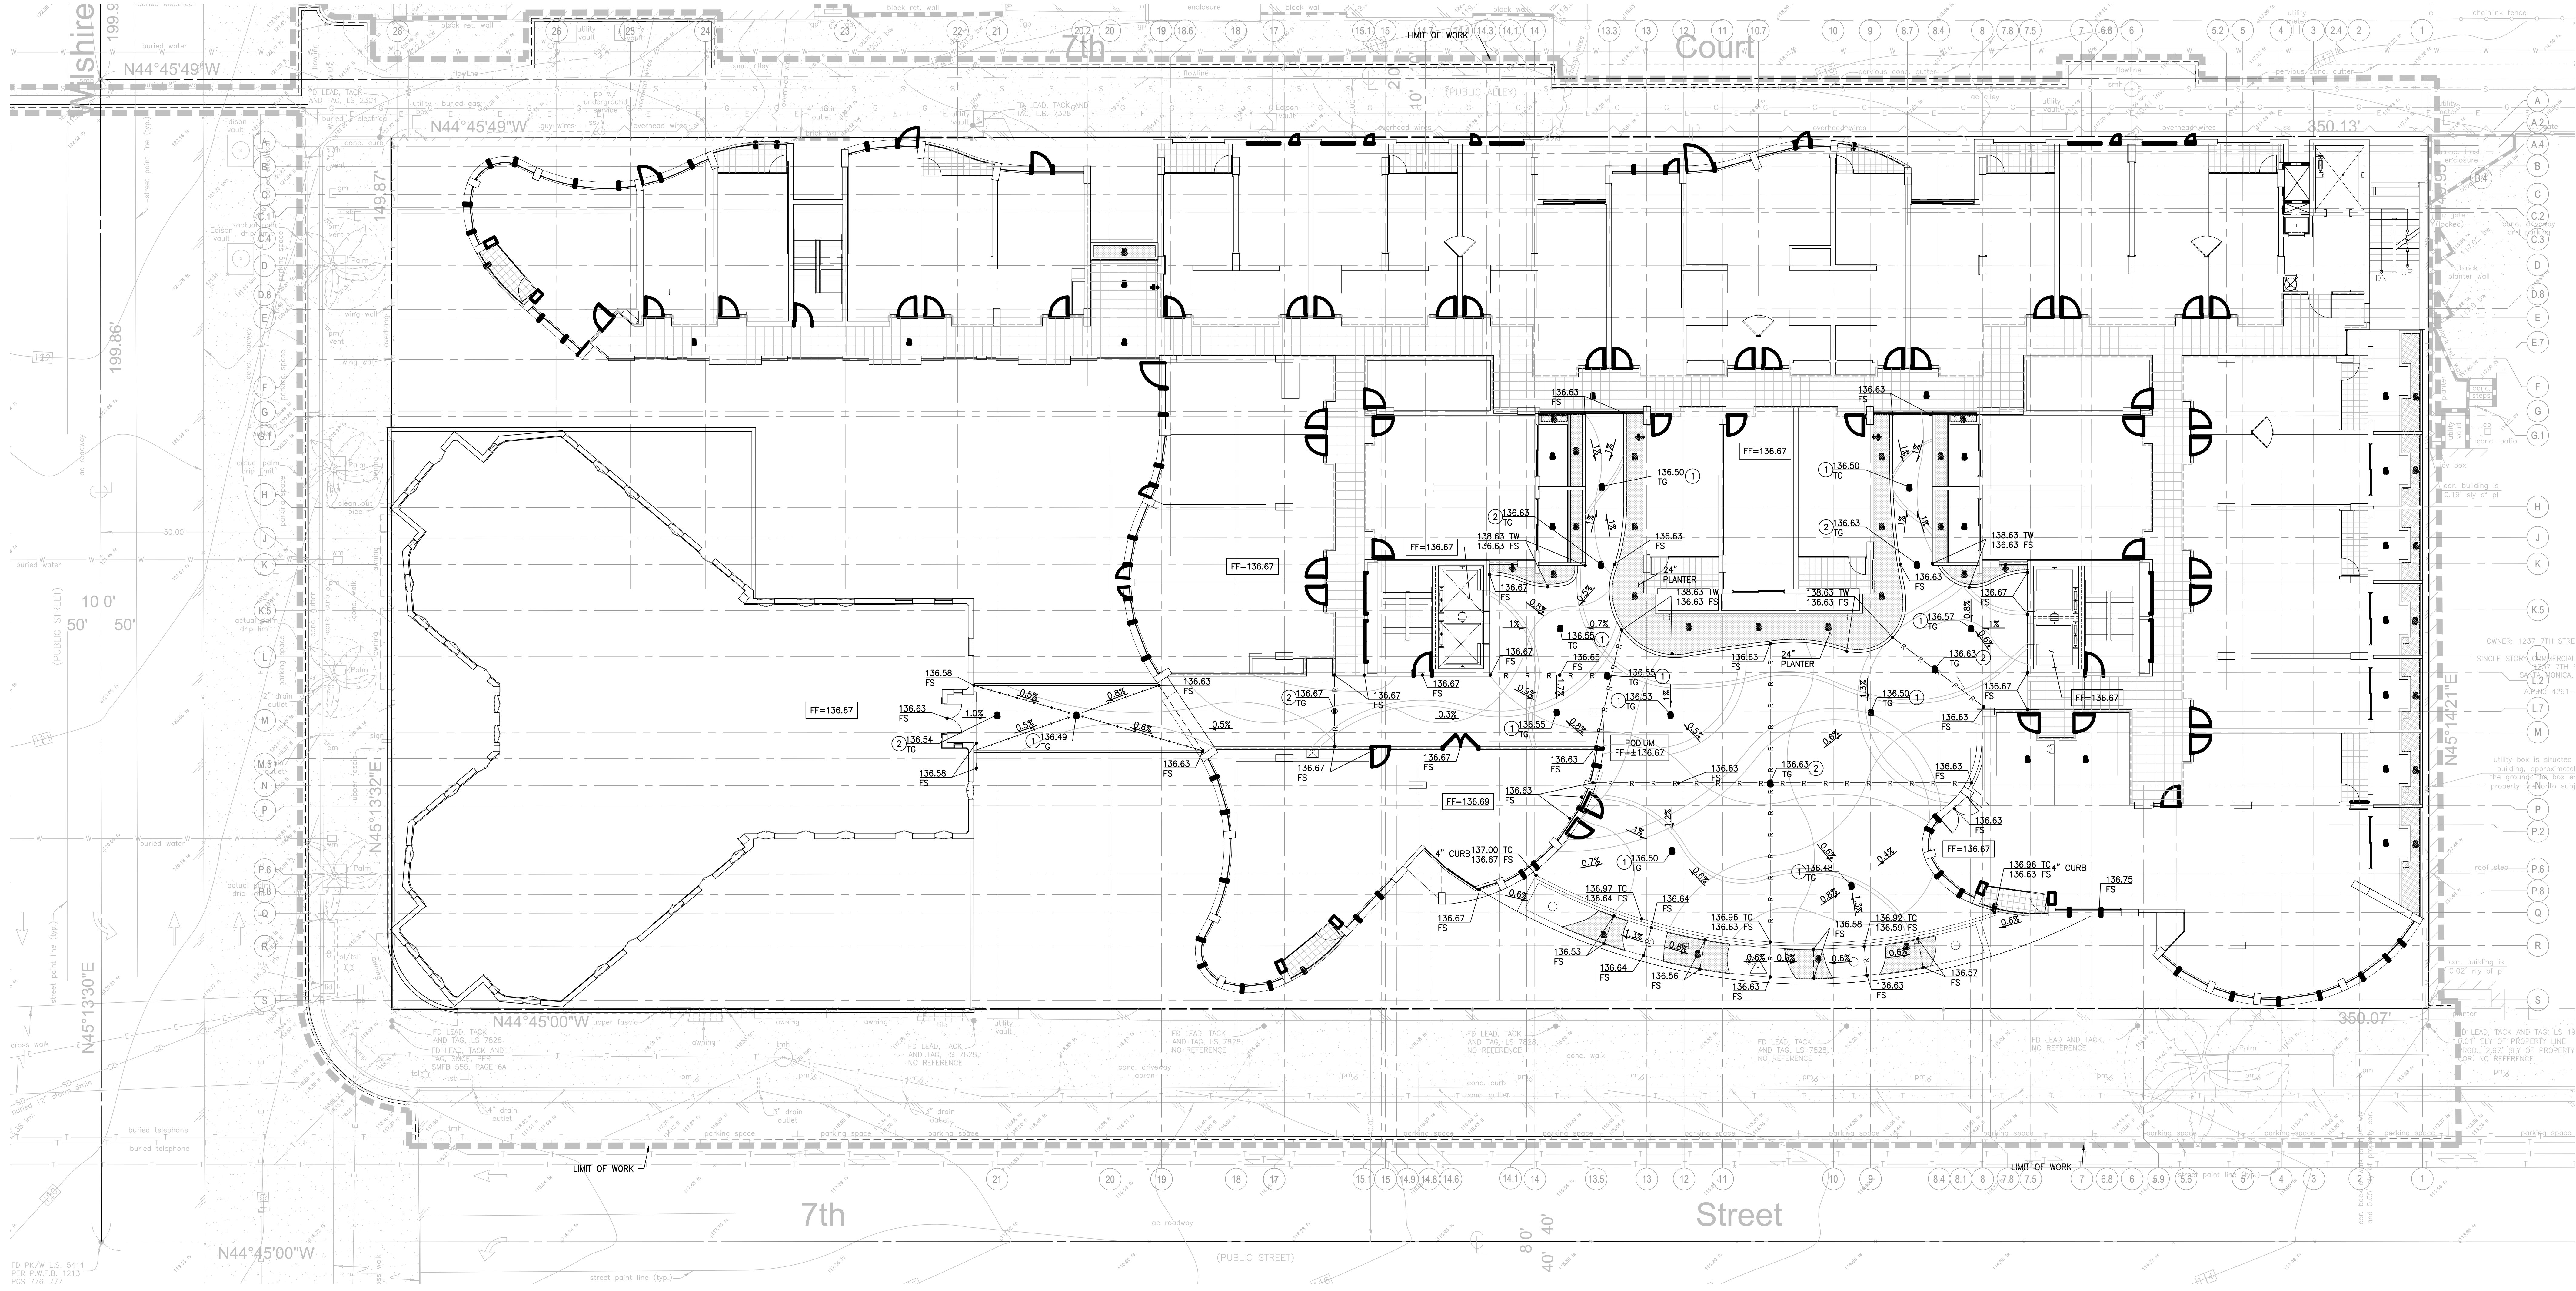


LEGEND

- LIMIT OF WORK
- RETAINING WALL
- SAWCUT AND JOIN LINE
- SEATWALL PER LANDSCAPE PLANS
- PLANTER PER LANDSCAPE PLANS

GRADING PLAN NOTES

- ① DRAINS TIED INTO STORM DRAIN. TO BE COORDINATED WITH PLUMBING ENGINEER.
- ② OVERFLOW DRAINS TO BE COORDINATED WITH PLUMBING ENGINEER. OUTLET PER PLUMBING PLANS.

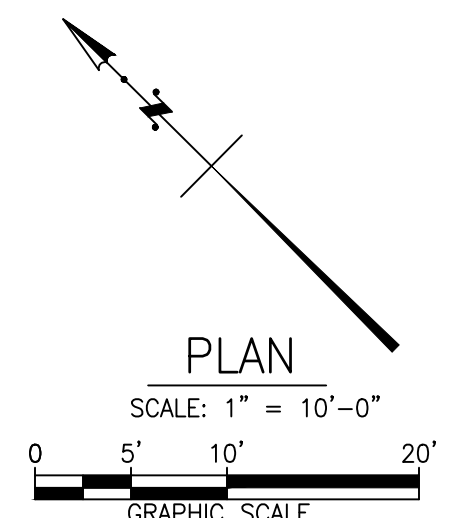

710 WILSHIRE BOULEVARD MIXED-USE HOTEL PROJECT SANTA MONICA - CALIFORNIA 90401		DRAWN: SS CHECKED: SR APPROVED: RD SCALE: AS SHOWN SHEET: C-141 DATE: June 25, 2013 PROJECT NUMBER: HLA 0000000-00000	
CONSULTANTS		OWNER: 1237 7TH STREET SANTA MONICA, CA 90401 ARCHITECT: 4291-1 UTILITY BOX IS SITUATED BUILDING, APPROXIMATELY THE GROUND THE BOX IS PROPERTY (N=to sub)	
howard laks architects		OWNER: 1237 7TH STREET SANTA MONICA, CA 90401 ARCHITECT: 4291-1 UTILITY BOX IS SITUATED BUILDING, APPROXIMATELY THE GROUND THE BOX IS PROPERTY (N=to sub)	
hla		OWNER: 1237 7TH STREET SANTA MONICA, CA 90401 ARCHITECT: 4291-1 UTILITY BOX IS SITUATED BUILDING, APPROXIMATELY THE GROUND THE BOX IS PROPERTY (N=to sub)	
PROJECT NO. 110229		PROJECT NO. 110229	
DATE: 06/07/2013		DATE: 06/07/2013	
REVISION: 00/04/2013		REVISION: 00/04/2013	
REVISION: 10/20/2013		REVISION: 10/20/2013	
REVISION: 05/27/2013		REVISION: 05/27/2013	
VOICE: 310-393-4465		VOICE: 310-393-4465	
FAX: 310-393-2230		FAX: 310-393-2230	