





KEY NOTES

- 1 FOR PRIMARY AND SECONDARY CONDENSATE DRAINS; SEE PLUMBING DRAWINGS.
- 2 FAN'S FILTER BOX W/MERV 8.
- 3 10" OSA DUCT. 210 CFM
- 4 12" OSA DUCT. 375 CFM
- 5 3/4" CHWS/R AND 3/4" HHWS/R.
- 6 3/4" CHWS/R
- 7 1" CHWS/R AND 1" HHWS/R.
- 8 4" CHWS/R AND 3" HHWS/R.
- 9 1-1/4" CHWS/R AND 1-1/4" HHWS/R.
- 10 REFRIGERANT PIPING FROM WATER COOLED CONDENSING UNIT TO EVAPORATOR SECTION

REVISION	DATE	DESCRIPTION
1	05/07/2013	MECHANICAL
2	08/04/2013	MECHANICAL
3	10/29/2013	MECHANICAL
4	05/27/2016	MECHANICAL

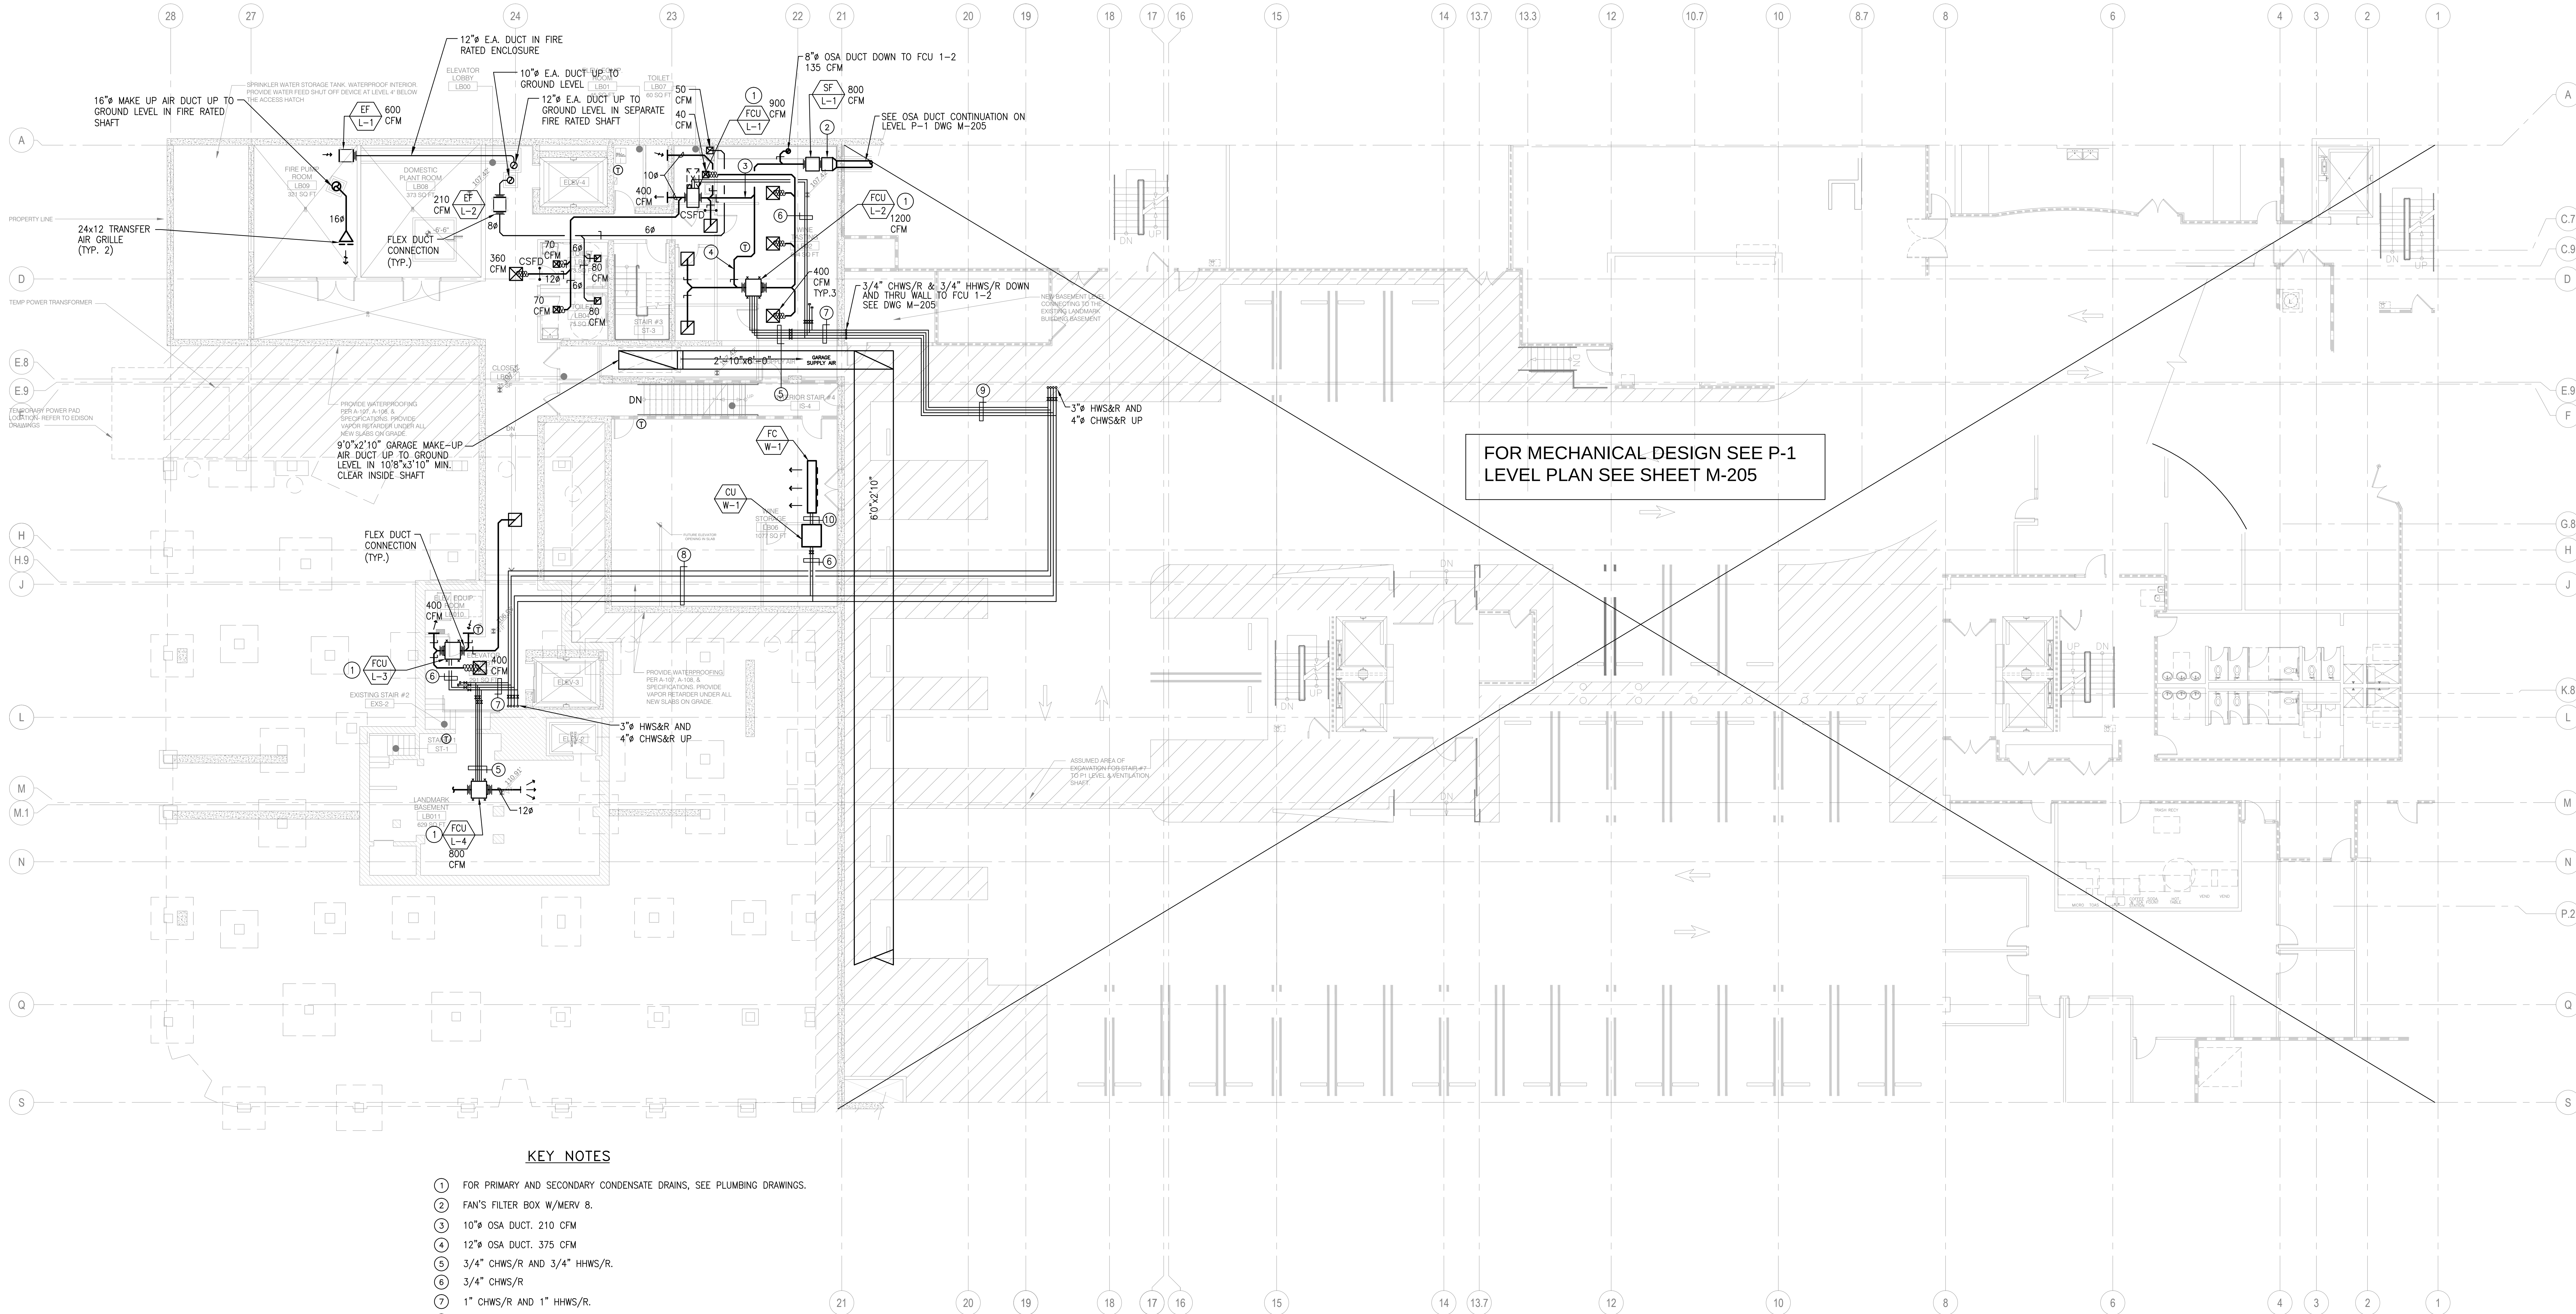

howard laks architects
1545 Wilshire Street
Santa Monica, CA 90401
voice : 310-393-4465
fax : 310-393-2220

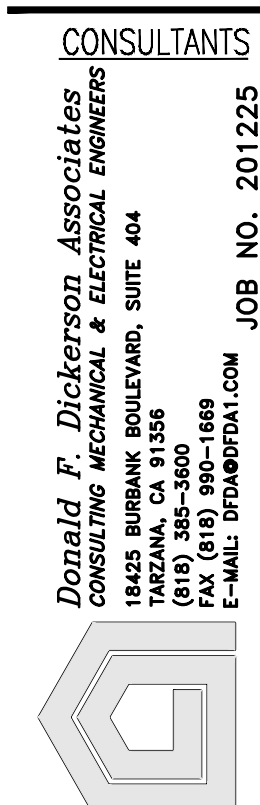

Donald F. Diskeropian, Architect
CONSULTING MECHANICAL & ELECTRICAL ENGINEERS
1545 WILSHIRE STREET, SUITE 404
SANTA MONICA, CA 90401
TEL: 310-393-4465
FAX: 310-393-2220
E-MAIL: DON@DONF.COM

710 WILSHIRE BOULEVARD
MIXED-USE HOTEL PROJECT
SANTA MONICA - CALIFORNIA 90401
LANDMARK BLDG BASEMENT FLOOR PLAN

DRAWN	--
CHECKED	--
APPROVED	--
SCALE	1/8" = 1'-0"
SHEET	M-206
DATE	June 25, 2013
PROJECT NUMBER	HLA 0000000-00000