


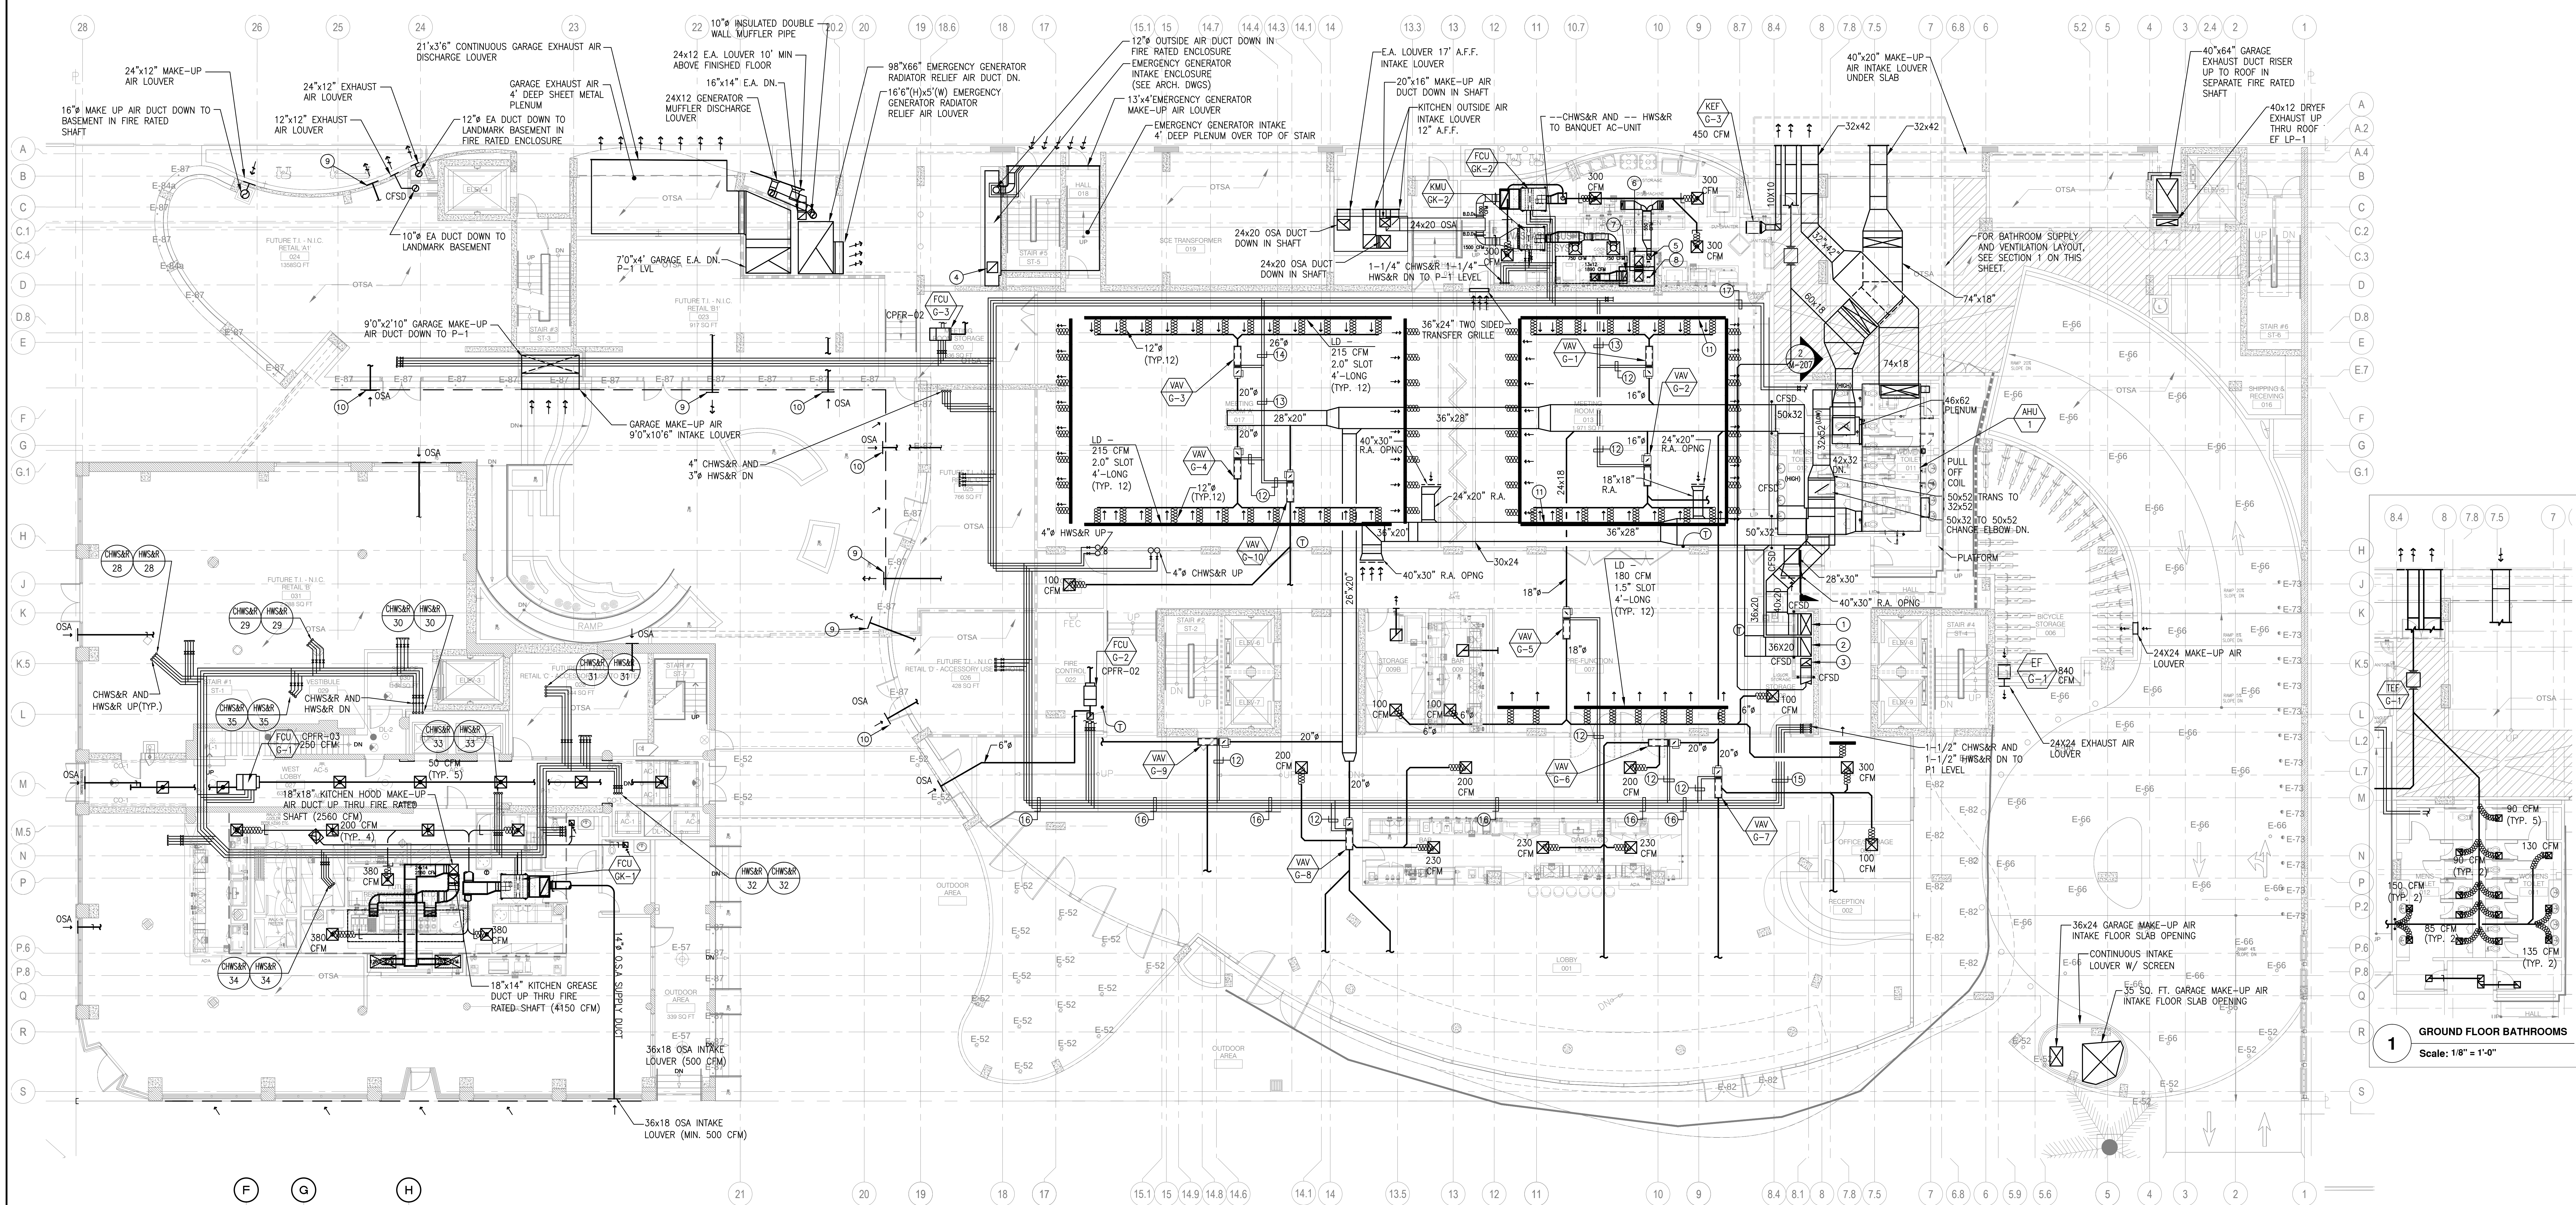

KEY NOTES

- 40x20 S.A. DUCT DOWN TO LEVEL P-1 IN FIRE RATED SHAFT WITH CFSD
- 36x20 R.A. DUCT DOWN TO LEVEL P-1 IN FIRE RATED SHAFT WITH CFSD
- 14x20 E.A. DUCT DOWN TO LEVEL P-1 IN FIRE RATED SHAFT WITH CFSD
- 20x20 COMBUSTION AIR DUCT DOWN. START 24\"/>
- 10\"/>

SECTION

Scale: 1/8" = 1'-0"



howard laks architects
1545 health street
santa monica, ca 90401
voice : 310-393-4465
fax : 310-393-2220

CONSULTANTS

Donald F. Dickerson Associates
CONSULTING MECHANICAL & ELECTRICAL ENGINEERS
1700 WILSHIRE BOULEVARD, SUITE 404
SANTA MONICA, CA 90401
TEL: 310-393-4465
FAX: 310-393-2220
E-MAIL: ddickerson@hla.com

710 WILSHIRE BOULEVARD
MIXED-USE HOTEL PROJECT
SANTA MONICA - CALIFORNIA 90401
GROUND FLOOR PLAN

DRAWN: ---
CHECKED: ---
APPROVED: ---
SCALE: 1/8" = 1'-0"
SHEET: M-207

DATE: June 25, 2013
PROJECT NUMBER: HLA 000000-00000