




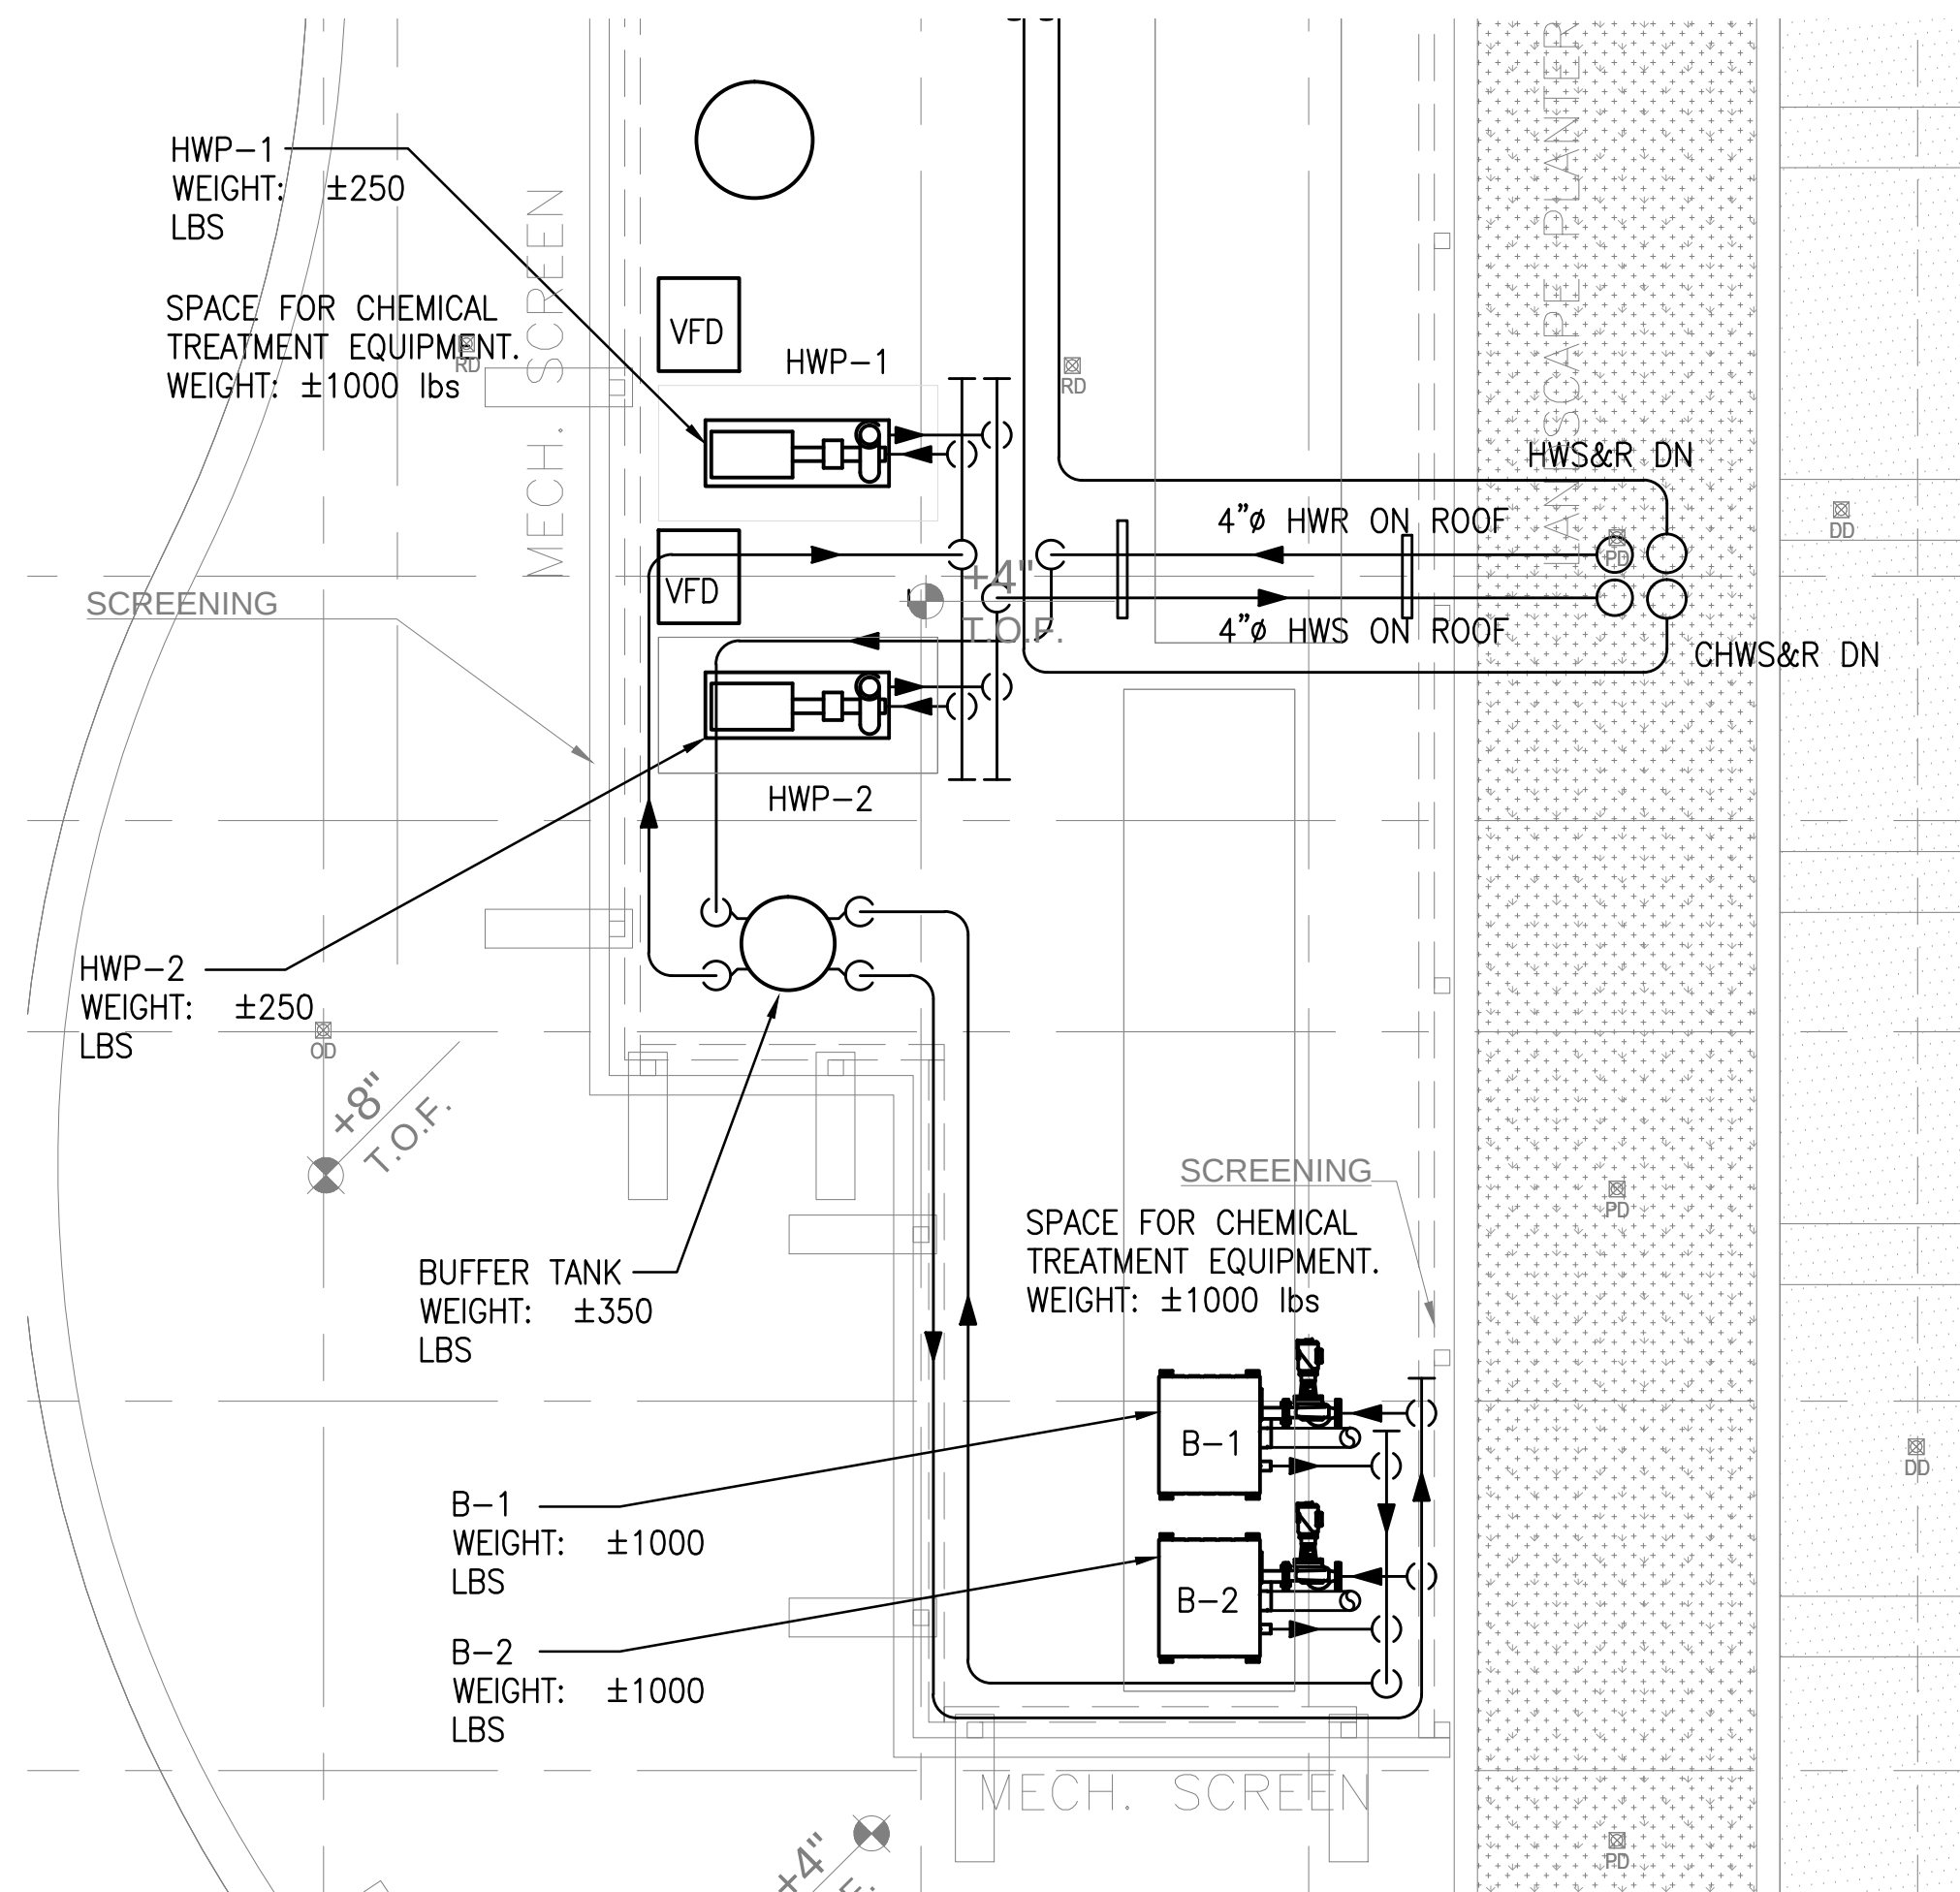

3 ENLARGED SEVENTH FLOOR HEATING PLANT
Scale: 3/8" = 1'-0"

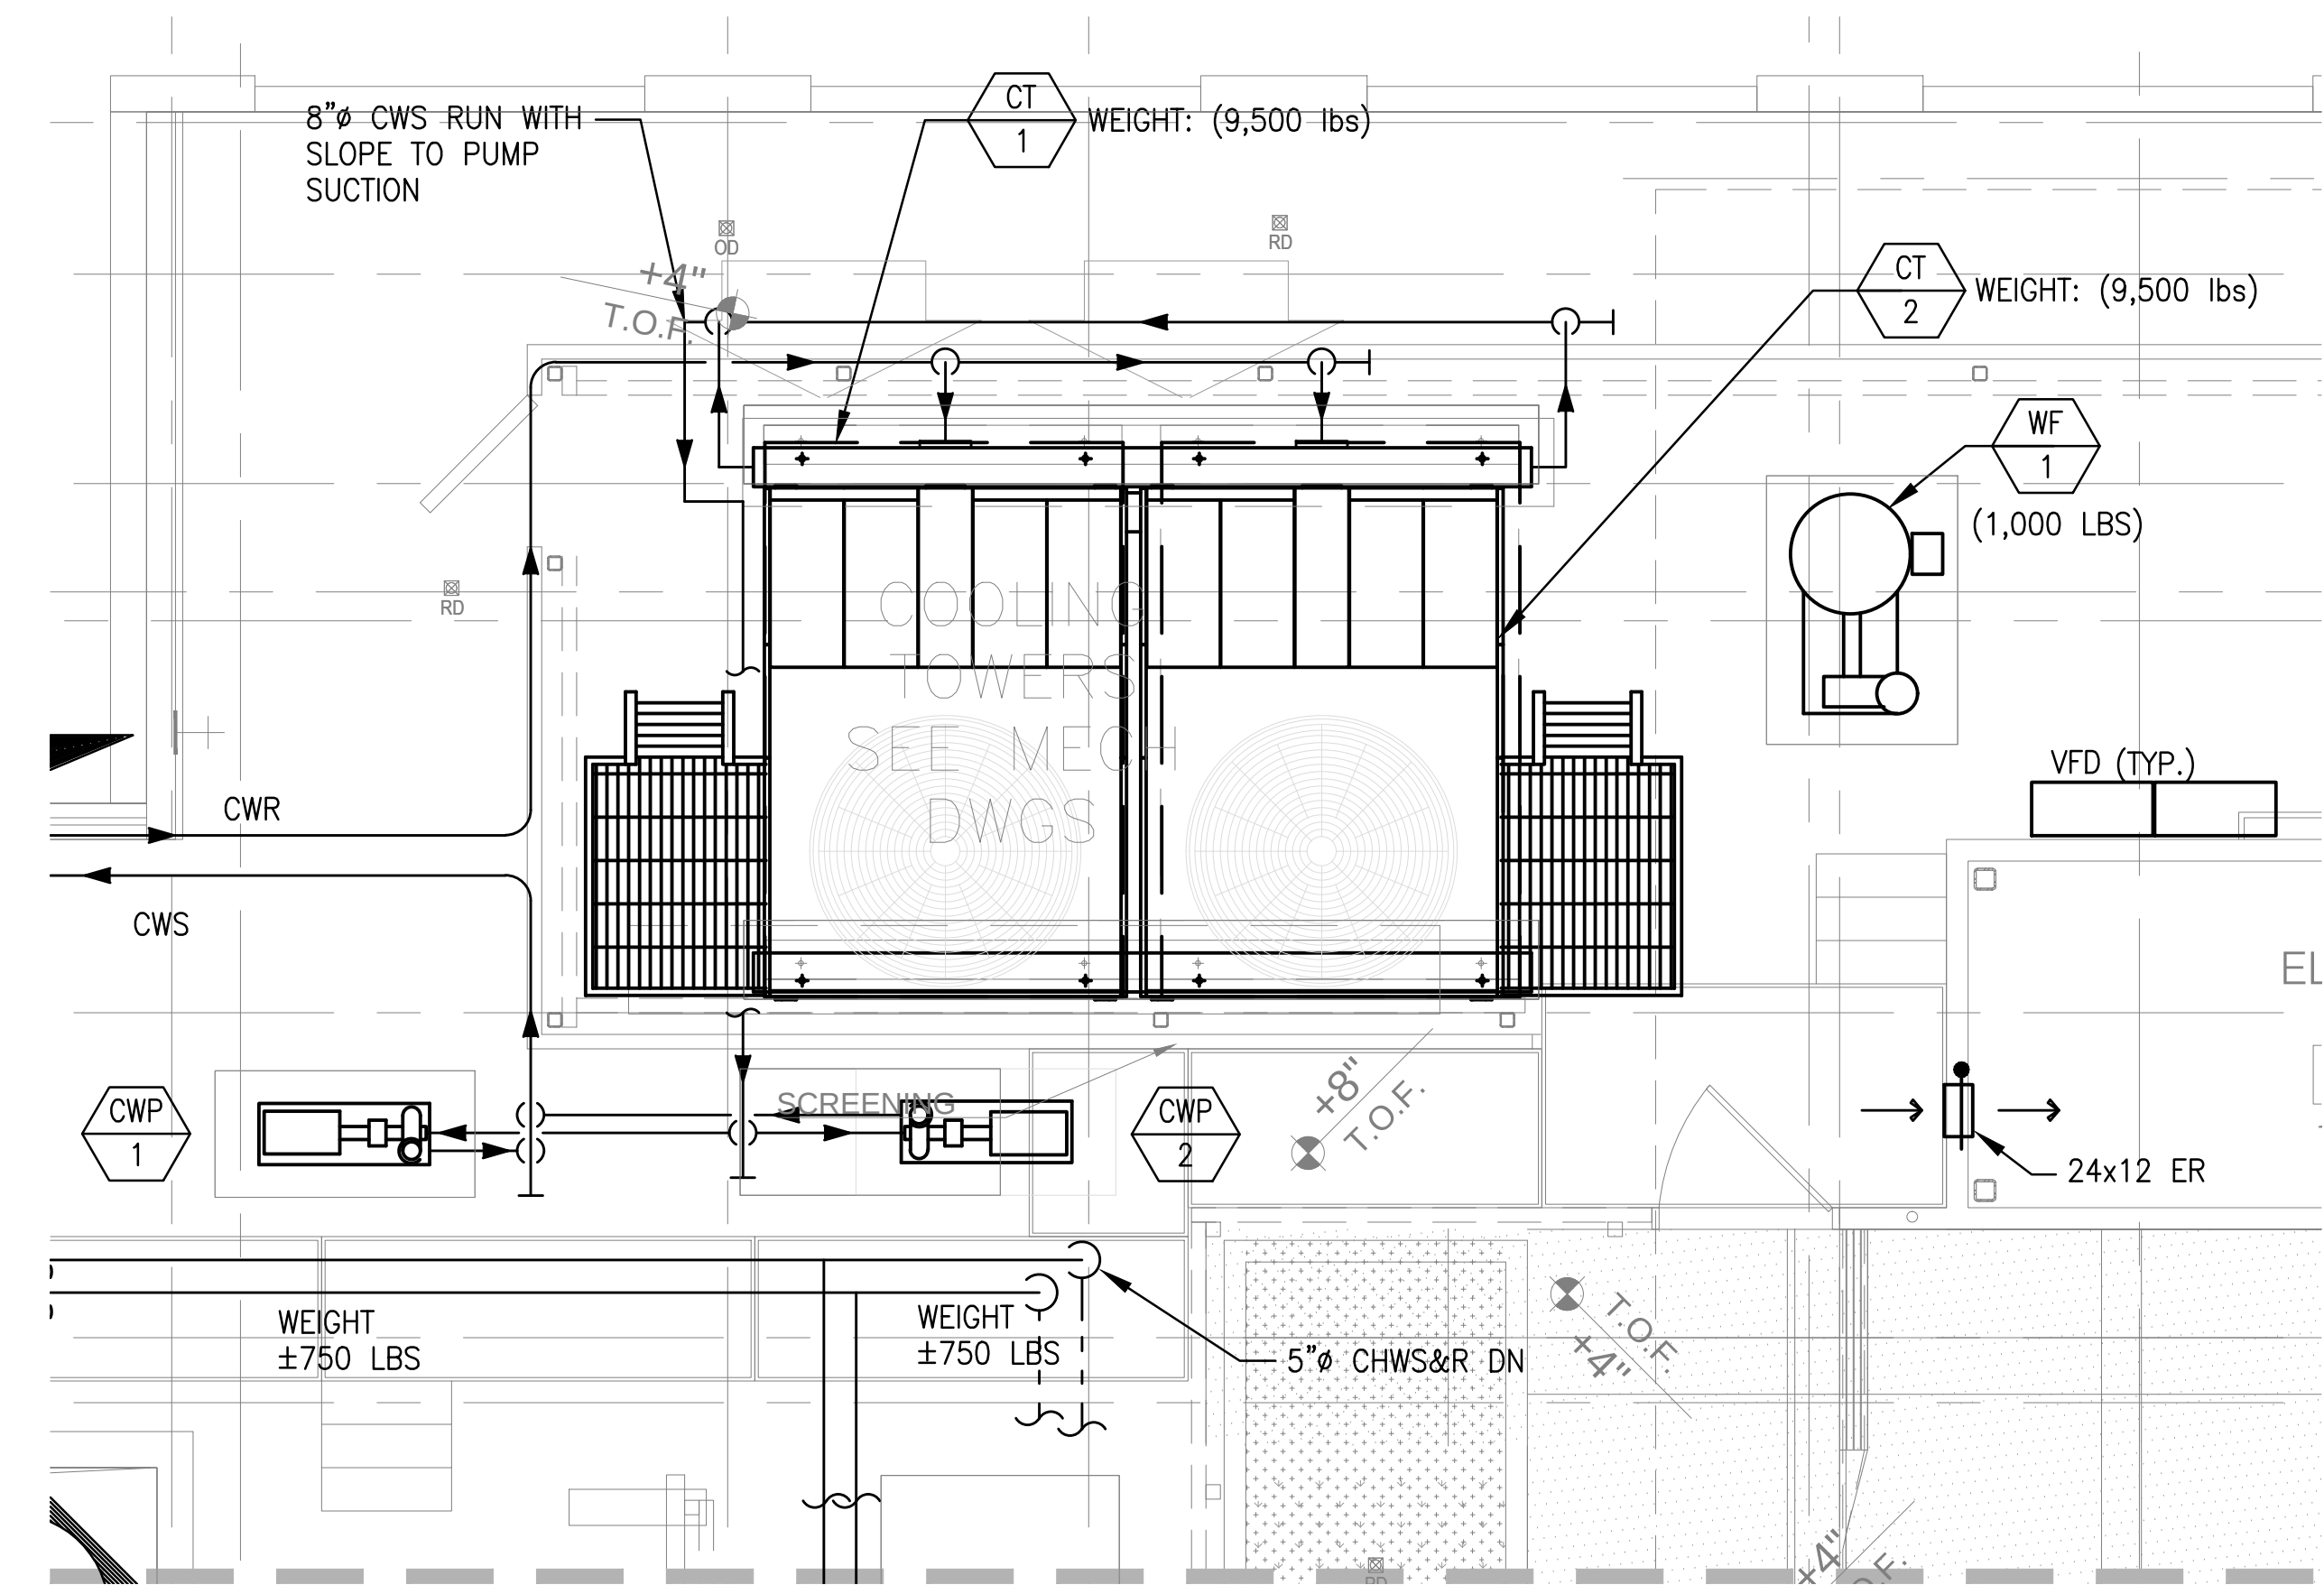

1 ENLARGED SEVENTH FLOOR COOLING TOWER
Scale: 3/8" = 1'-0"

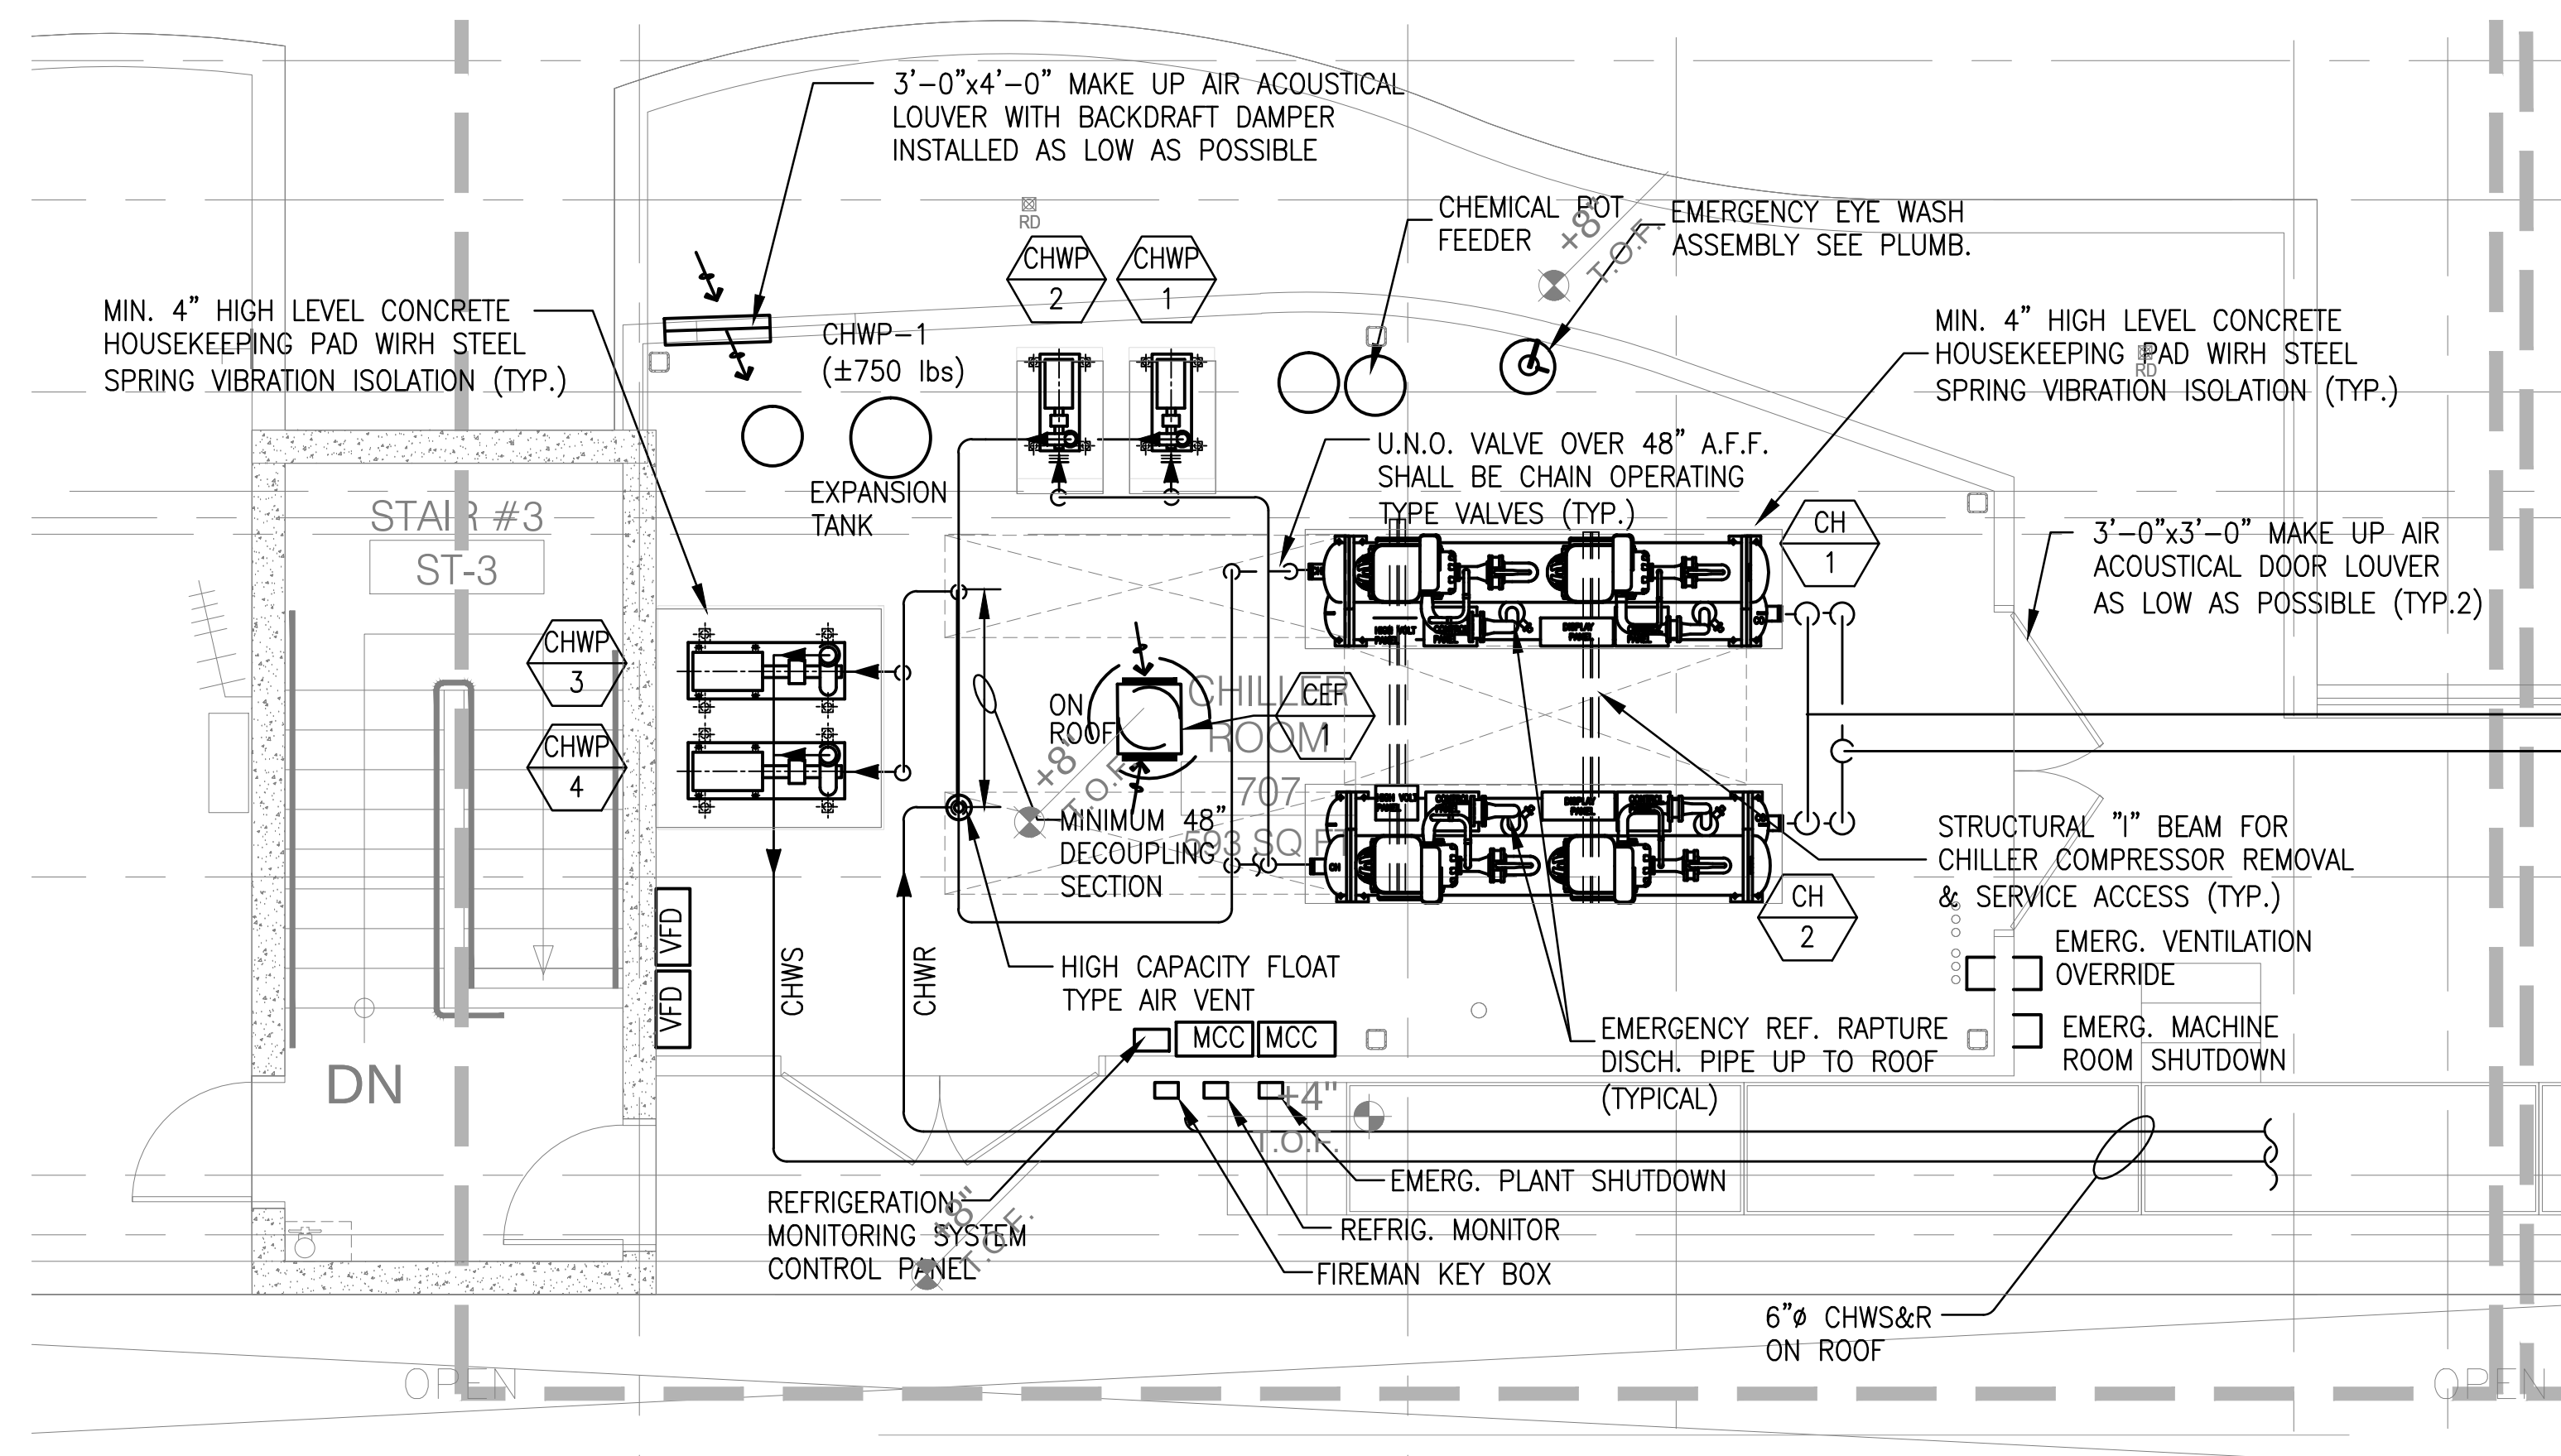


2 ENLARGED SEVENTH FLOOR CHILLER ROOM
Scale: 3/8" = 1'-0"

REVISION	DATE	DESCRIPTION
1	05/07/2015	Medium 02
2	09/04/2015	Medium 03
3	10/20/2015	Medium 04
4	05/27/2016	Medium 05



howard laks architects
1545 hewlett street
santa monica, ca 90401
voice : 310-393-4465
fax : 310-393-2220

CONSULTANTS
Donald F. Dickerson Associates
CONSULTING MECHANICAL & ELECTRICAL ENGINEERS
1545 HEWLETT STREET, SUITE 404
SANTA MONICA, CA 90401
TEL: 310-393-4465
FAX: 310-393-2220
E-MAIL: ddickerson@hla.com
JOB NO. 201225

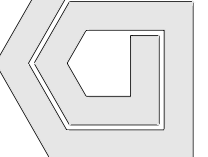

710 WILSHIRE BOULEVARD
MIXED-USE HOTEL PROJECT
SANTA MONICA - CALIFORNIA 90401
ENLARGED SEVENTH FLOOR MECHANICAL PLAN

DRAWN	CM
CHECKED	---
APPROVED	---
SCALE	1/8" = 1'-0"
SHEET	M-301
DATE	June 25, 2013
PROJECT NUMBER	HLA 0000000-00000