


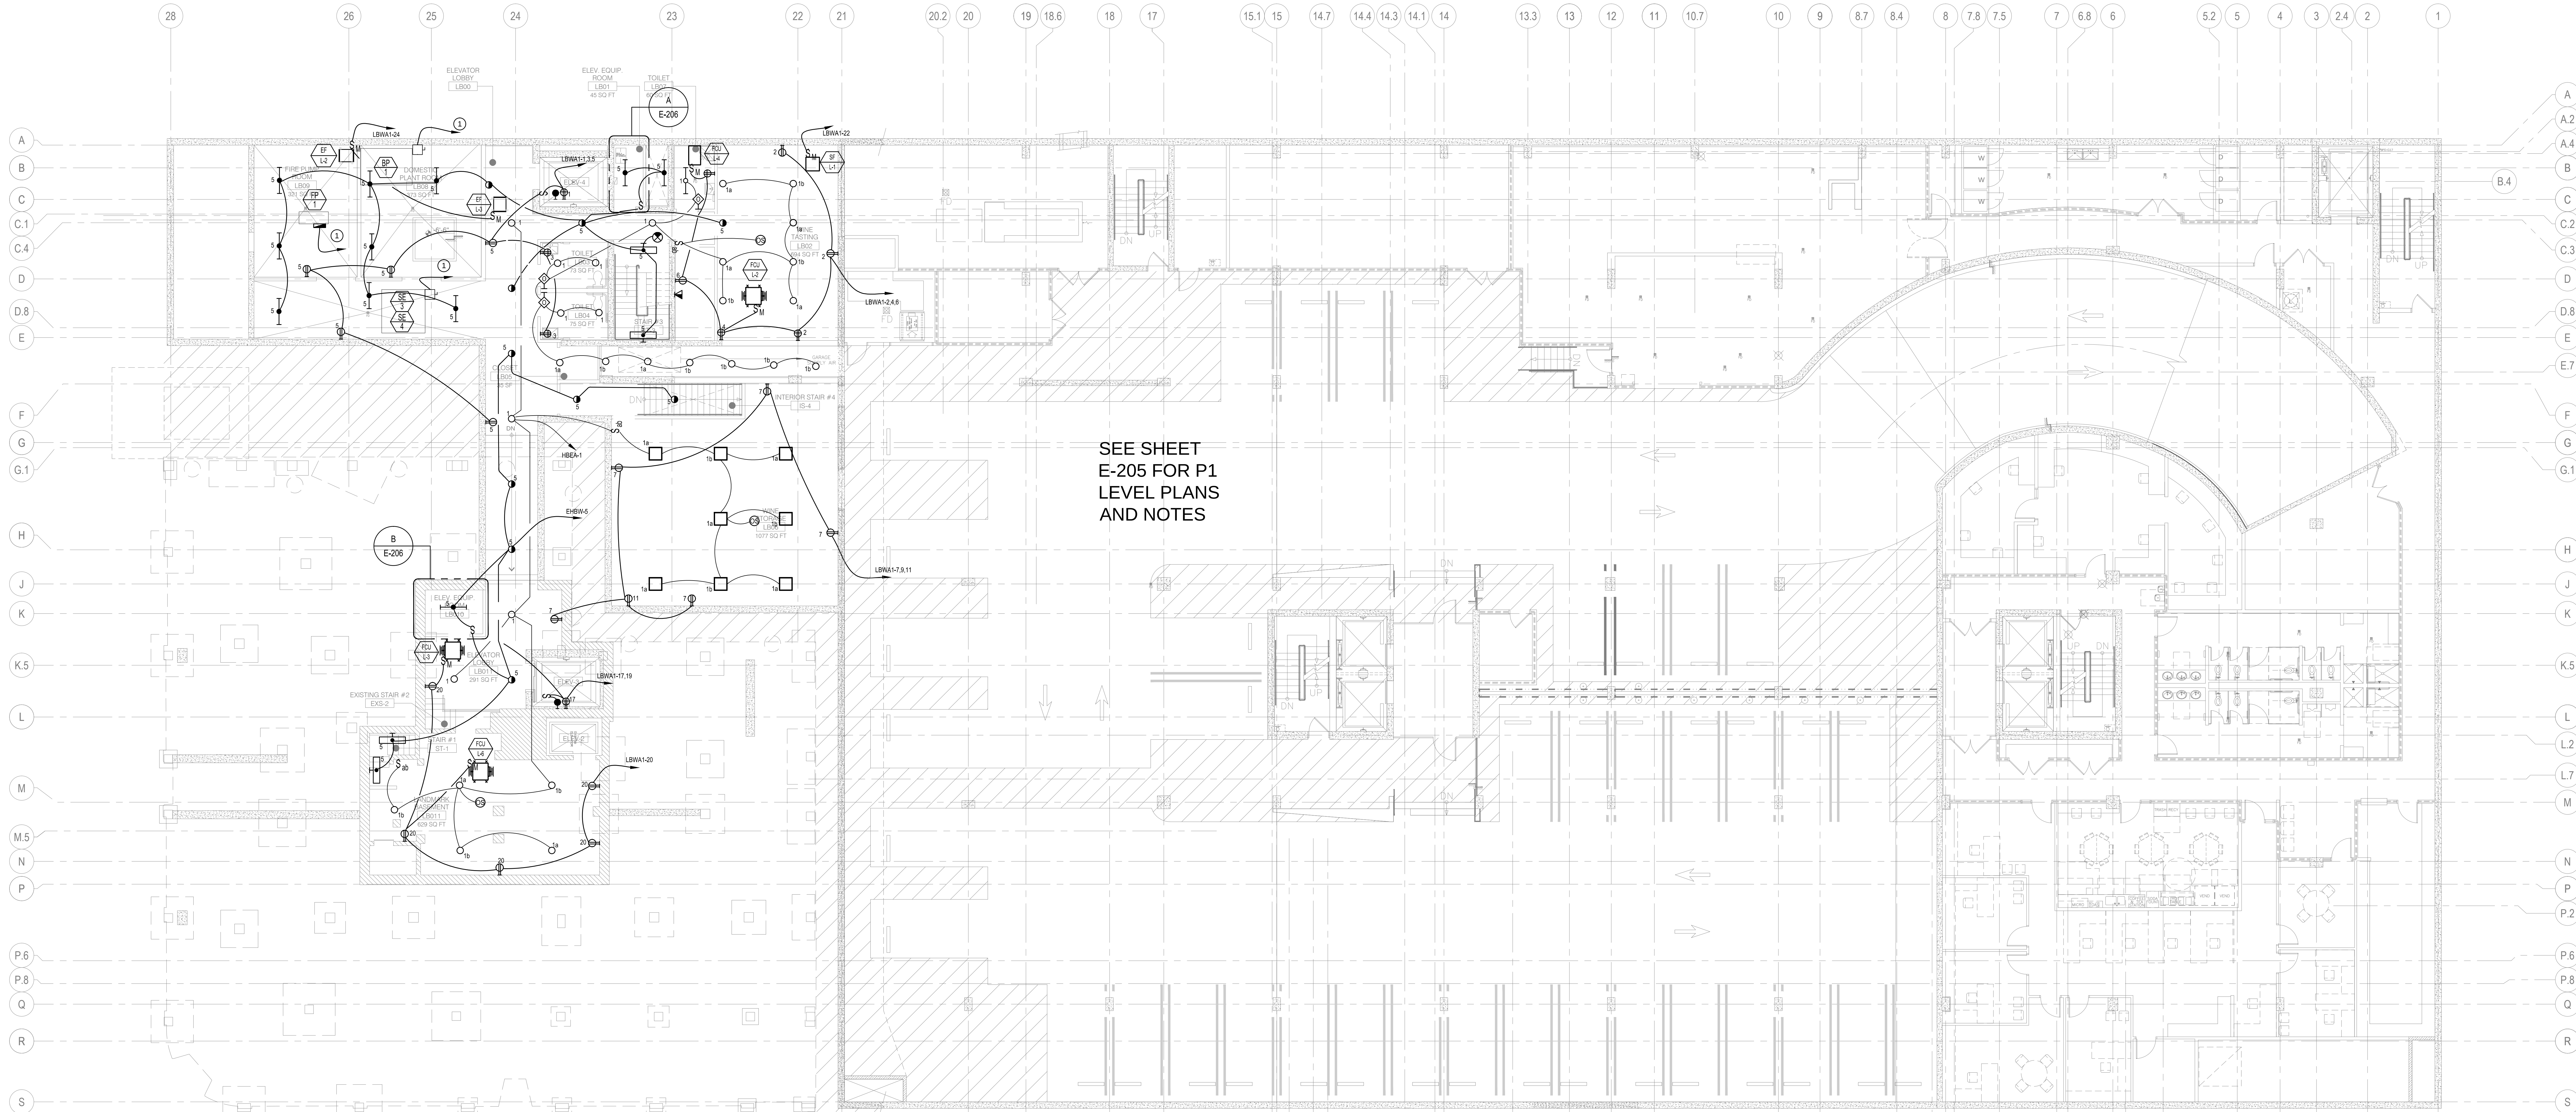

SEE SHEET
E-205 FOR P1
LEVEL PLANS
AND NOTES

ENLARGED ELEVATOR EQUIPMENT ROOM ELEVATOR 4

SCALE: 1/4" = 1'-0"

ENLARGED ELEVATOR EQUIPMENT ROOM ELEVATOR 2 & 3

SCALE: 1/4" = 1'-0"

KEY NOTES:

1. REFER TO SINGLE LINE DIAGRAM FOR CIRCUIT INFORMATION.
2. DISCONNECT SWITCH FOR ELEVATOR MOTOR (COORDINATE SIZE WITH EQUIPMENT PROVIDER PRIOR TO INSTALLATION)
3. LOCKABLE SWITCH FOR ELEVATOR CAB LIGHTING.
4. JUNCTION BOX FOR ELEVATOR CONTROLLER.
5. HEAT DETECTOR TO CONTROL SHUNT TRIP CIRCUIT BREAKER FOR ELEVATOR MOTOR.
6. TELEPHONE OUTLET. RUN 3/4"C.O. TO NEAREST TELEPHONE BACKBOARD.

SHEET NOTES:

1. FOR EXACT LOCATION AND CONTROL REQUIREMENTS OF HVAC AND PLUMBING EQUIPMENT REFER TO CORRESPONDING DRAWINGS.
2. PROVIDE EXTRA UNSWITCHED HOT WIRE FOR EXIT SIGNS. LOCATION AND QUANTITY OF EXIT SIGNS SHALL MATCH ARCHITECTURAL DRAWINGS.


REVISION	DATE	DESCRIPTION
1	05/07/2015	MECHANICAL
2	06/04/2015	MECHANICAL
3	06/04/2015	MECHANICAL
4	06/04/2015	MECHANICAL
5	06/07/2016	MECHANICAL



howard laks architects
1545 hewlett street
santa monica, ca 90401
voice : 310-393-4465
fax : 310-393-2220

CONSULTANTS

Donald F. Dickerson Associates
CONSULTING MECHANICAL & ELECTRICAL ENGINEERS
1545 HEWLETT STREET, SUITE 404
SANTA MONICA, CA 90401
TEL: 310-393-4465
FAX: 310-393-2220
E-MAIL: DONALD@DLA.COM

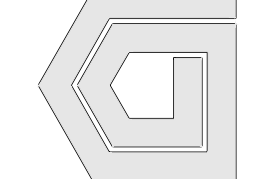

710 WILSHIRE BOULEVARD
MIXED-USE HOTEL PROJECT
SANTA MONICA - CALIFORNIA 90401
LANDMARK BLDG BASEMENT FLOOR PLAN

DRAWN	--
CHECKED	--
APPROVED	--
SCALE	1/8" = 1'-0"
SHEET	E-206
DATE	June 25, 2013
PROJECT NUMBER	HLA 0000000-00000