




SHEET NOTES:

1. FOR EXACT LOCATION AND CONTROL REQUIREMENTS OF HVAC AND PLUMBING EQUIPMENT REFER TO CORRESPONDING DRAWINGS.
2. PROVIDE EXTRA UNSWITCHED HOT WIRE FOR EXIT SIGNS. LOCATION AND QUANTITY OF EXIT SIGNS SHALL MATCH ARCHITECTURAL DRAWINGS.
3. PROVIDE ADDITIONAL SWITCH LEG FOR ALL EXTERIOR FIXTURES TO CONTROL WITH PHOTOCELL AND TIME CLOCK.

|        |            |             |
|--------|------------|-------------|
| DESIGN | DATE       | DESCRIPTION |
| REV    | 05/07/2015 | Medium 02   |
|        | 09/04/2015 | Medium 03   |
|        | 10/20/2015 | Medium 04   |
|        | 03/27/2016 | Medium 05   |

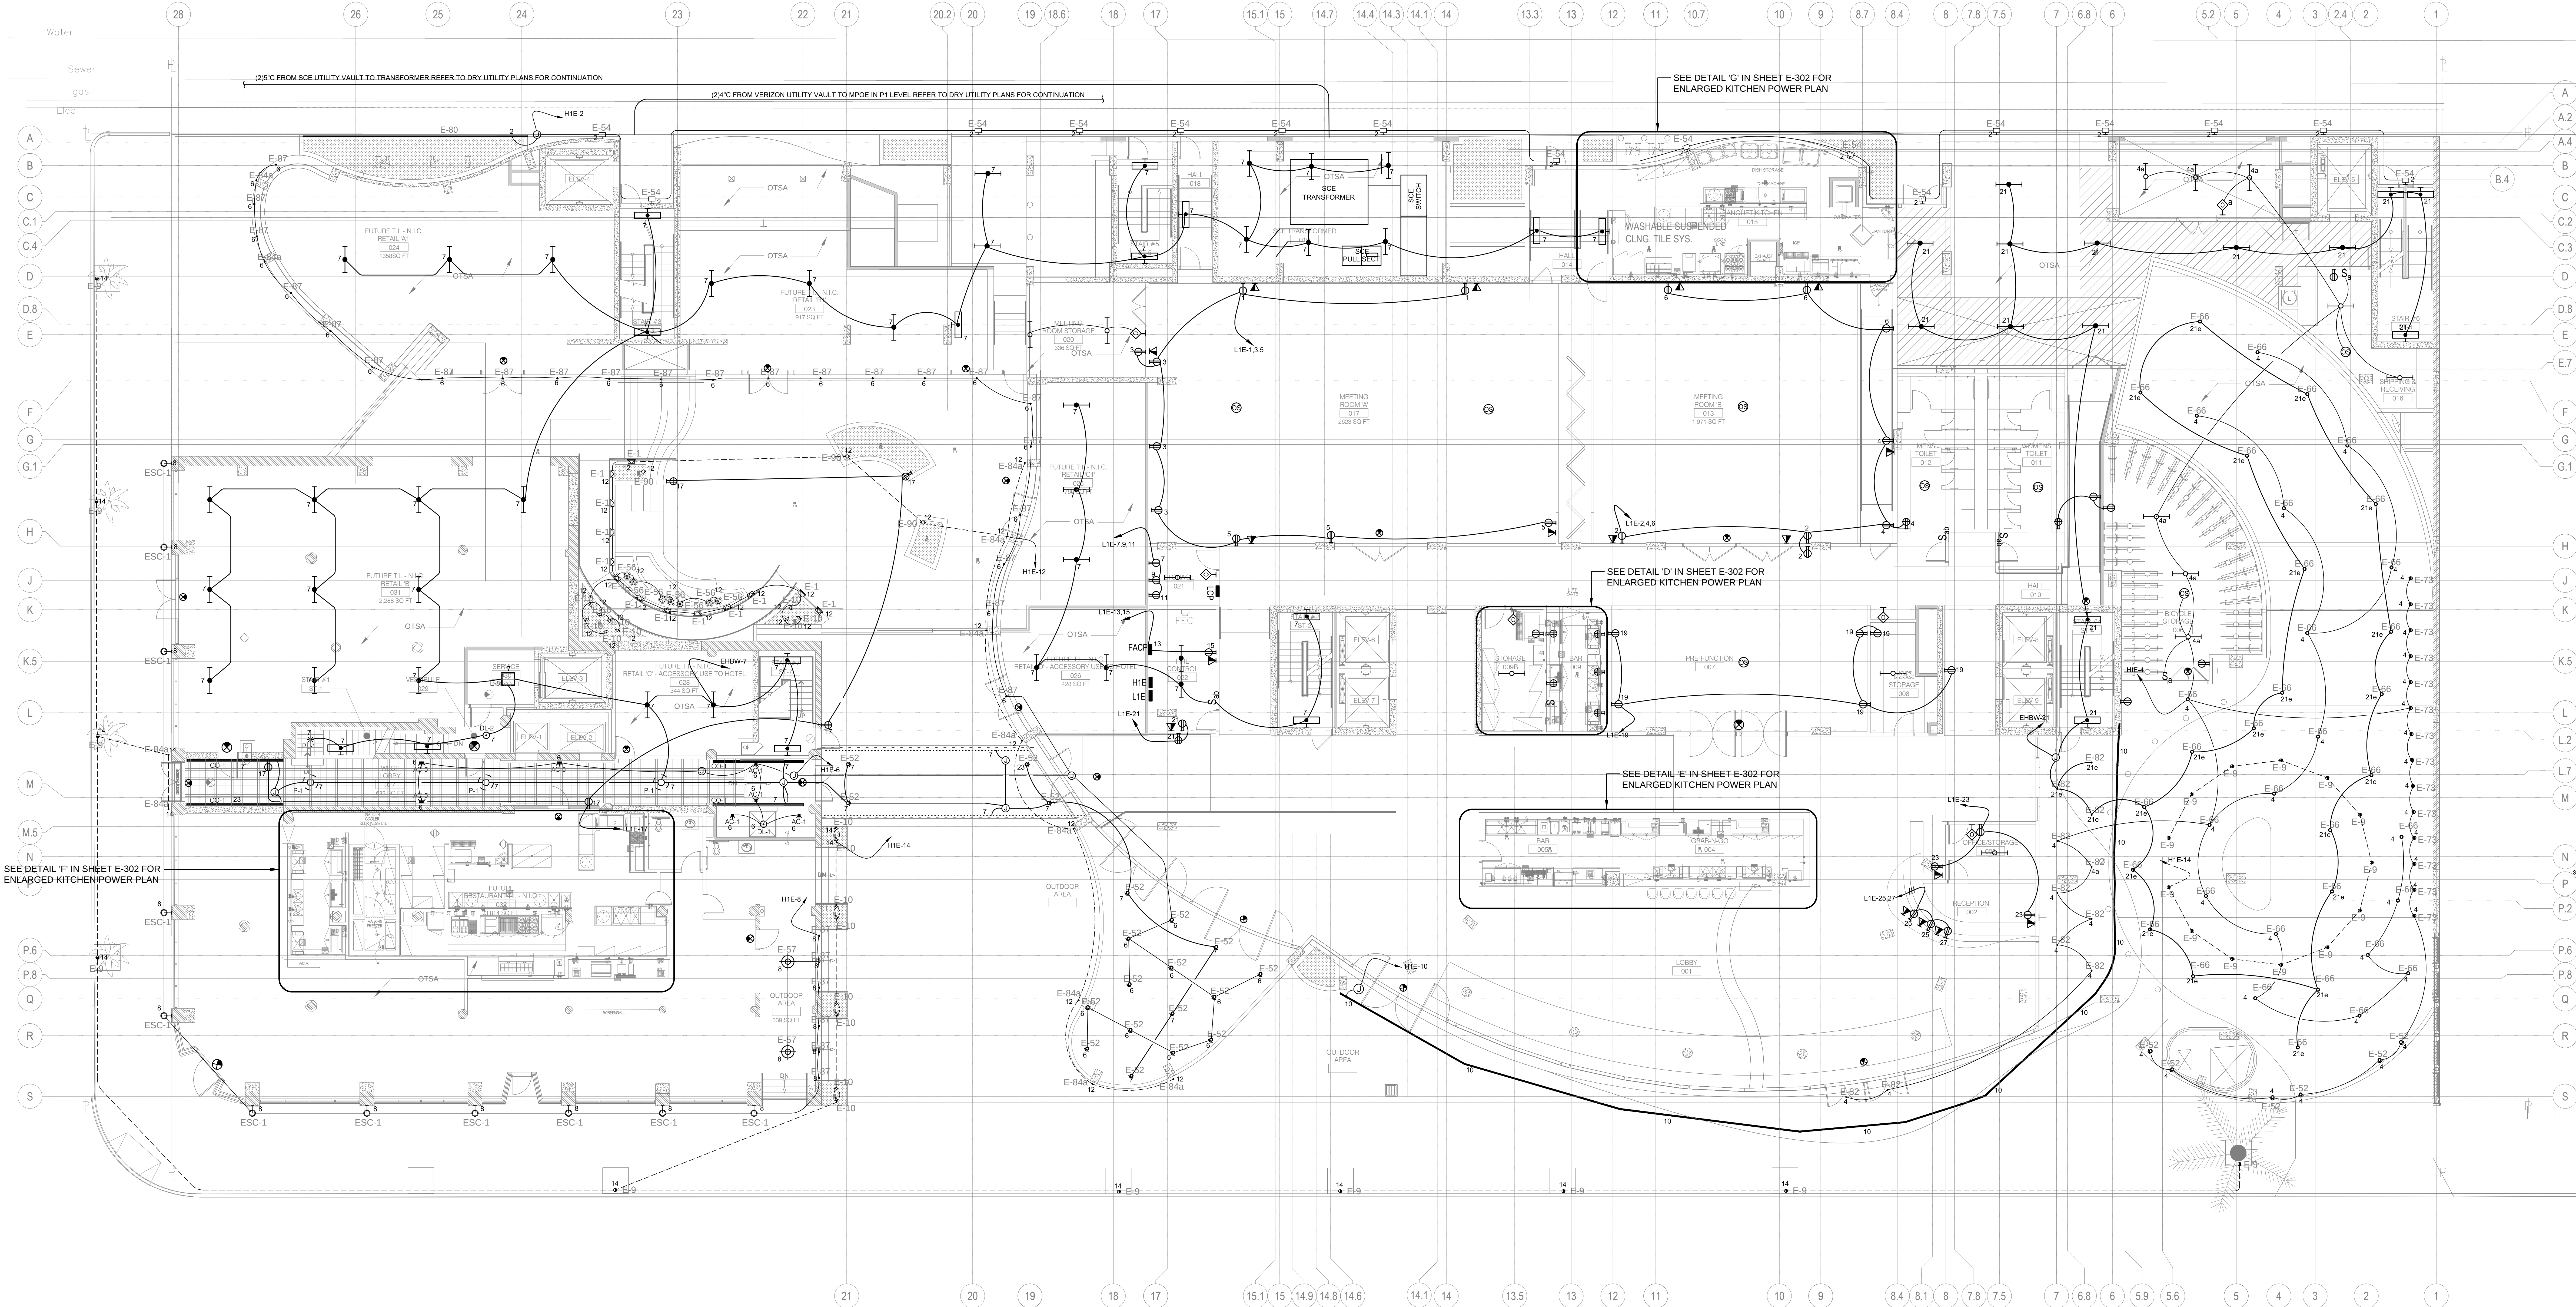

howard laks architects  
1545 health street  
santa monica, ca 90401  
voice : 310-393-4465  
fax : 310-393-2230

CONSULTANTS  
Donald F. Diskin, Architect  
CONSULTING MECHANICAL & ELECTRICAL ENGINEERS  
1545 HEALTH STREET, SUITE 404  
SANTA MONICA, CA 90401  
TEL: 310-393-4465  
E-MAIL: DONALD@HLSA.COM

710 WILSHIRE BOULEVARD  
MIXED-USE HOTEL PROJECT  
SANTA MONICA - CALIFORNIA, 90401  
GROUND FLOOR PLAN

|                |                   |
|----------------|-------------------|
| DRAWN          | --                |
| CHECKED        | --                |
| APPROVED       | --                |
| SCALE          | 1/8" = 1'-0"      |
| SHEET          | E-207             |
| DATE           | June 25, 2013     |
| PROJECT NUMBER | HLA 0000000-00000 |