




REVISION	DATE	DESCRIPTION
1	05/07/2015	MECHANICAL
2	06/04/2015	MECHANICAL
3	06/04/2015	MECHANICAL
4	06/04/2015	MECHANICAL
5	06/04/2015	MECHANICAL

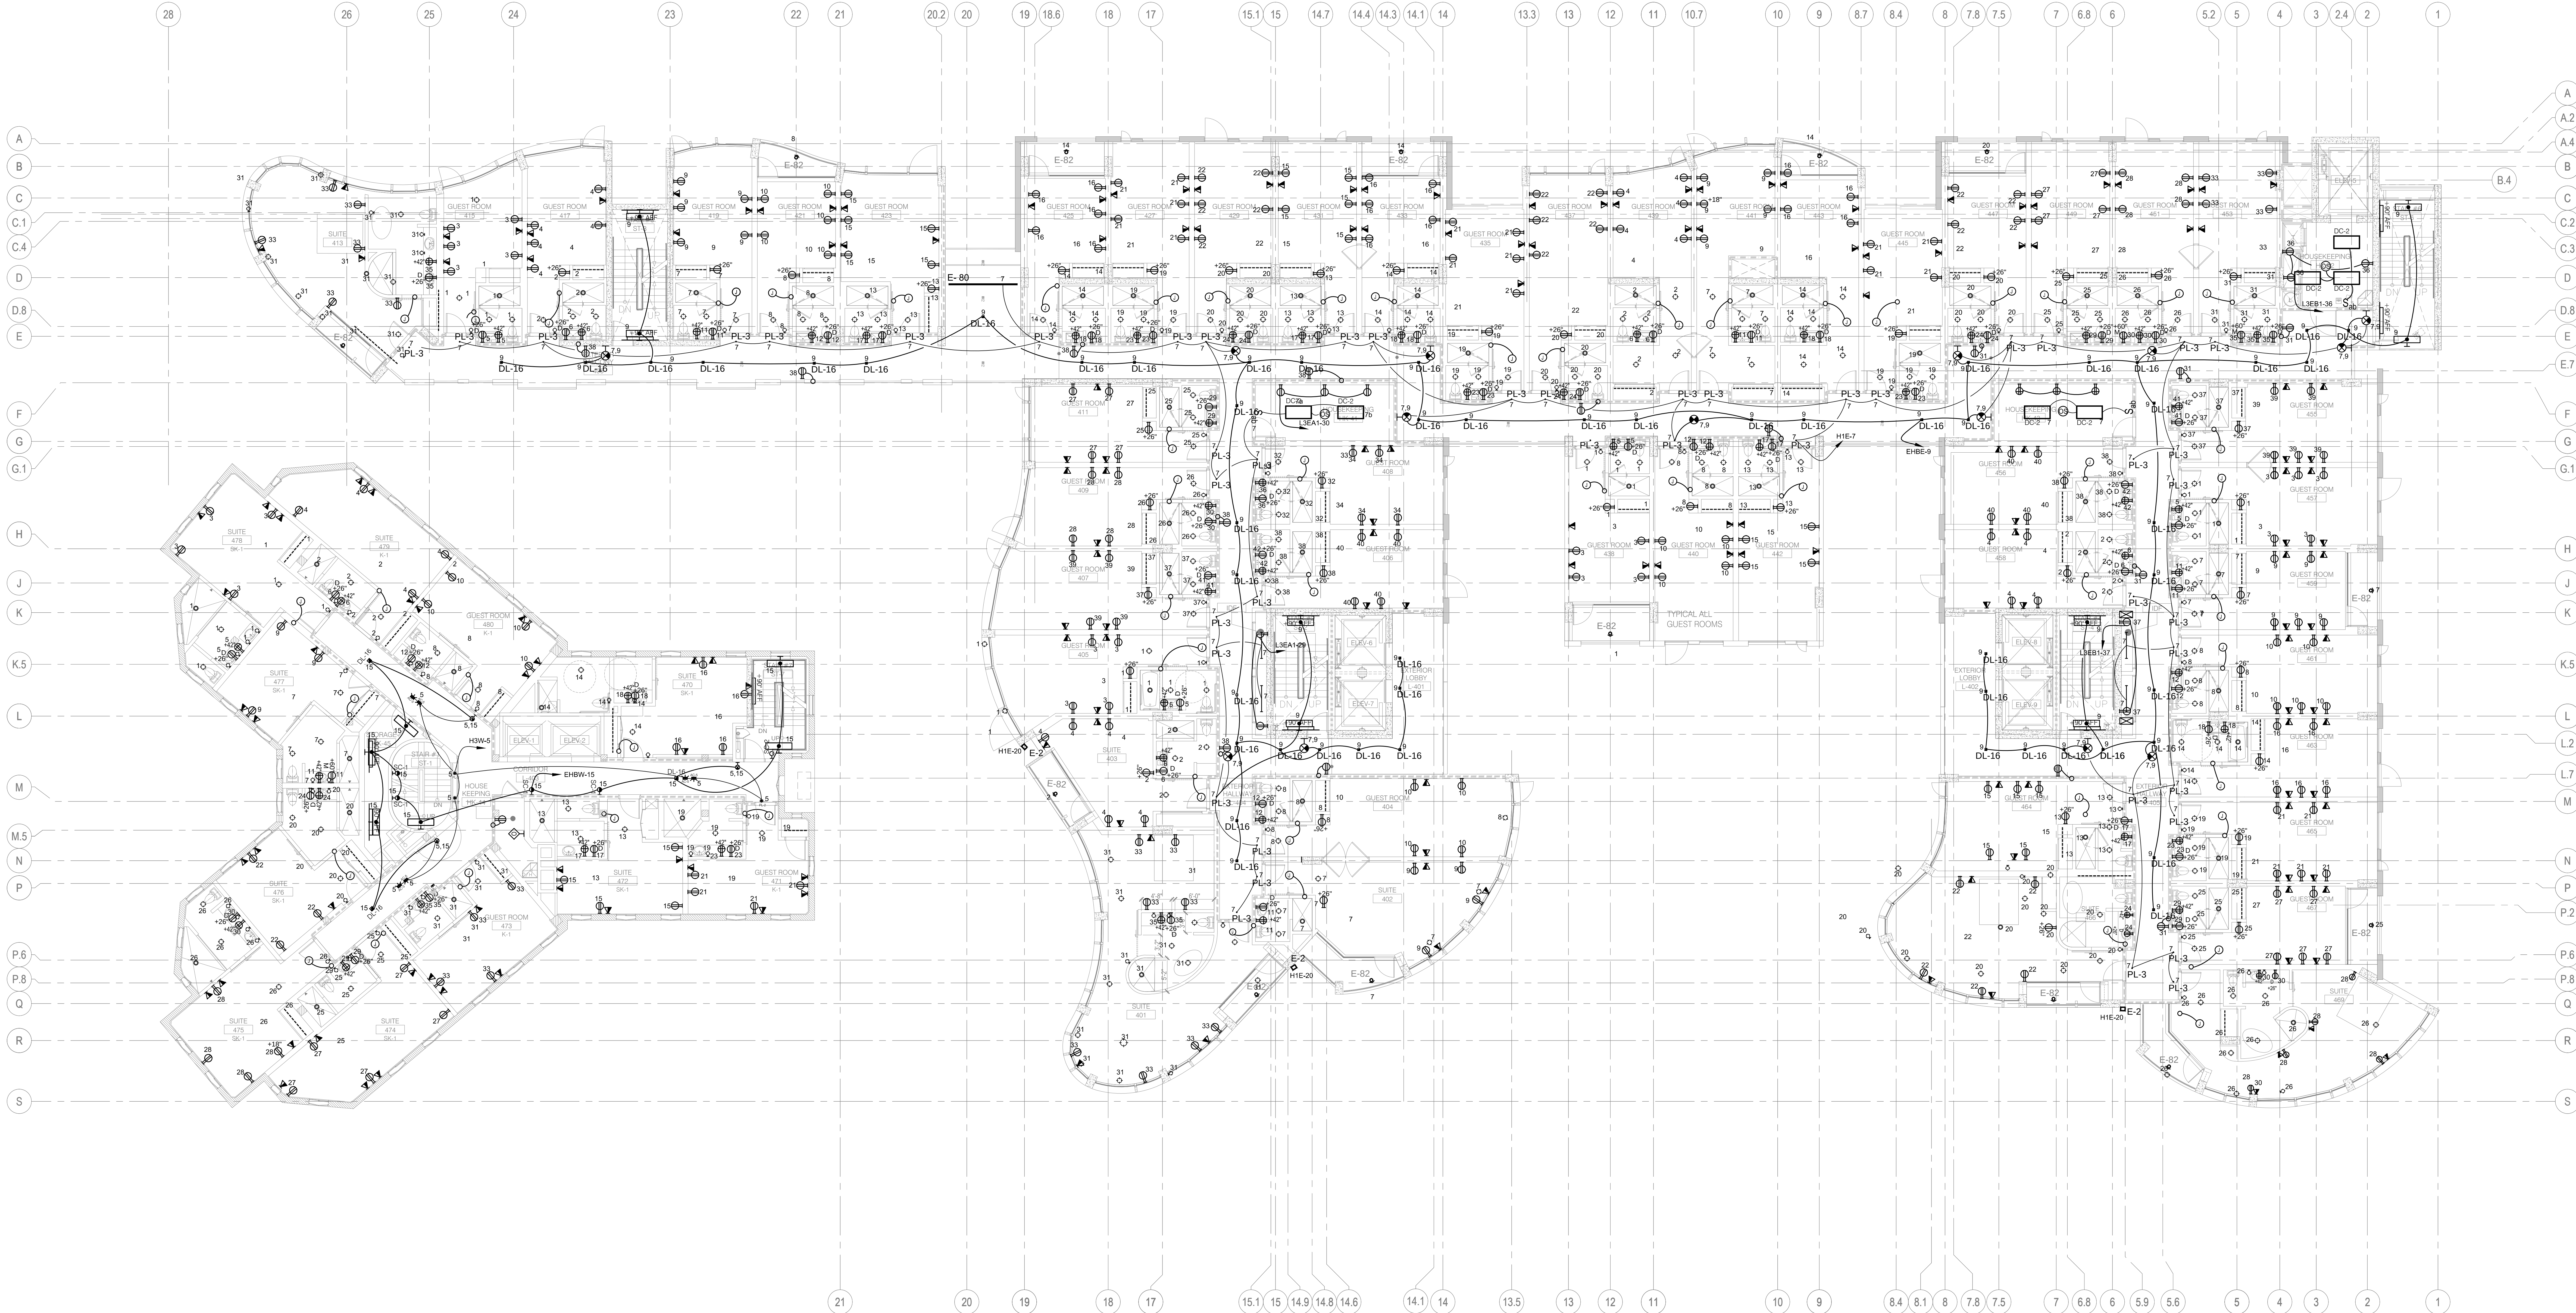

howard laks architects
1545 hollywood street
santa monica, ca 90401
voice : 310-393-4465
fax : 310-393-2230

CONSULTANTS
Donald F. Dickerson Associates
CONSULTING MECHANICAL & ELECTRICAL ENGINEERS
1400 WILSHIRE BLVD., SUITE 404
SANTA MONICA, CA 90401
TEL: 310-393-4465
FAX: 310-393-2230
E-MAIL: DONALD@DLA.COM
JOB NO. 201225

710 WILSHIRE BOULEVARD
MIXED-USE HOTEL PROJECT
SANTA MONICA - CALIFORNIA, 90401
FOURTH FLOOR PLAN

DRAWN	--
CHECKED	--
APPROVED	--
SCALE	1/8" = 1'-0"
SHEET	E-210
DATE	June 25, 2013
PROJECT NUMBER	HLA 0000000-00000