


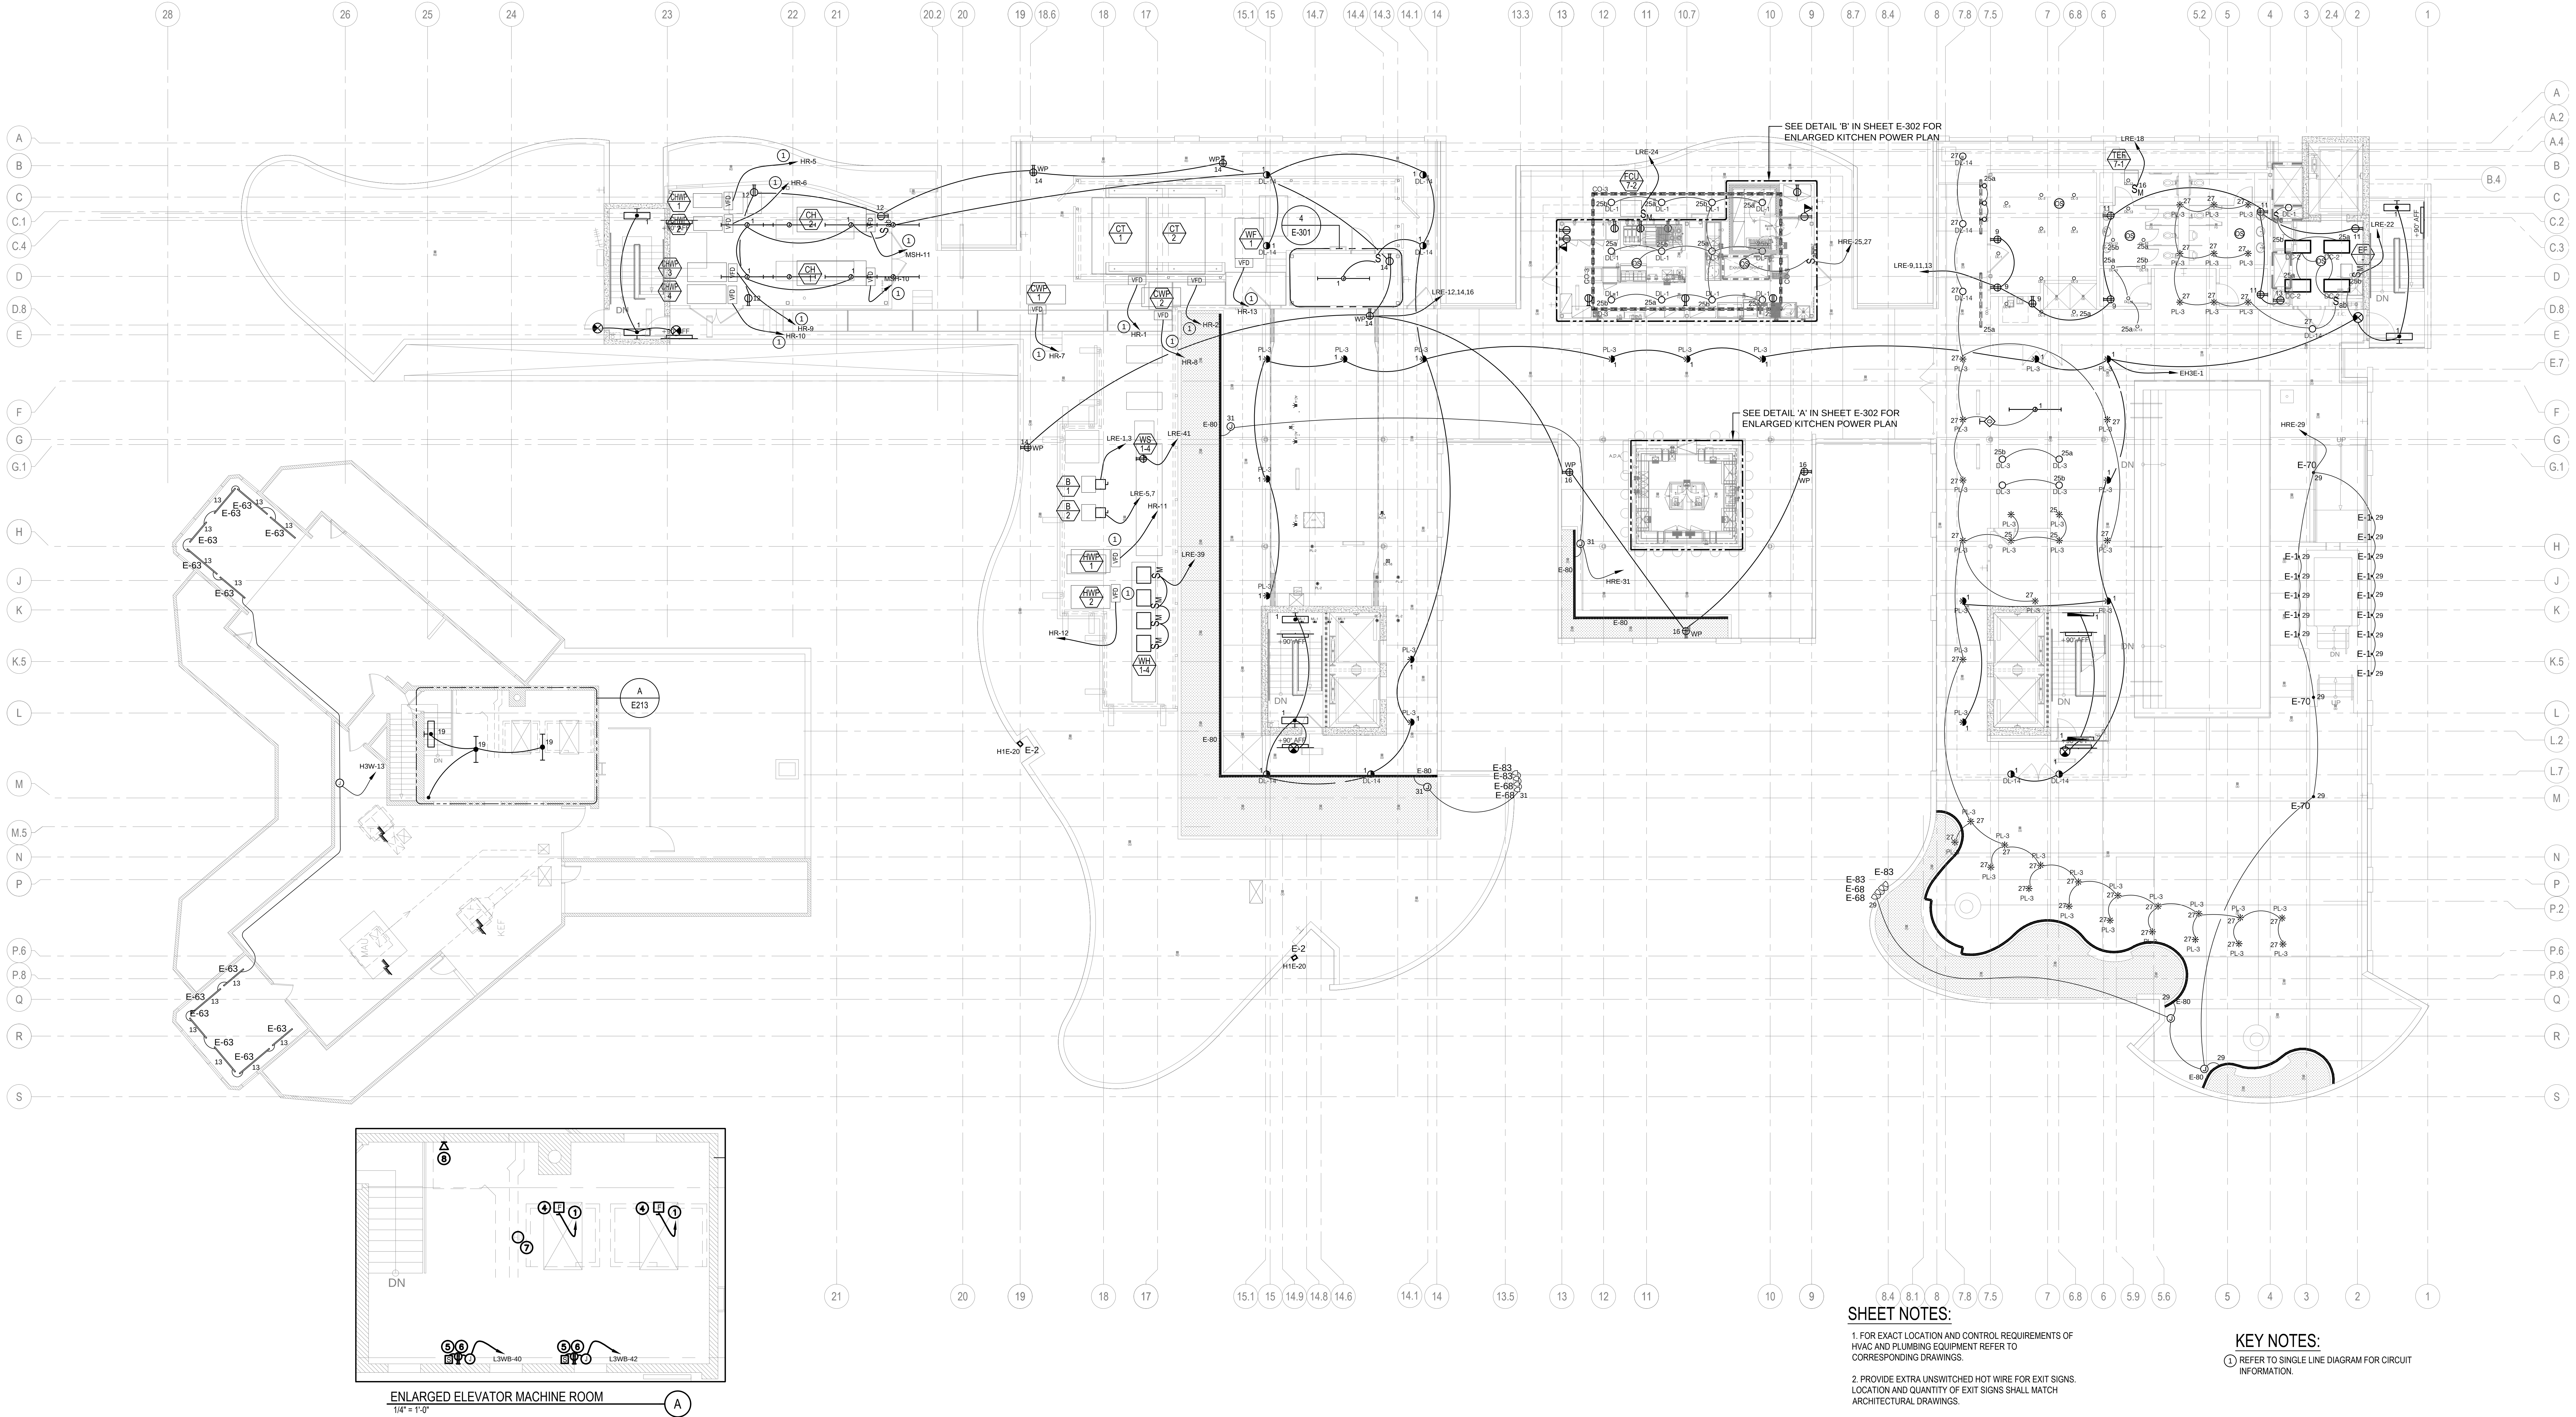

SHEET NOTES:

1. FOR EXACT LOCATION AND CONTROL REQUIREMENTS OF HVAC AND PLUMBING EQUIPMENT REFER TO CORRESPONDING DRAWINGS.
2. PROVIDE EXTRA UNSWITCHED HOT WIRE FOR EXIT SIGNS. LOCATION AND QUANTITY OF EXIT SIGNS SHALL MATCH ARCHITECTURAL DRAWINGS.
3. EXTERIOR LIGHTING SHALL BE CONTROLLED BY A TIMECLOCK AND PHOTOCELL.
4. PROVIDE GFCI PROTECTION TO LIGHTING OUTLETS INSTALLED IN THE AREA EXTENDING BETWEEN 5FT AND 10FT HORIZONTALLY FROM THE INSIDE WALLS OF POOL.

KEY NOTES:


- 1 REFER TO SINGLE LINE DIAGRAM FOR CIRCUIT INFORMATION.

DATE	DESCRIPTION
05/07/2015	Medium 02
06/04/2015	Medium 03
10/20/2015	Medium 04
05/27/2016	Medium 05



howard laks architects
1545 hewlett street
santa monica, ca 90401
voice : 310-393-4465
fax : 310-393-2230

CONSULTANTS
Donald F. Dickerson Associates
CONSULTING MECHANICAL & ELECTRICAL ENGINEERS
1700 ALVARADO STREET, SUITE 404
SANTA MONICA, CA 90401
(310) 393-9868
E-MAIL: ddickerson@dfda.com

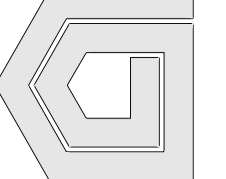

710 WILSHIRE BOULEVARD
MIXED-USE HOTEL PROJECT
SANTA MONICA - CALIFORNIA, 90401
SEVENTH FLOOR PLAN

DRAWN	--
CHECKED	--
APPROVED	--
SCALE	1/8" = 1'-0"
SHEET	E-213
DATE	June 25, 2013
PROJECT NUMBER	HLA 0000000-00000