



GROUND LEVEL - BANQUET

Scale
1/4" = 1'-0"

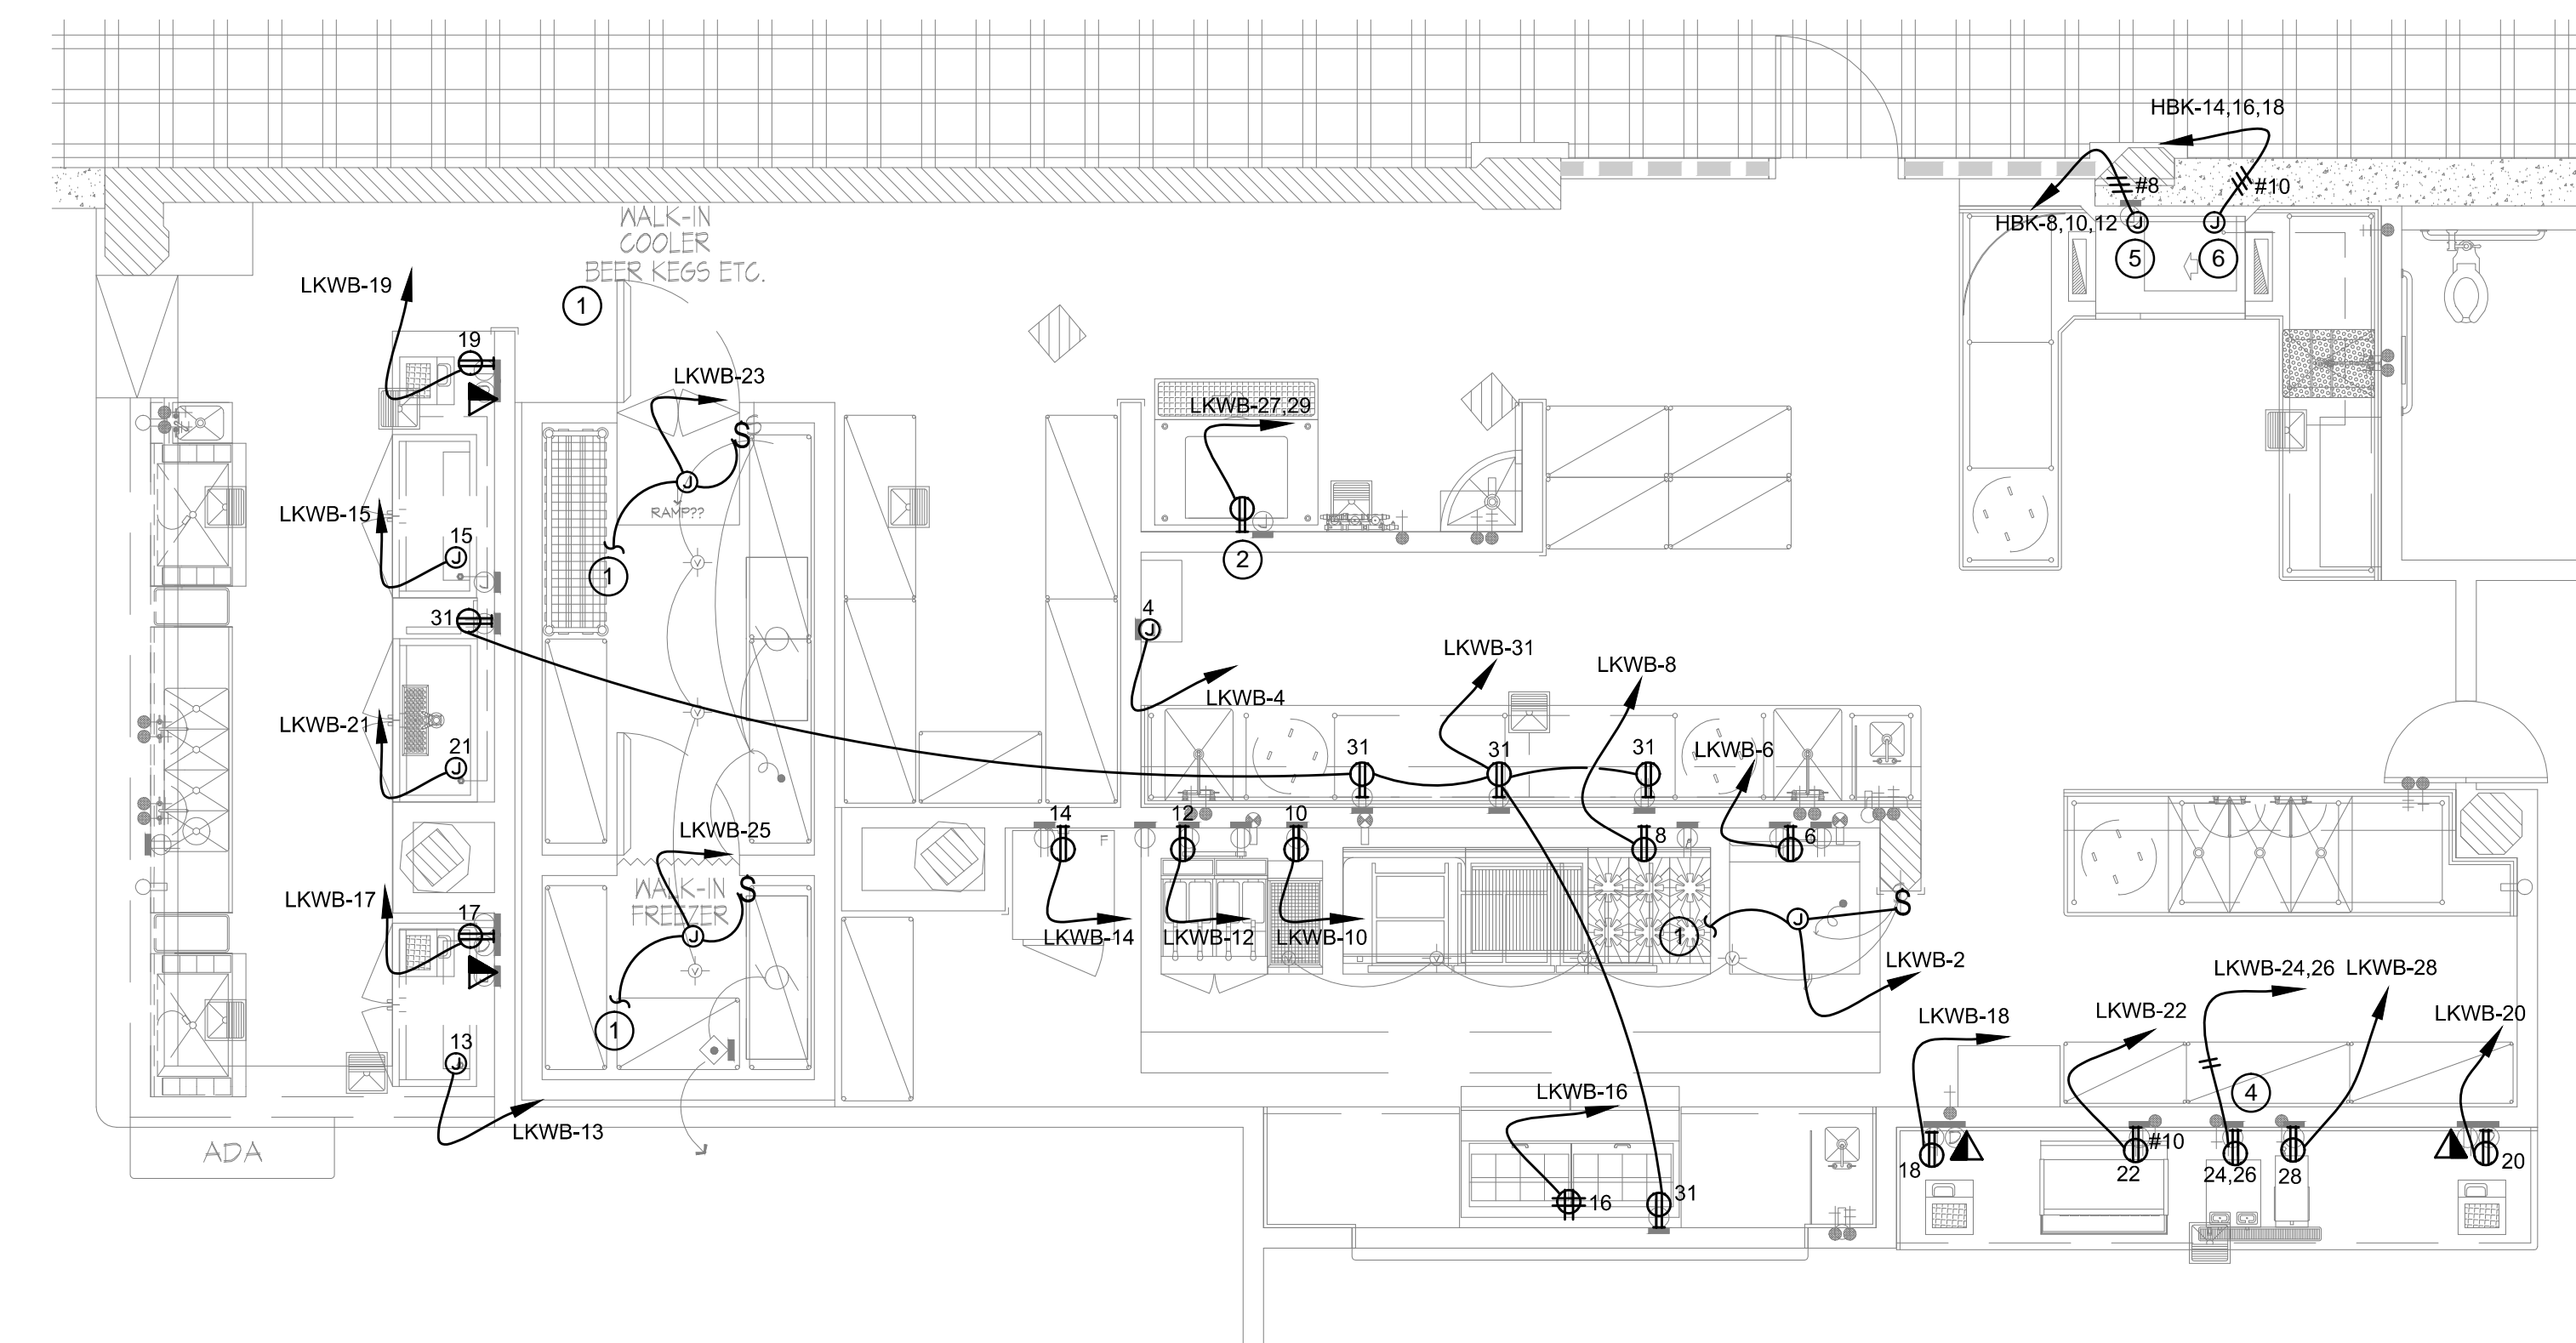


GROUND LEVEL - RESTAURANT 'A'

Scale
1/4" = 1'-0"

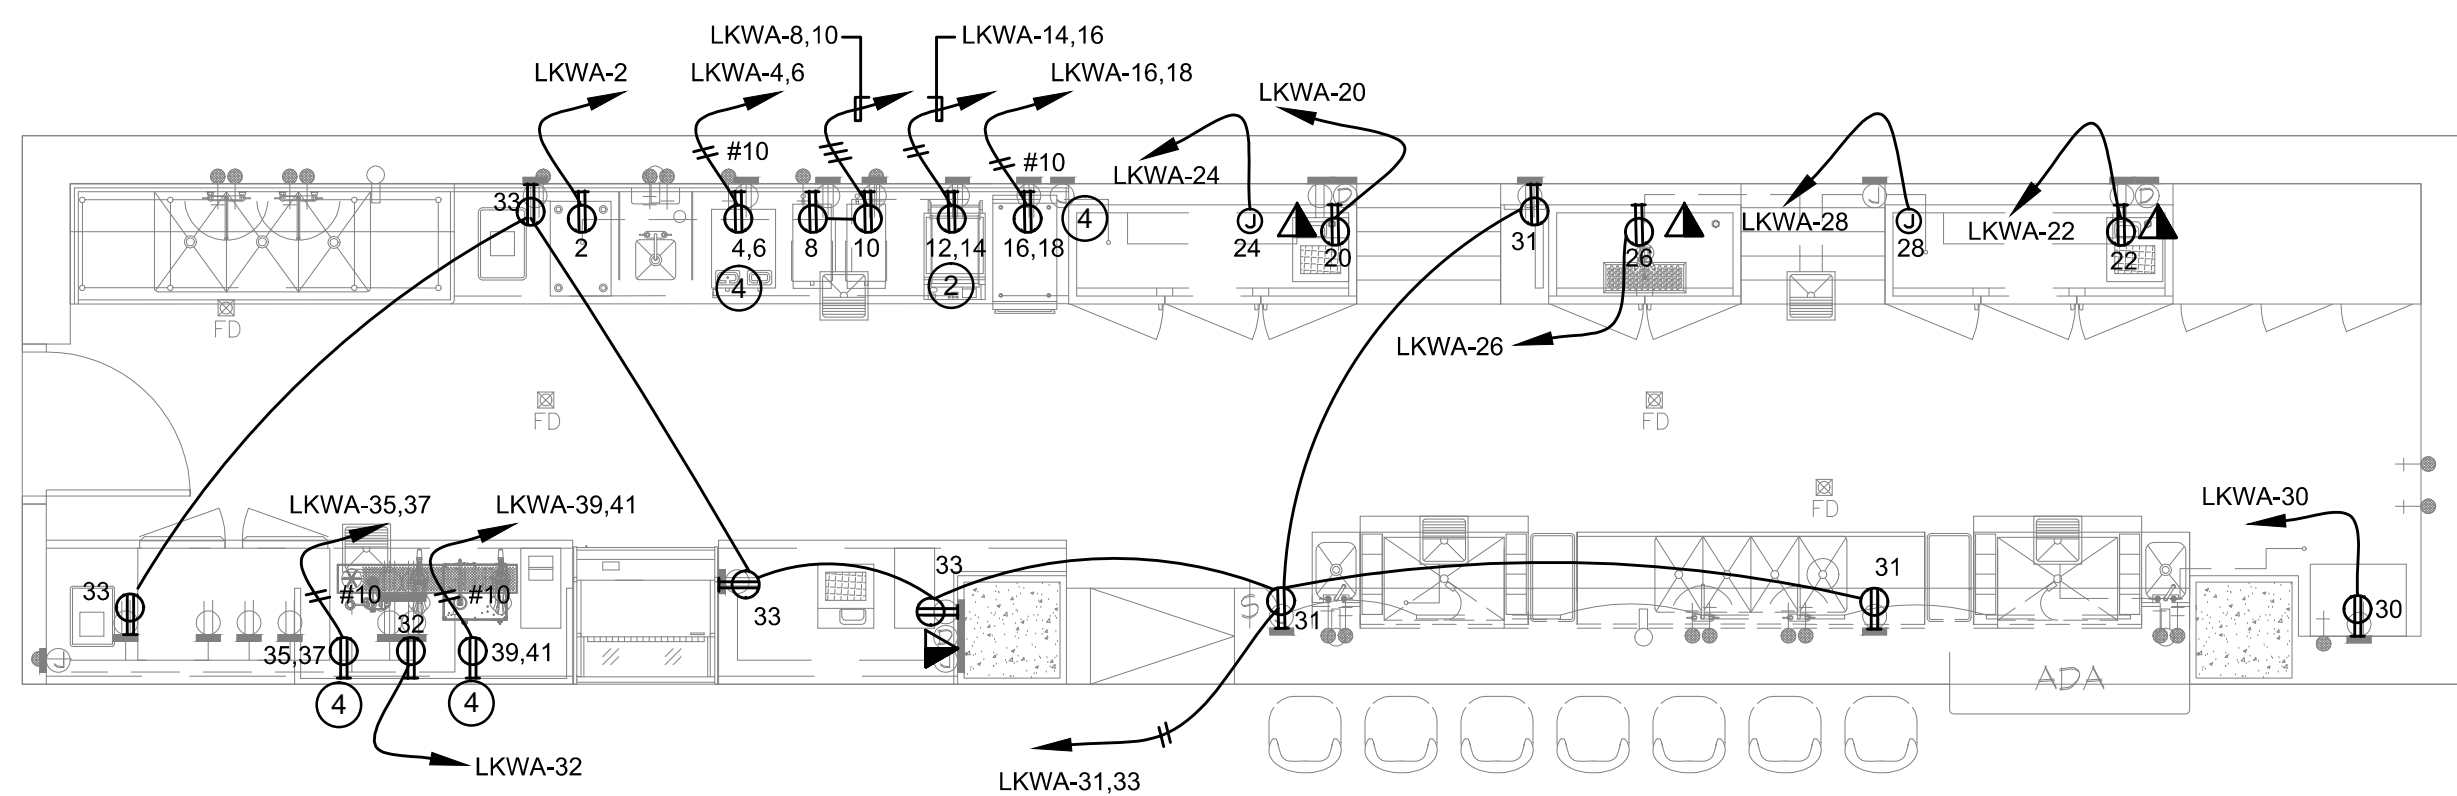


GROUND LEVEL - BAR/GRAB-N-GO

Scale
1/4" = 1'-0"

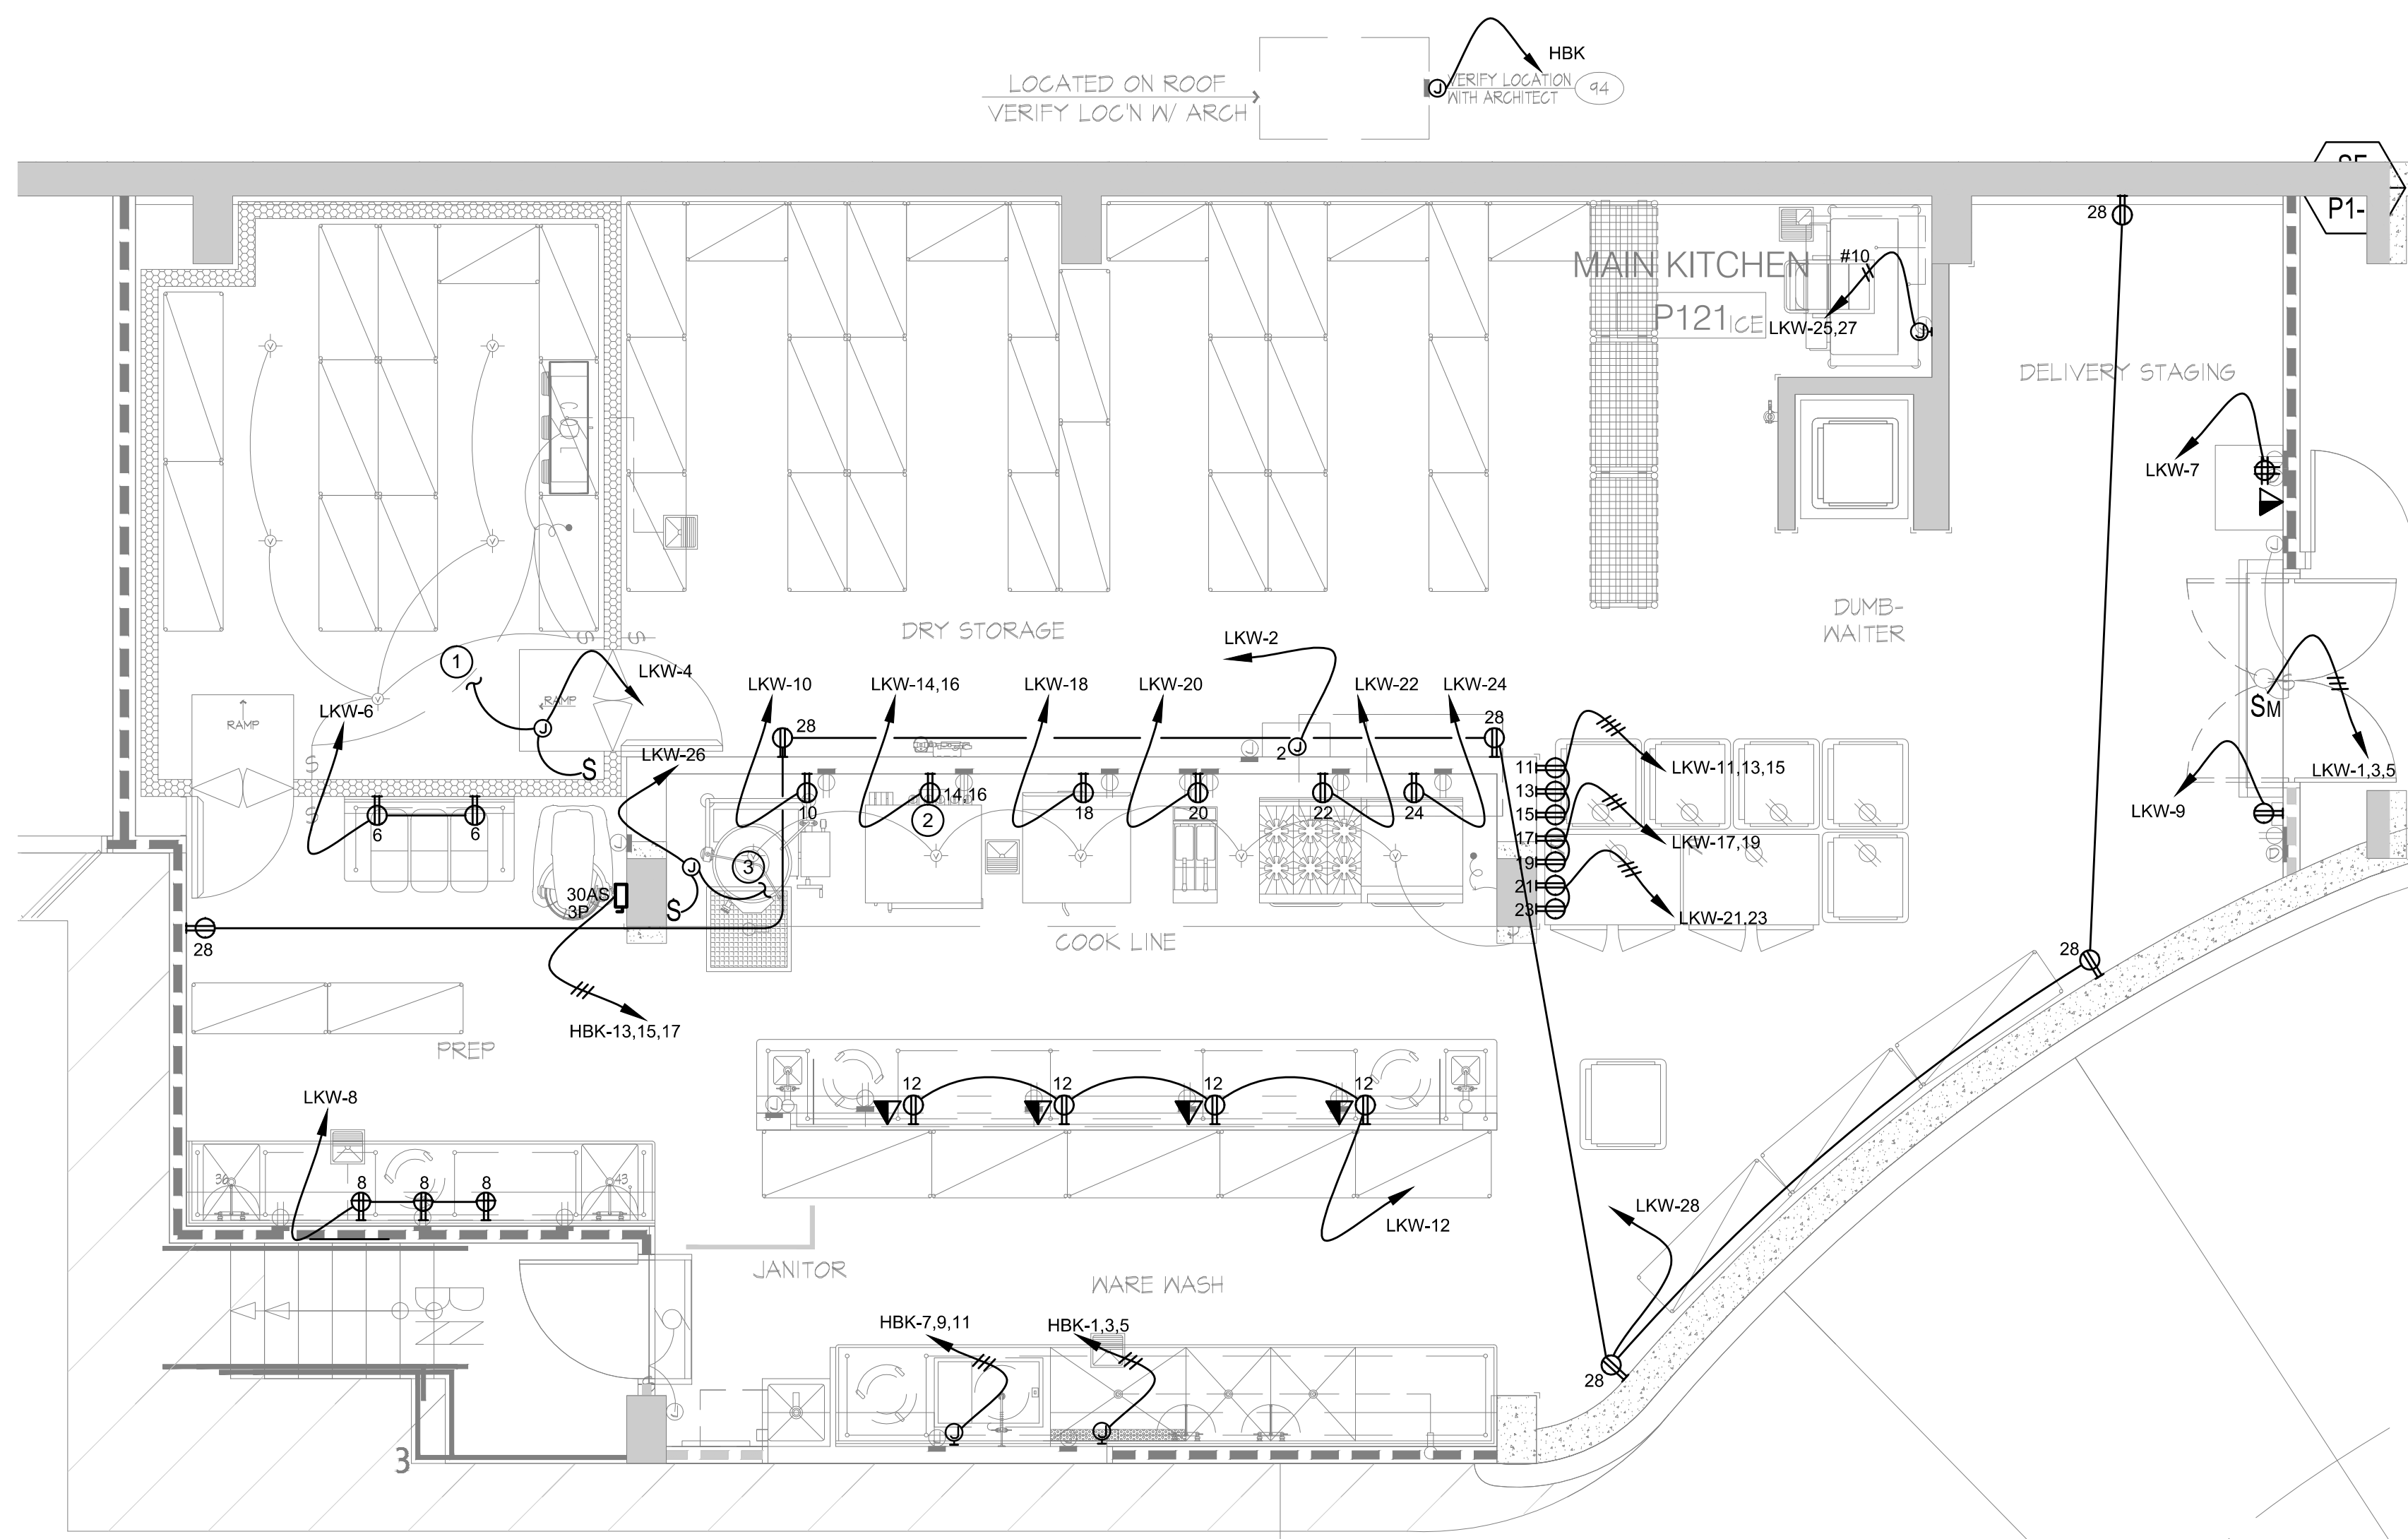


LEVEL P1 - MAIN KITCHEN

Scale
1/4" = 1'-0"

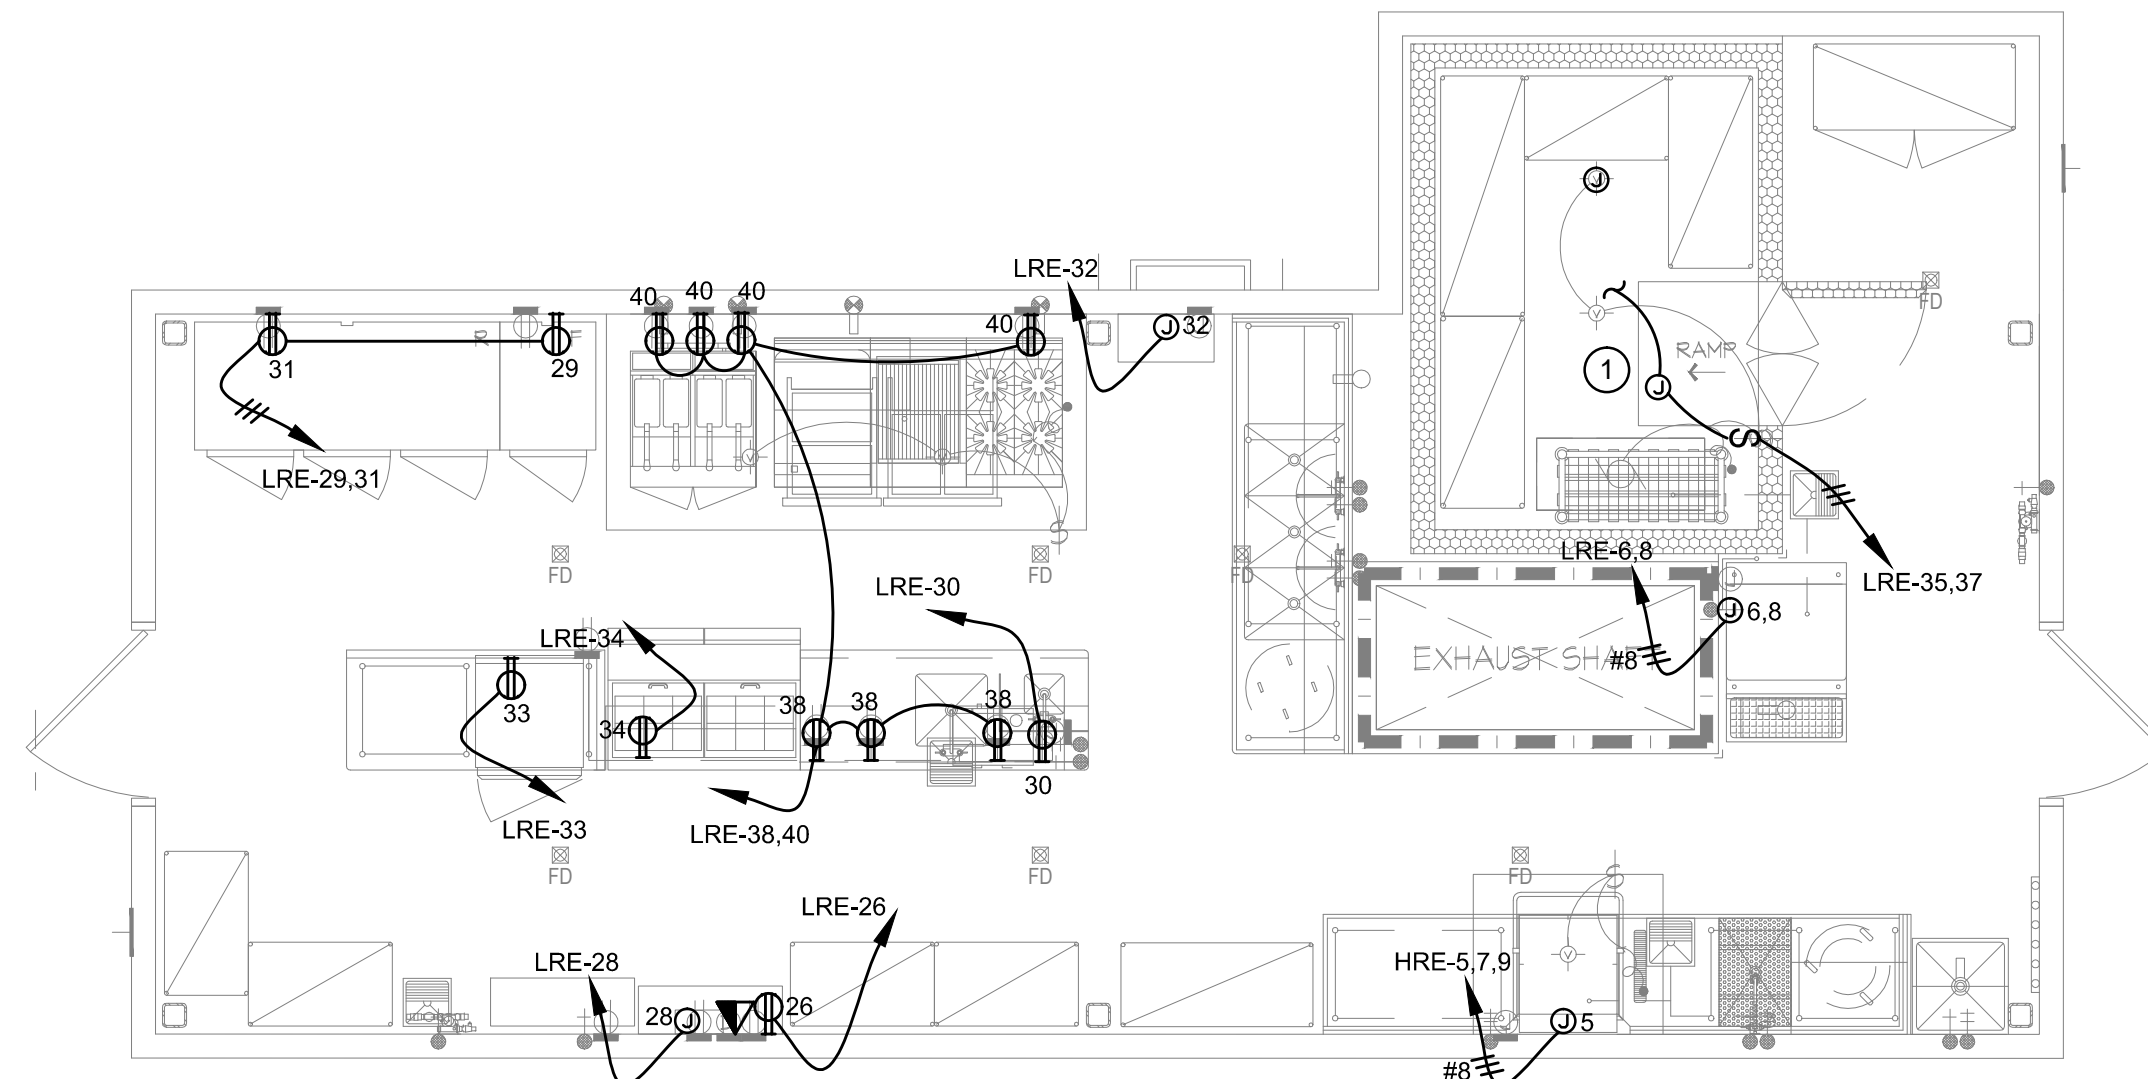


ROOF TERRACE - KITCHEN

Scale
1/4" = 1'-0"

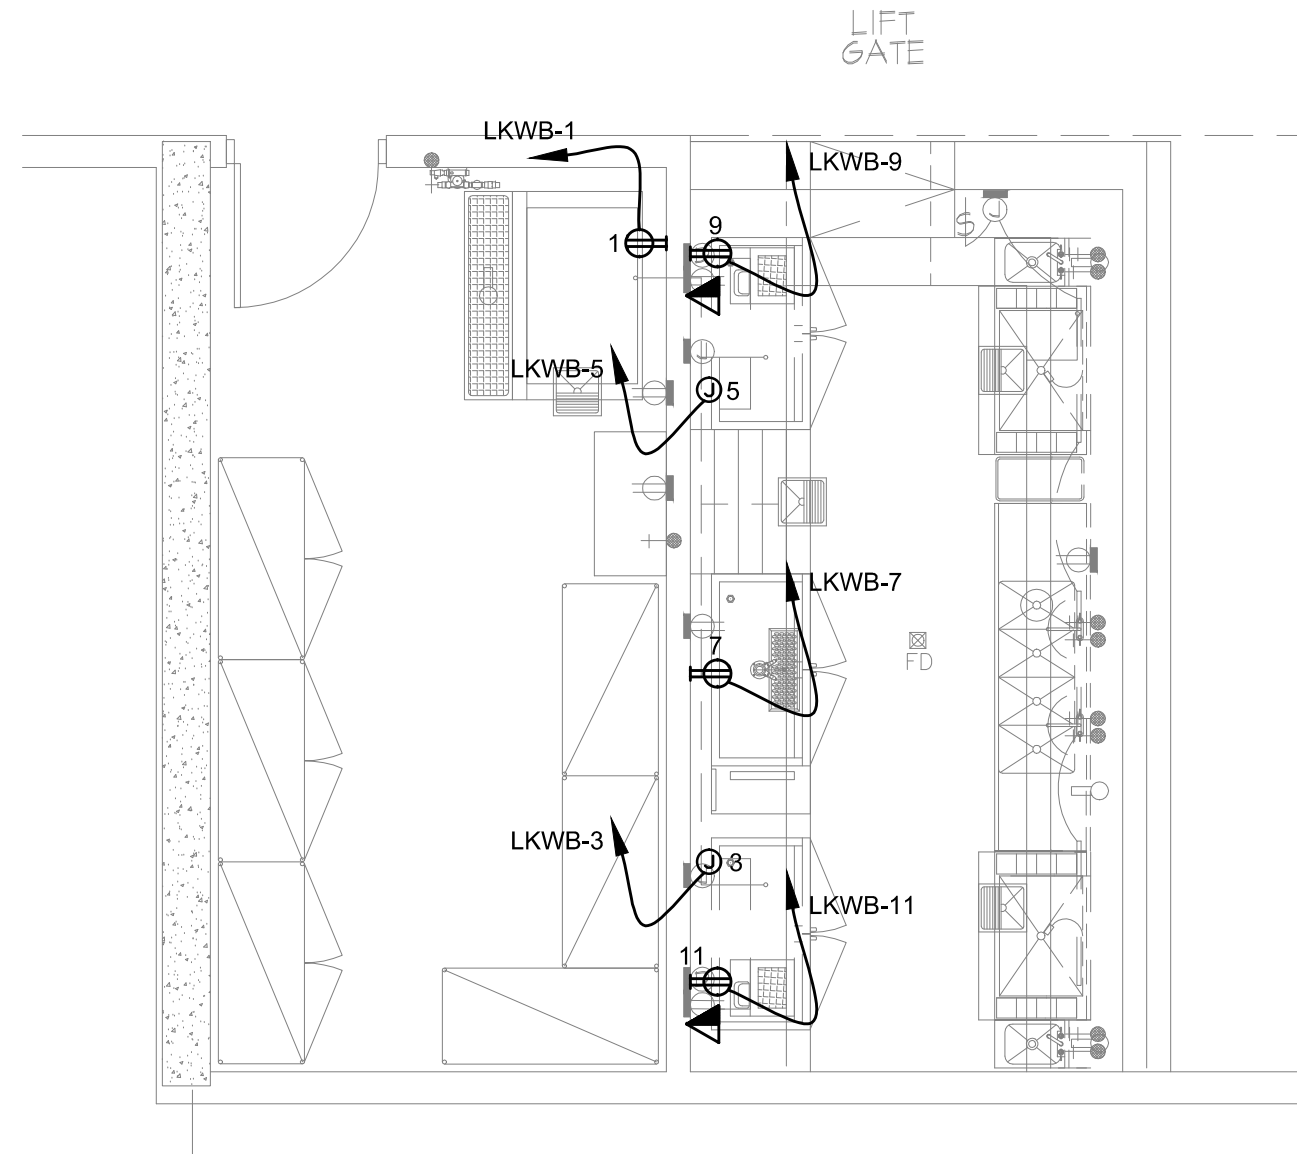

GROUND LEVEL - BAR

Scale
1/4" = 1'-0"

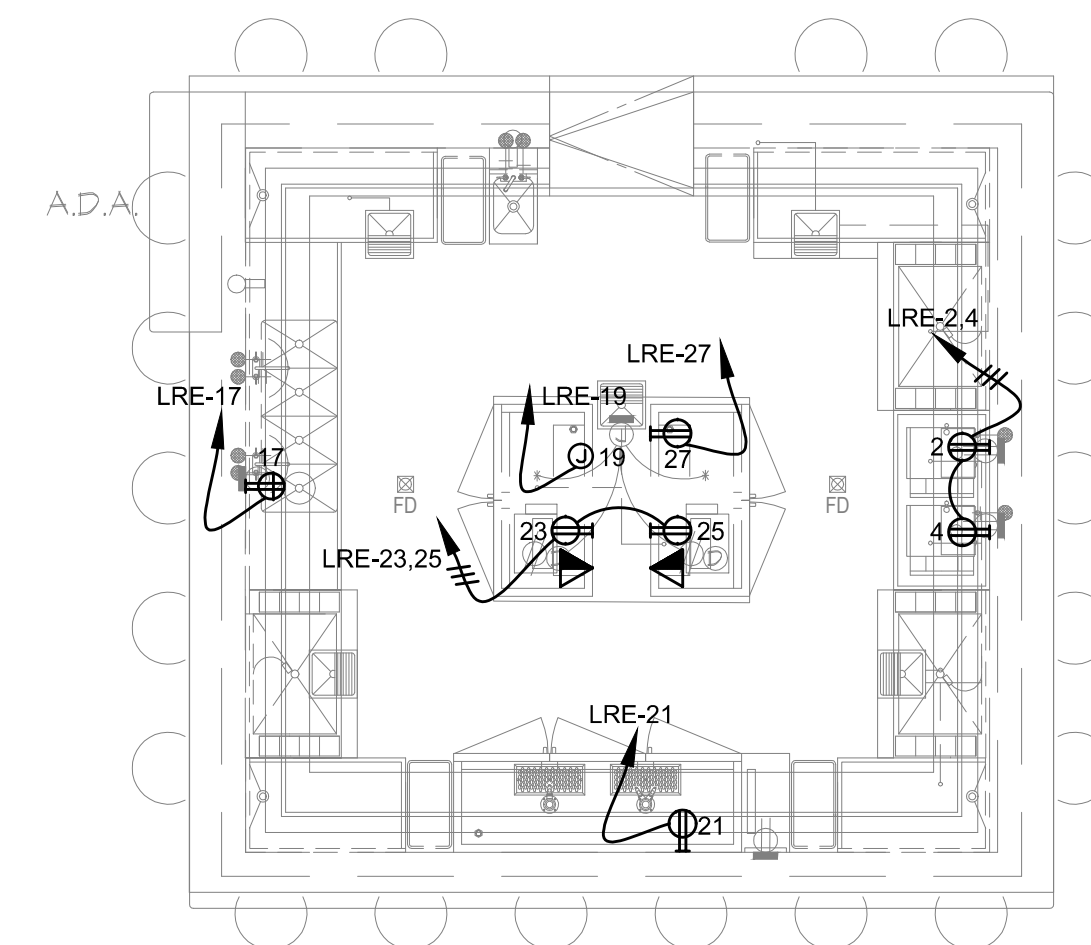

ROOF TERRACE - COCKTAIL BAR

Scale
1/4" = 1'-0"

SHEET NOTES:

- 1 TO WALK-IN COOLER/FREEZER LIGHTING FIXTURES. COORDINATE WITH MANUFACTURER FOR EXACT REQUIREMENTS.
- 2 NEMA 6-15R RECEPTACLE.
- 3 TO EXHAUST HOOD LIGHTING FIXTURES. COORDINATE WITH MANUFACTURER FOR EXACT REQUIREMENTS.
- 4 NEMA 6-30R RECEPTACLE.
- 5 J-BOX FOR CONNECTION TO DISH MACHINE. COORDINATE EXACT WIRING REQUIREMENTS WITH MANUFACTURER.
- 6 J-BOX FOR CONNECTION TO BOOSTER HEATER. COORDINATE EXACT WIRING REQUIREMENTS WITH MANUFACTURER.

REVISION	DATE	DESCRIPTION
1	05/07/2015	MECHANICAL
2	08/04/2015	MECHANICAL
3	10/20/2015	MECHANICAL
4	05/27/2016	MECHANICAL



howard laks architects
1545 nellth street
santa monica, ca 90401
voice : 310-393-4465
fax : 310-393-2230

CONSULTANTS

Donald F. Dickerson Associates
CONSULTING MECHANICAL & ELECTRICAL ENGINEERS
1400 MAIN STREET, SUITE 404
SANTA MONICA, CA 90401
TEL: 310-393-2230
E-MAIL: DICKERSON@GMAIL.COM
JOB NO. 201225

710 WILSHIRE BOULEVARD
MIXED-USE HOTEL PROJECT
SANTA MONICA - CALIFORNIA, 90401
ENLARGED KITCHEN POWER PLANS

DRAWN	---
CHECKED	---
APPROVED	---
SCALE	AS SHOWN
SHEET	E-302
DATE	June 25, 2013
PROJECT NUMBER	H/A 0000000-00000