


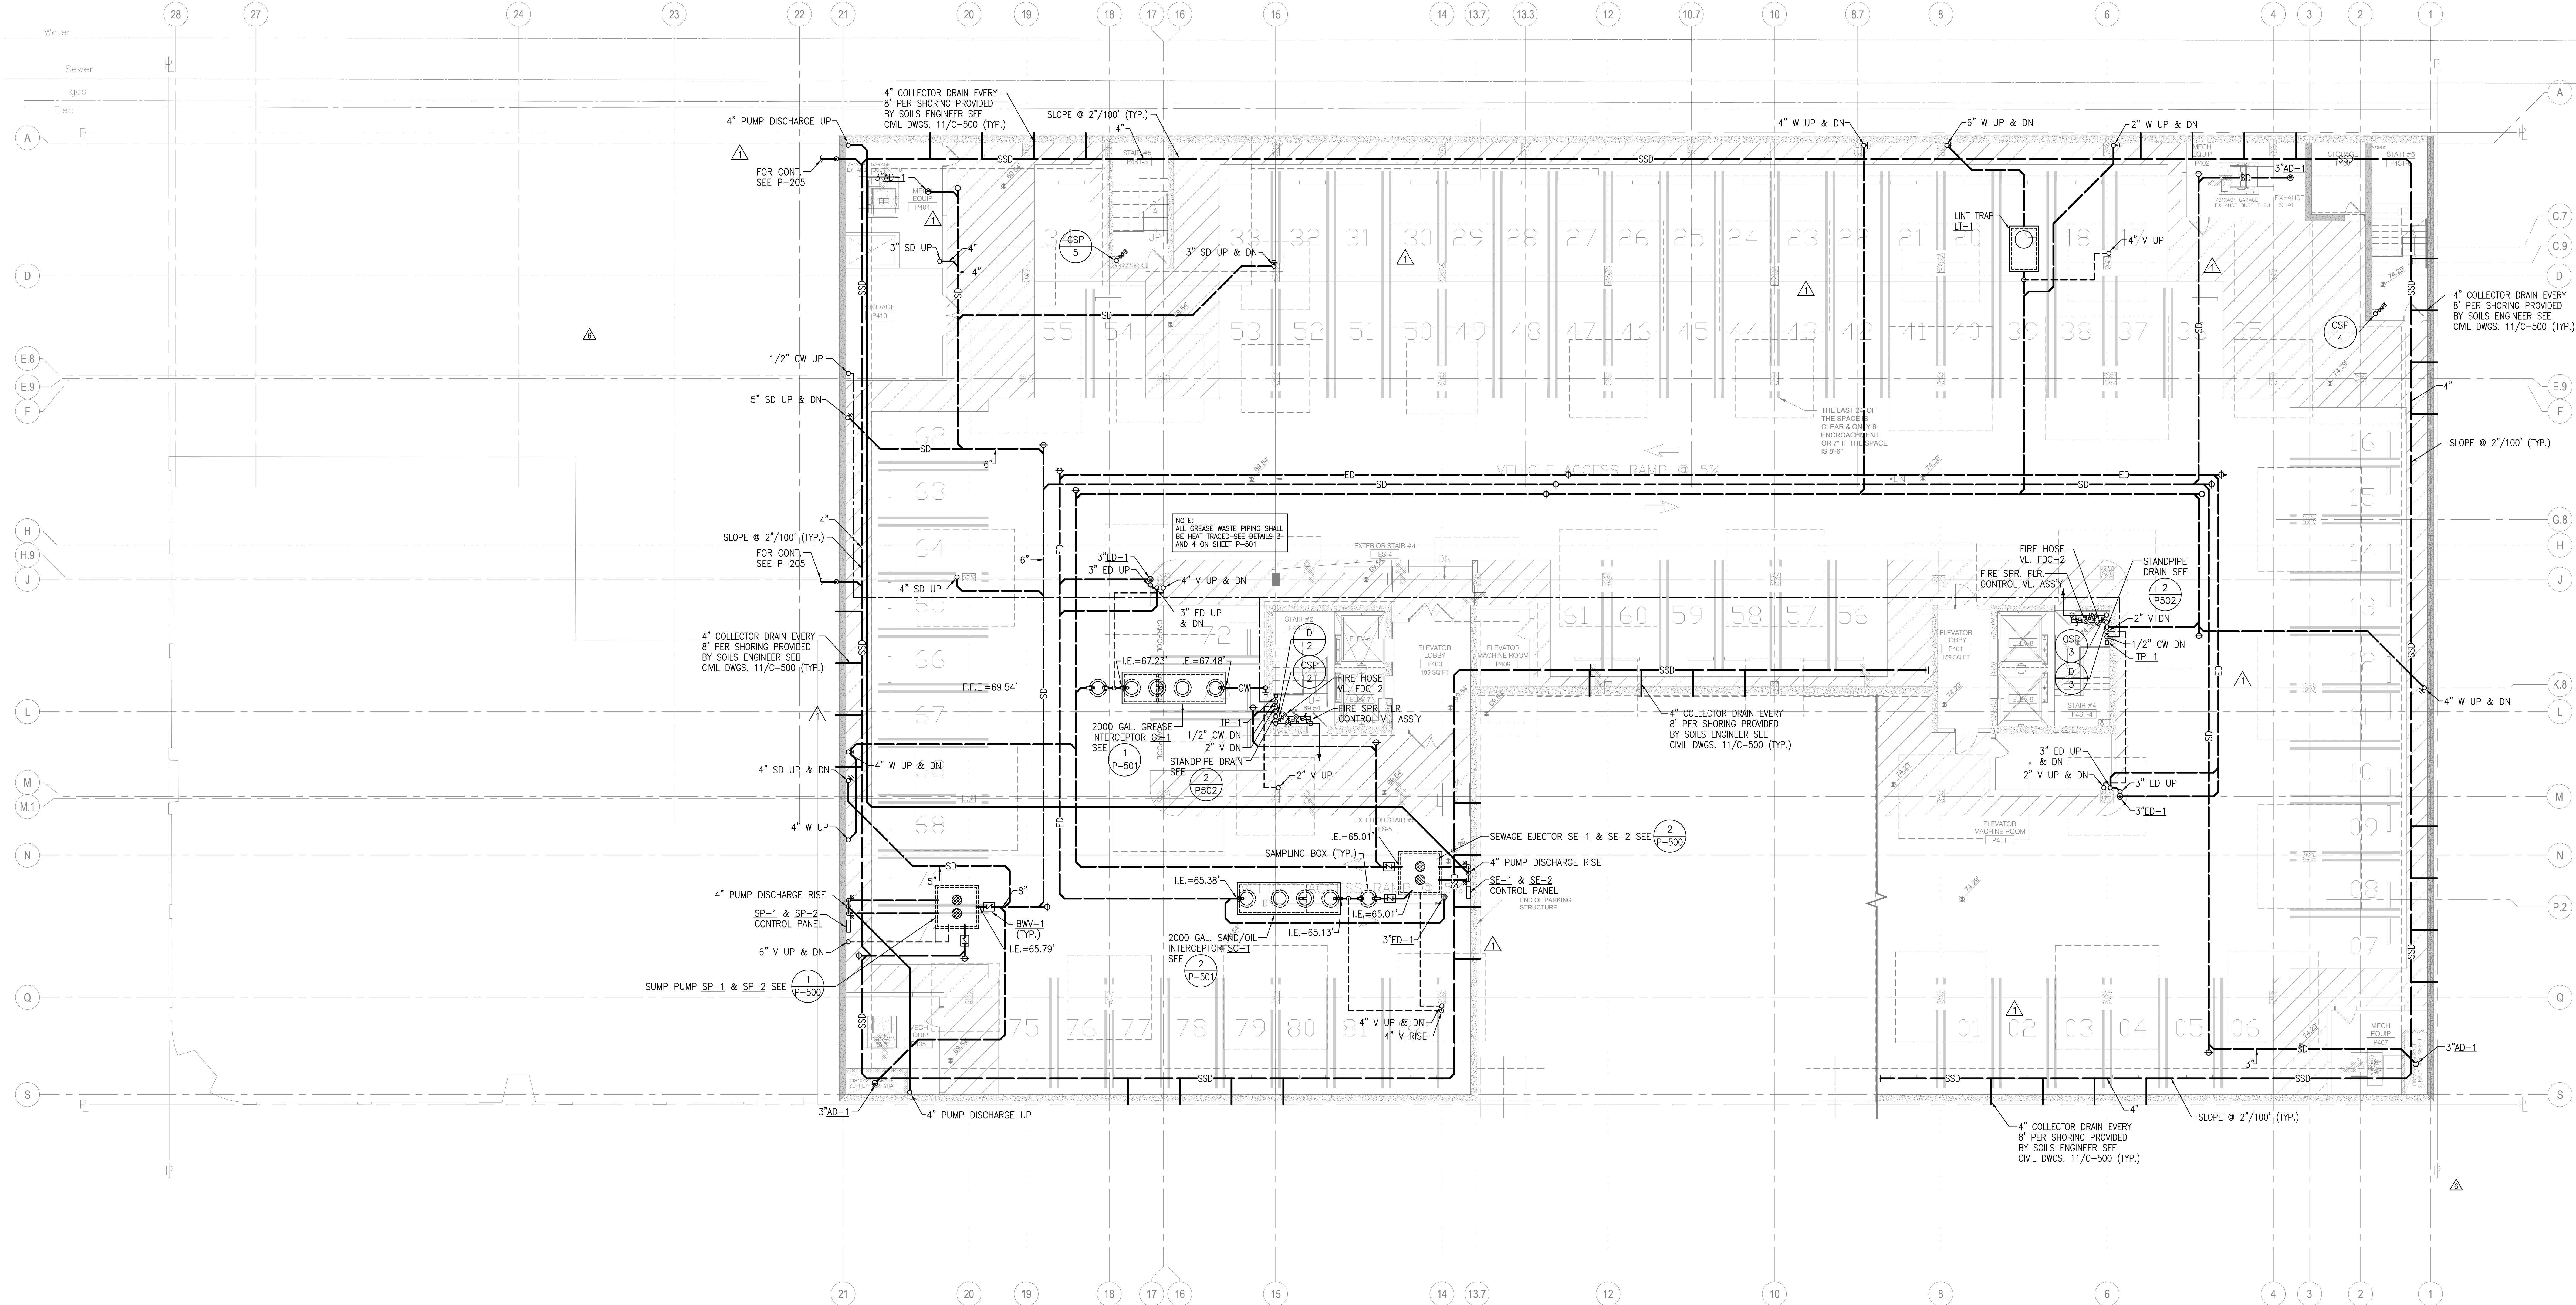

hla howard laks architects	CONSULTANTS	710 WILSHIRE BOULEVARD MIXED-USE HOTEL PROJECT SANTA MONICA - CALIFORNIA 90401 PARKING FLOOR PLAN - P4
	Donald F. Diskin, President CONSULTING MECHANICAL & ELECTRICAL ENGINEERS 1700 WILSHIRE BLVD., SUITE 404 SANTA MONICA, CA 90401 (310) 393-4465 FAX (310) 393-4468 E-MAIL: DONALD@HLSA.COM	
	JOB NO. 201225	
	voice : 310-393-4465	
	fax : 310-393-2230	
DATE: 06/25/2013 REVISION: 06/25/2013 06/25/2013 06/25/2013 06/25/2013	DRAWN: AH/SC CHECKED: HLA APPROVED: - SCALE: 1/8" = 1'-0" SHEET: P-202 DATE: June 25, 2013 PROJECT NUMBER: HLA 0000000-00000	