


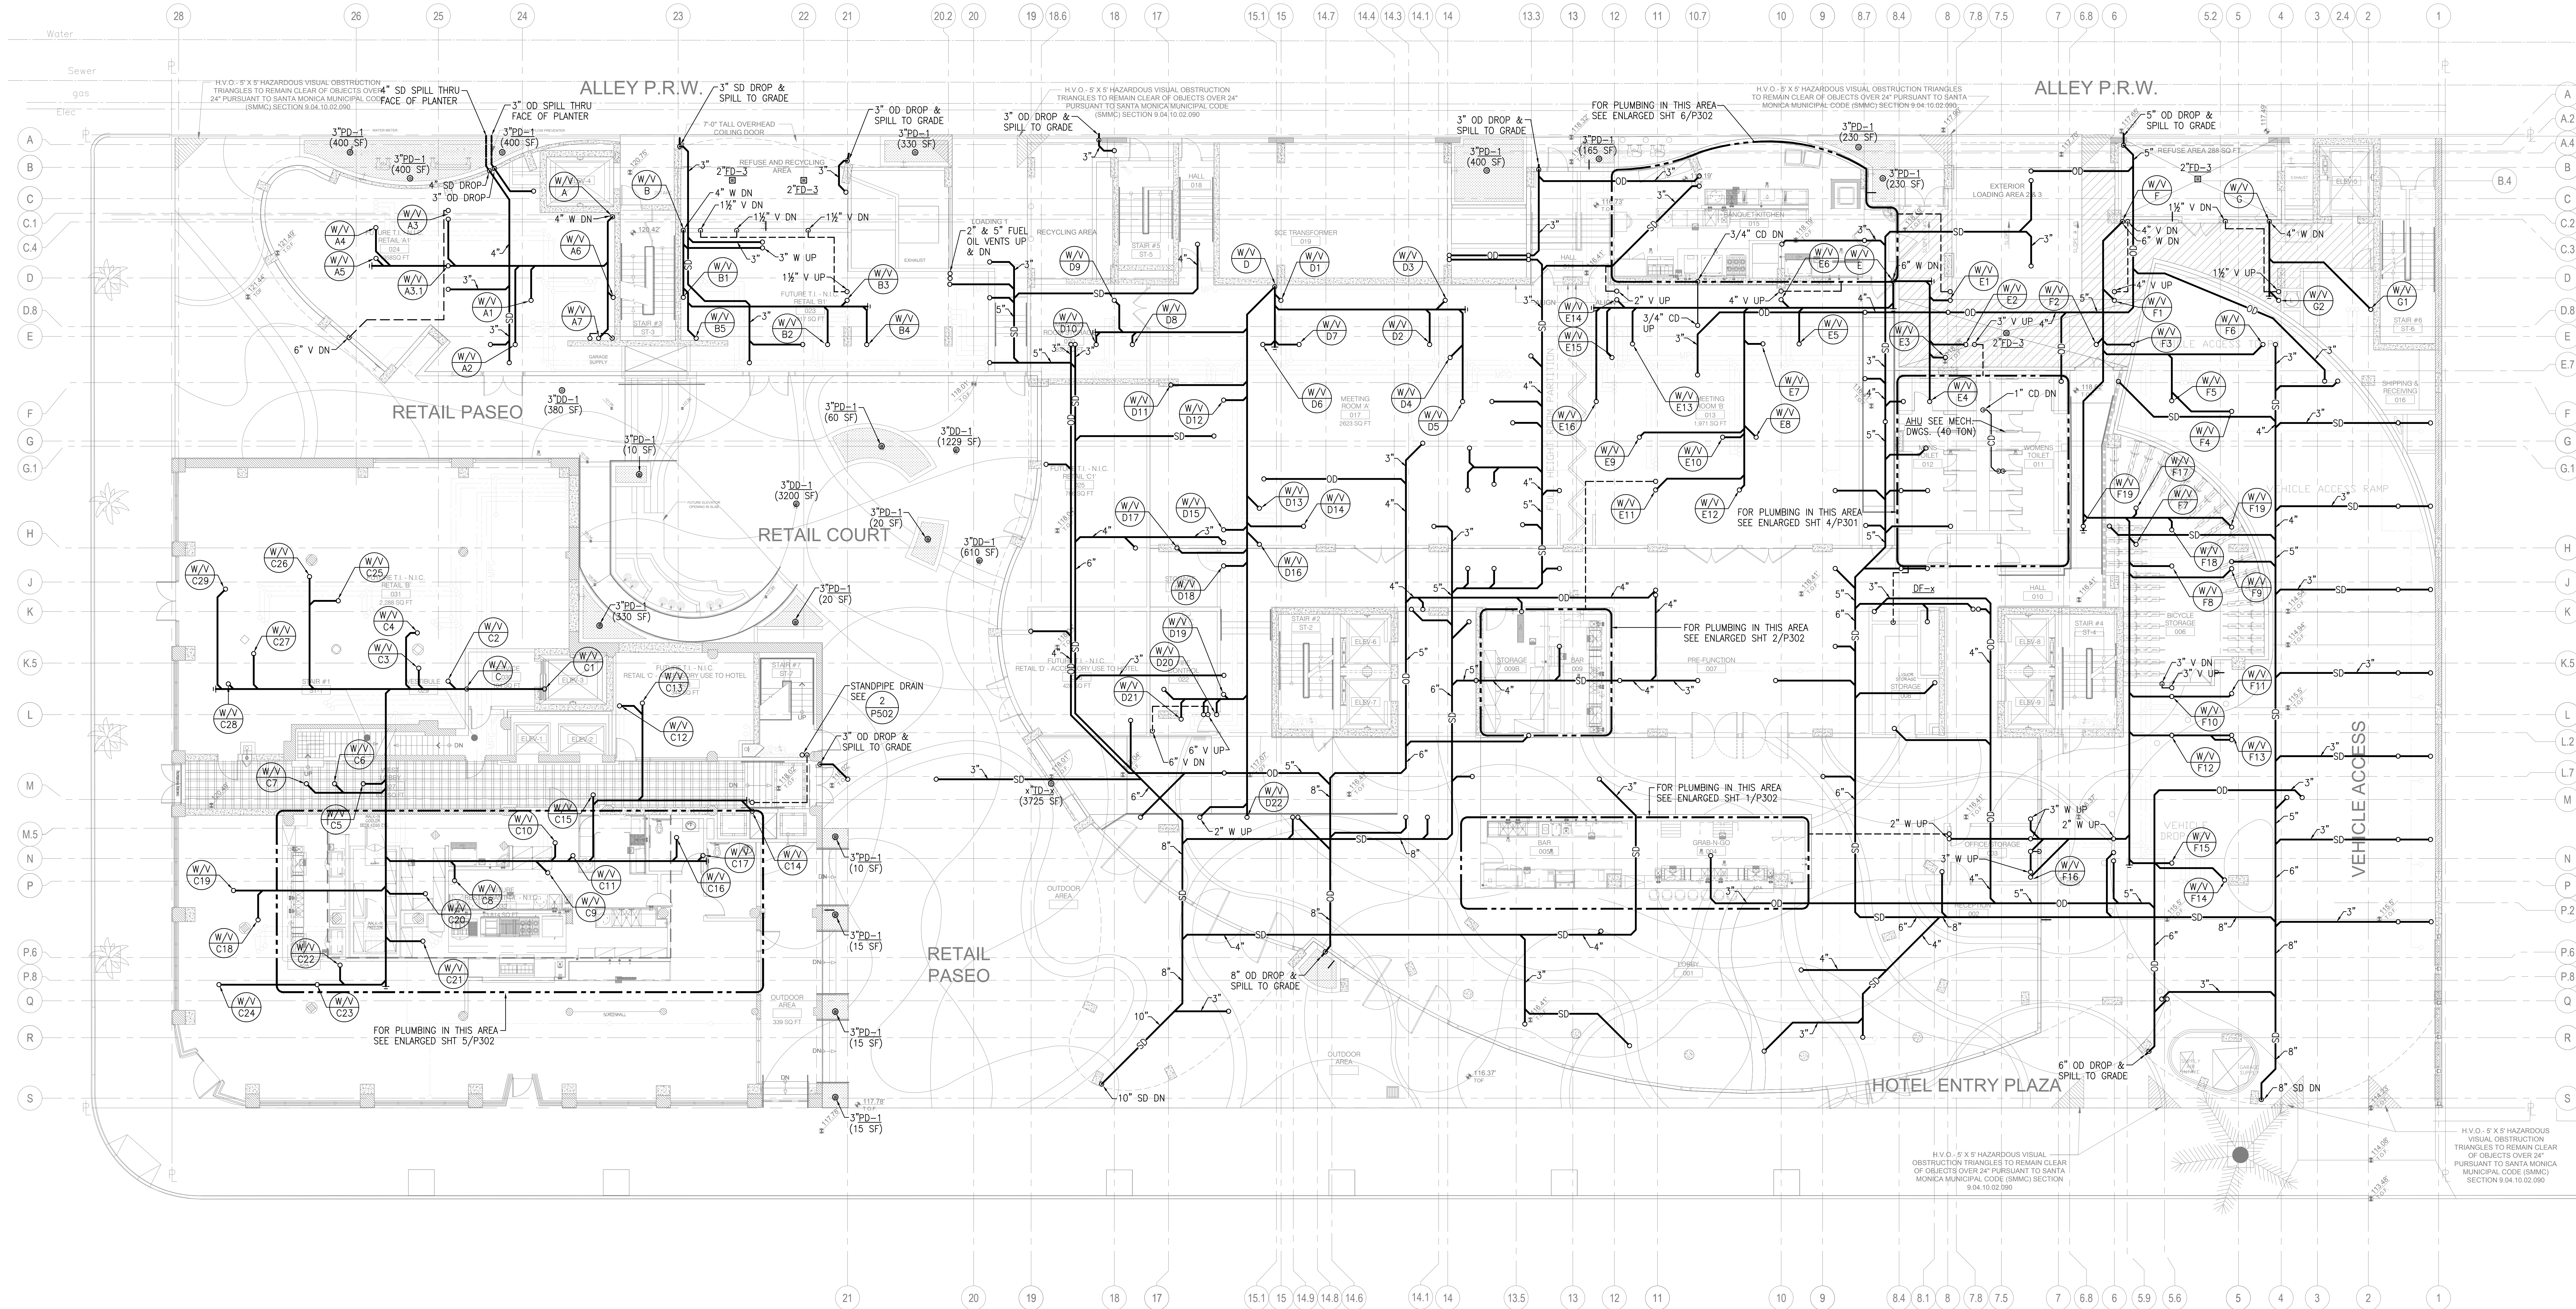

710 WILSHIRE BOULEVARD
MIXED-USE HOTEL PROJECT
SANTA MONICA - CALIFORNIA 90401

GROUND FLOOR PLUMBING W&V AND SD FLOOR PLAN

DATE
June 25, 2013

PROJECT NUMBER
HLA 0000000-00000

DESIGN
HLA

CHECKED
HLA

APPROVED
HLA

SCALE
1/8" = 1'-0"

SHEET
P-207A

CONSULTANTS
Donald F. Dickerson Associates
CONSULTING MECHANICAL & ELECTRICAL ENGINEERS
12000 WILSHIRE BLVD., SUITE 404
SANTA MONICA, CA 90404
(310) 310-2222
E-MAIL: DONALD@DFDA.COM

DATE
05/07/2013
06/04/2013
10/20/2013
05/27/2016

REVISION
1
2
3
4

DESIGNER
HLA

PROJECT
710 WILSHIRE BOULEVARD
MIXED-USE HOTEL PROJECT
SANTA MONICA - CALIFORNIA 90401

DATE
05/07/2013
06/04/2013
10/20/2013
05/27/2016

REVISION
1
2
3
4

DESIGNER
HLA

PROJECT
710 WILSHIRE BOULEVARD
MIXED-USE HOTEL PROJECT
SANTA MONICA - CALIFORNIA 90401

DATE
05/07/2013
06/04/2013
10/20/2013
05/27/2016

REVISION
1
2
3
4

DESIGNER
HLA