


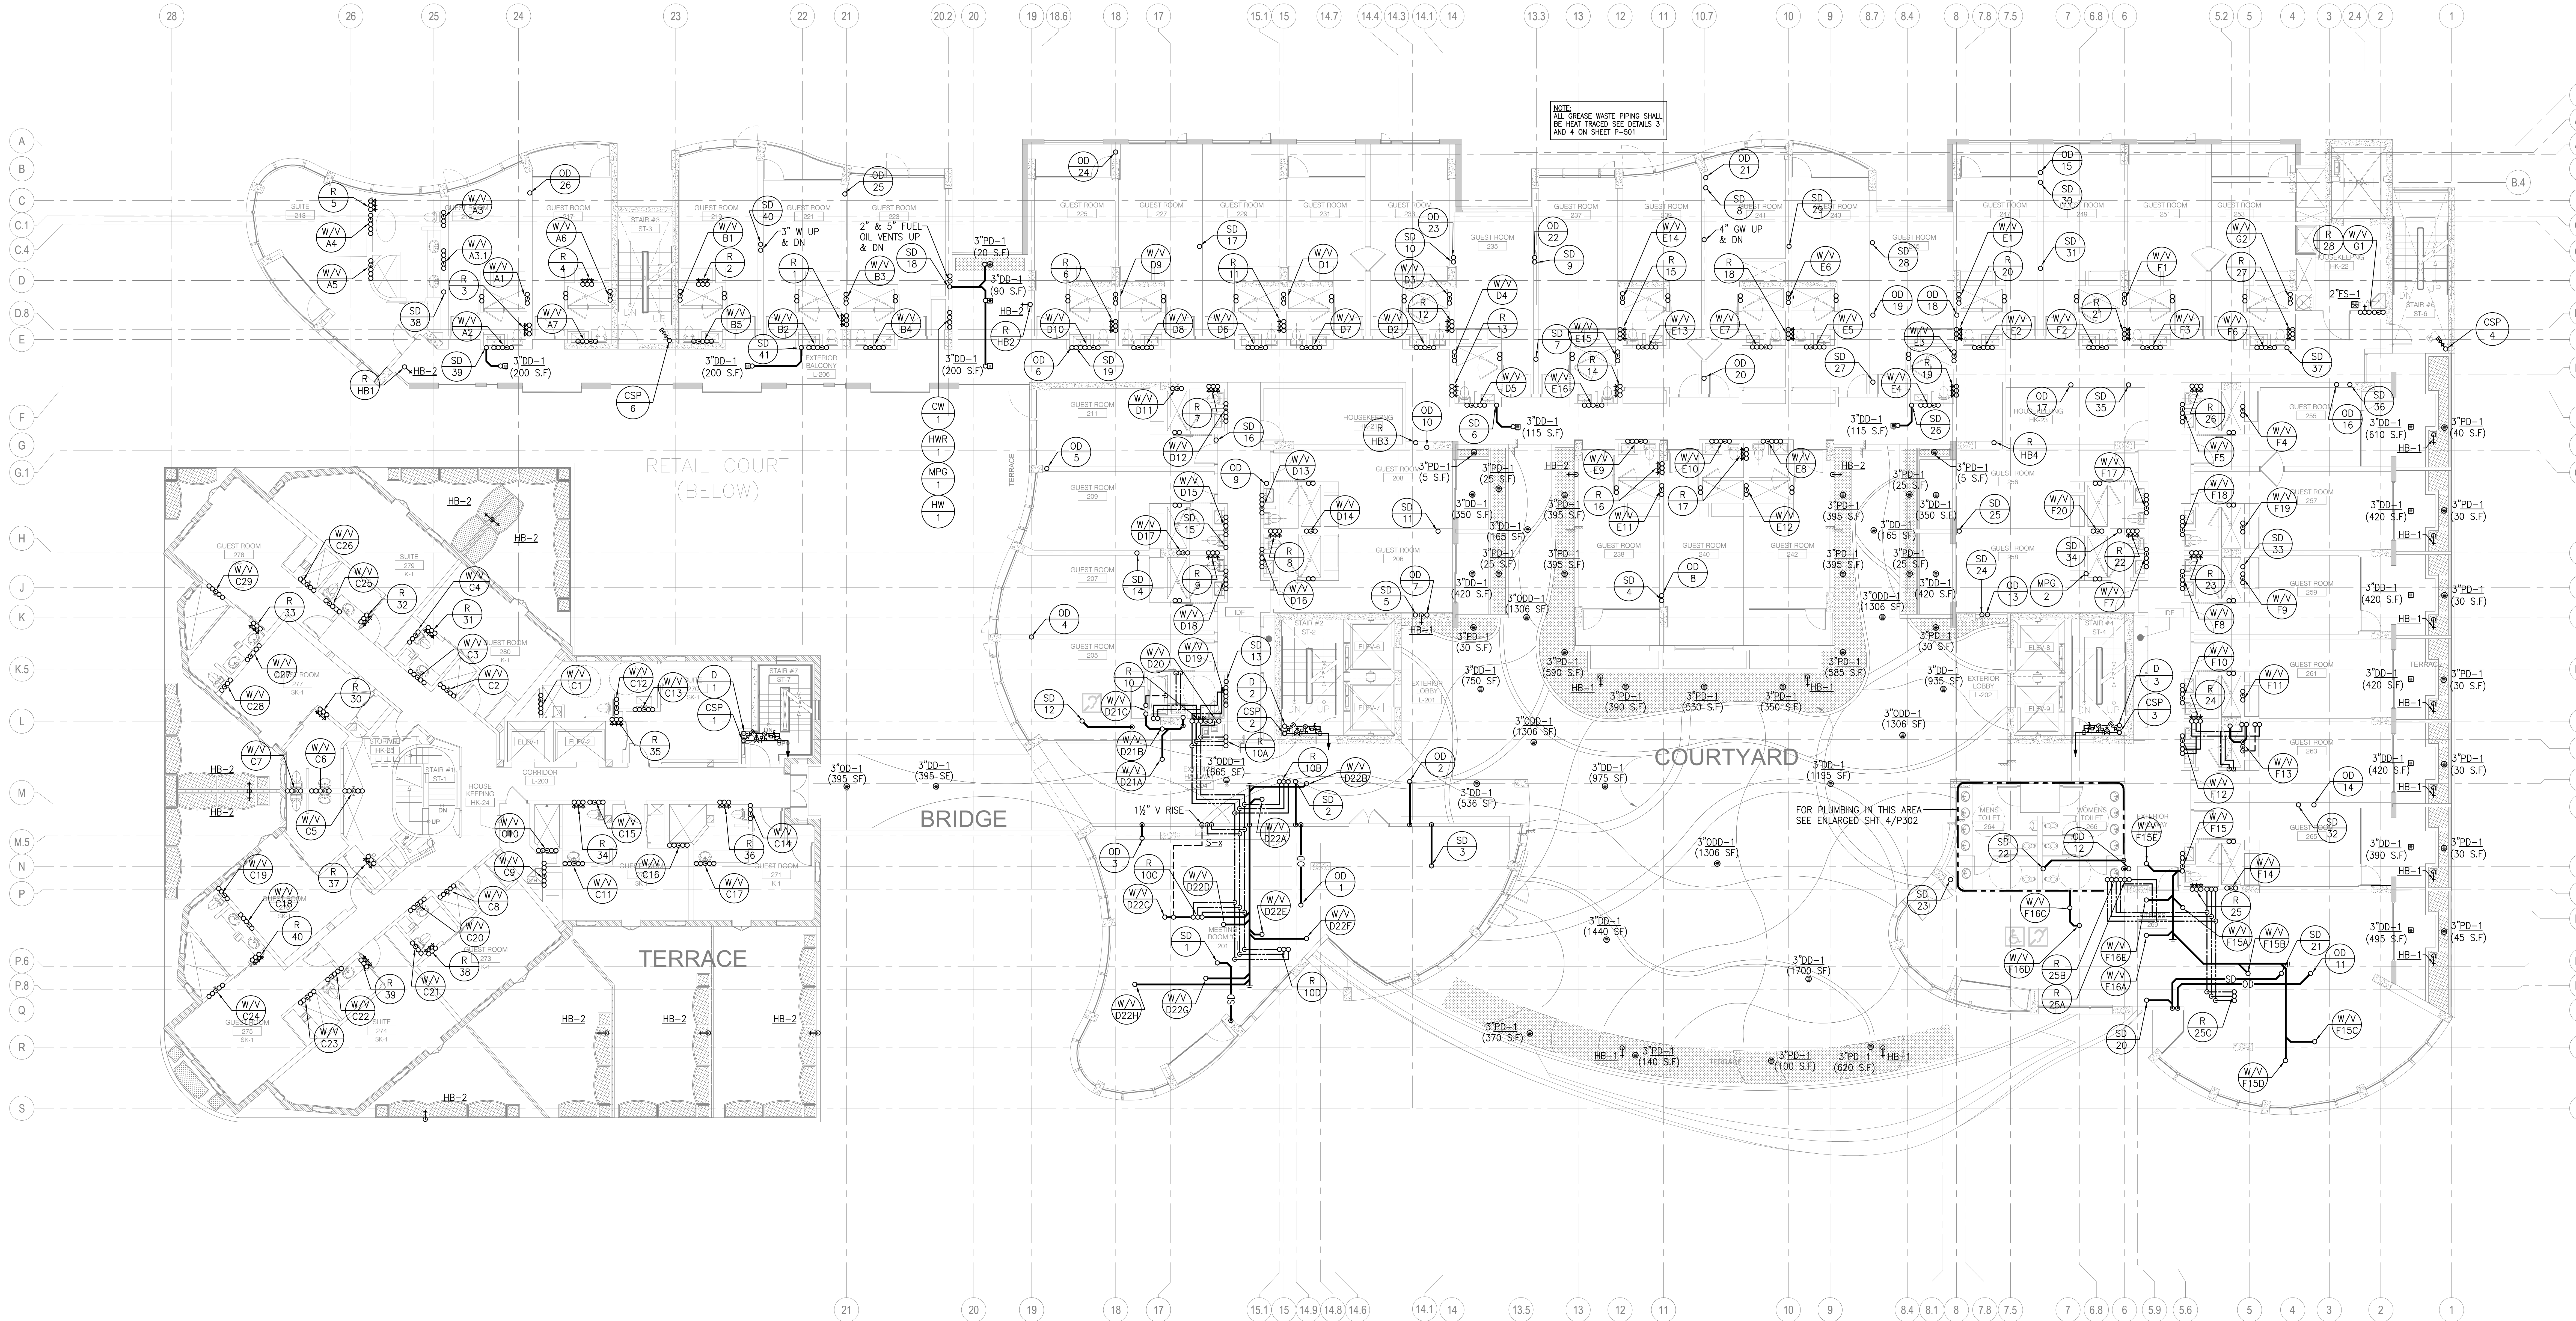

REVISIONS
DATE
BY
DESCRIPTION
05/07/2015
Medium 02
09/04/2015
Medium 03
10/20/2015
Medium 04
02/27/2016
Medium 05

hla
howard laks architects
1545 Wilshire Street
Santa Monica, CA 90401
voice 310-393-4465
fax 310-393-2230

CONSULTANTS
Donald F. Dickerson Associates
CONSULTING MECHANICAL & ELECTRICAL ENGINEERS
1700 Wilshire Blvd., Suite 404
Santa Monica, CA 90401
(310) 393-2800
E-MAIL: DONALD@DFDA.COM
JOB NO. 201225

710 WILSHIRE BOULEVARD
MIXED-USE HOTEL PROJECT
SANTA MONICA - CALIFORNIA 90401
SECOND FLOOR PLUMBING PLAN

DRAWN
CHECKED
APPROVED
SCALE
1/8" = 1'-0"
SHEET
P-208
DATE
June 25, 2013
PROJECT NUMBER
HLA 000000-00000