





REVISION	DATE	DESCRIPTION
1	05/07/2015	Medium 02
2	06/04/2015	Medium 03
3	06/04/2015	Medium 04
4	06/04/2015	Medium 05

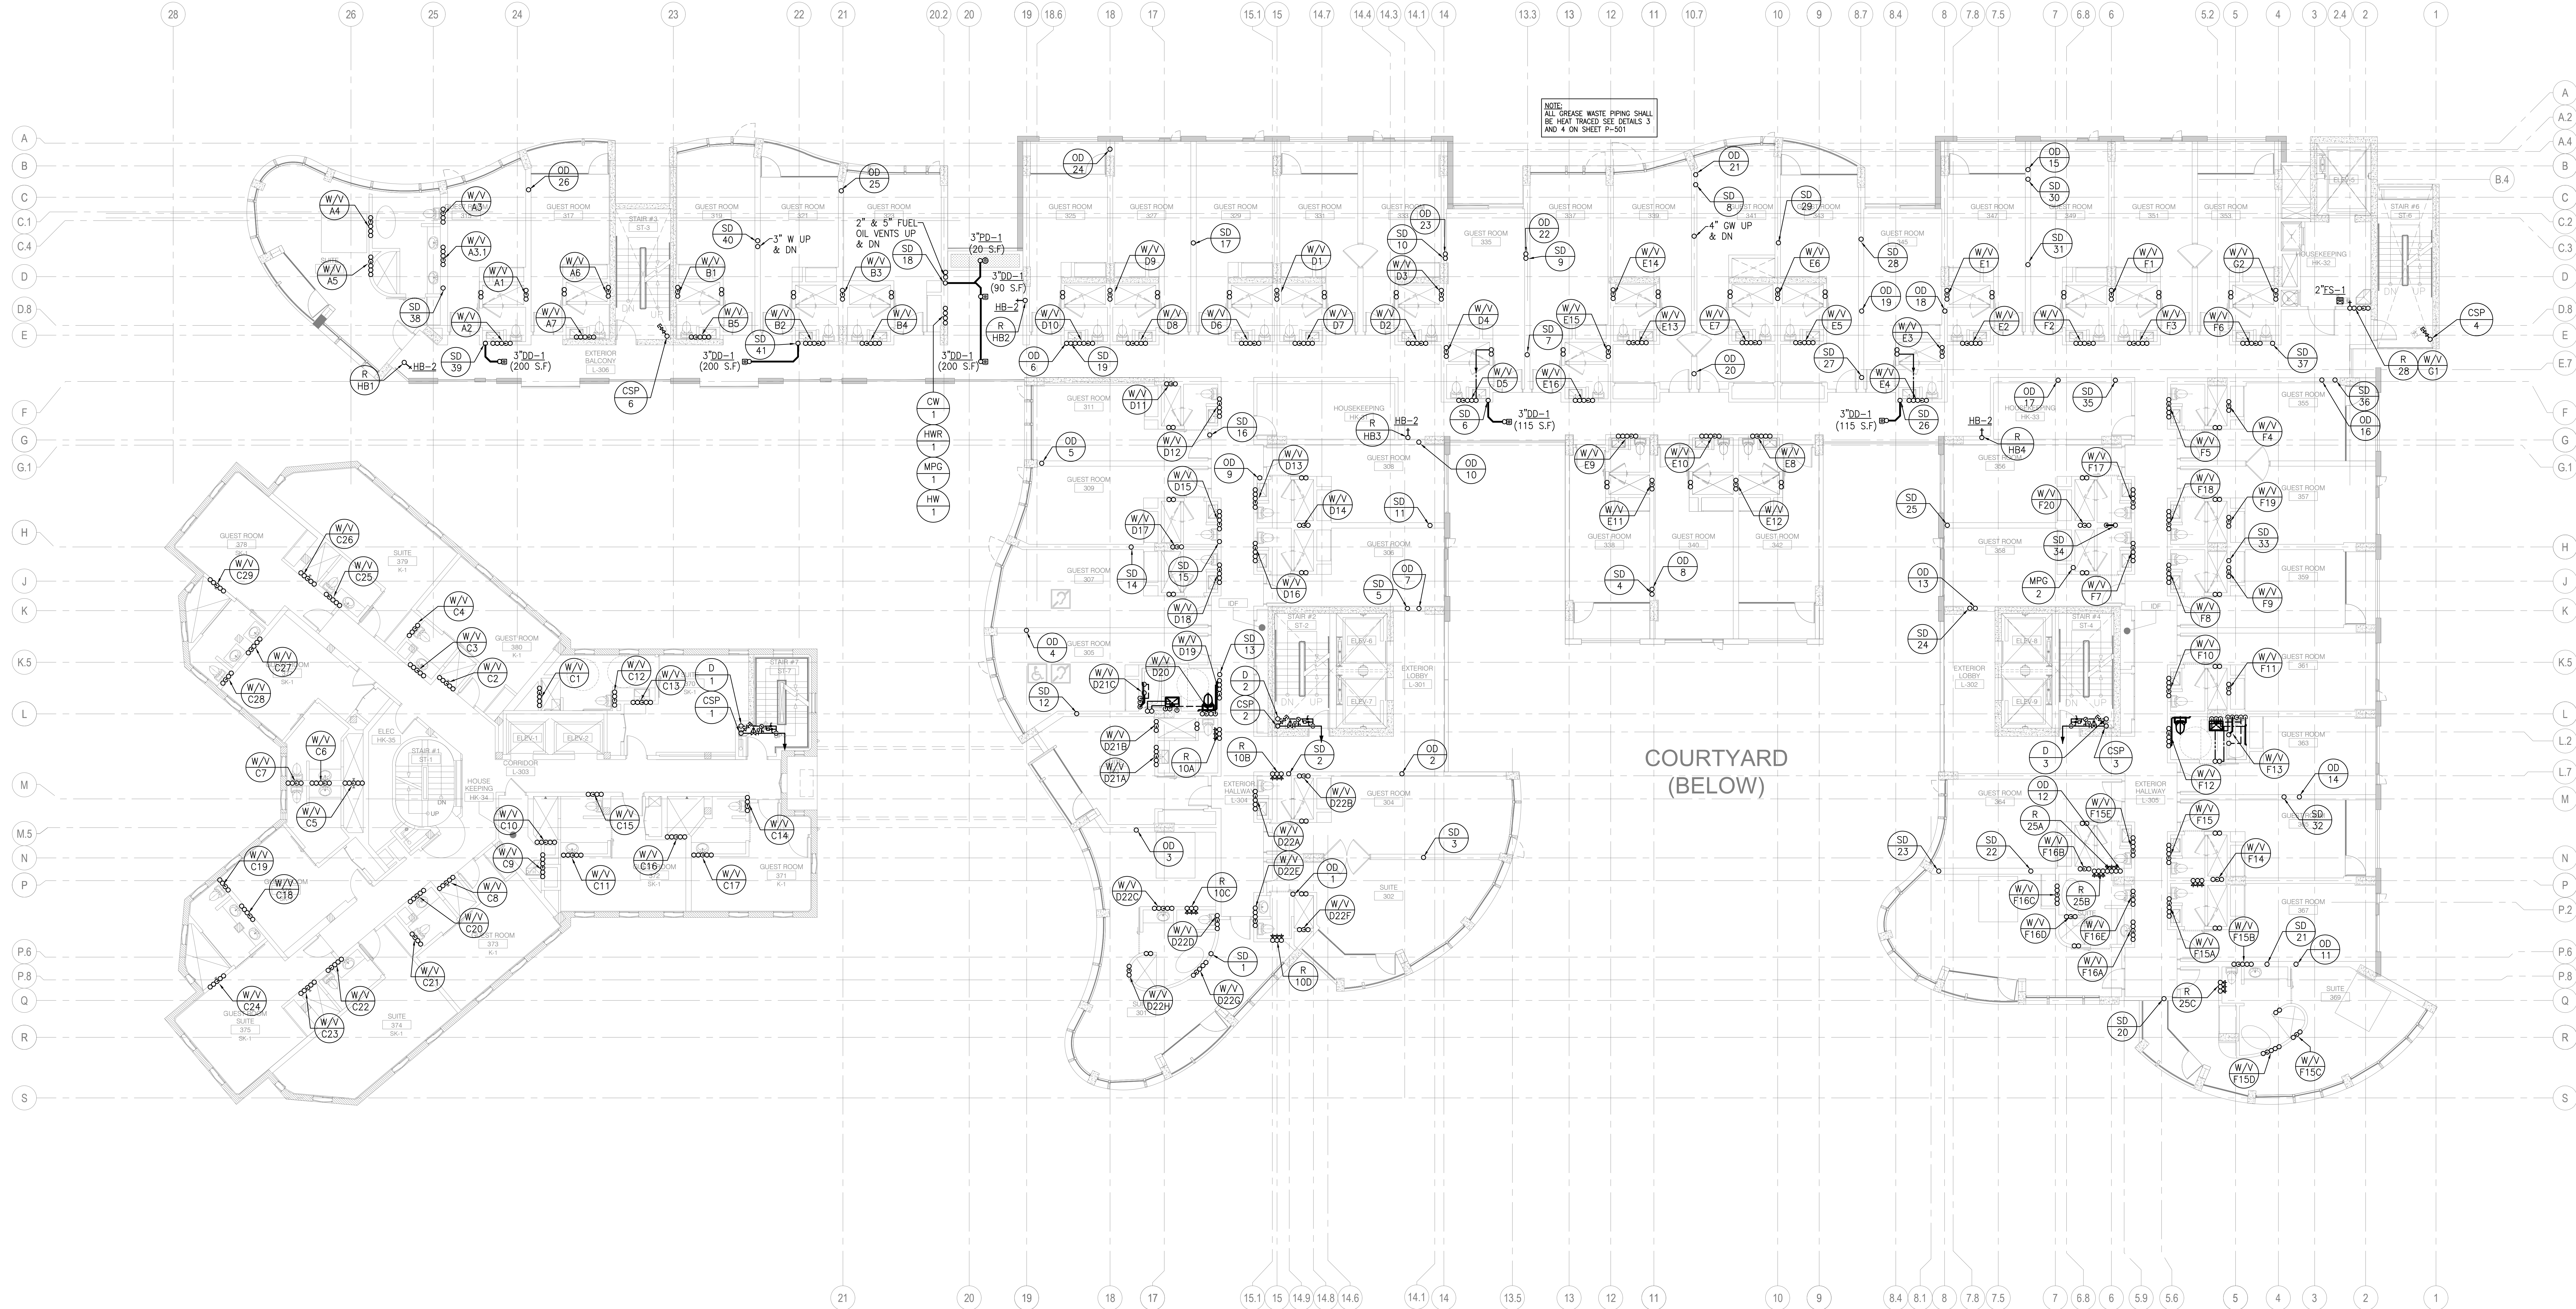

howard laks architects
1545 wealth street
santa monica, ca 90401
voice : 310-393-4465
fax : 310-393-2230

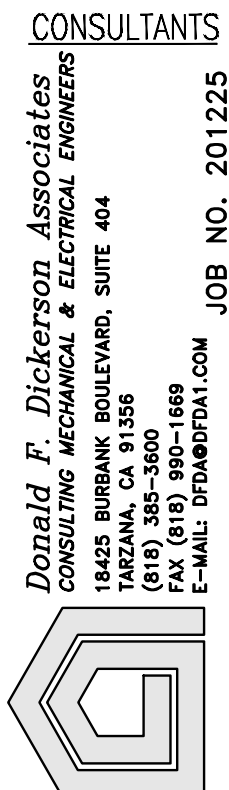

Donald F. Diskeropian, Architect
CONSULTING MECHANICAL & ELECTRICAL ENGINEERS
1545 WEALTH STREET, SUITE 404
SANTA MONICA, CA 90401
TEL: 310-393-4465
FAX: 310-393-2230
E-MAIL: DON@HLSA.COM

710 WILSHIRE BOULEVARD
MIXED-USE HOTEL PROJECT
SANTA MONICA - CALIFORNIA 90401
THIRD FLOOR PLUMBING PLAN

DRAWN	---
CHECKED	---
APPROVED	---
SCALE	1/8" = 1'-0"
SHEET	P-209
DATE	June 25, 2013
PROJECT NUMBER	HLSA 0000000-00000