




REVISIONS
DATE
BY
DESCRIPTION
05/07/2015
Mikaelum 02
06/04/2015
Mikaelum 03
10/20/2015
Mikaelum 04
05/27/2016
Mikaelum 05

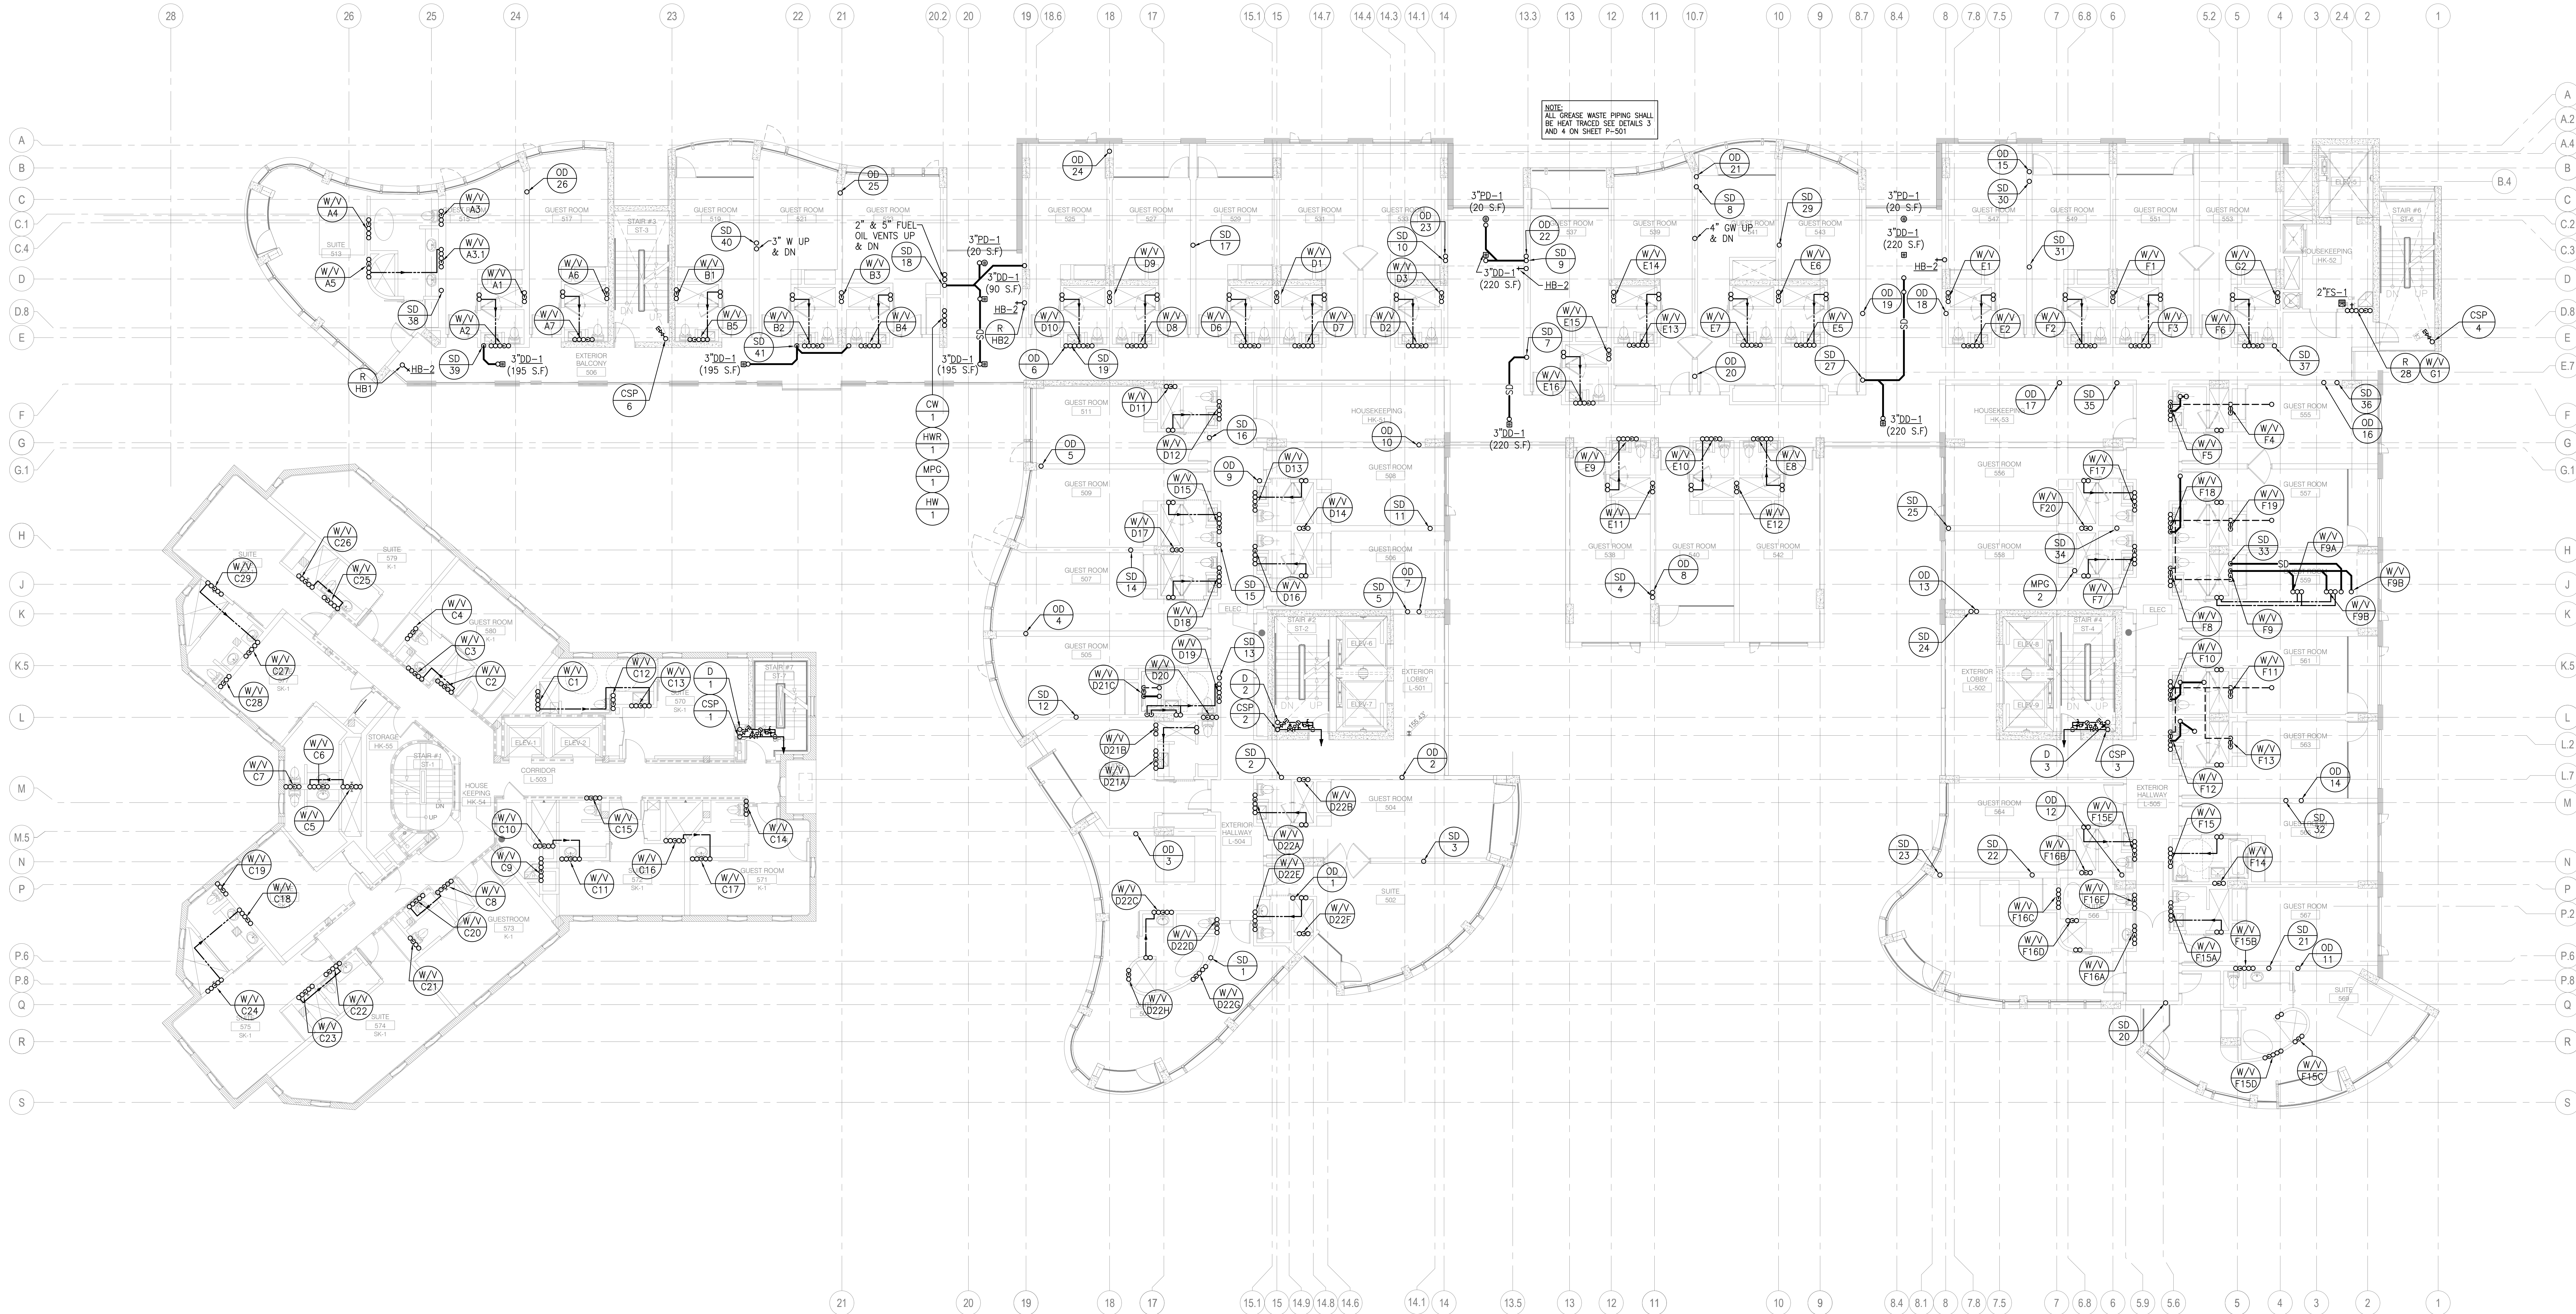

howard laks architects
1545 wealth street
santa monica, ca 90401
voice : 310-393-4465
fax : 310-393-2230

CONSULTANTS
Donald F. Dickerson Associates
CONSULTING MECHANICAL & ELECTRICAL ENGINEERS
1700 WILSHIRE BLVD., SUITE 404
SANTA MONICA, CA 90401
TEL: 310-393-8888
E-MAIL: DONALD@DFDA.COM
JOB NO. 201225

710 WILSHIRE BOULEVARD
MIXED-USE HOTEL PROJECT
SANTA MONICA - CALIFORNIA 90401
FIFTH FLOOR PLUMBING PLAN

DRAWN
CHECKED
APPROVED
SCALE
1/8" = 1'-0"
SHEET
P-211
DATE
June 25, 2013
PROJECT NUMBER
HLA 0000000-00000