


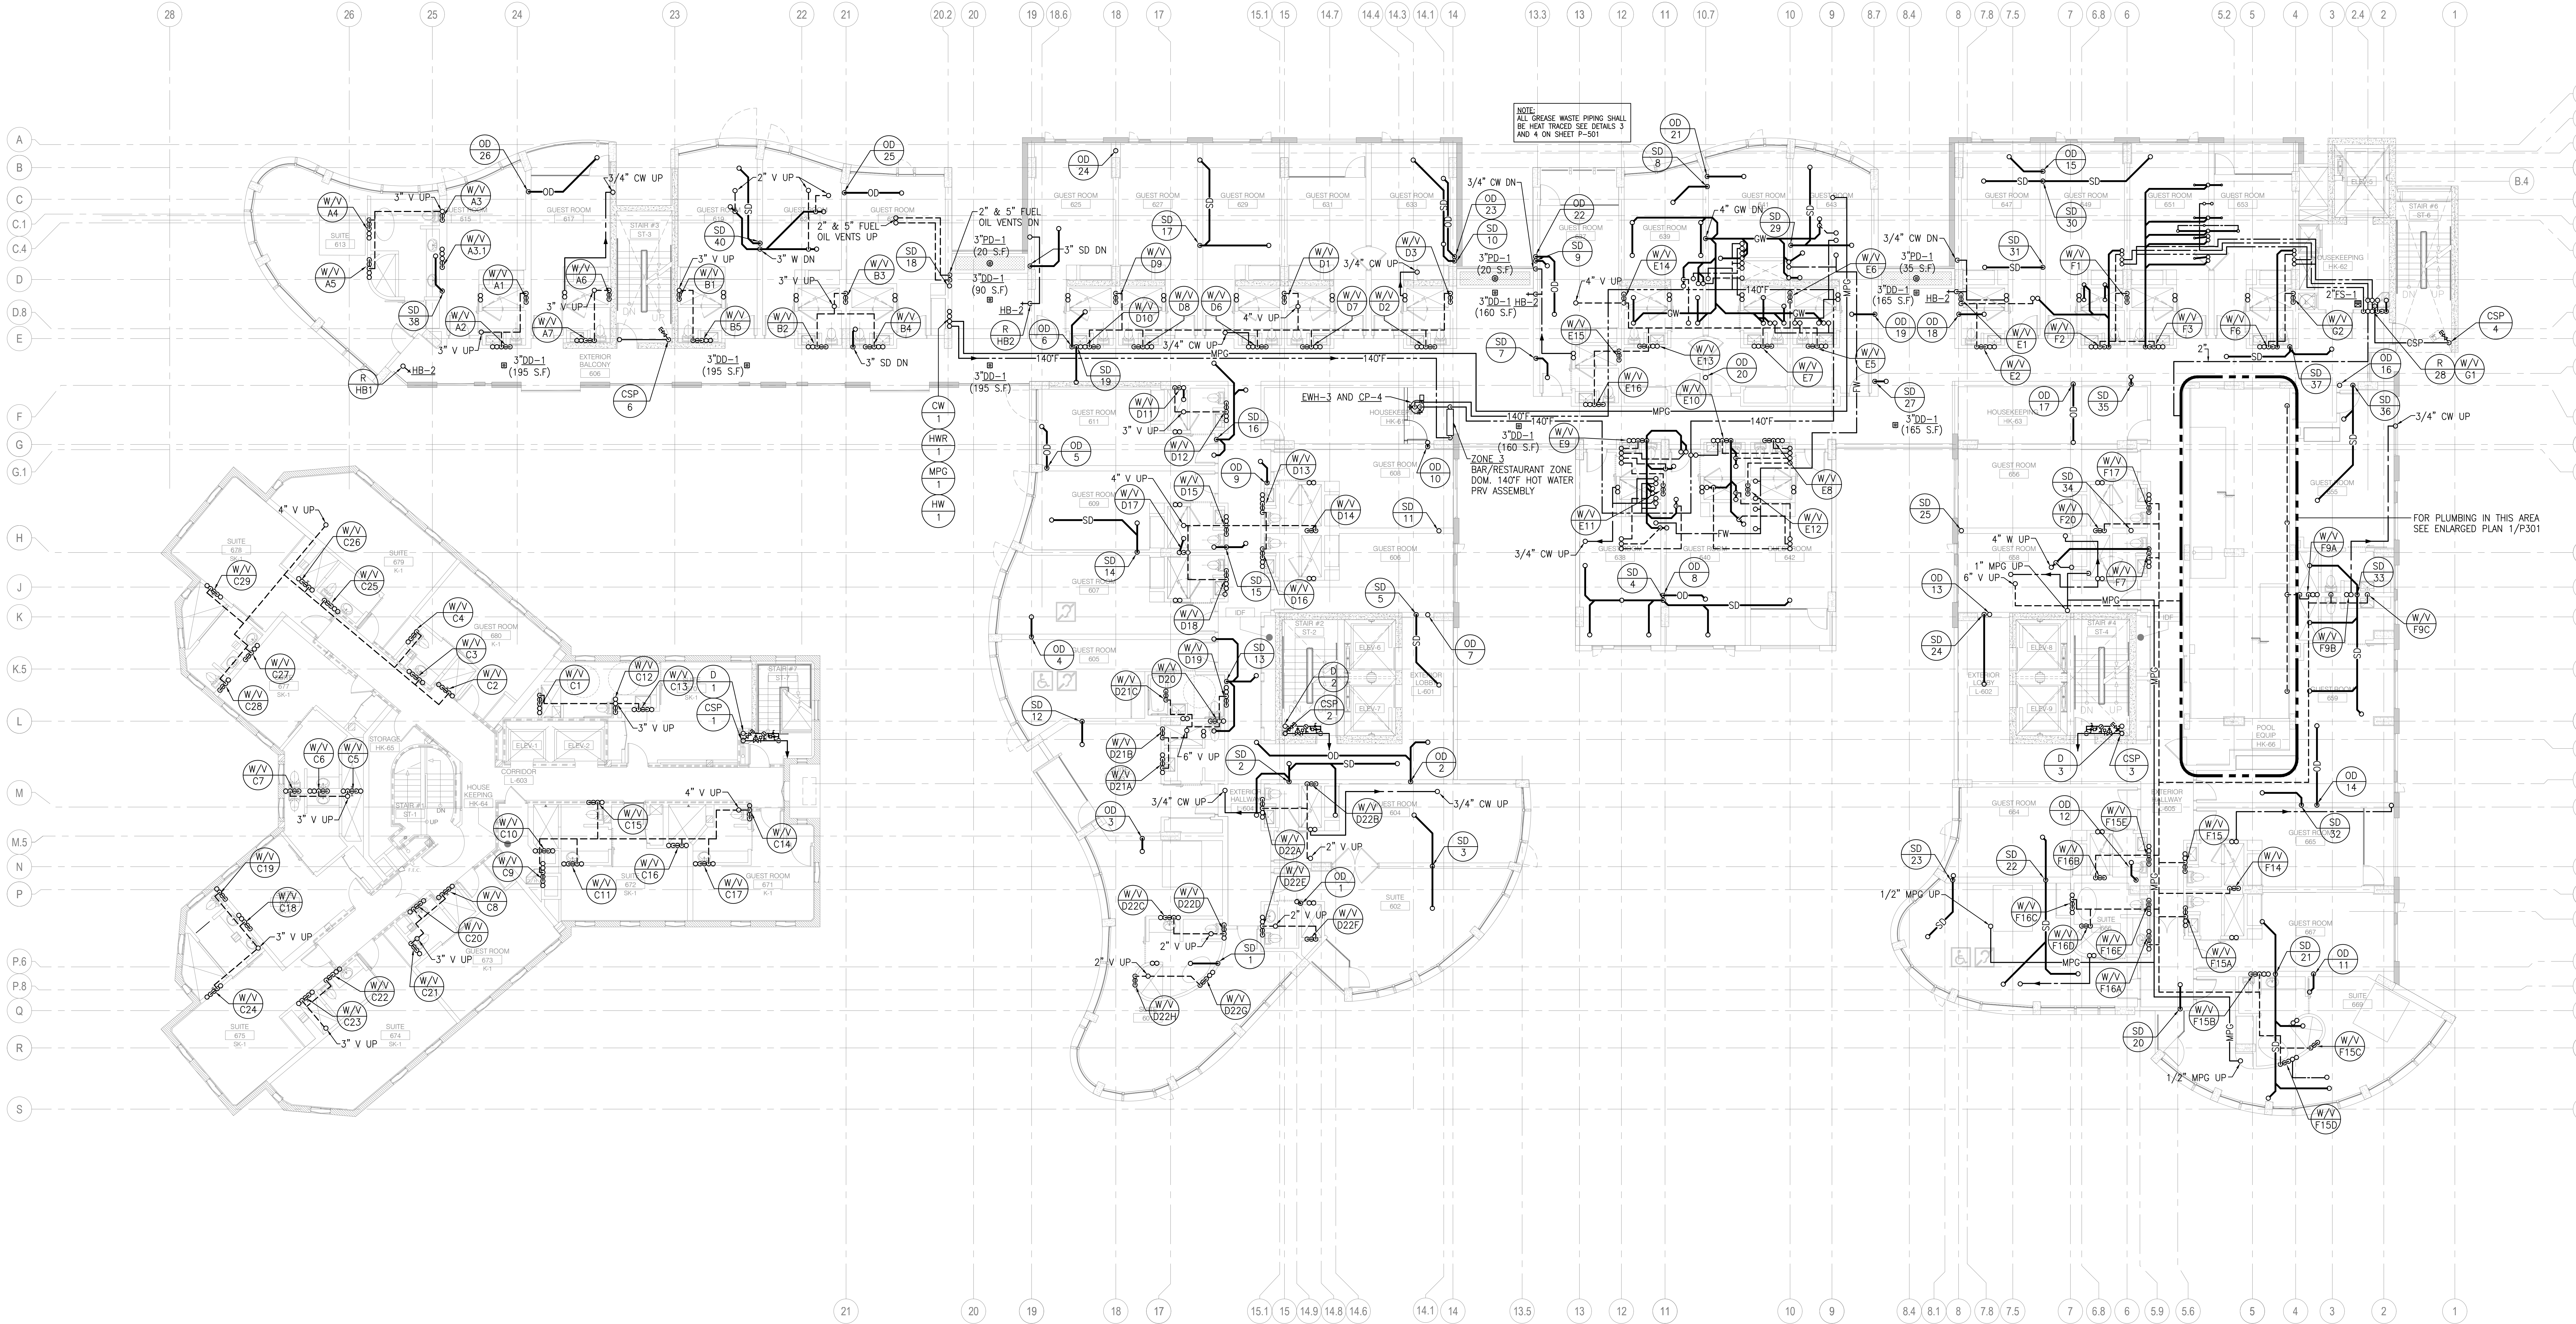

REVISION	DATE	DESCRIPTION
1	05/07/2013	Medium 02
2	09/04/2015	Medium 03
3	10/20/2015	Medium 04
4	03/27/2016	Medium 05

hla

howard laks architects

1945 wealth street
santa monica, ca 90401

voice : 310-393-4465
fax : 310-393-2230

CONSULTANTS

Donald F. Diskerup Associates
CONSULTING MECHANICAL & ELECTRICAL ENGINEERS
1700 WILSHIRE BLVD., SUITE 404
SANTA MONICA, CA 90401
(310) 393-9900
E-MAIL: DDISK@DFA.COM

710 WILSHIRE BOULEVARD

MIXED-USE HOTEL PROJECT
SANTA MONICA - CALIFORNIA 90401

SIXTH FLOOR PLUMBING PLAN

DRAWN	---
CHECKED	---
APPROVED	---
SCALE	1/8" = 1'-0"
SHEET	P-212
DATE	June 25, 2013
PROJECT NUMBER	HLA 0000000-00000