


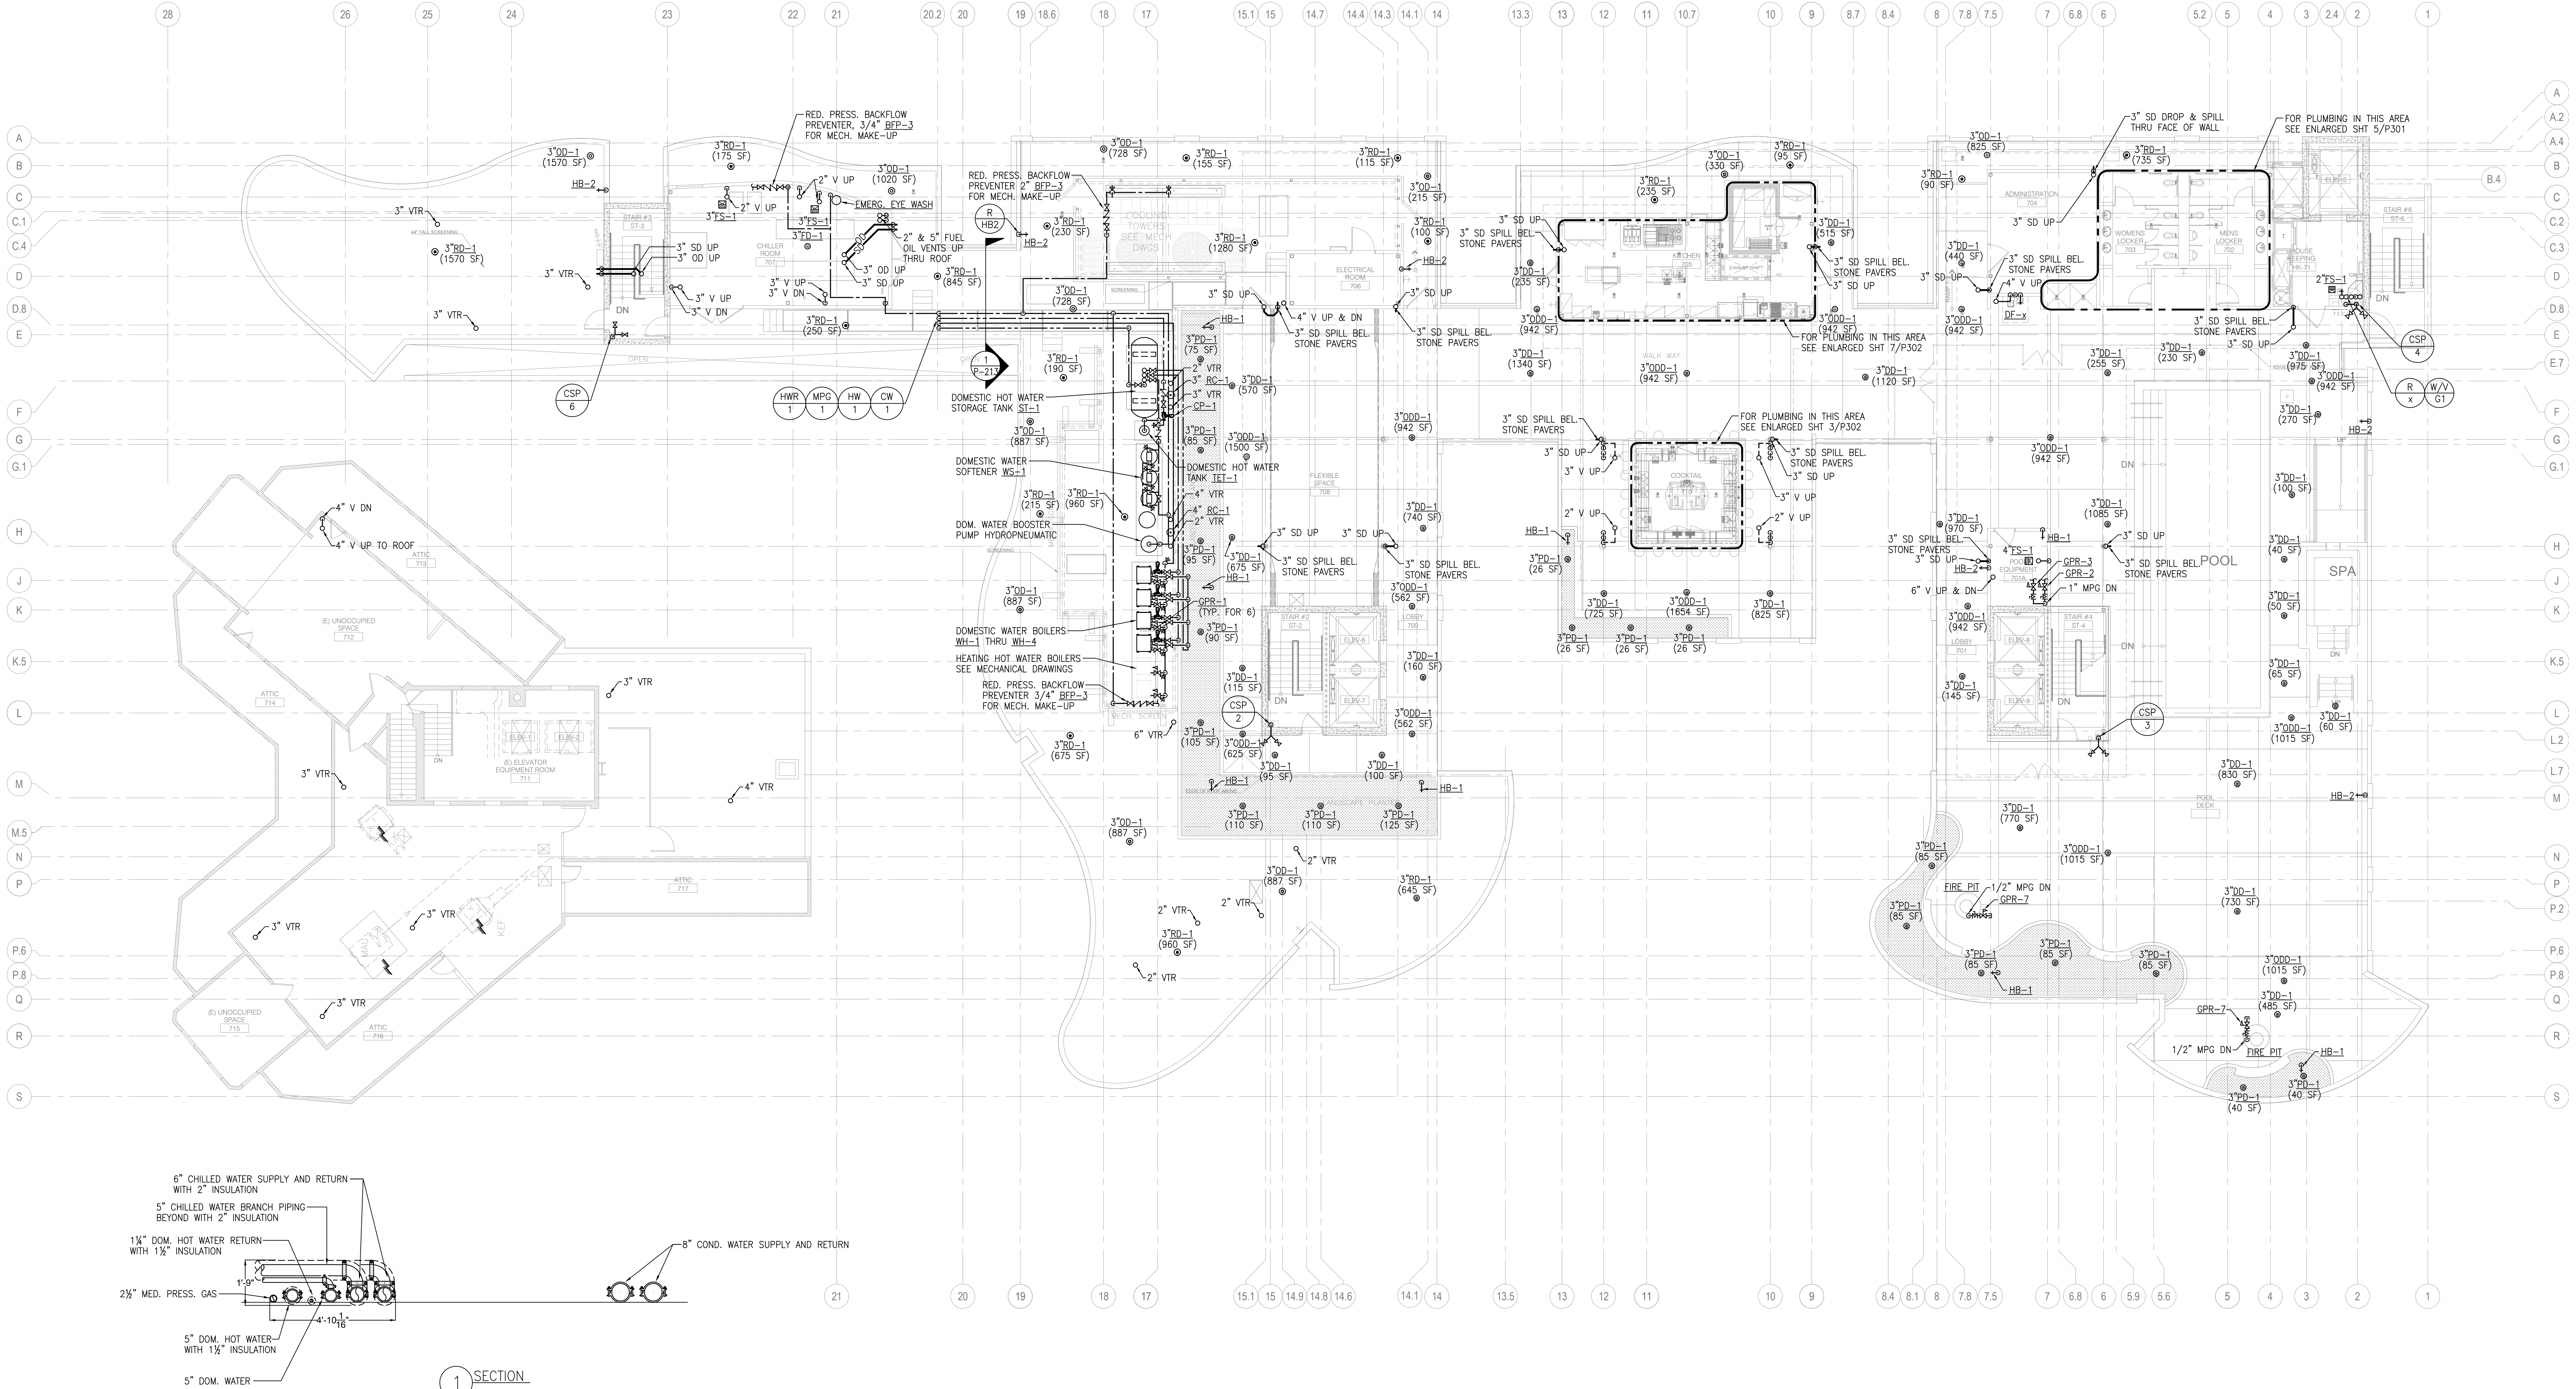

REVISION	DATE	DESCRIPTION
1	05/07/2015	MECHANICAL
2	06/04/2015	MECHANICAL
3	06/04/2015	MECHANICAL
4	06/04/2015	MECHANICAL
5	06/07/2016	MECHANICAL

hla

howard laks architects

1945 wealth street
santa monica, ca 90401

voice : 310-393-4465
fax : 310-393-2230

CONSULTANTS

Donald F. Dickerson Associates
CONSULTING MECHANICAL & ELECTRICAL ENGINEERS
1700 WILSHIRE BOULEVARD, SUITE 404
SANTA MONICA, CA 90401
(310) 393-8888
E-MAIL: DONALD@DFA.COM

710 WILSHIRE BOULEVARD

MIXED-USE HOTEL PROJECT
SANTA MONICA, CALIFORNIA 90401

ROOF TERRACE PLUMBING PLAN (W/PARTIAL SEVENTH FLOOR)

DRAWN: ---
CHECKED: ---
APPROVED: ---
SCALE: 1/8" = 1'-0"
SHEET: **P-213**
DATE: June 25, 2013
PROJECT NUMBER: HLA 0000000-00000