





REVISION	DATE	DESCRIPTION
1	05/07/2013	MECHANICAL
2	06/04/2013	MECHANICAL
3	06/04/2013	MECHANICAL
4	06/04/2013	MECHANICAL
5	06/04/2013	MECHANICAL

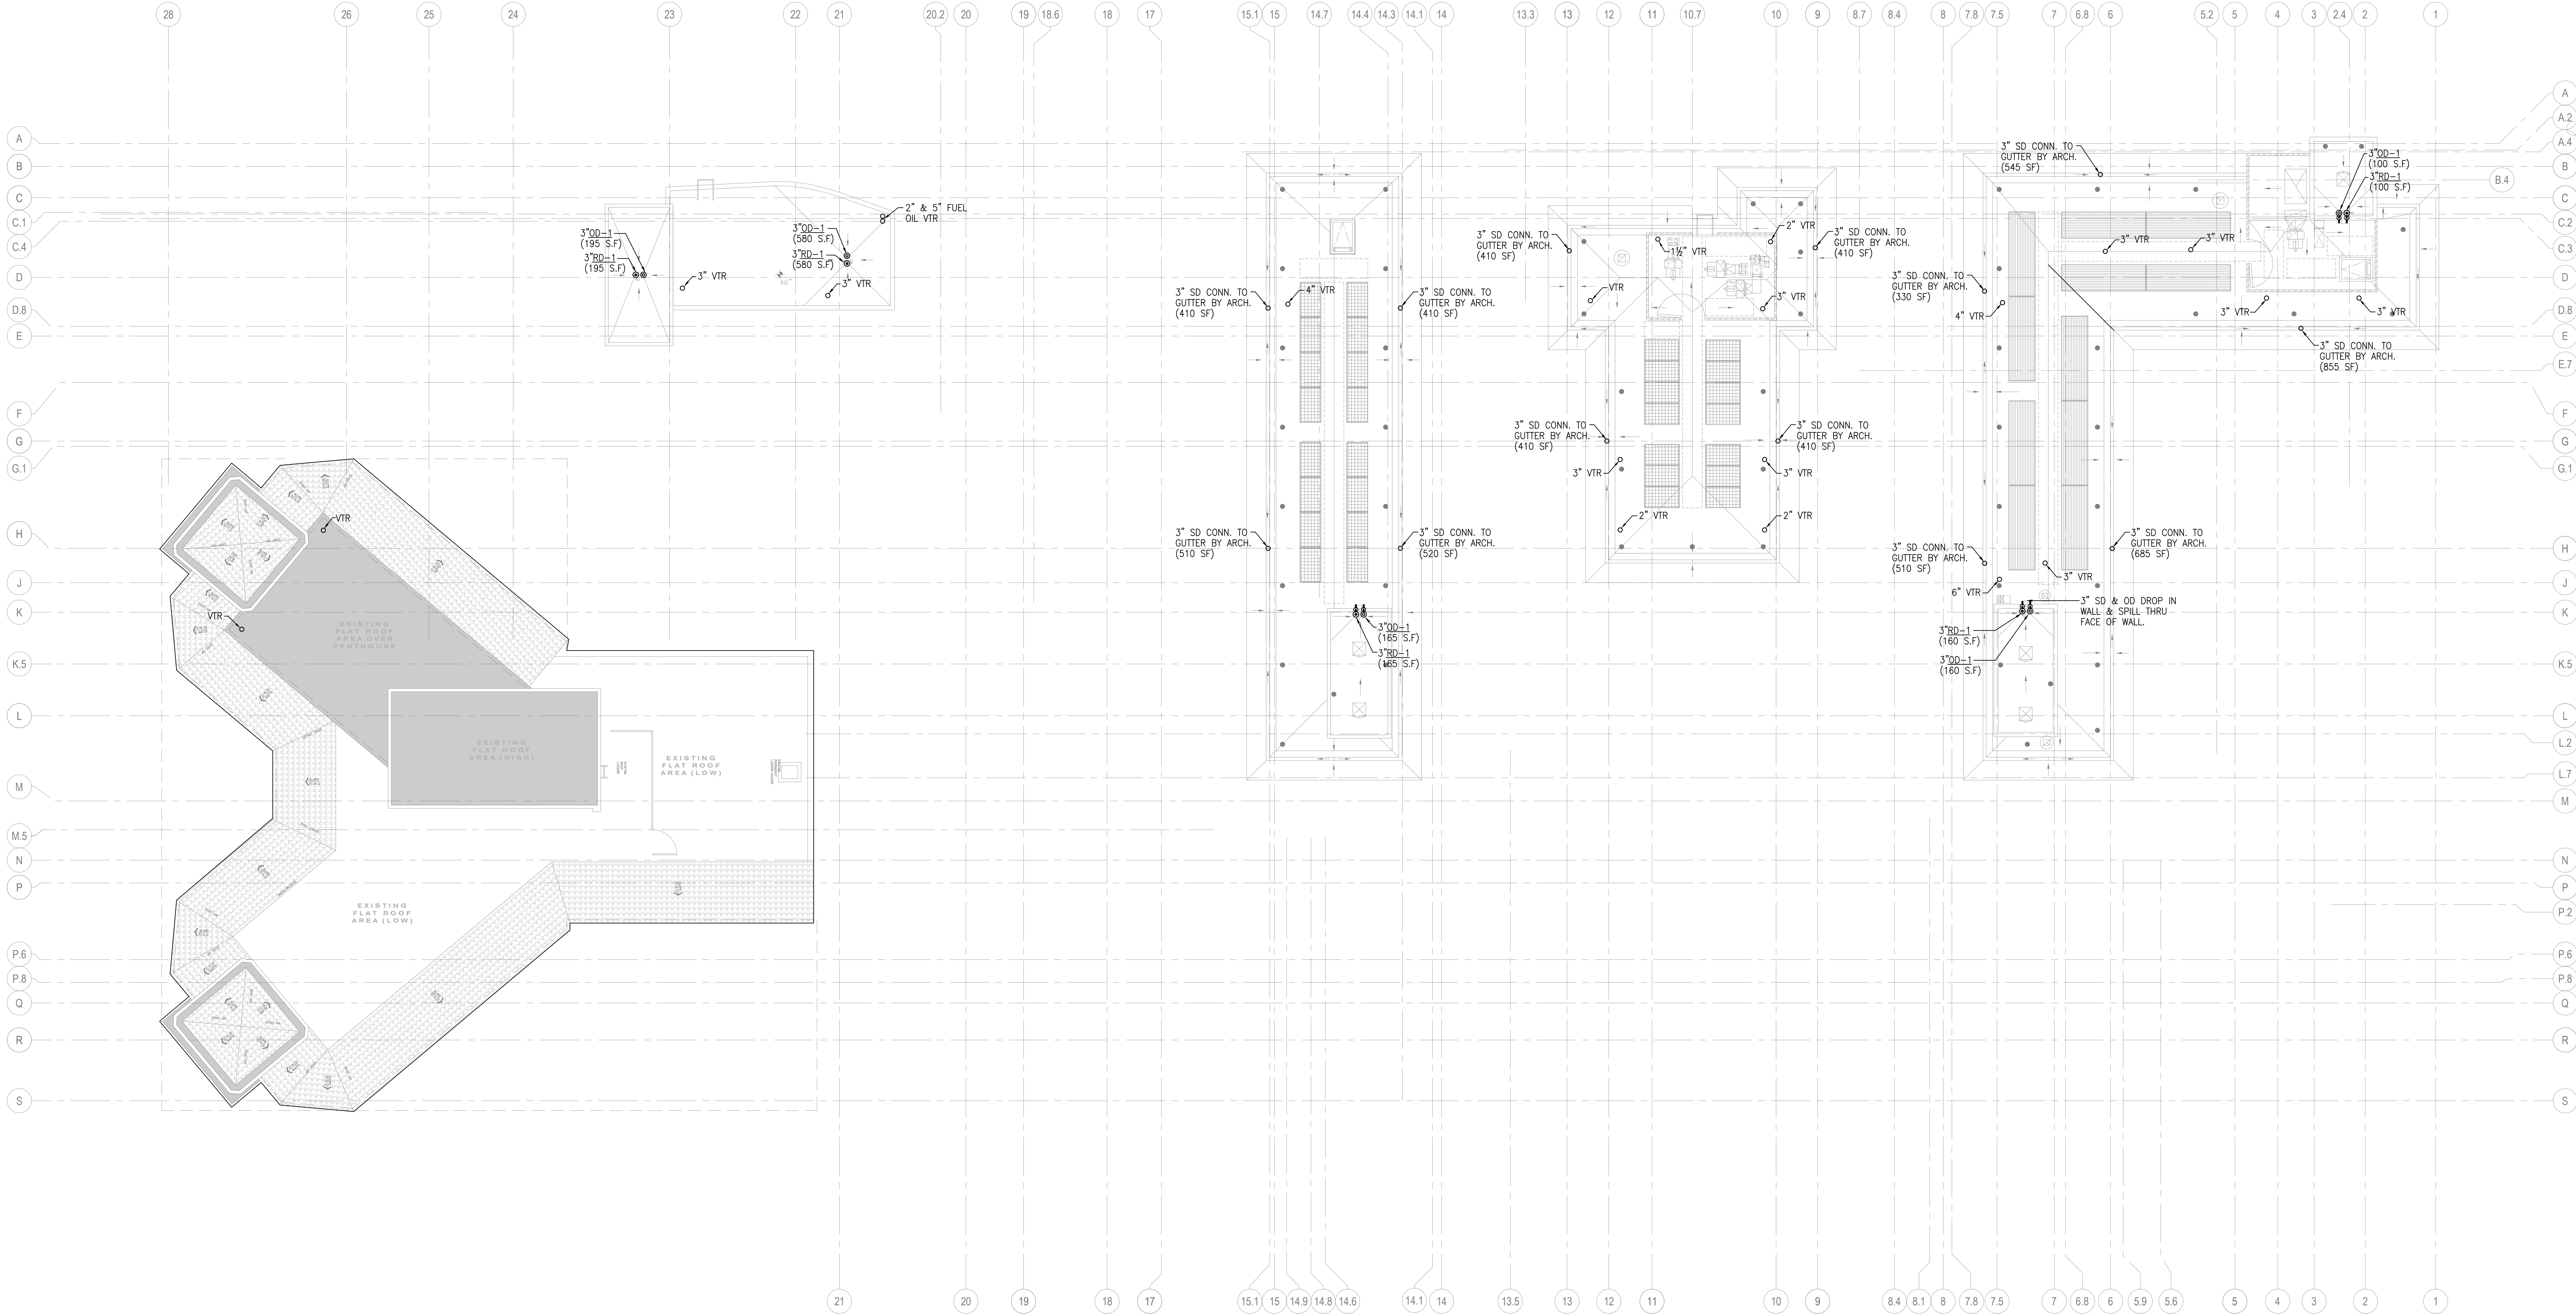

howard laks architects
1545 hewlett street
santa monica, ca 90401
voice : 310-393-4465
fax : 310-393-2230

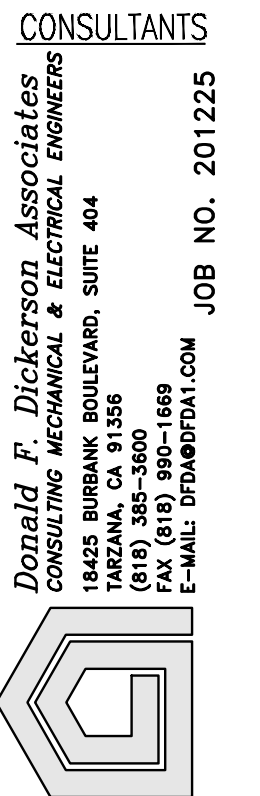

710 WILSHIRE BOULEVARD
MIXED-USE HOTEL PROJECT
SANTA MONICA - CALIFORNIA 90401
ROOF PLUMBING PLAN

DRAWN	--
CHECKED	--
APPROVED	--
SCALE	1/8" = 1'-0"
SHEET	P-214
DATE	June 25, 2013
PROJECT NUMBER	HLA 0000000-00000