




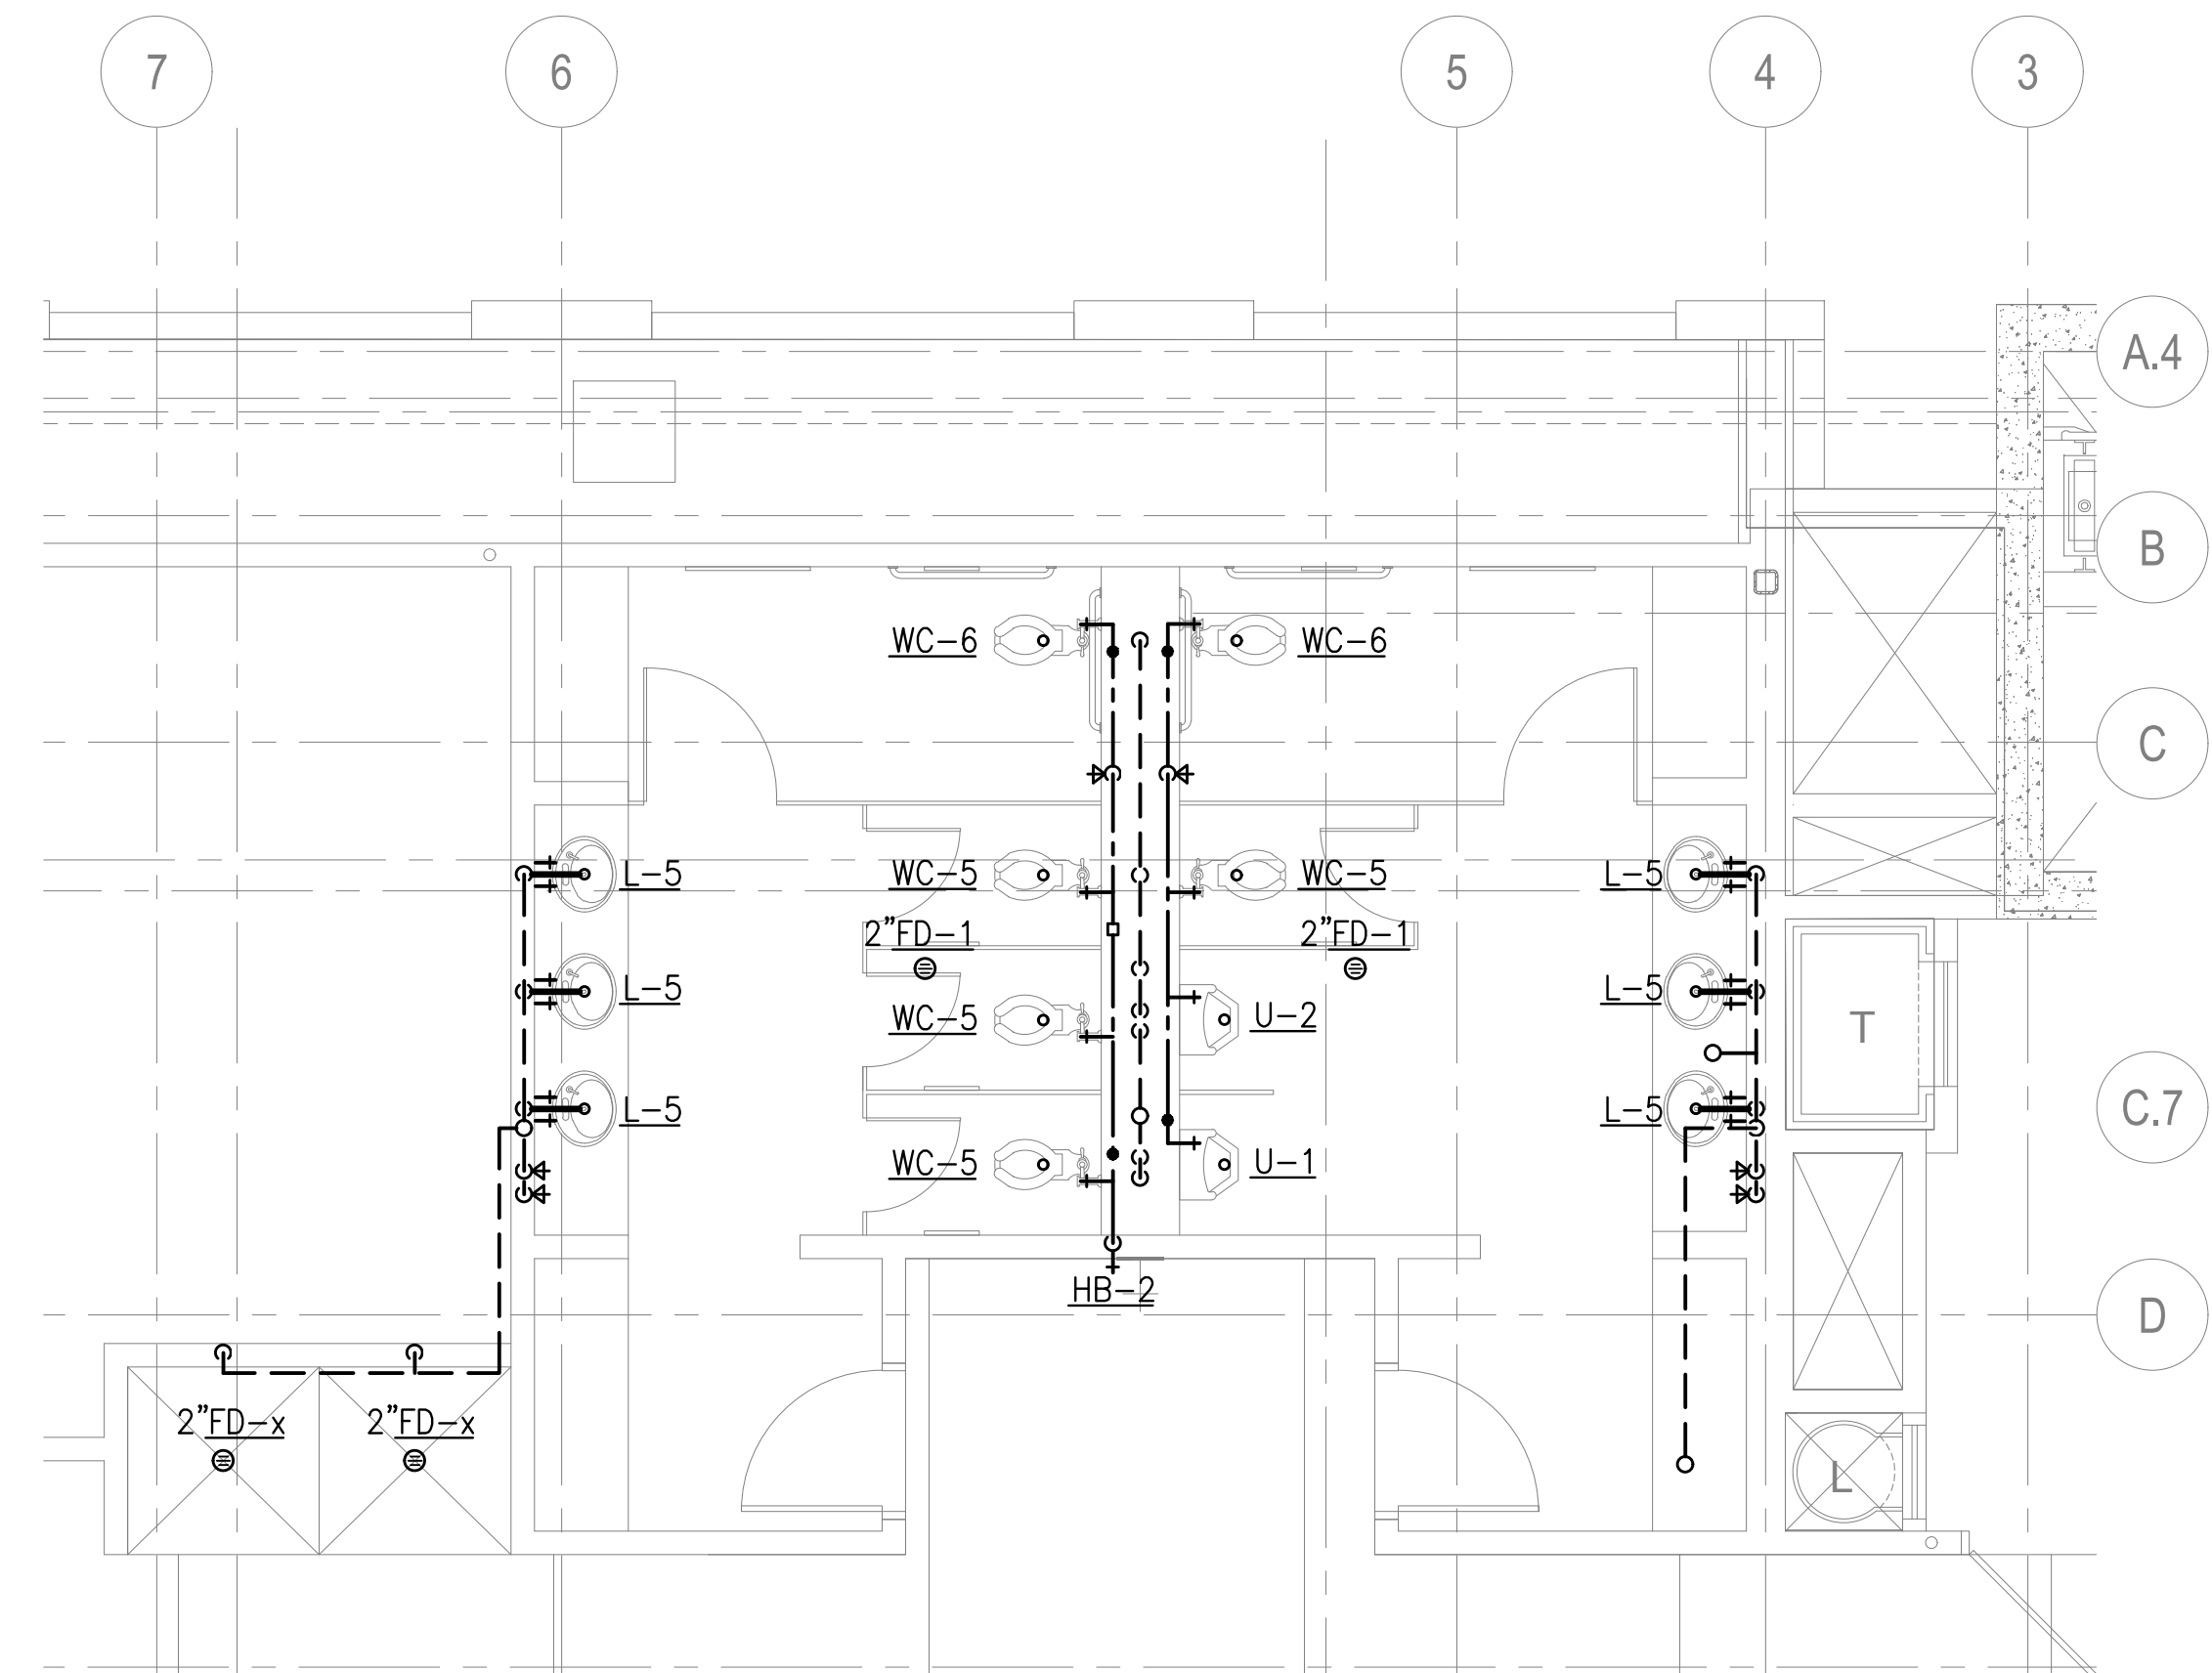


5 ENLARGED SEVENTH LEVEL MENS AND WOMENS LOCKER ROOM
Scale: 1/4" = 1'-0"

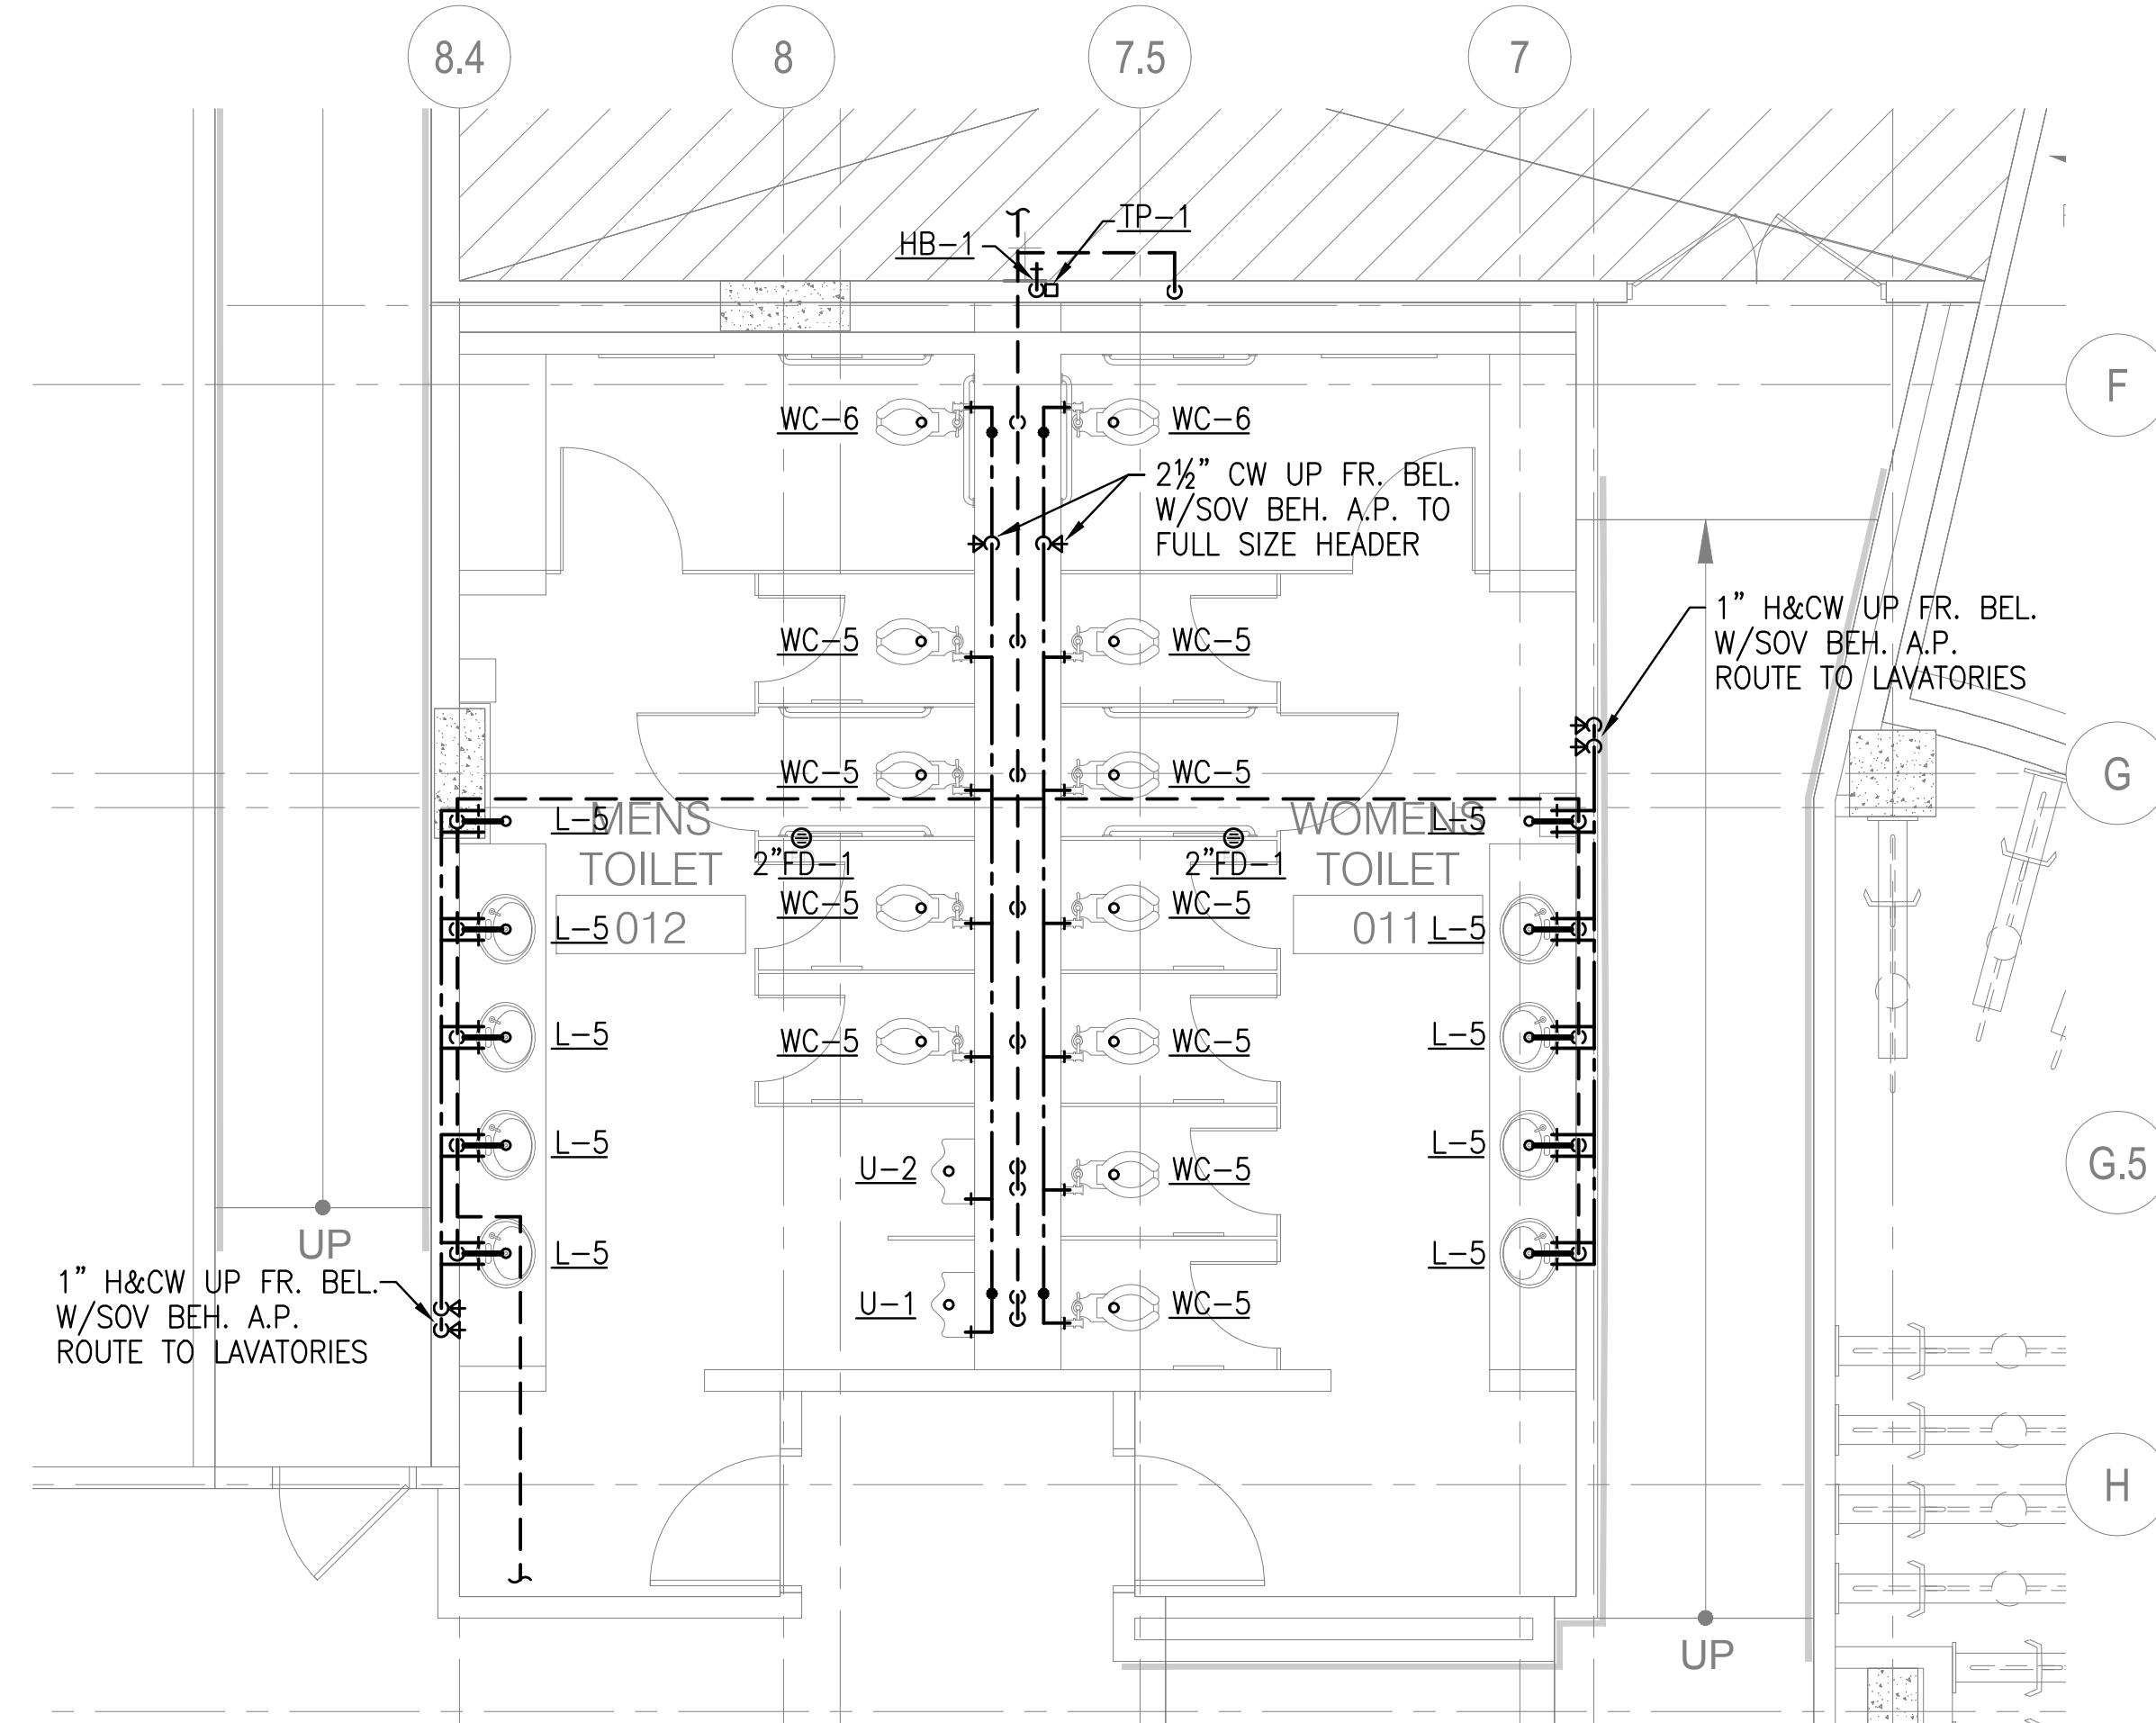


4 ENLARGED GROUND LEVEL MENS AND WOMENS TOILET ROOM
Scale: 1/4" = 1'-0"

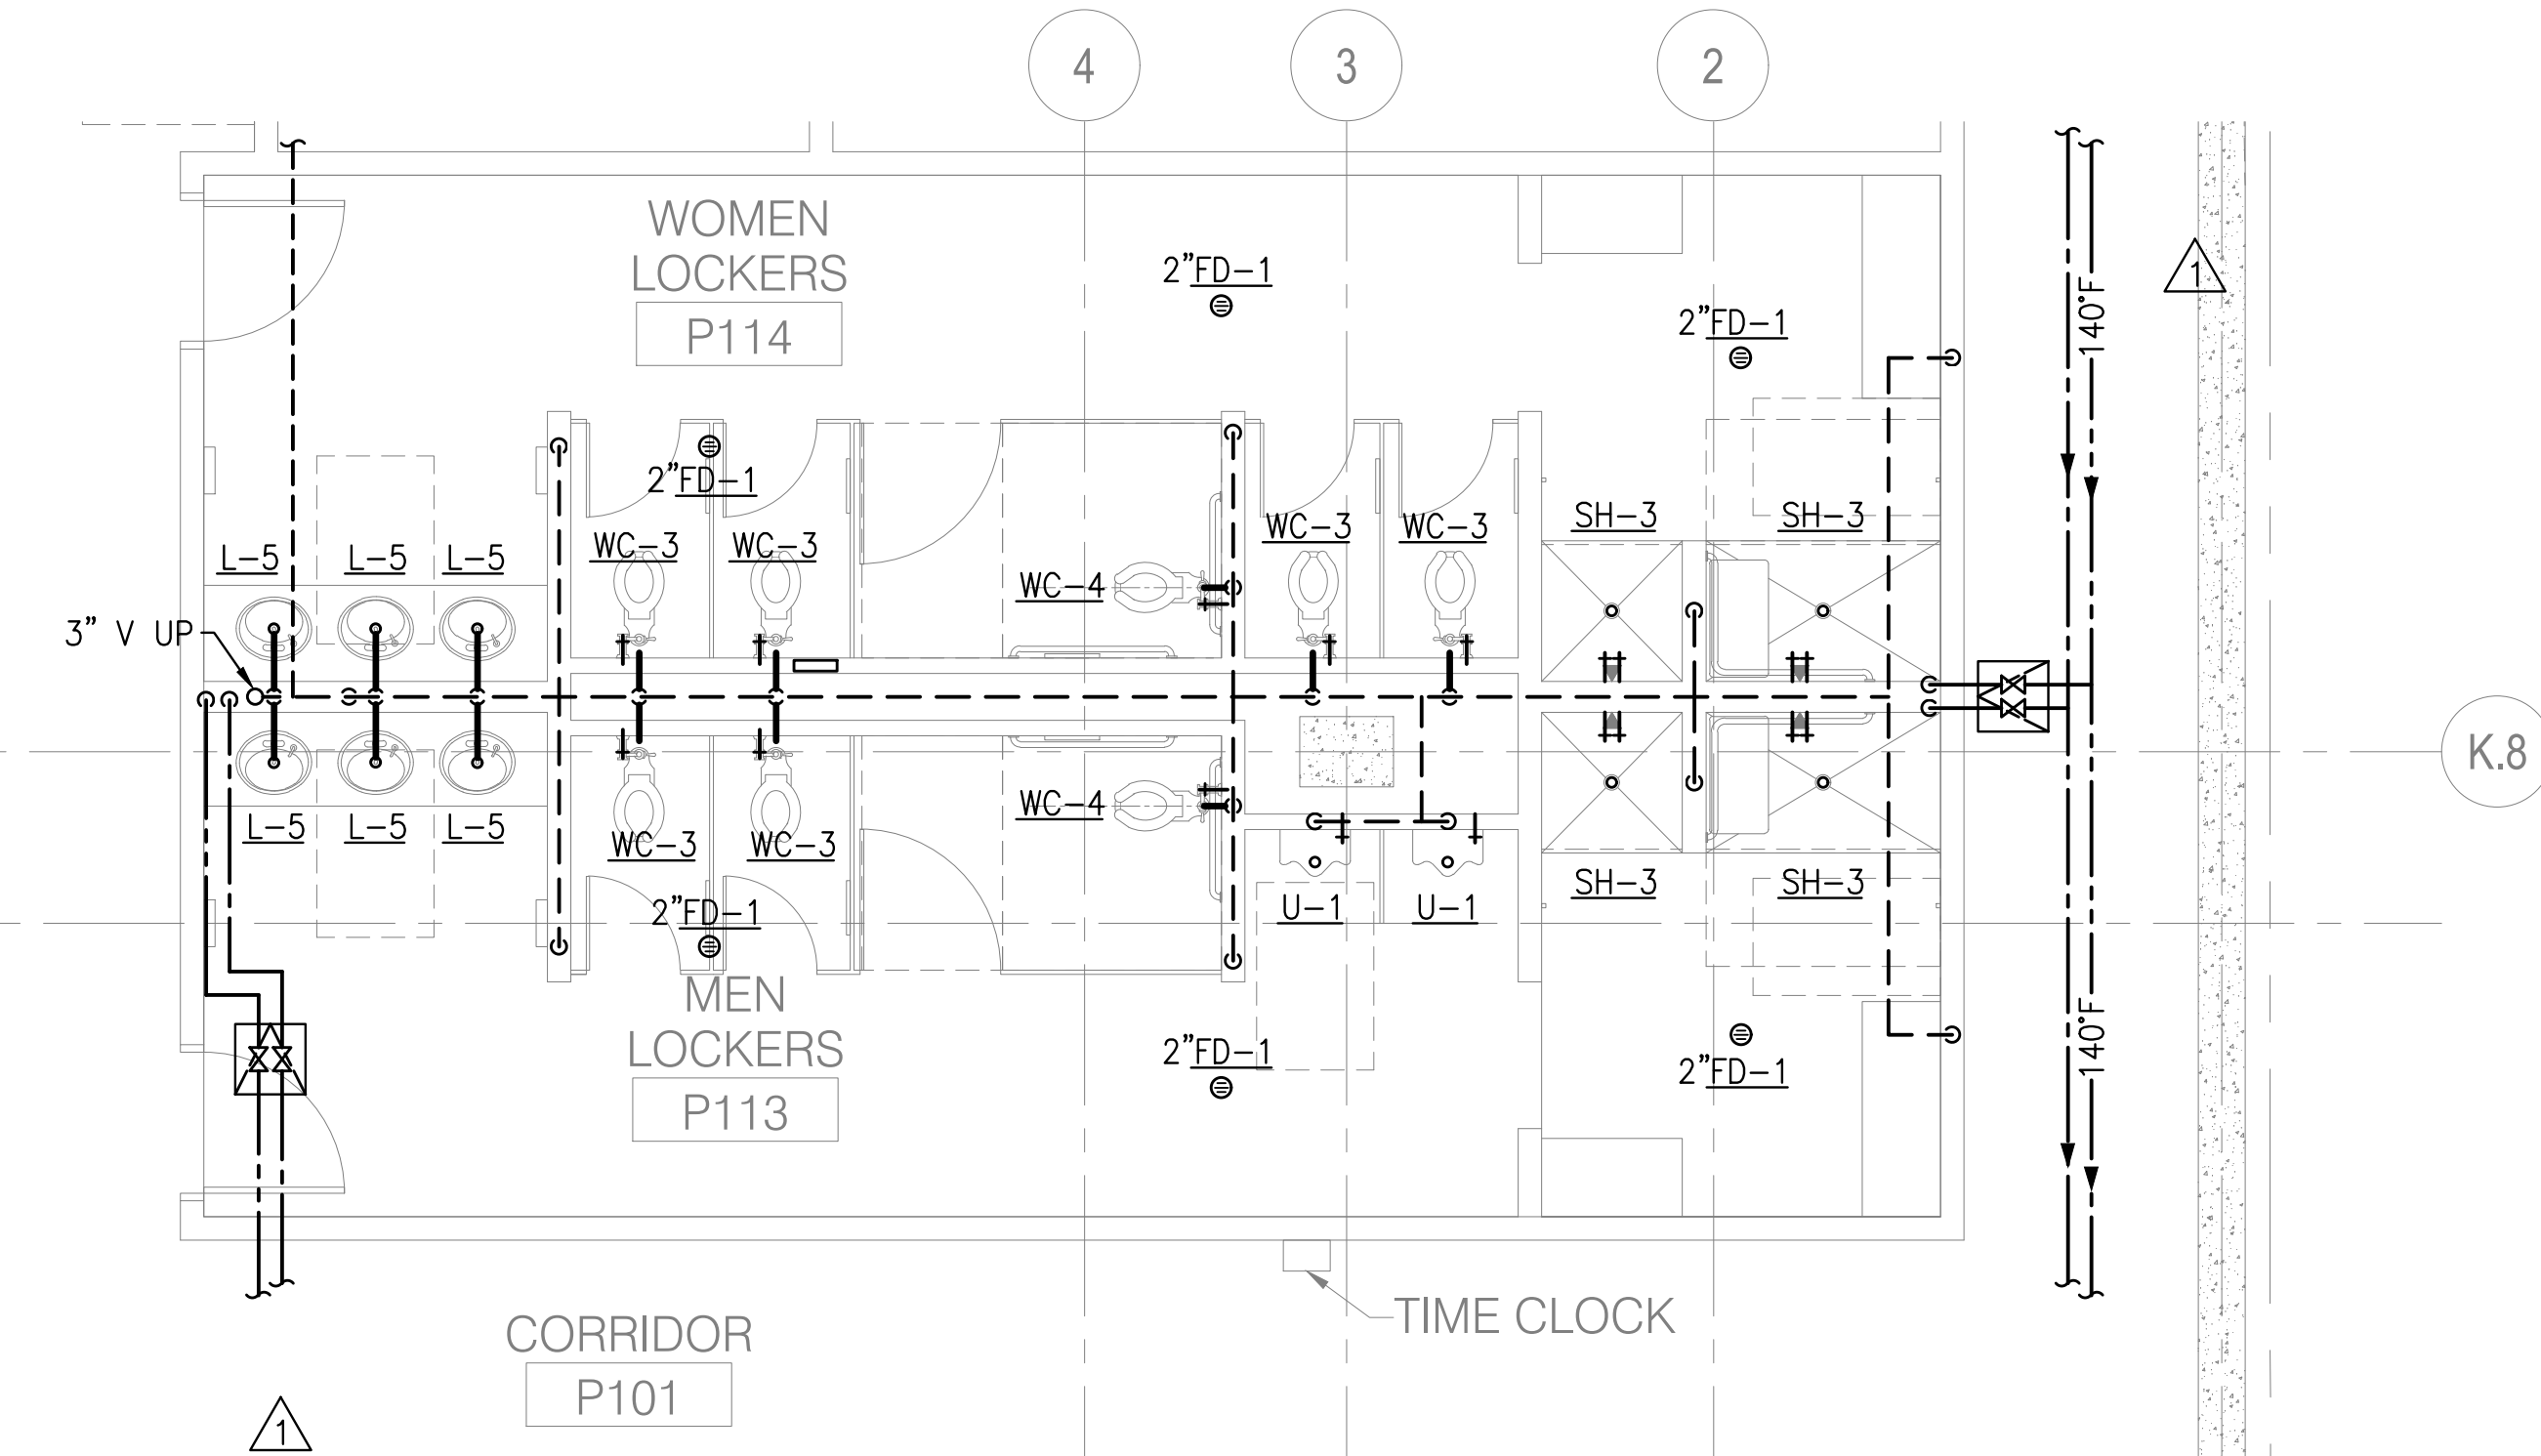

3 ENLARGED P1 LEVEL MENS AND WOMENS LOCKER ROOM
Scale: 1/4" = 1'-0"

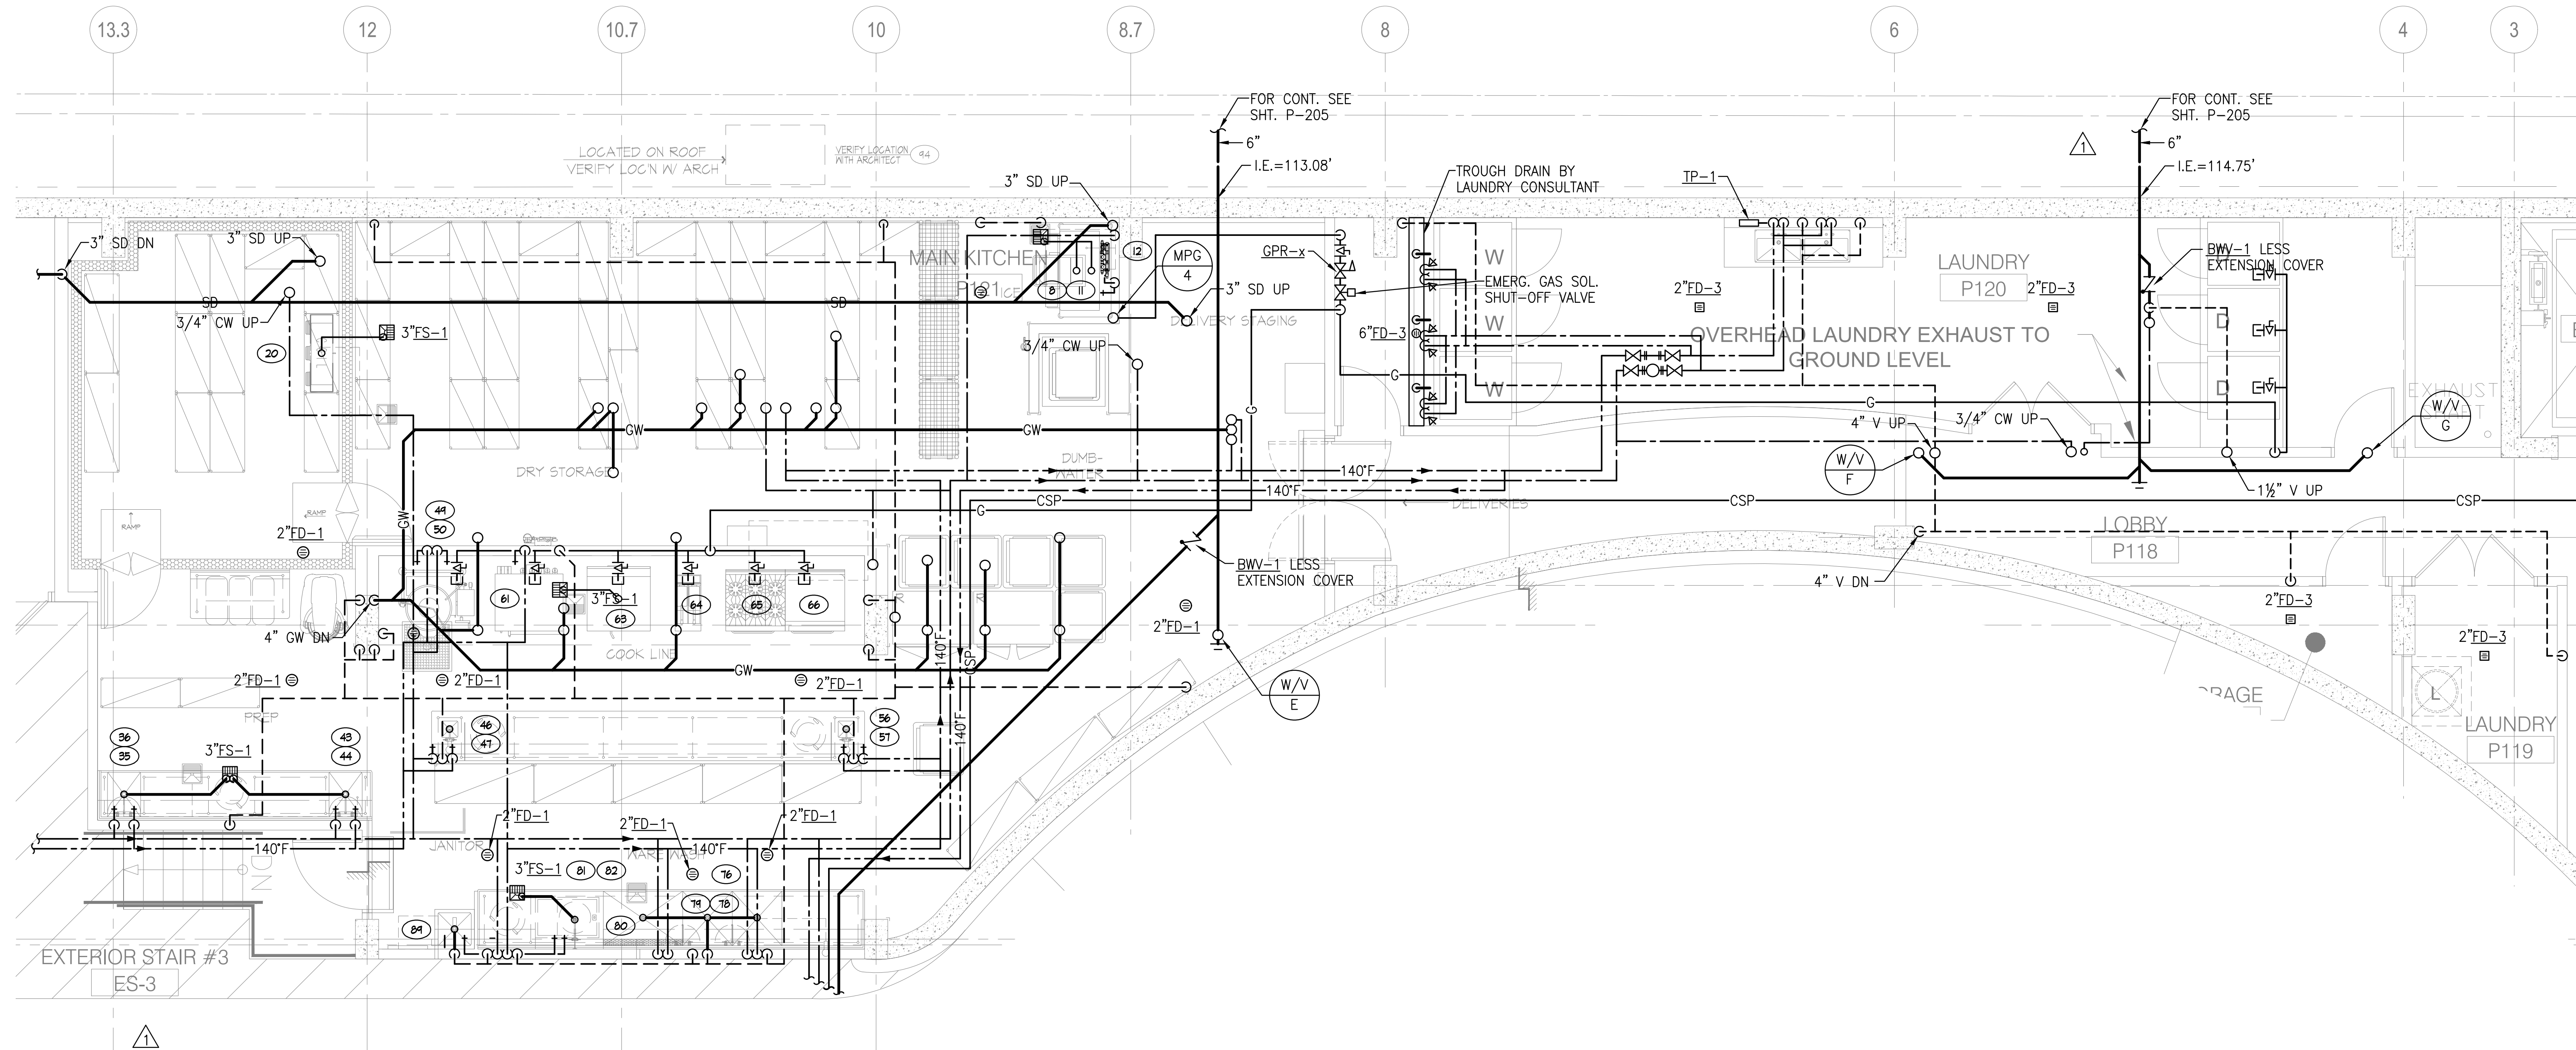

2 ENLARGED P1 LEVEL MAIN KITCHEN AND LAUNDRY FACILITY
Scale: 1/4" = 1'-0"

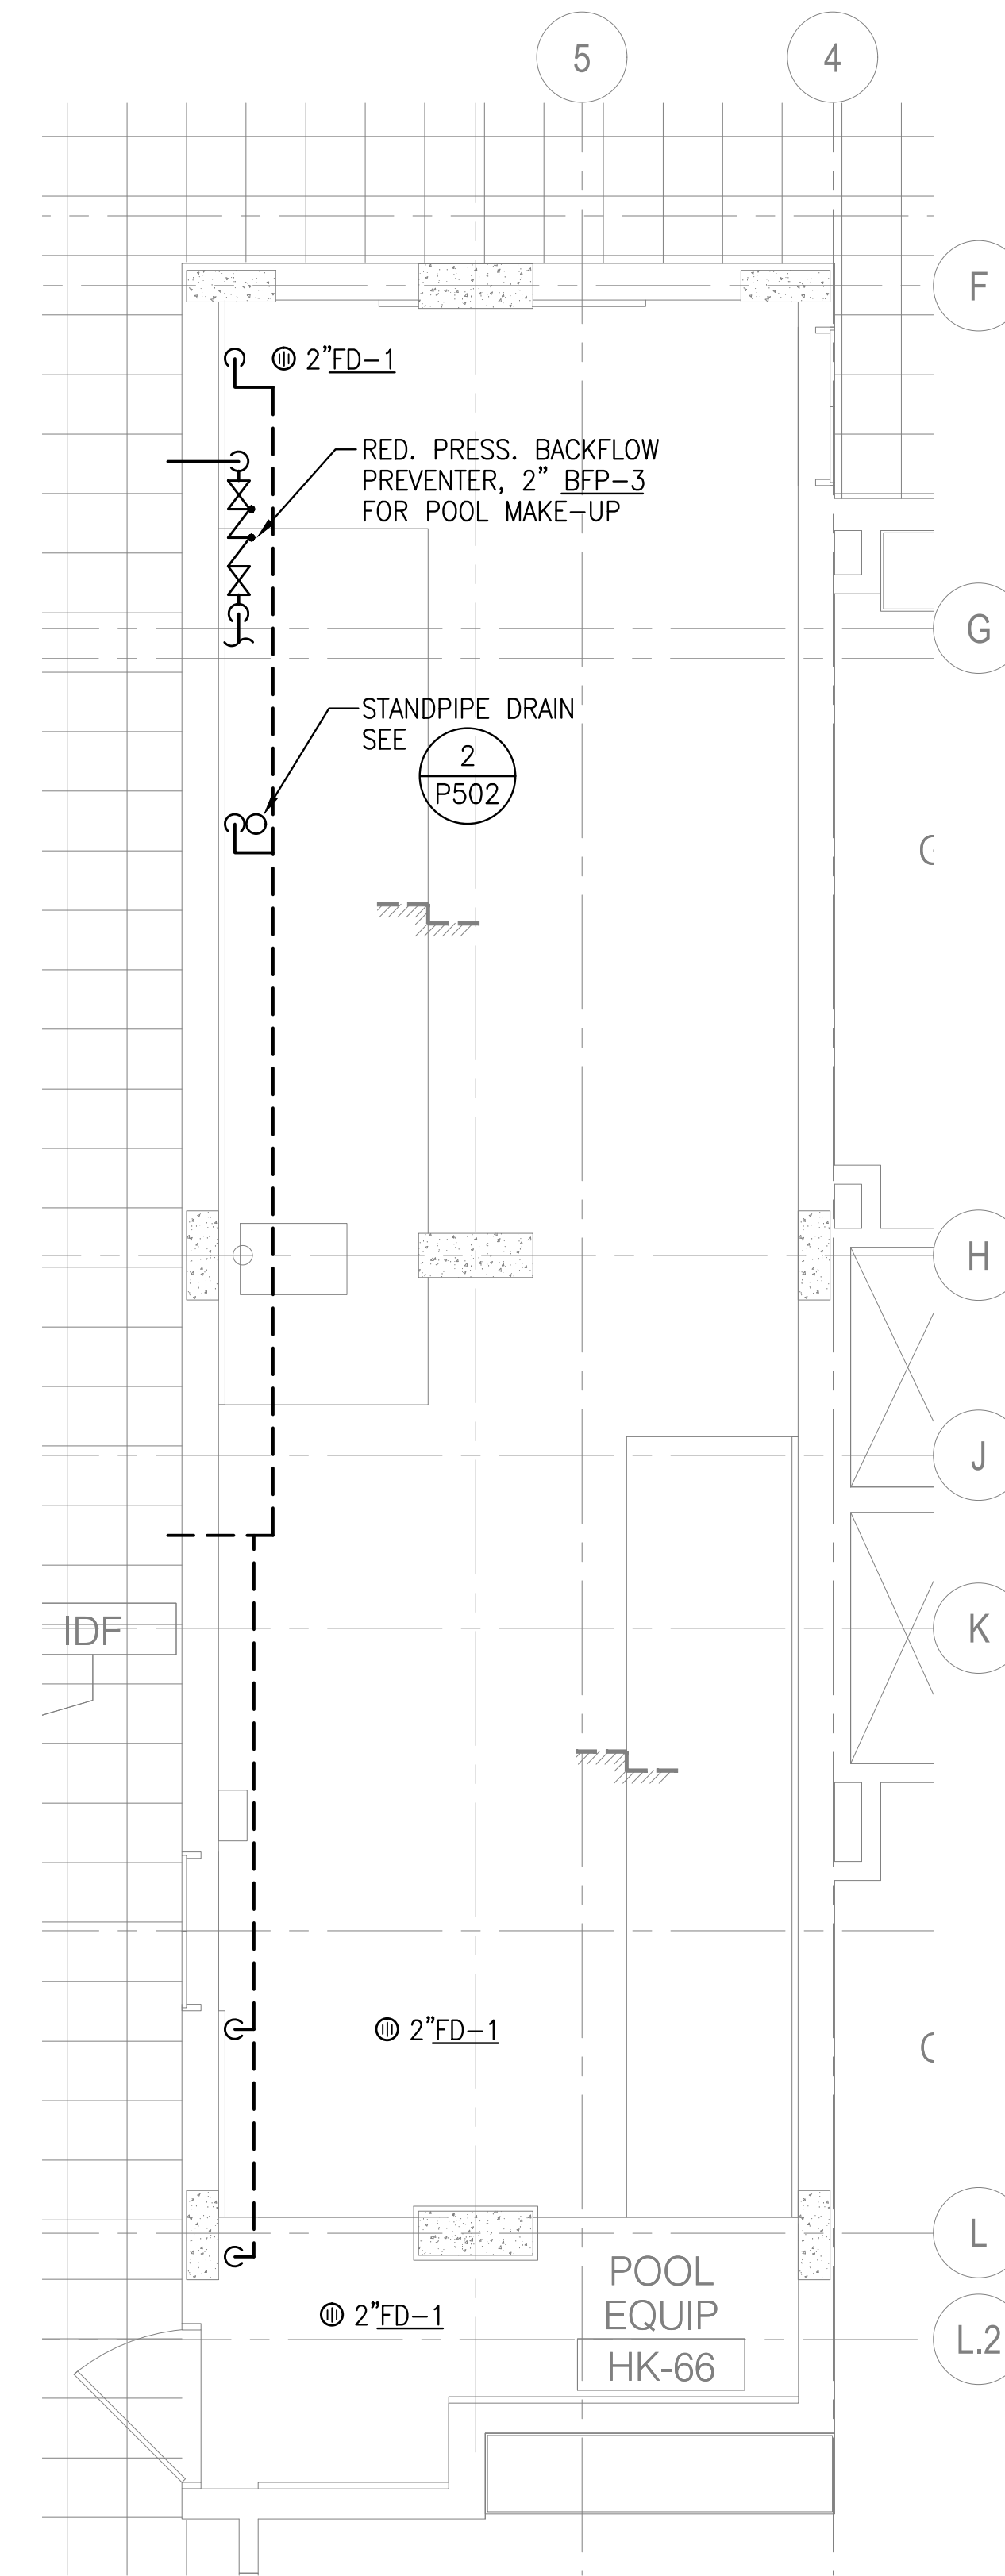

1 ENLARGED 6TH LEVEL POOL EQUIPMENT ROOM
Scale: 1/4" = 1'-0"

DATE	DESCRIPTION
05/07/2015	Medium 02
09/04/2015	Medium 03
10/20/2015	Medium 04
03/27/2016	Medium 05

hla
howard laks architects
1545 wealth street
santa monica, ca 90401
voice : 310-393-4465
fax : 310-393-2230

CONSULTANTS
Donald F. Dickerson Associates
CONSULTING MECHANICAL & ELECTRICAL ENGINEERS
1545 WEALTH STREET, SUITE 404
SANTA MONICA, CA 90401
(310) 393-2230
E-MAIL: DONALD@DFA.COM

710 WILSHIRE BOULEVARD
MIXED-USE HOTEL PROJECT
SANTA MONICA - CALIFORNIA 90401
ENLARGED PLUMBING PLANS

DRAWN	---
CHECKED	---
APPROVED	---
SCALE	AS NOTED
SHEET	---
P-301	
DATE	June 25, 2013
PROJECT NUMBER	H.A. 0000000-00000