




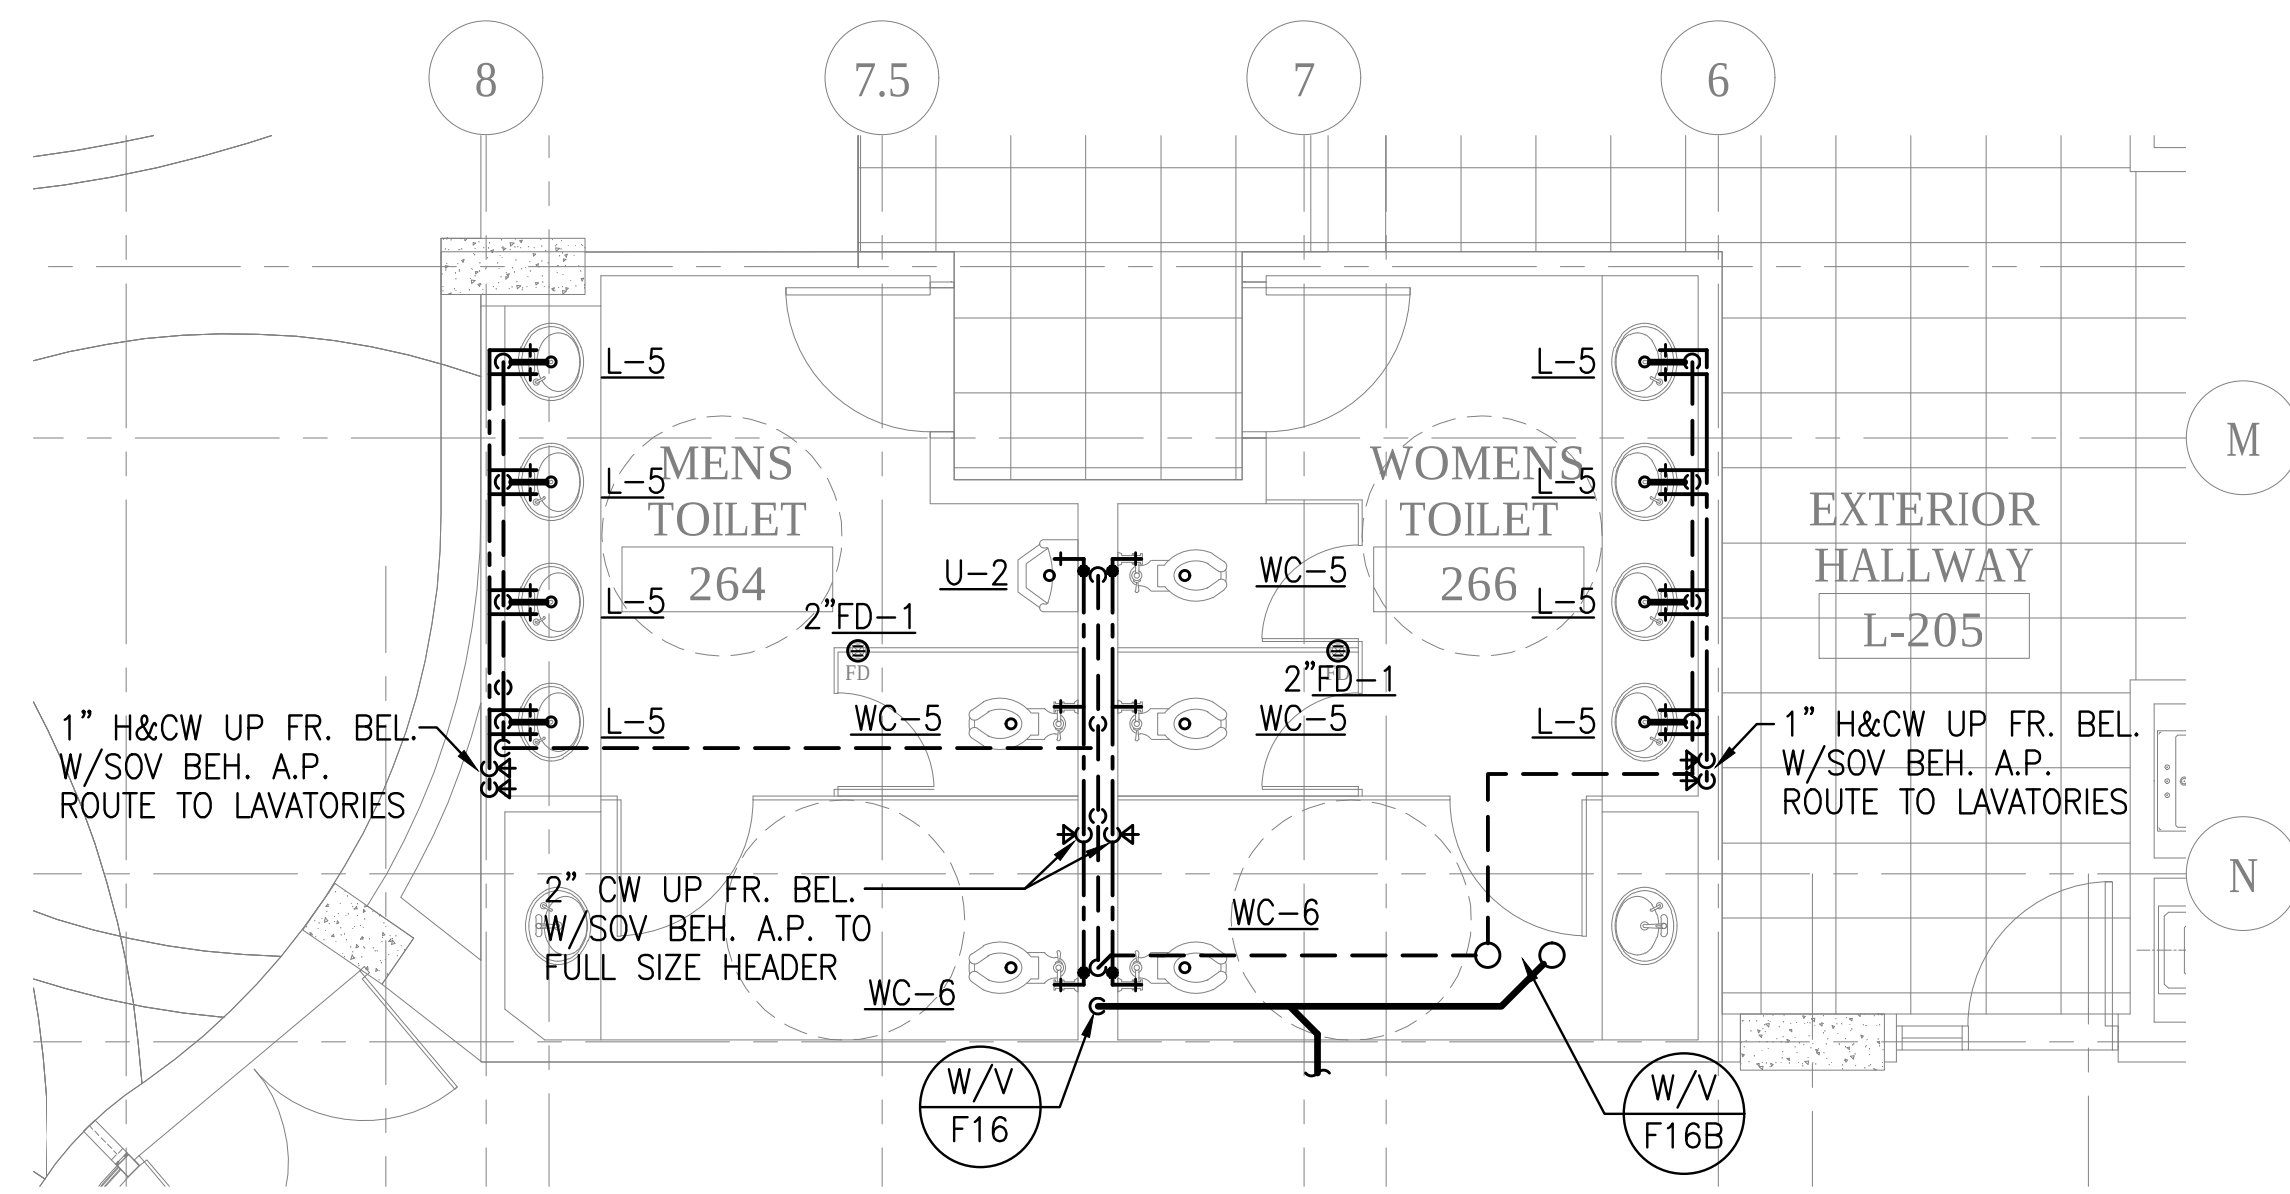


4 ENLARGED LEVEL 2 TOILET ROOM
Scale: 1/4" = 1'-0"

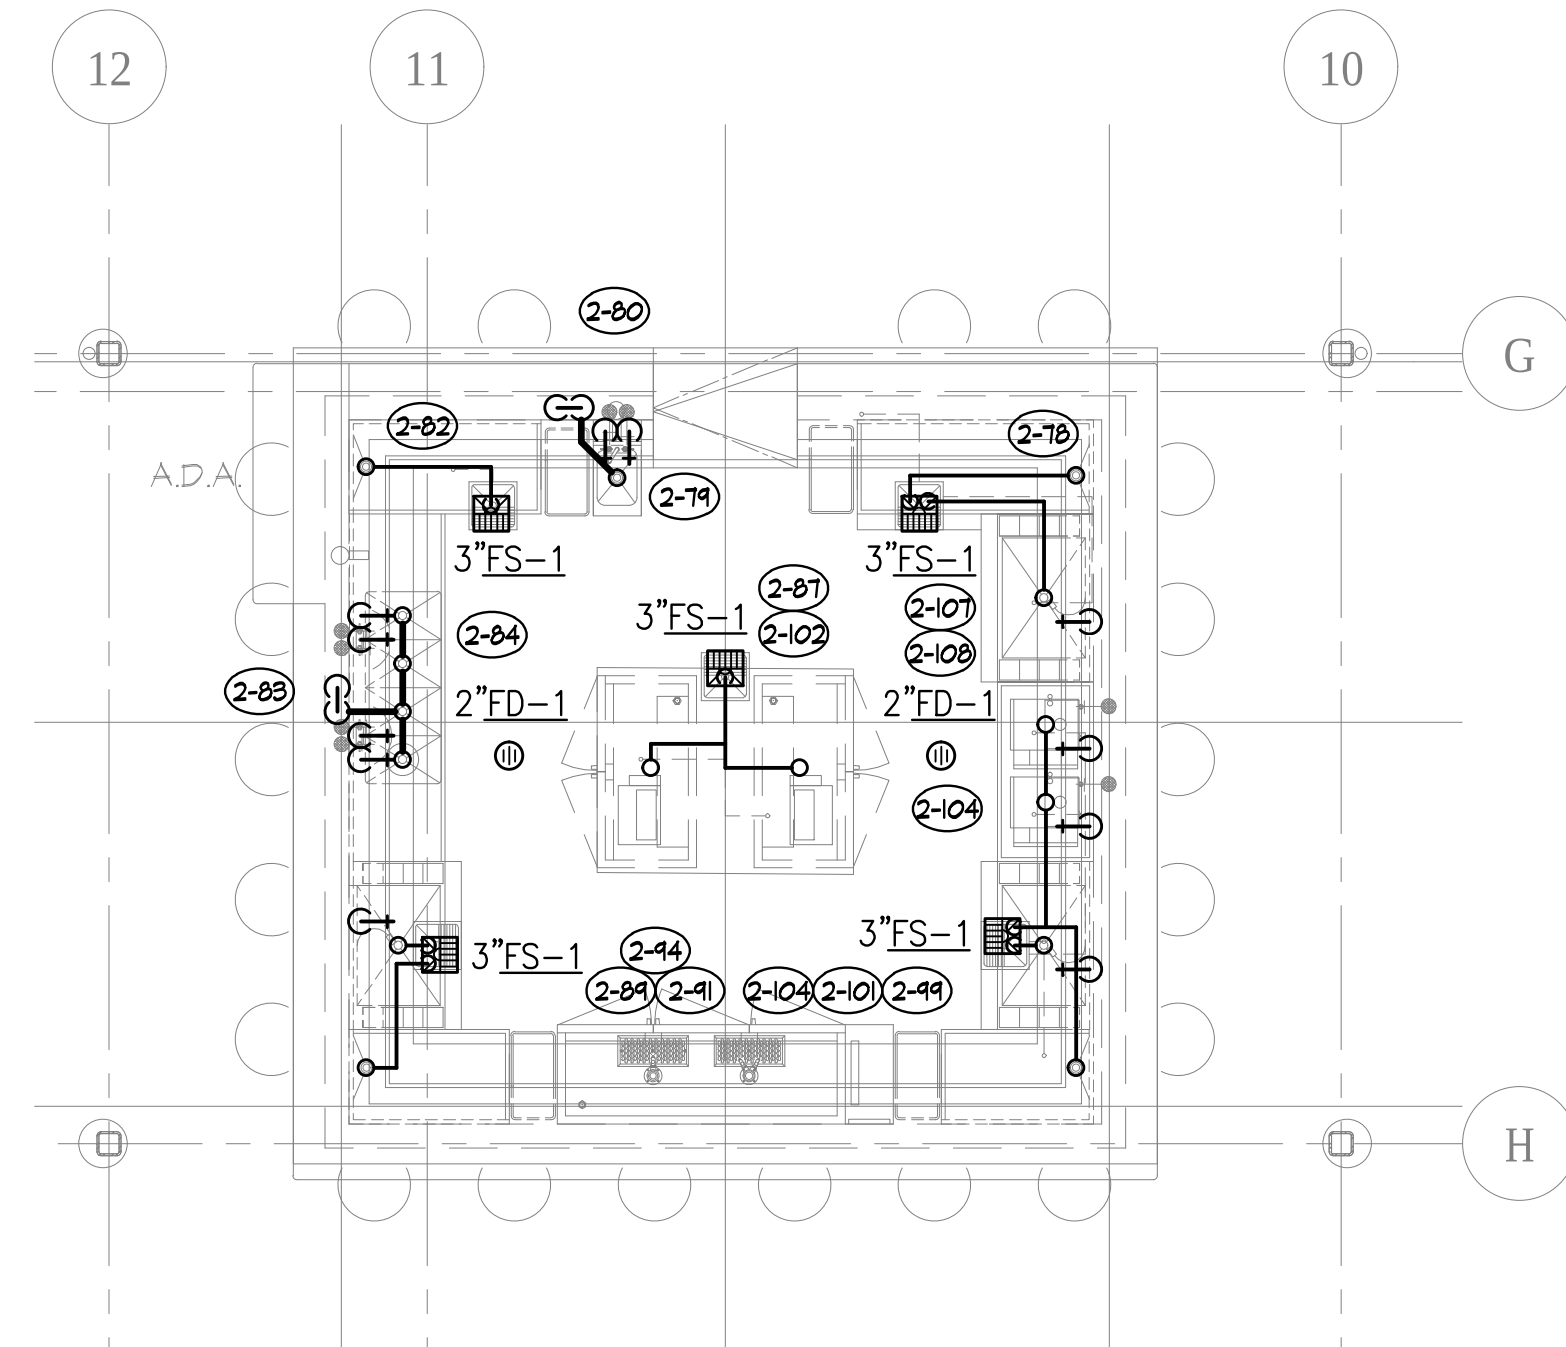


3 ENLARGED LEVEL 7 COCKTAIL BAR
Scale: 1/4" = 1'-0"

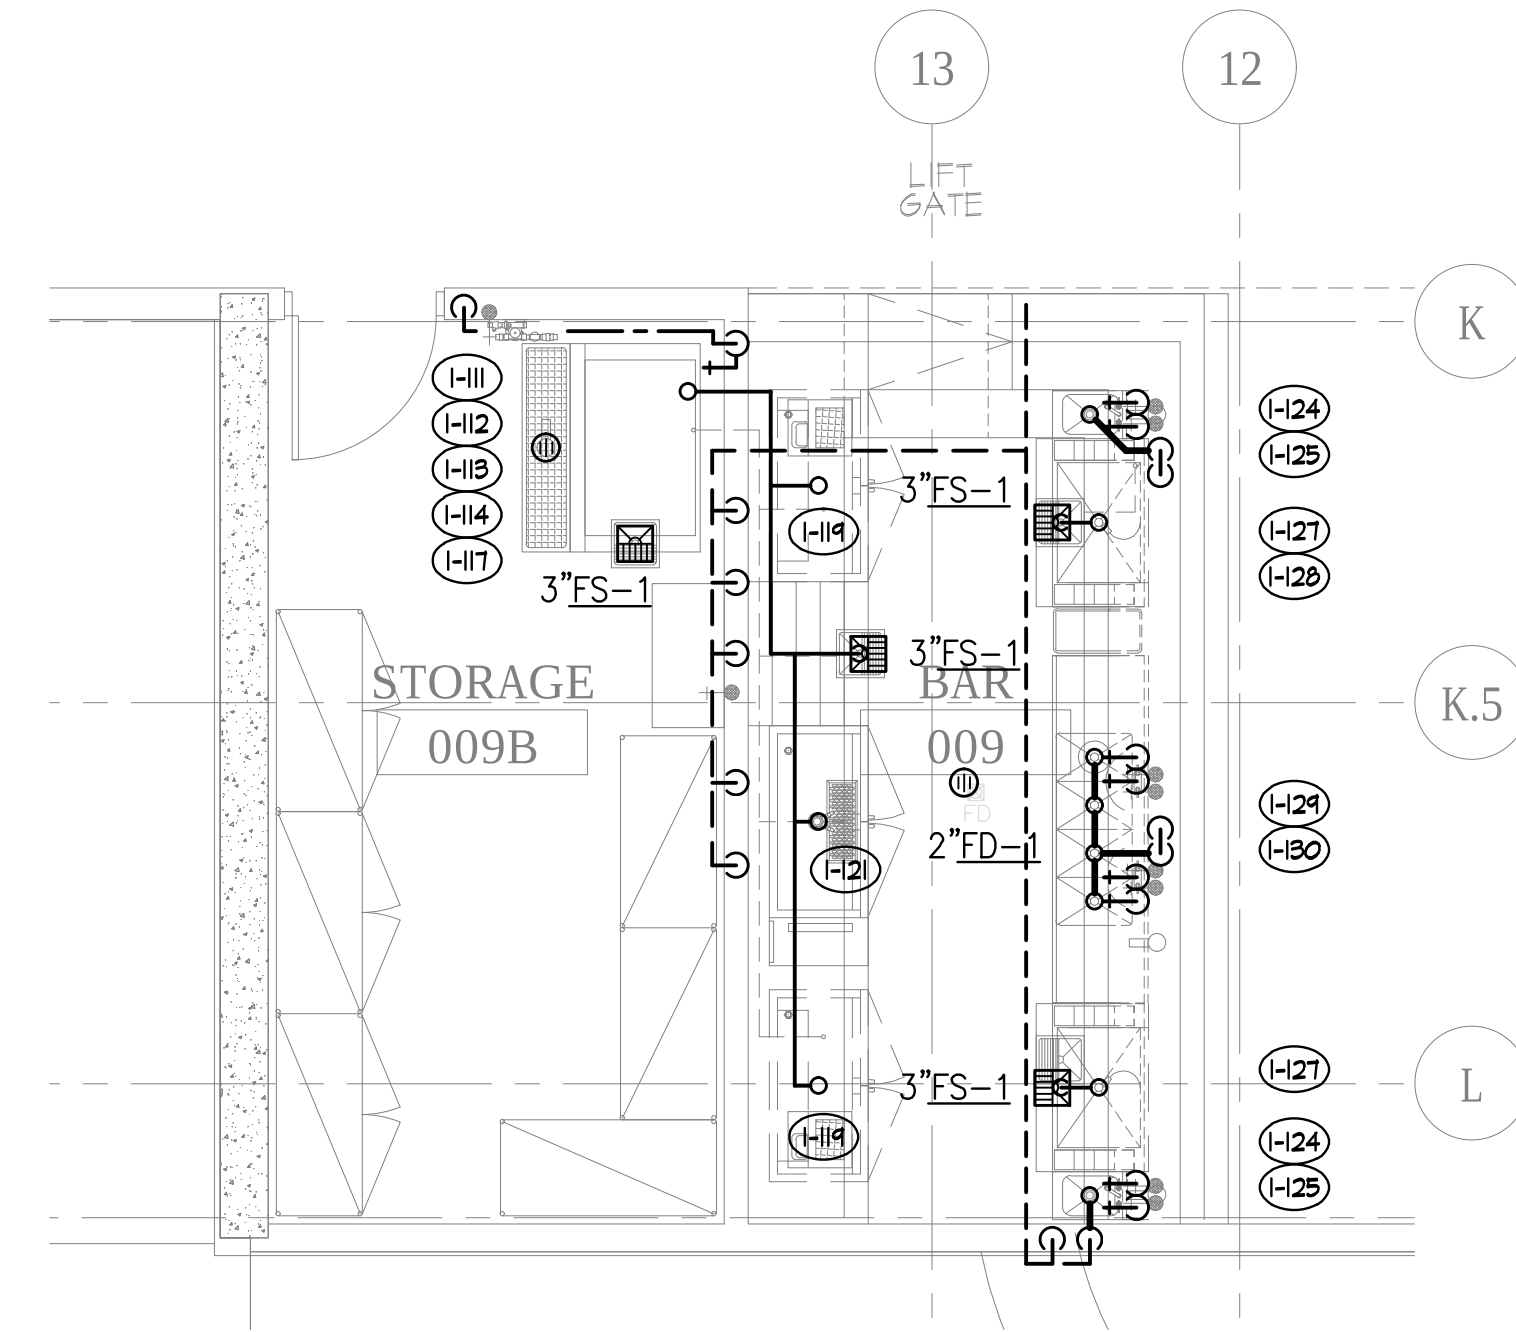


2 ENLARGED GROUND LEVEL PRE-FUNCTION BAR
Scale: 1/4" = 1'-0"

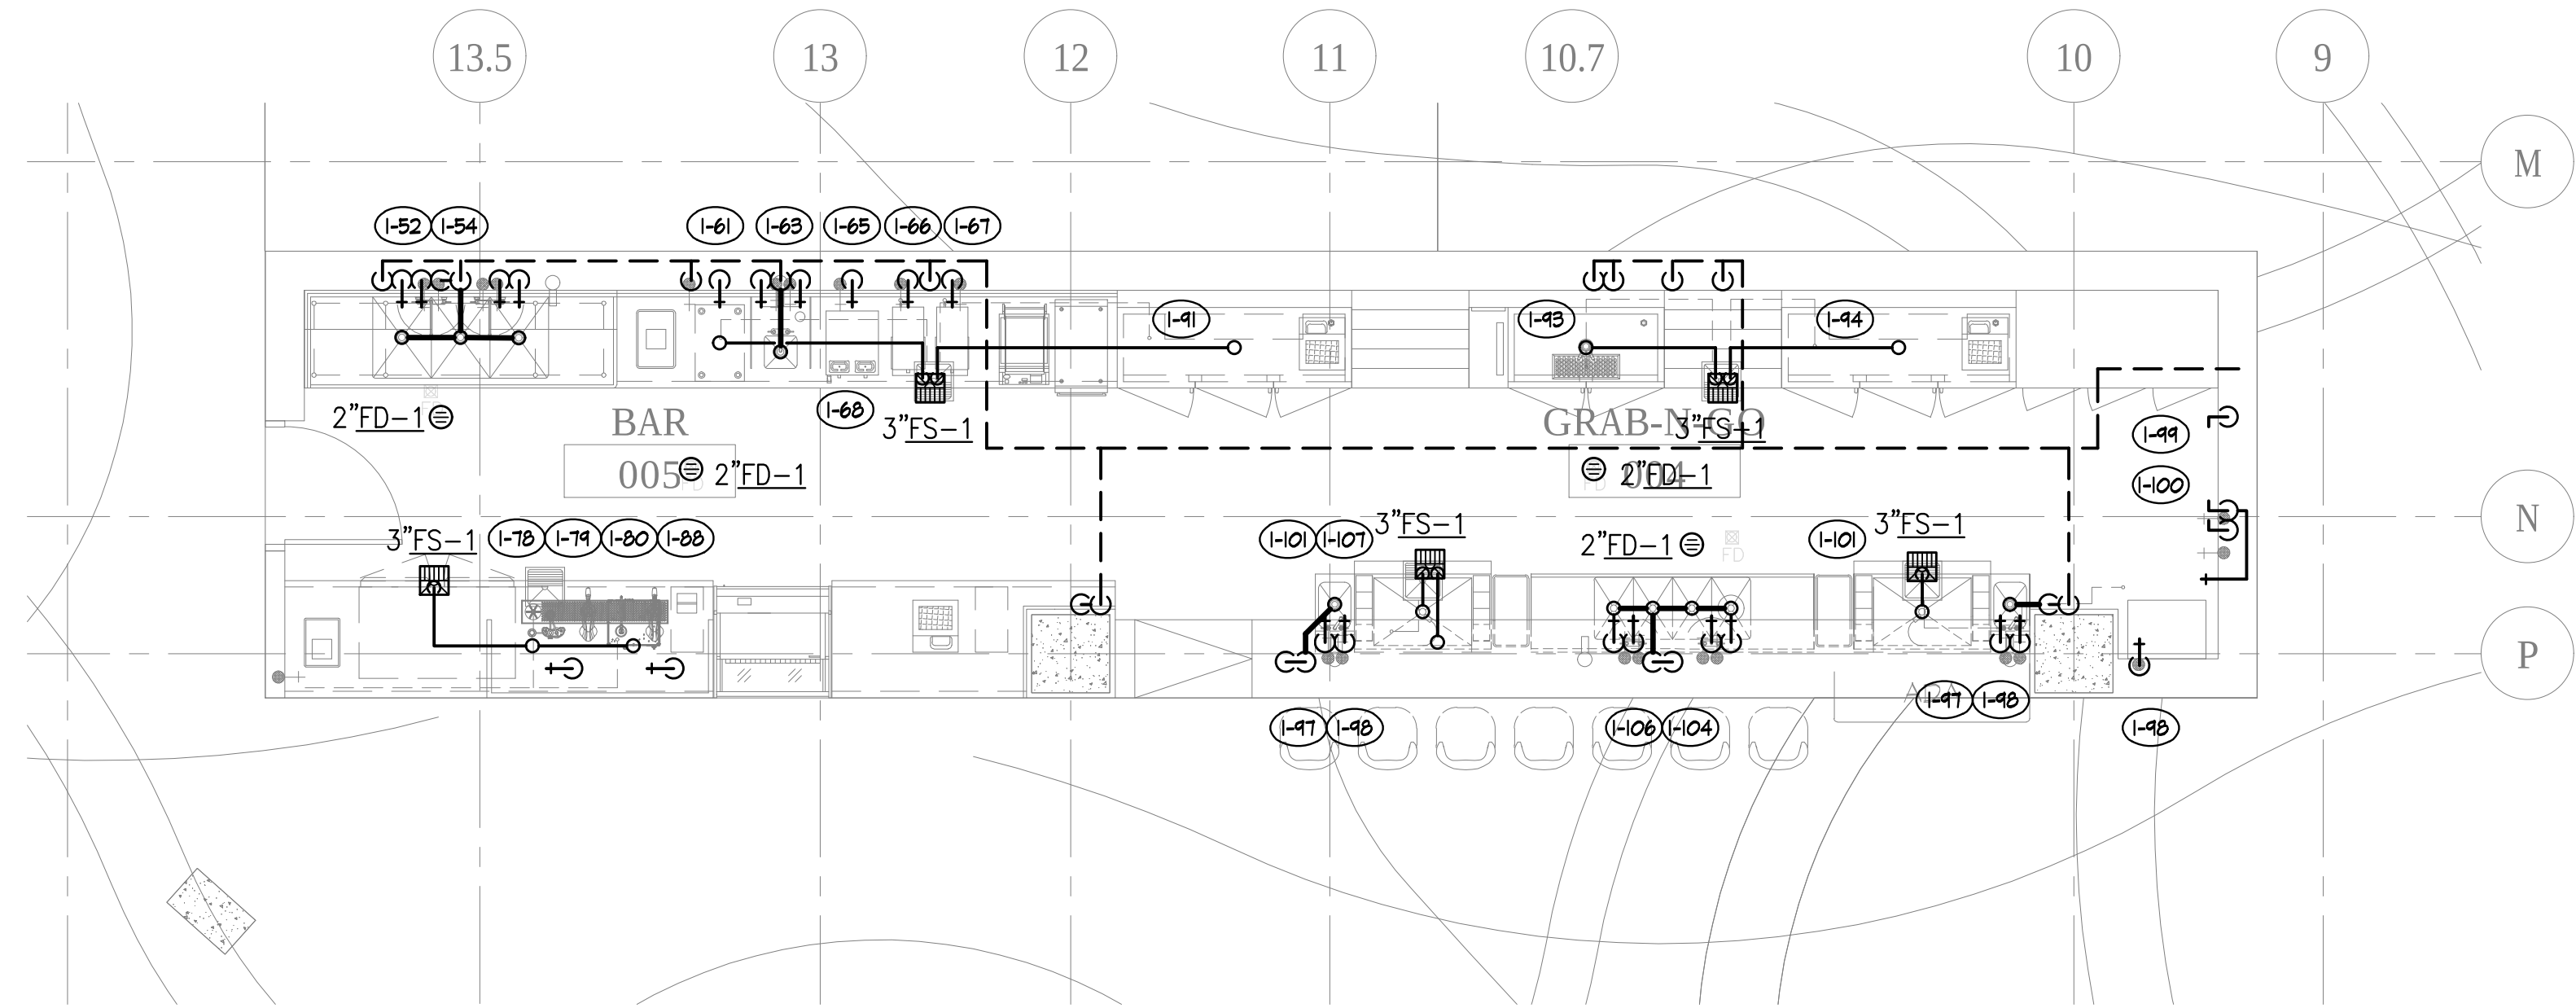


1 ENLARGED GROUND LEVEL GRAB-N-GO
Scale: 1/4" = 1'-0"

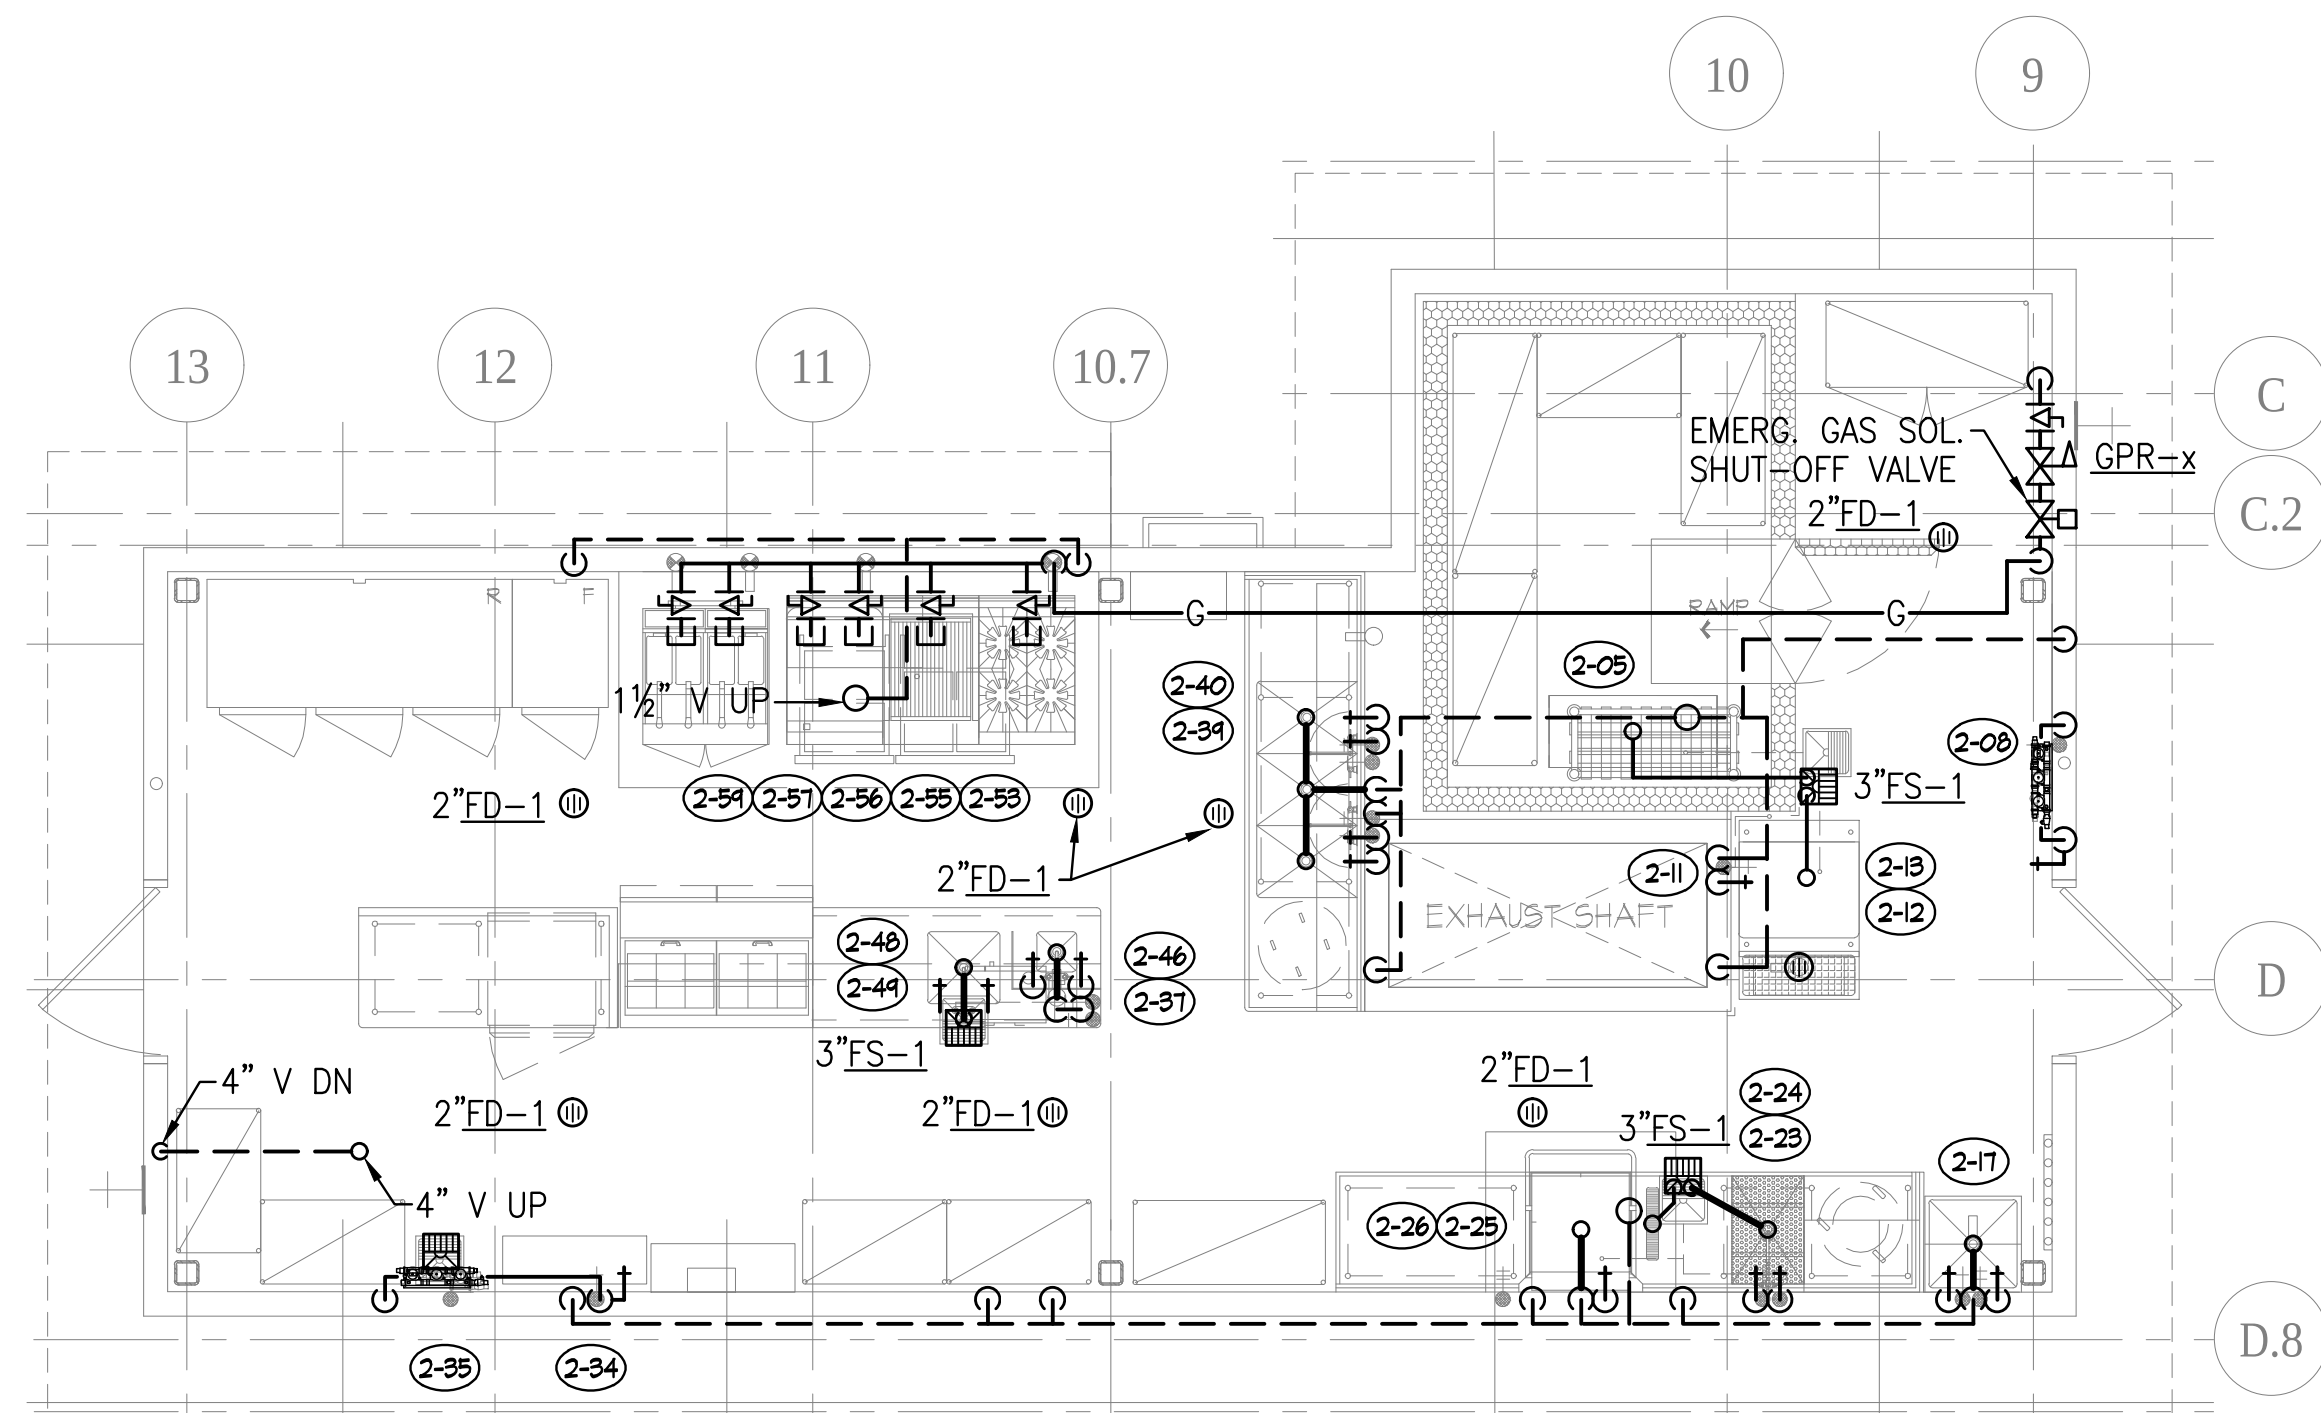

7 ENLARGED LEVEL 7 KITCHEN
Scale: 1/4" = 1'-0"

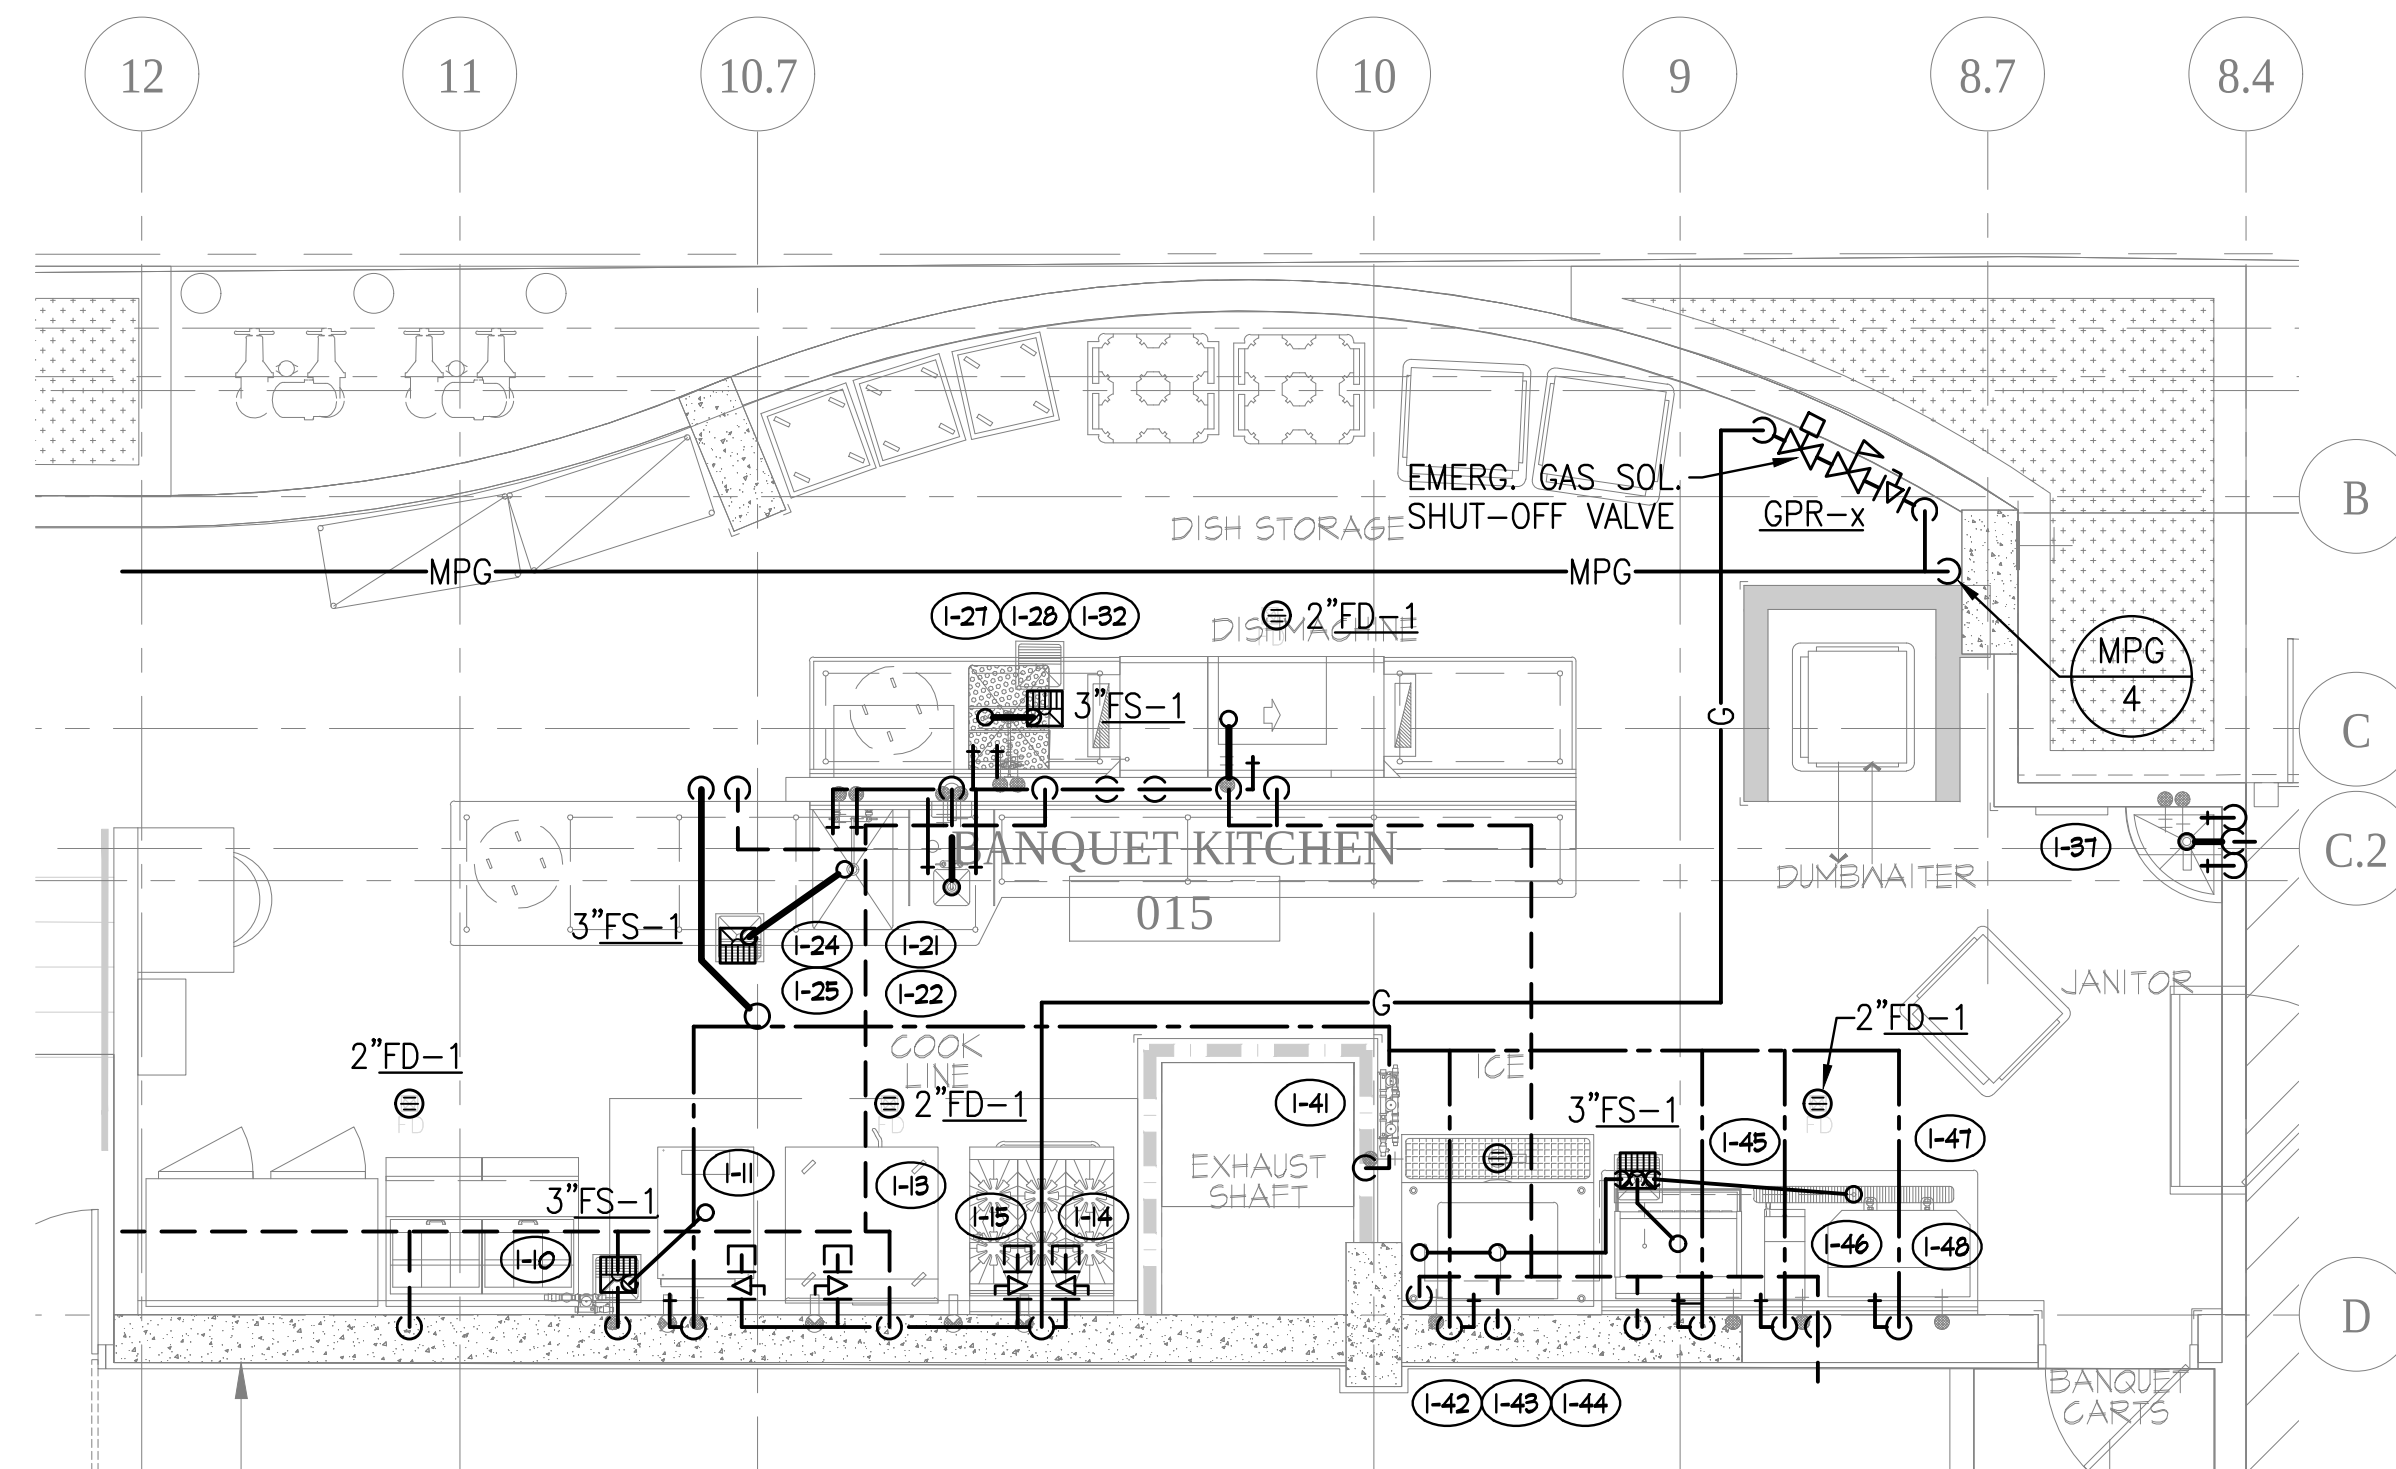

6 ENLARGED GROUND LEVEL BANQUET KITCHEN
Scale: 1/4" = 1'-0"

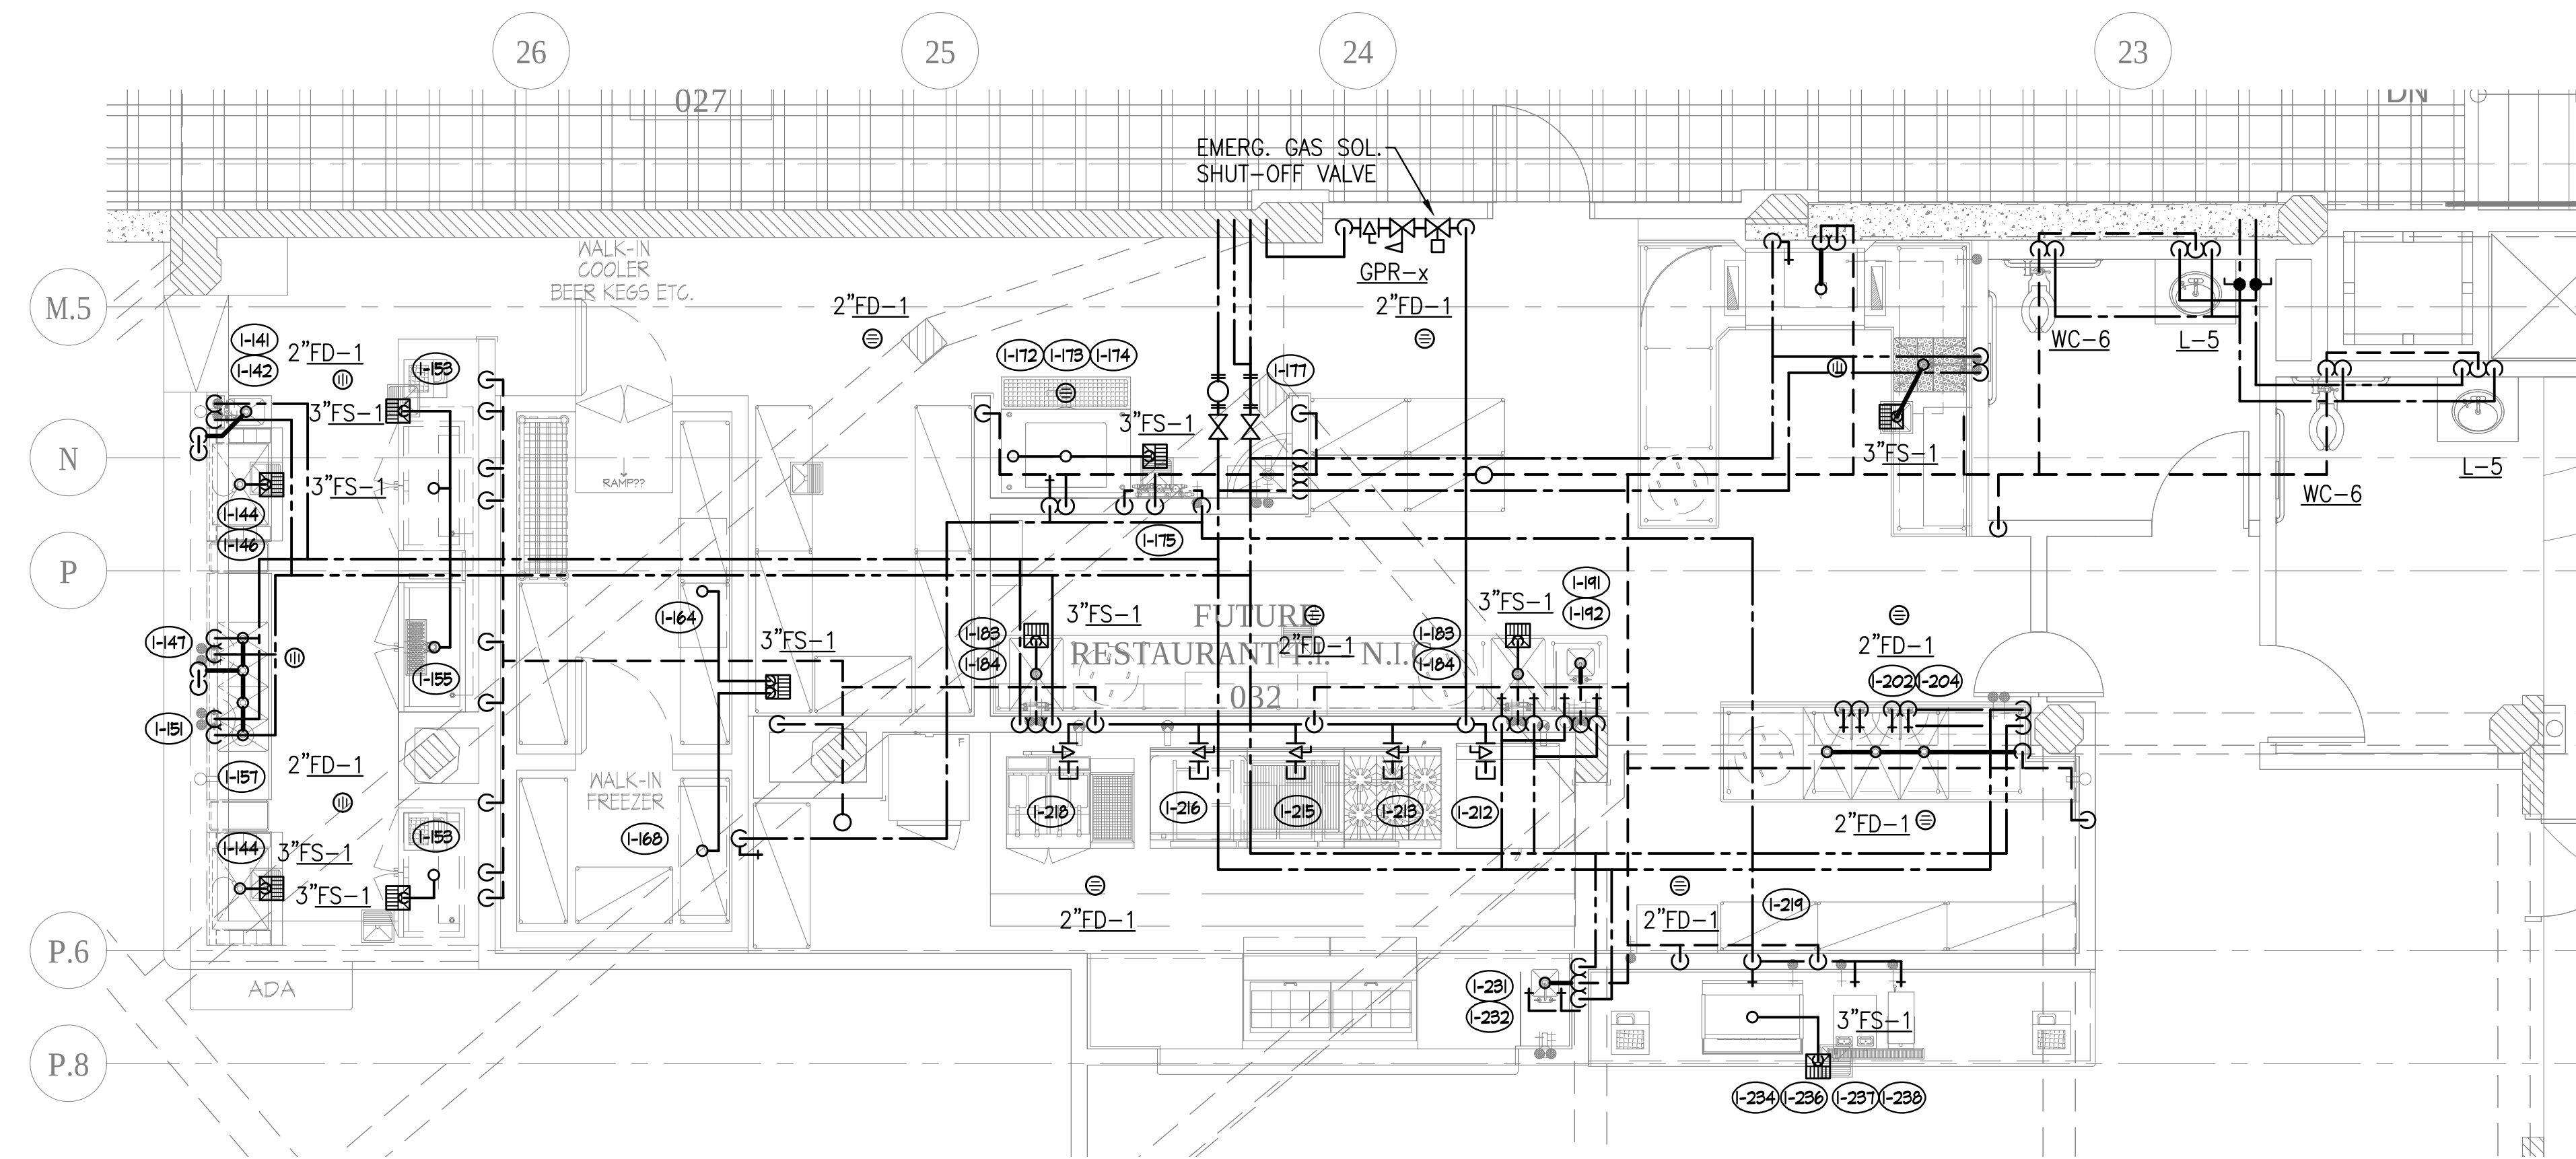


5 ENLARGED GROUND LEVEL LANDMARK RESTAURANT
Scale: 1/4" = 1'-0"

REVISION	DATE	DESCRIPTION
1	05/07/2015	Medium 02
2	08/04/2015	Medium 03
3	10/20/2015	Medium 04
4	05/27/2016	Medium 05



howard laks architects
1545 wealth street
santa monica, ca 90401
voice : 310-393-4465
fax : 310-393-2230

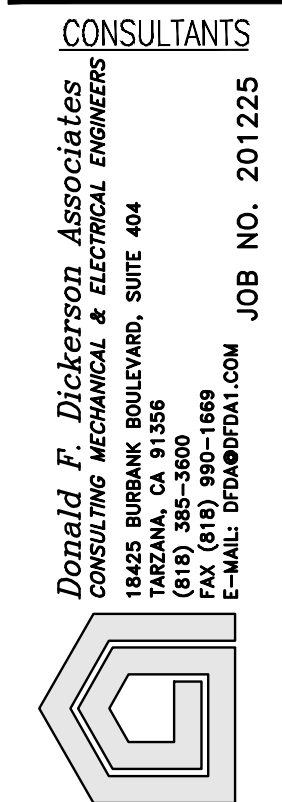

710 WILSHIRE BOULEVARD
MIXED-USE HOTEL PROJECT
SANTA MONICA - CALIFORNIA 90401
ENLARGED PLUMBING PLANS

DRAWN	---
CHECKED	---
APPROVED	---
SCALE	AS NOTED
SHEET	P-302
DATE	June 25, 2013
PROJECT NUMBER	H.A. 0000000-00000