


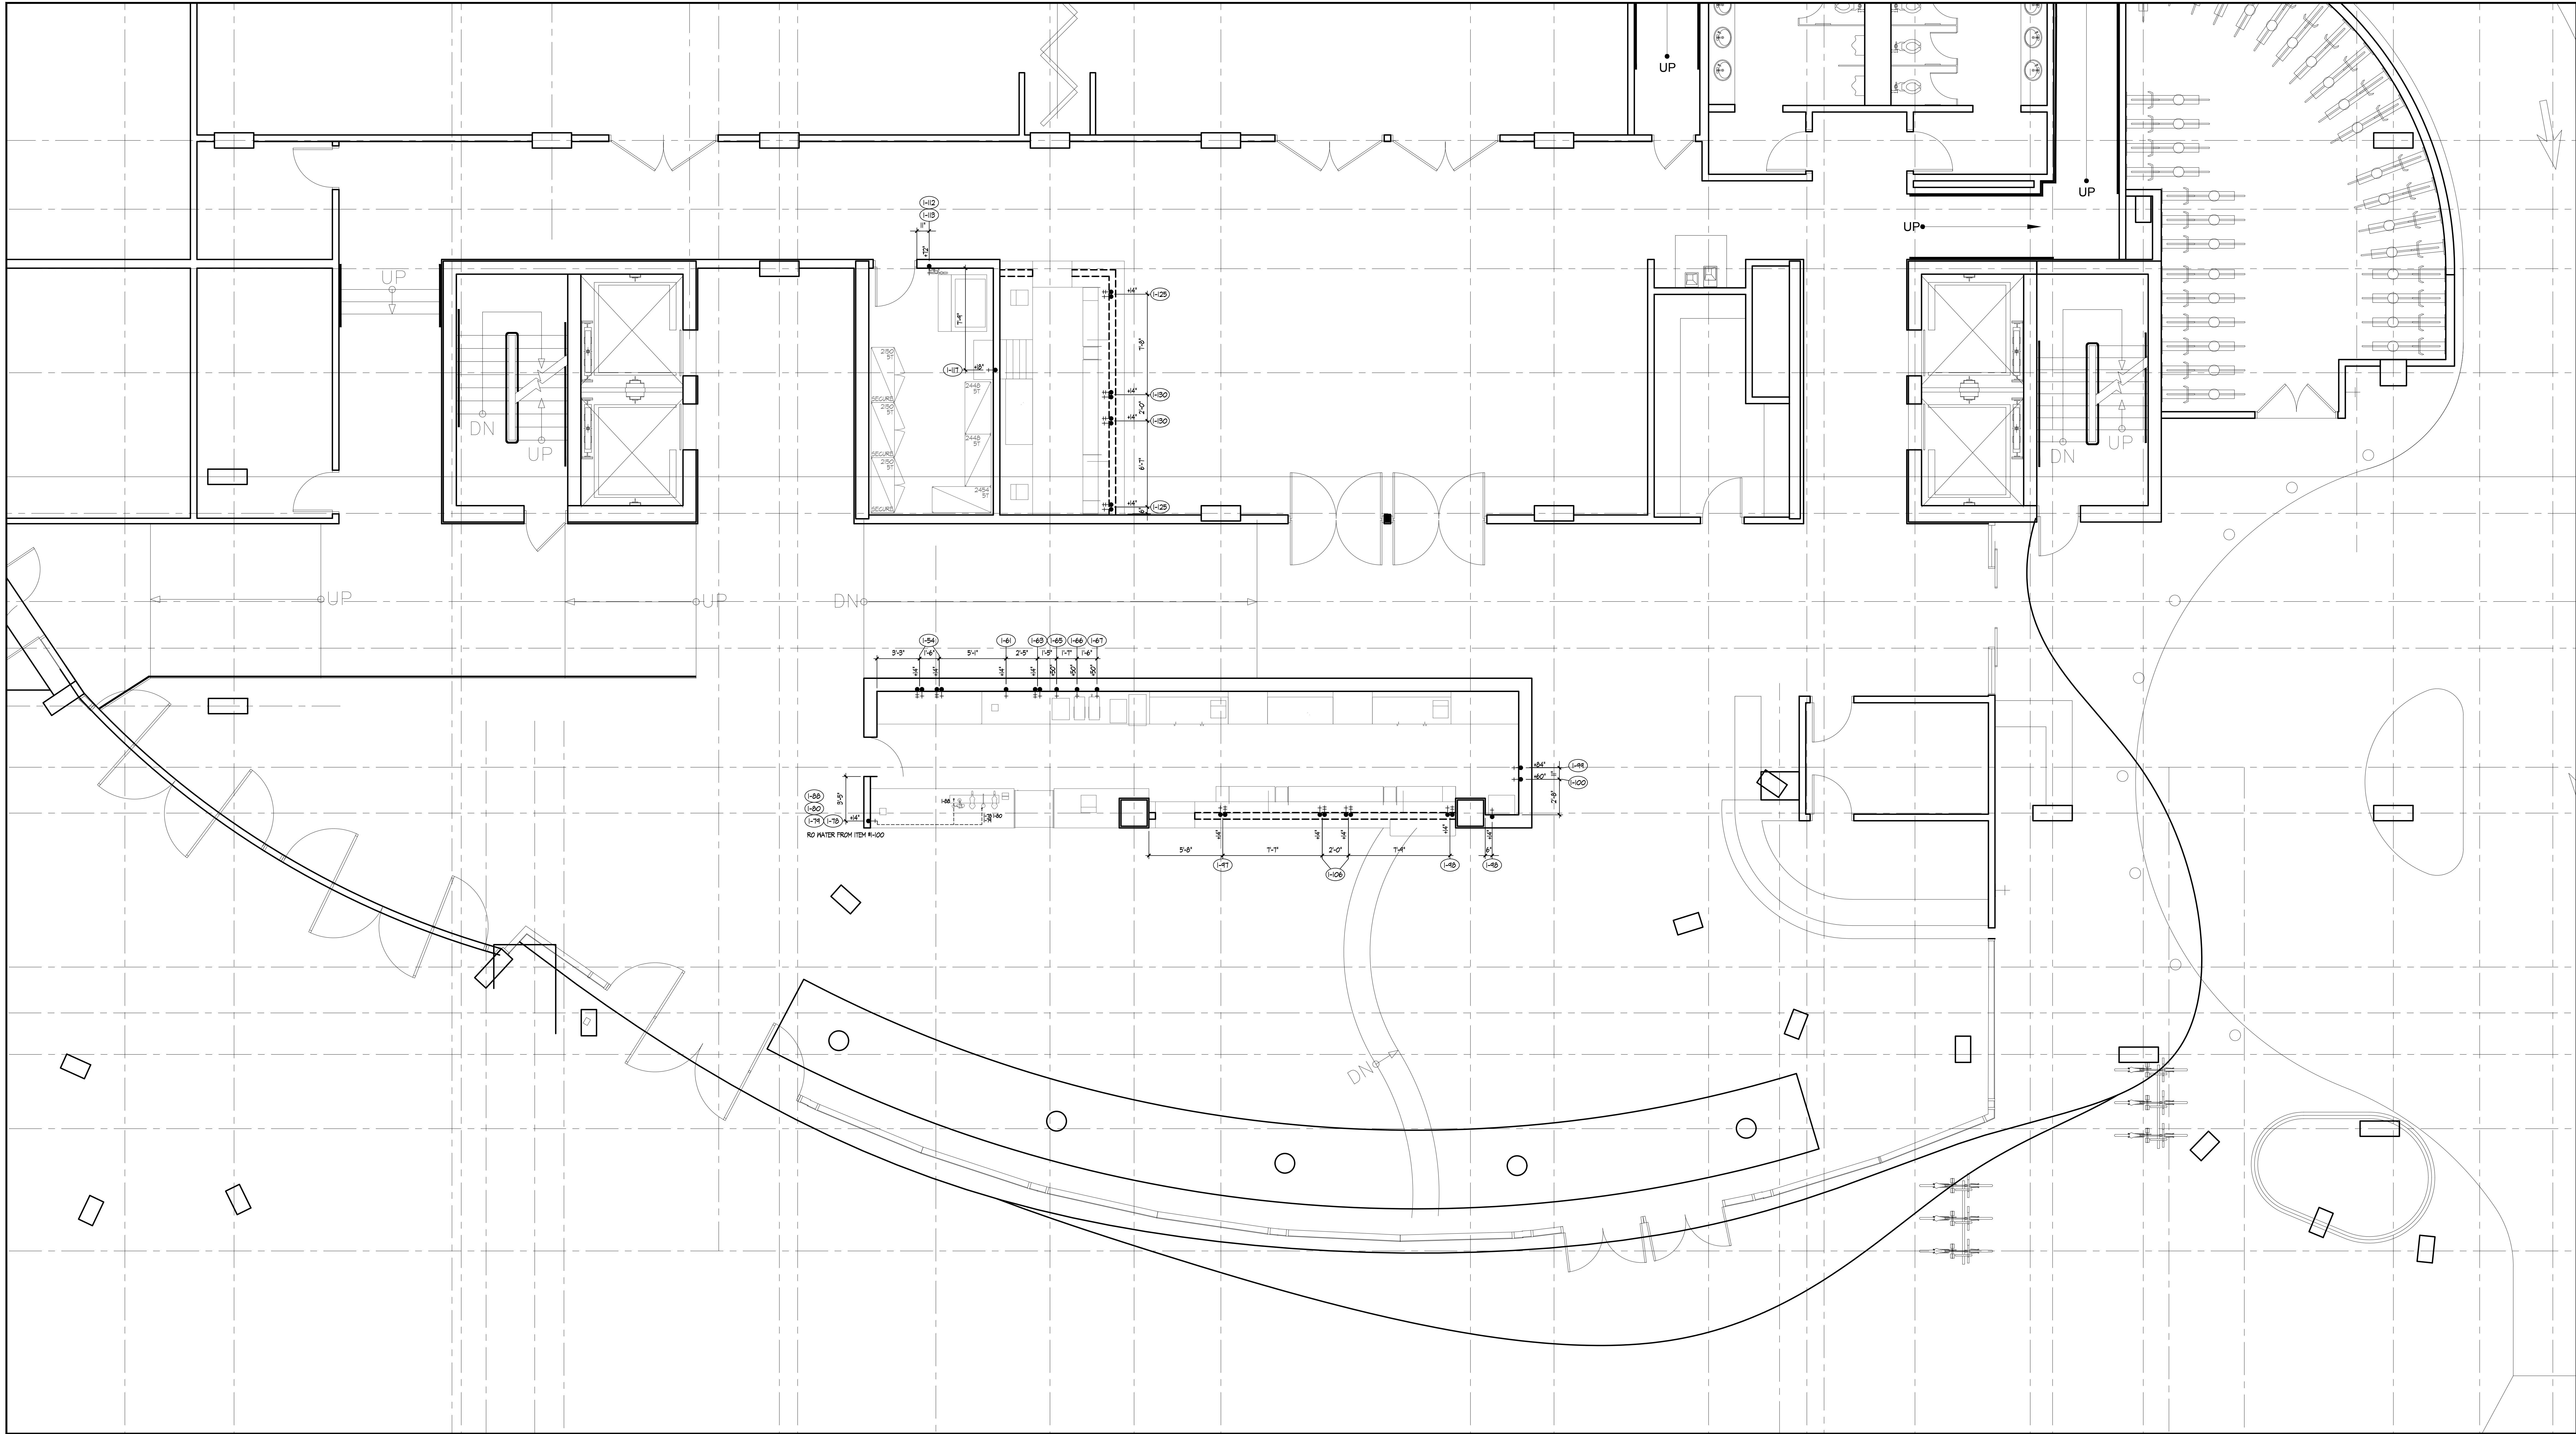

LOBBY BAR PLUMBING PLAN

DESIGN	DATE	DESCRIPTION
1	05/07/2013	MECHANICAL
2	06/04/2013	MECHANICAL
3	06/04/2013	MECHANICAL
4	06/04/2013	MECHANICAL
5	06/04/2013	MECHANICAL

hla
howard laks architects
1545 Lowell Street
Santa Monica, CA 90401
voice : 310-393-4465
fax : 310-393-2220

Kitchen Professionals
16742 Colwood Street, Suite 103
Huntington Beach, CA 92647
Phone: 714.841.0531 Fax: 714.841.9986

710 WILSHIRE BOULEVARD
MIXED-USE HOTEL PROJECT
SANTA MONICA - CALIFORNIA, 90401
LOBBY BAR PLUMBING PLAN

DRAWN	JL
CHECKED	CH
APPROVED	-
SCALE	1/4" = 1'-0"
SHEET	K-1.3.5
DATE	June 25, 2013
PROJECT NUMBER	H.A. 0000000-00000