




THREE MEAL RESTAURANT PLUMBING PLAN

DESIGN	DATE	REVISION
1	05/07/2013	Medium 02
2	06/04/2013	Medium 03
3	10/20/2013	Medium 04
4	05/27/2016	Medium 05

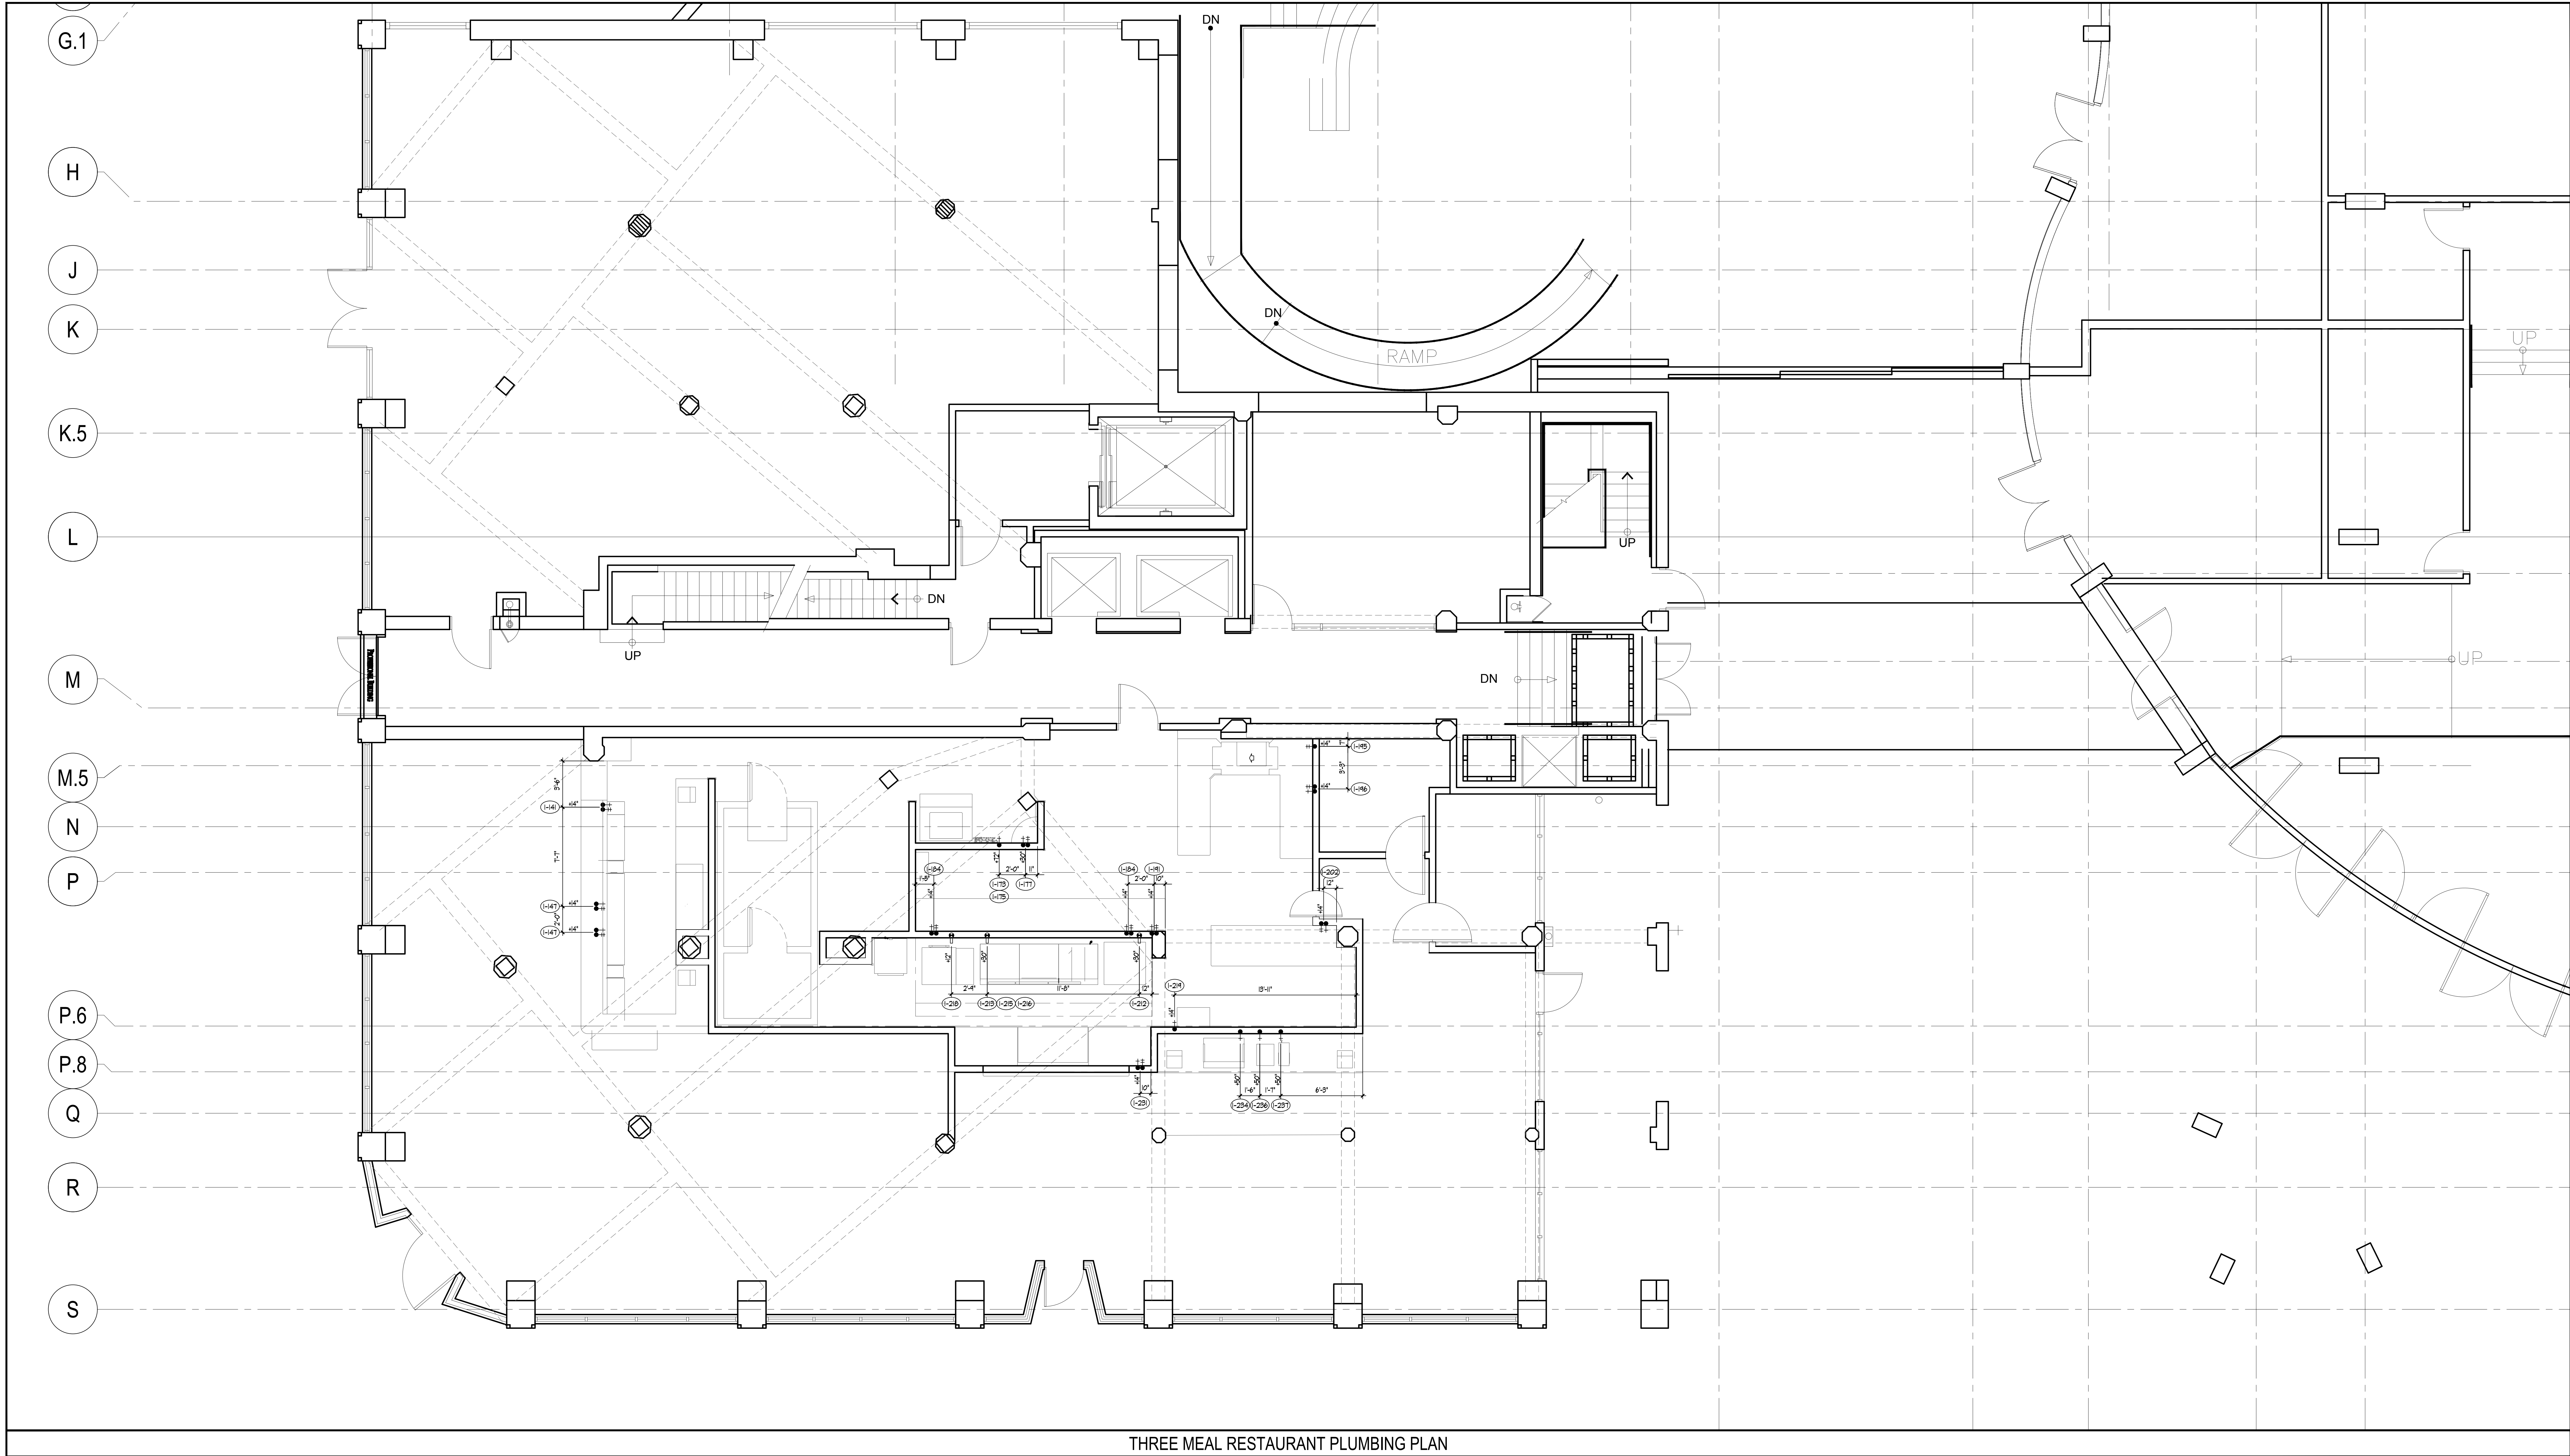

howard laks architects
1545 hewlett street
santa monica, ca 90401
voice : 310-393-4465
fax : 310-393-2220

CONSULTANTS

Kitchen Professionals
16742 Colwood Street, Suite 103
Huntington Beach, CA 92647
Phone: 714.841.0531 Fax: 714.841.9986

710 WILSHIRE BOULEVARD
MIXED-USE HOTEL PROJECT
SANTA MONICA - CALIFORNIA 90401
THREE MEAL RESTAURANT PLUMBING PLAN

DRAWN	JL
CHECKED	CH
APPROVED	-
SCALE	1/4" = 1'-0"
SHEET	

K-1.36

DATE: June 25, 2013
PROJECT NUMBER: HLA 0000000-00000