




THREE MEAL RESTAURANT ELECTRICAL PLAN

REVISION	DATE	DESCRIPTION
1	06/07/2013	Medium 02
2	06/04/2013	Medium 03
3	10/20/2013	Medium 04
4	06/27/2013	Medium 05

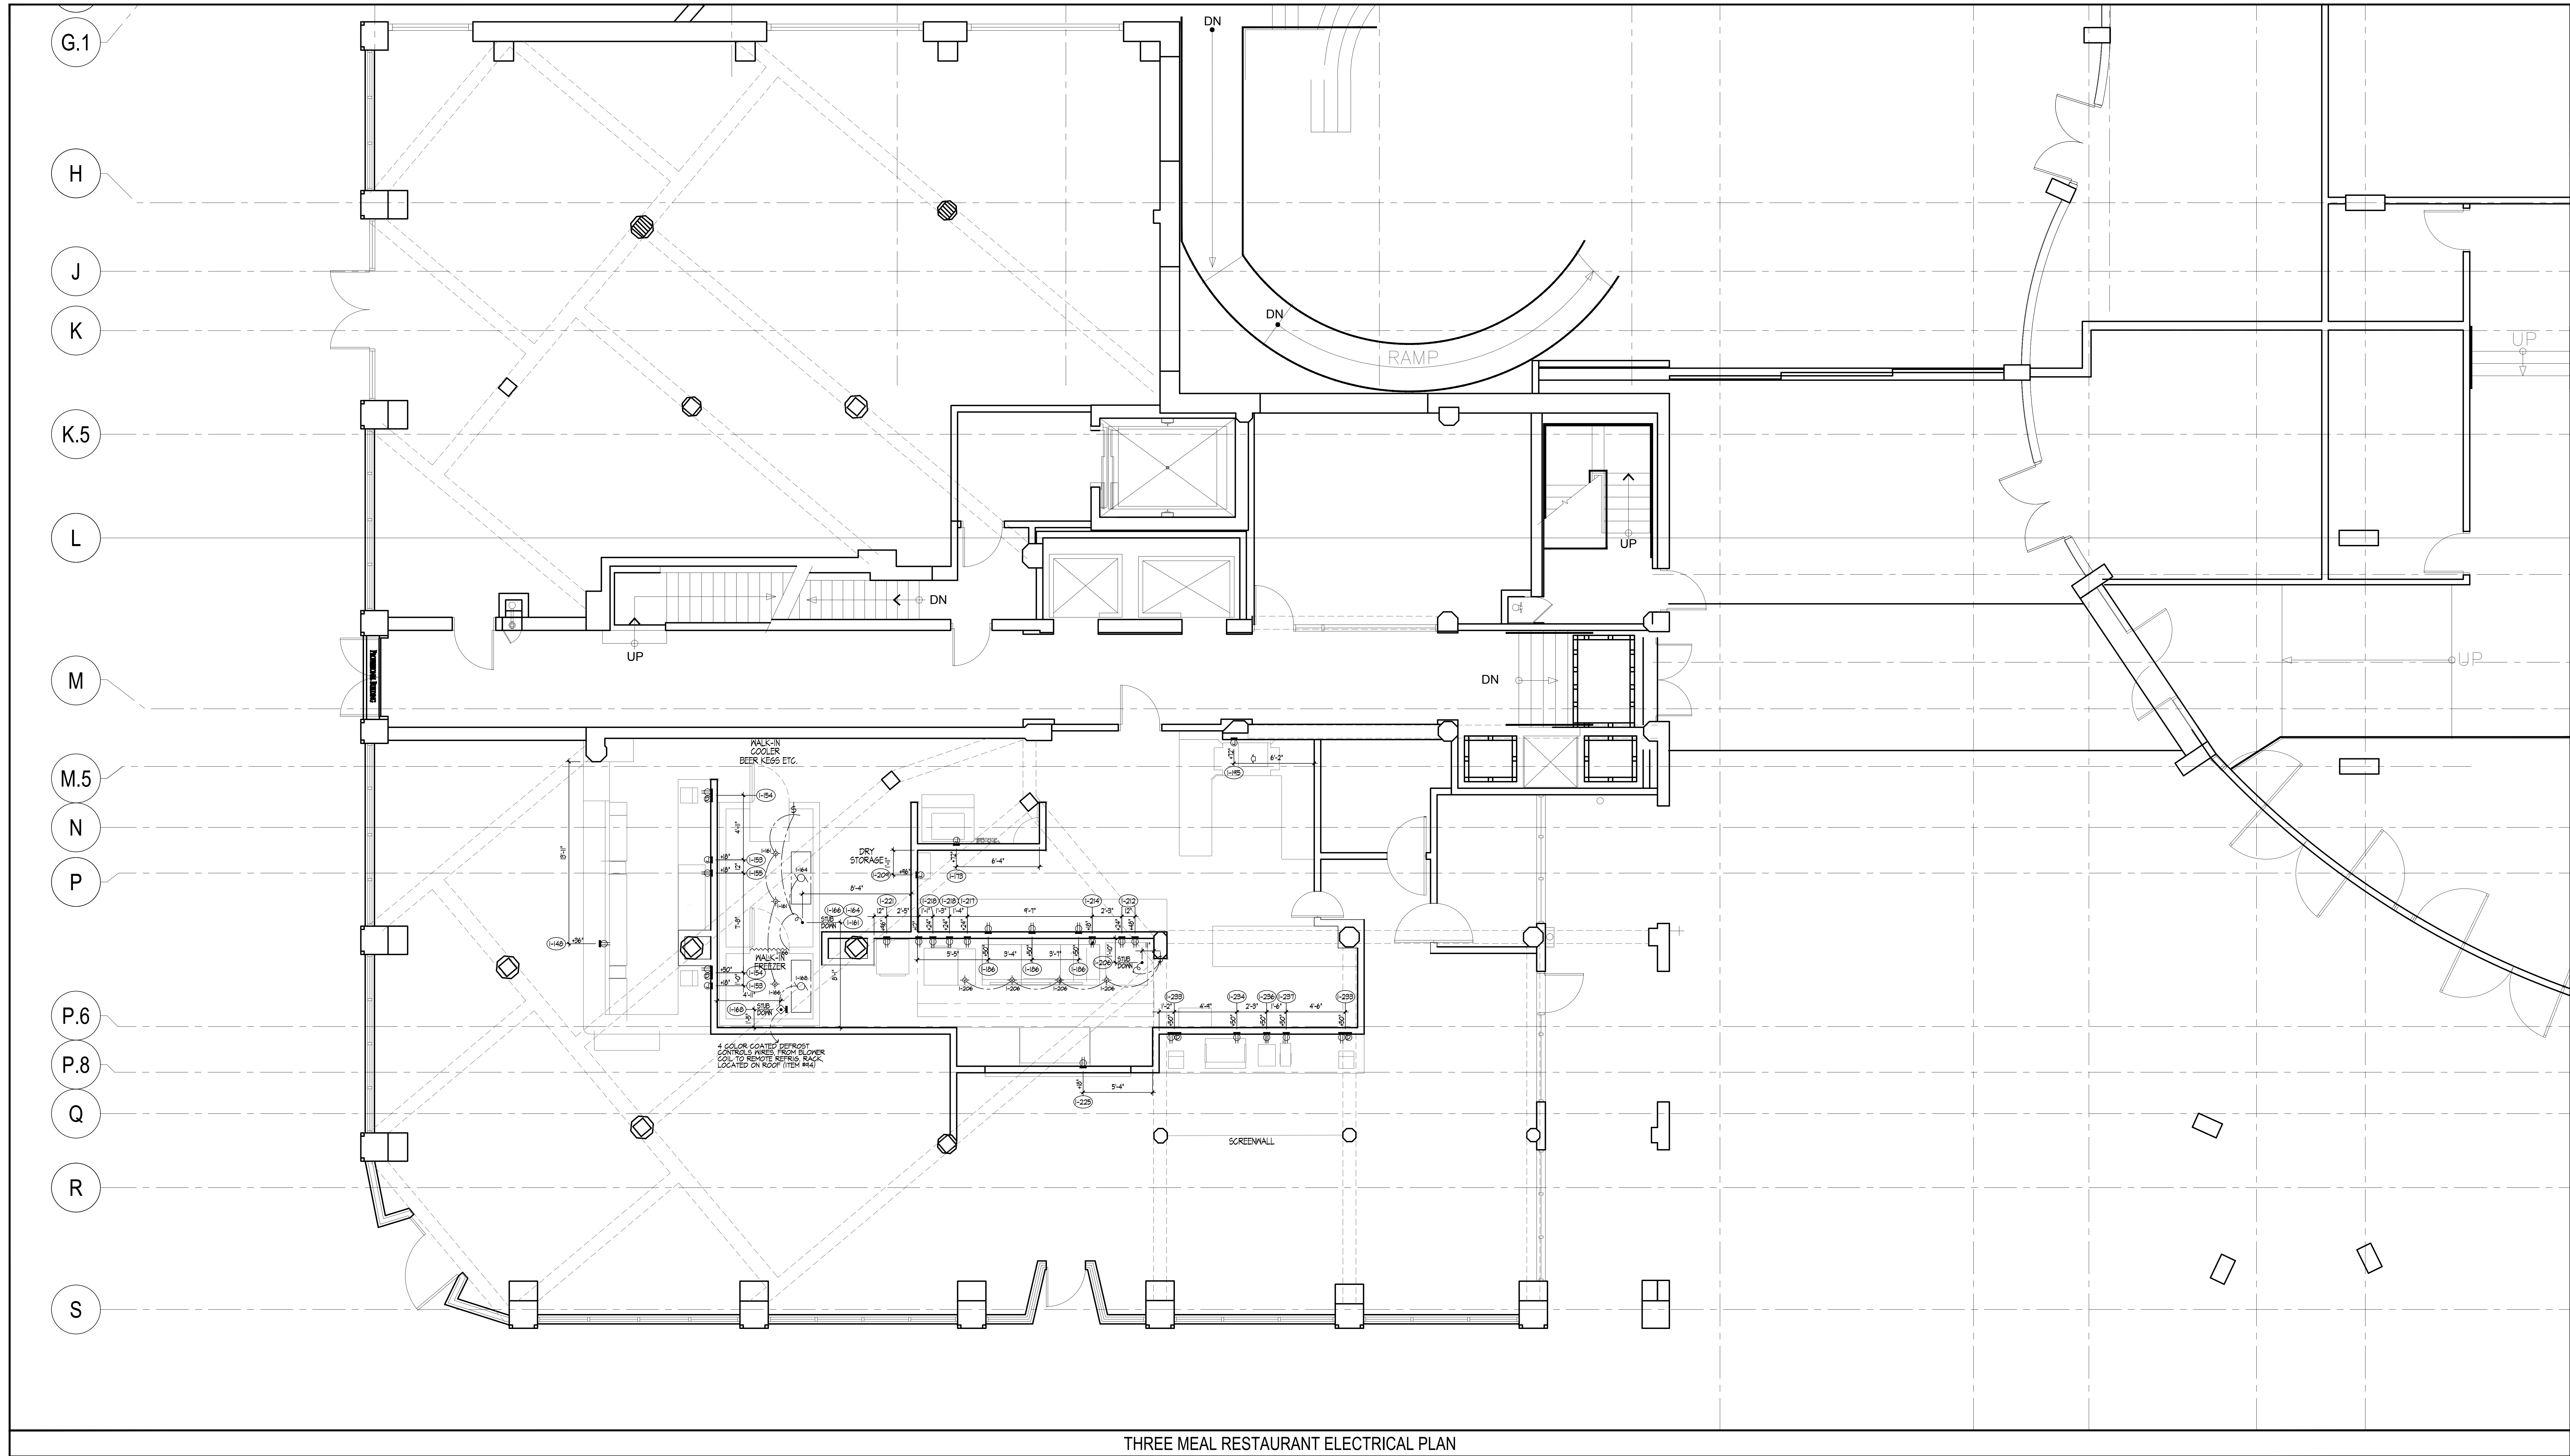

howard laks architects
1545 hewlett street
santa monica, ca 90401
voice : 310-393-4465
fax : 310-393-2220

CONSULTANTS

Kitchen Professionals
16742 Colwood Street, Suite 103
Huntington Beach, Ca 92647
Phone: 714.841.0531 Fax: 714.841.9986

710 WILSHIRE BOULEVARD
MIXED-USE HOTEL PROJECT
SANTA MONICA - CALIFORNIA 90401
THREE MEAL RESTAURANT ELECTRICAL PLAN

DRAWN	JL
CHECKED	CH
APPROVED	-
SCALE	1/4" = 1'-0"
SHEET	K-1.4.3
DATE	June 25, 2013
PROJECT NUMBER	H.A. 0000000-00000