


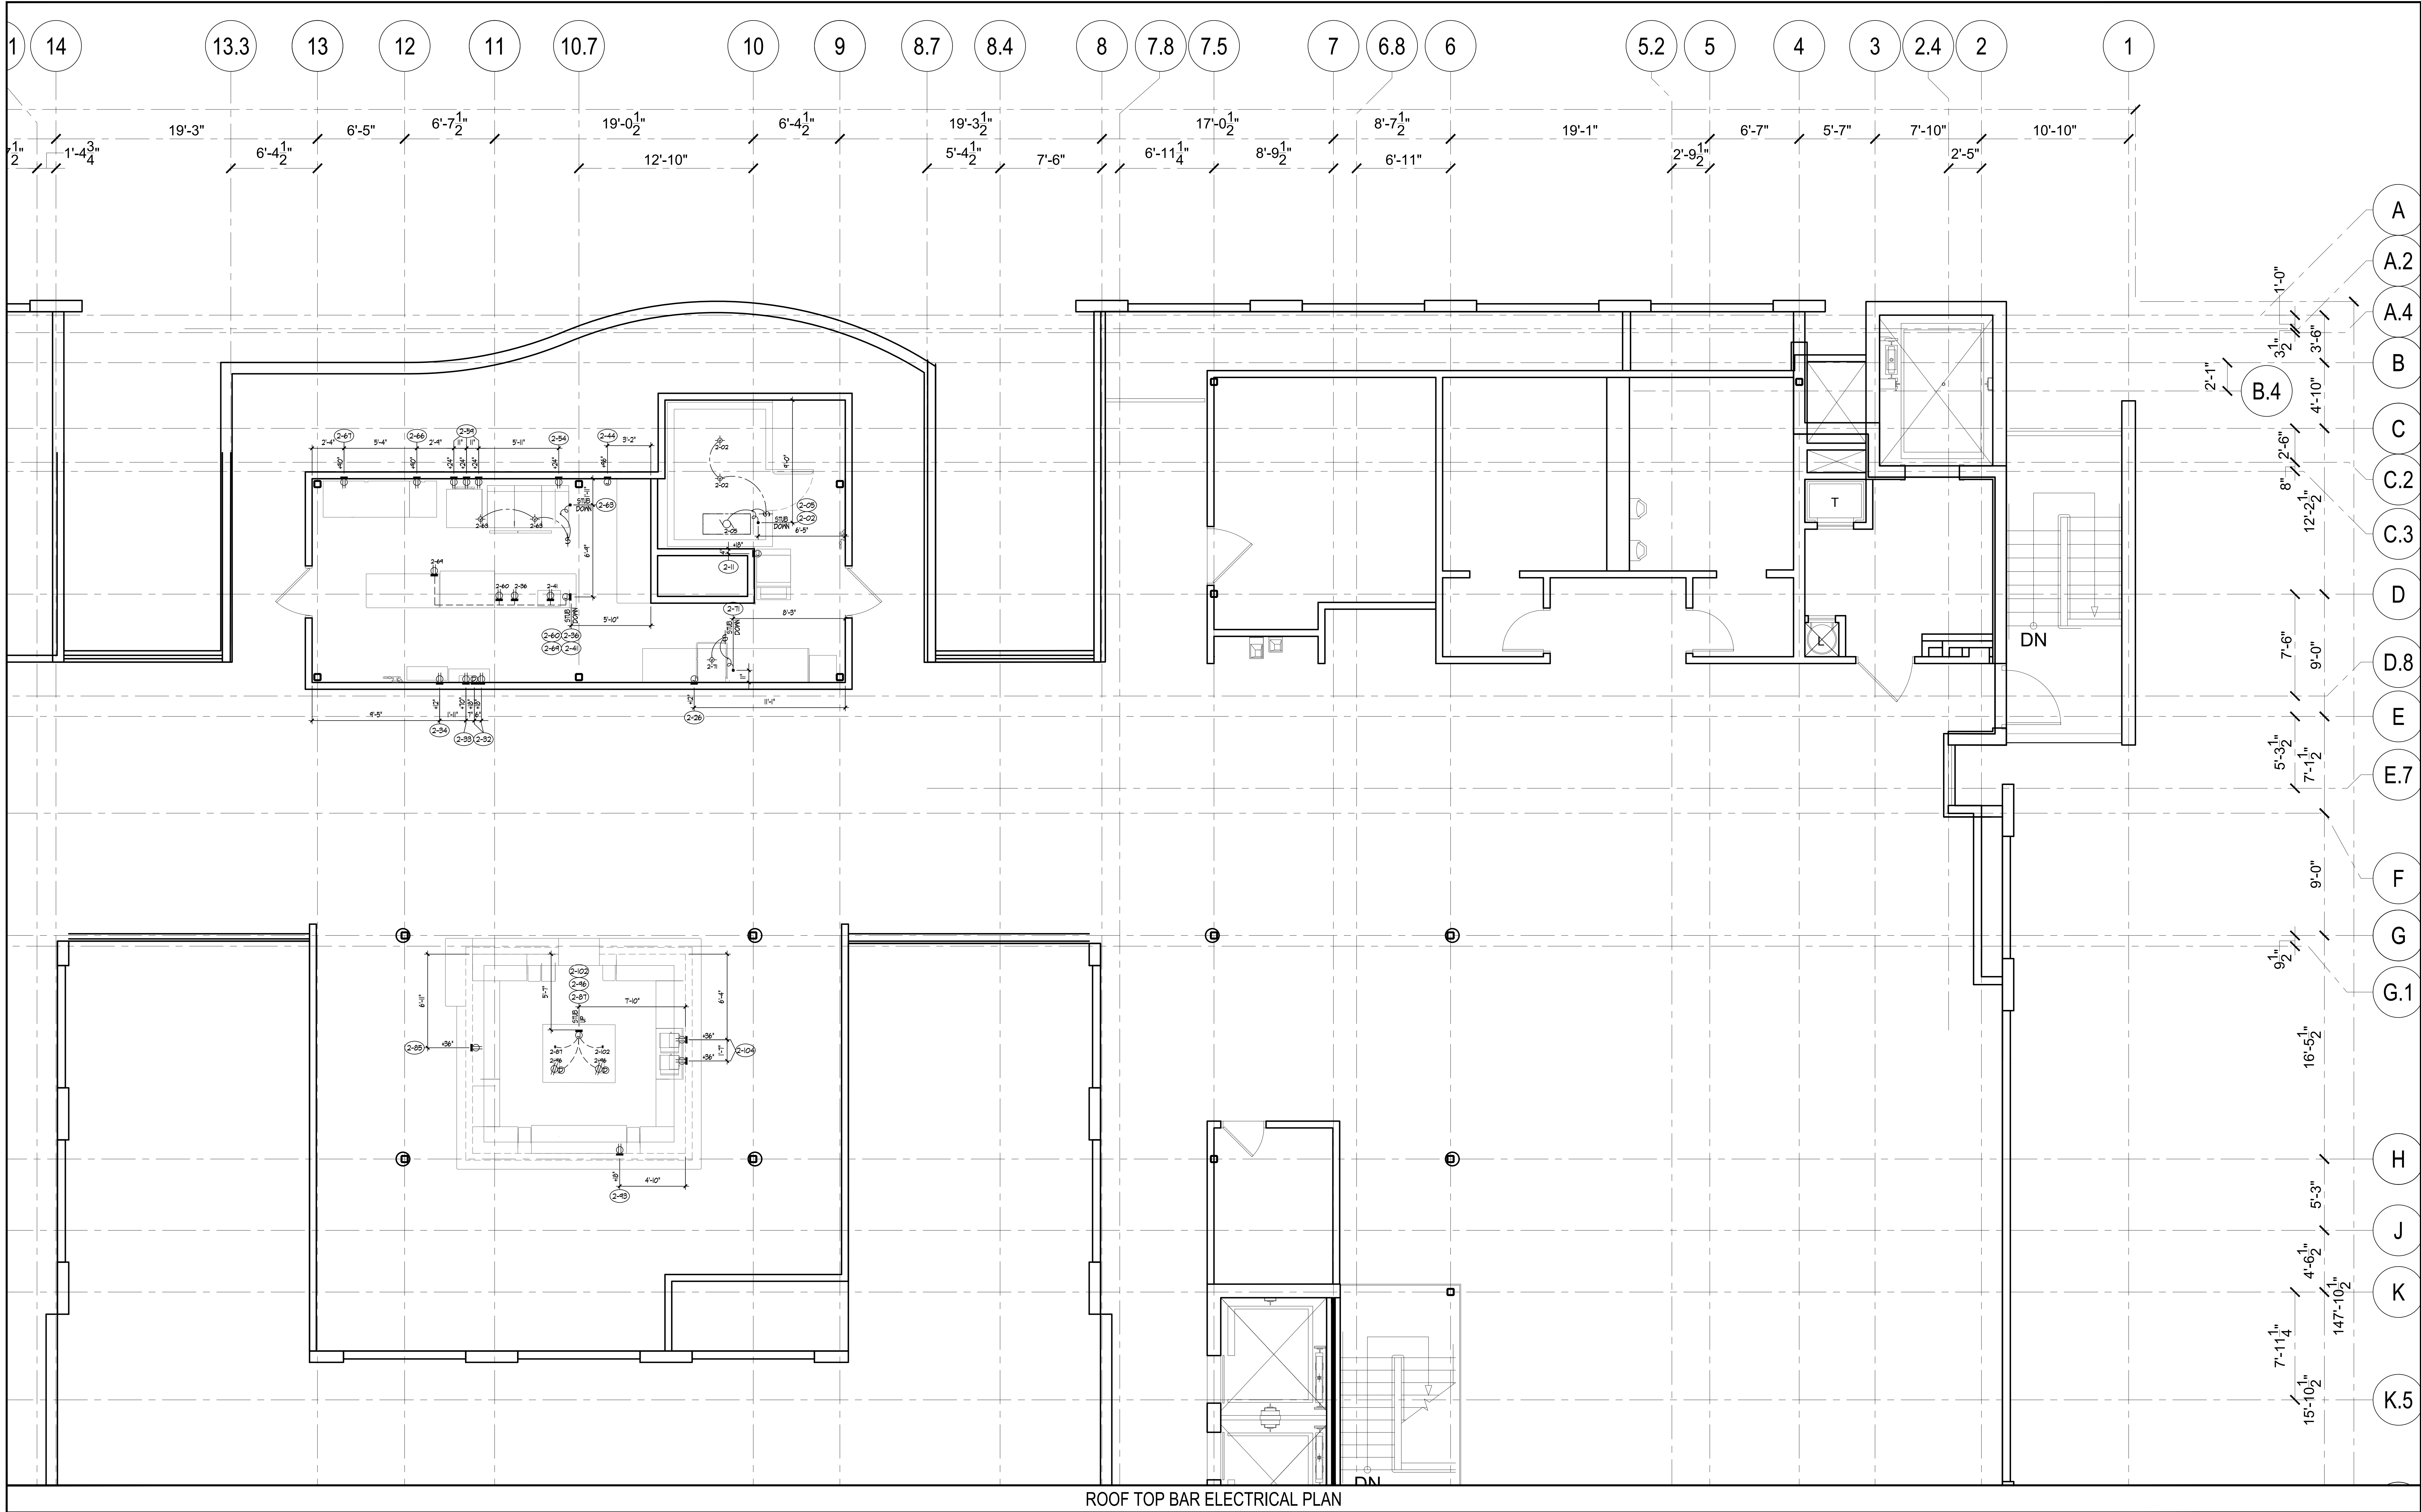

ELECTRICAL NOTES

1. ELECTRICAL CONTRACTOR TO VERIFY ALL INCOMING SERVICE AND FINAL HOOK-UP TO ALL APPLICABLE EQUIPMENT AND TO PROVIDE ALL SWITCHES, BREAKERS, CONDUIT, ETC., UNLESS SPECIFICALLY STATED OTHERWISE.

2. ELECTRICAL CONTRACTOR TO PROVIDE ALL JUNCTION BOXES, OUTLETS AND RECEPTILES IN FINISHED FLOOR FABRICATOR TO LOCATE ALL RECEPTILES AND SWITCHES WHEN PART OF FUTURE INTERNAL FINISHES TO BE PROVIDED AND INSTALLED BY ELECTRICAL CONTRACTOR.

3. ALL ELECTRICAL OUTLETS AND CONNECTIONS SHOWN ON THIS PLAN ARE FOR EQUIPMENT SHOWN ON FOOD SERVICE EQUIPMENT PLAN AND MUST BE AS SHOWN ON LOCAL PLANS FOR ADDITIONAL ELECTRICAL REQUIREMENTS.

4. ALL HORIZONTAL DIMENSIONS SHOWN ARE FROM FINISHED FACE OF WALL TO CENTER OF OUTLET UNLESS OTHERWISE NOTED ON PLANS OR DETAILS. ELECTRICAL CONTRACTOR TO VERIFY ALL DIMENSIONS AT JOB SITE.

5. ALL SYMBOLS NOTED "+2", "+24", ETC., TO STUB OUT OFF WALL AT HEIGHT INDICATED. HEIGHT IS GIVEN FROM FINISHED FLOOR UNLESS OTHERWISE NOTED. TO STUB UP TO OUTLET FINISHES SHOWN AT HEIGHT AND LOCATION INDICATED. MINIMUM HEIGHT TO BE 6" AFF.

6. ELECTRICAL CONTRACTOR TO PROVIDE 6'-0" PISTAL FLEX CONDUIT AT ALL DIRECT CONNECT STUB OUTS. EXTEND AND CONNECT TO FINISHES.

7. ELECTRICAL CONTRACTOR TO WIRE MAGNETIC CONTACTORS FOR POWER SHUT-OFF FOR ALL ELECTRIC COOKING EQUIPMENT THAT IS PROTECTED BY THE FIRE PROTECTION SYSTEM. CONNECT (BY CONTROL CIRCUIT FROM MICRO-SWITCH SYSTEM ON CYLINDER) POINT TO CONTRACTOR COIL.

8. ELECTRICAL CONTRACTOR TO PROVIDE A MINIMUM OF 3 WIRES ON ALL 208 OR 250 VOLT CIRCUITS.

9. ELECTRICAL CONTRACTOR TO PROVIDE AND INSTALL SERVICE ON ROOF FOR EXHAUST AND MAKE-UP AIR SYSTEMS. VERIFY LOCATION.

10. ELECTRICAL CONTRACTOR TO PROVIDE AND INSTALL UNDERBAR LIGHTING AND CONNECT BACKBAR DISPLAY LIGHTING.

11. ELECTRICAL CONTRACTOR TO PROVIDE AND INSTALL STAINLESS STEEL COVERS PLATES FOR ALL RECEPTILES UNLESS OTHERWISE NOTED. ALL RECEPTILES TO BE SET HORIZONTALLY.

12. ELECTRICAL CONTRACTOR TO PROVIDE AND INSTALL ALL GENERAL LIGHTING FIXTURES COMPLETE WITH LAMPS. DECORATIVE LIGHT FIXTURES THAT ARE SUPPLIED BY THE FOOD SERVICE EQUIPMENT CONTRACTOR ARE TO BE INSTALLED BY THE ELECTRICAL CONTRACTOR WITH LAMPS BY OWNER, UNLESS OTHERWISE NOTED.

13. ELECTRICAL CONTRACTOR TO PROVIDE AND INSTALL EXIT LIGHTS UNLESS OTHERWISE NOTED.

14. ELECTRICAL CONTRACTOR TO PROVIDE CABS AND CORDS FOR ALL ITEMS WHICH USE CONVENIENCE OUTLETS WHEN NOT IN USE. VERIFY LOCATION AND SHORTEST ANY CORDS NECESSARY OR REQUESTED.

15. ELECTRICAL CONTRACTOR TO INSTALL FLY FANS AND/OR AIR GRILLS PROVIDED BY THE FOOD SERVICE EQUIPMENT CONTRACTOR (UNLESS OTHERWISE NOTED).

16. LIGHT AND POWER PANELS TO BE SELECTED WITH 20 PER. CONT. FRAME CIRCUIT CAPACITY TO PERMIT EXPANSION.

17. ELECTRICAL CONTRACTOR TO PROVIDE AND INSTALL CONDUIT 1/2" MIN. OF REINFORCEMENT AND EXPOSED LINES AS SHOWN ON PLAN WITH A MINIMUM BENDING RADIUS OF 24" (NO FACTORY "L" BENDS PERMITTED) (VERIFY LOCATION AND FINISHES BY THESE PLANS).

18. ELECTRICAL CONTRACTOR TO VERIFY ALL REQUIREMENTS FOR HOT WATER TANK WITH HEALTH DEPARTMENT REQUIREMENTS.

19. ELECTRICAL CONTRACTOR TO PROVIDE AND INSTALL MECHANICAL VENTILATION WITH LIGHT AND SWITCH IN RESTROOMS AND CHANGE ROOMS. (MINIMUM AIR CHANGE = 12 PER HOUR.)

20. FIXTURE FABRICATOR SHALL CUT ACCESS HOLES TO CONVENIENCE OUTLETS IN BASE, RECEPTILES, ETC., BUT ELECTRICAL CONTRACTOR TO PROVIDE EXTENSION SHIELDS IF REQUIRED.

21. ELECTRICAL CONTRACTOR TO CONNECT ALL COMPRESSORS COMPLETE WITH DISCONNECT SWITCHES AND MAGNETIC STARTERS (UNLESS THERE IS A PRE-WIRED COMPRESSOR RACK THAT INCLUDES DISCONNECT SWITCHES).

22. ELECTRICAL CONTRACTOR TO PROVIDE AND INSTALL ALL WIRING FOR WALK-IN COOLERS AND FREEZERS ON THE EXTERIOR OF THE BOX WHENEVER POSSIBLE.

23. ELECTRICAL CONTRACTOR TO VERIFY ALL DIMENSIONS AT THE JOB SITE.

24. ELECTRICAL CONTRACTOR TO VERIFY ANY ADDITIONAL ELECTRICAL SERVICES REQUIRED IN THE BUILDING FOR ITEMS NOT SHOWN ON THE PLANS, AND FOR N.E.C. ITEMS.

25. ELECTRICAL CONTRACTOR TO USE EXISTING ELECTRICAL SERVICES AND TO CAP OFF ANY EXISTING SERVICES MADE OBSOLETE BY THESE PLANS.

26. ELECTRICIAN TO VERIFY TYPE OF CONDUIT THAT MEETS LOCAL BUILDING CODES.

27. ELECTRICIAN TO VERIFY ALL WIRING OF WALK-IN COOLERS/FREEZERS WITH REFRIGERATION CONTRACTOR PRIOR TO INSTALL.

28. ELECTRICIAN TO REFER TO REFRIGERATION PLAN FOR ALL CONDUIT LOCATIONS.

29. ELECTRICAL CONTRACTOR TO CONNECT ALL EXHAUST AND MAKE-UP AIR FANS AND SUPPLY MAGNETIC STARTERS.

30. ELECTRICAL CONTRACTOR TO PROVIDE AND INSTALL AID BOX AT 4'-0" AFF. SOUTH (1/2" APPROVED CONDUIT AS SHOWN ON PLANS).

31. ELECTRICAL CONTRACTOR TO INTERCONNECT EXHAUST AND MAKE-UP AIR FANS TO SWITCH AT HOOD.

32. ELECTRICIAN TO PROVIDE SERVICE FOR SOUND SYSTEMS, P.O.S. SYSTEMS AND TELEPHONES.

33. ELECTRICIAN TO HOOK-UP HEATER STRIPS AT COLD STORAGE ROOM DOORS AND DRAIN LINES AS REQ'D.

ELECTRICAL NOTES

100 VOLT DOUBLE CONV. OUTLET

FOURPLEX CONV. OUTLET

FIXTURE MOUNTED DOUBLE CONV. OUTLET

208 VOLT SINGLE CONV. OUTLET

JUNCTION BOX

6 COLOR COATED DEFROST CONTROL WIRE FROM BLOWER COIL TO CONDENSING UNIT, TIME CLOCK BY ELECTRICIAN

MOTOR

SWITCH

VAPOR PROOF LIGHT FIXTURE

DATA PORT

UNDERBAR LIGHTS

FLEX CONNECTION

FIRE PULL

NOTE: LOCATION OF ALL RECEPTILES AND SWITCHES SHOWN IN OR ON CONTOURS TO BE FIELD VERIFIED AND INSTALLED BY ELECTRICAL CONTRACTOR.

REVISION
BY
DATE
DESCRIPTION
1
06/07/2015
Mehmet 02
2
06/04/2015
Mehmet 03
3
06/04/2015
Mehmet 04
4
06/27/2016
Mehmet 05

hla

howard laks architects

1545 wealth street
santa monica, ca 90401
voice : 310-393-4465
fax : 310-393-2220

CONSULTANTS

Kitchen Professionals

18742 Colwood Street, Suite 103
Huntington Beach, Ca 92647
Phone: 714.841.0531 Fax: 714.541.9986

710 WILSHIRE BOULEVARD

MIXED-USE HOTEL PROJECT
SANTA MONICA - CALIFORNIA 90401

ROOF TOP BAR ELECTRICAL PLAN

DRAWN
CHECKED
APPROVED
SCALE
SHEET

JL
CH
-
1/4" = 1'-0"
K-2.4.1

DATE
PROJECT NUMBER
JLH 000000-00000

June 25, 2013