



1. EQUIPMENT ROOM FLOOR MUST SLOPE MIN. 1/4" TO 12" TO FLOOR DRAINS.
2. ALL FLOOR EQUIPMENT MUST BE INSTALLED ON HOUSEKEEPING PADS PROVIDED BY BUILDING CONTRACTOR UNLESS NOTED OTHERWISE.
3. PROVIDE HOSE BIBBS) FOR HOUSE CLEANING PURPOSES. (SEE PLUMBING PLAN).
4. NOT USED.
5. NOT USED.
6. PROVIDE PRESSURE GAUGES ON INFLUENT AND EFFLUENT SIDE OF EACH FILTER SYSTEM.
7. INTERLOCK ALL CHEMICAL BOOST PUMPS WITH MAIN CIRCULATION PUMP FOR EACH POOL.
8. PROVIDE A MINIMUM OF TWO (2) PERMANENT AIR SUPPLY OPENINGS COMMUNICATING DIRECTLY THROUGH THE WALL TO OUTSIDE AIR: ONE WITHIN 12" OF THE CEILING, AND THE OTHER WITHIN 12" INCHES OF THE FLOOR. EACH OPENING MUST HAVE A MINIMUM FREE AREA OF ONE SQUARE INCH PER 4,000 BTU/H OF THE TOTAL INTRUCTION OF ALL APPLIANCES IN THE EQUIPMENT ROOM OR PROVIDE DIRECT AIR HEATER UNIT AND FLUE CONNECTION THROUGH BUILDING.
9. PROVIDE CPVC TRUE UNION BALL SHUT-OFF VALVES AND PVC SCH. 80 PIPE ON HEATER INFLUENT AND EFFLUENT LINES FOR ISOLATION.

- A SWIMMING POOL PUMP ON 3'-0"x3'-0" CONCRETE PAD (FIELD VERIFY HEIGHT OF PAD WITH EQUIPMENT CLEARANCE REQUIREMENTS), PROVIDE 4" BUTTERFLY VALVE ON SKIMMER LINE AND MAINDRIN LINE, PLUS ADDITIONAL 4" BUTTERFLY VALVE ON COMBINED SUCTION LINE BEFORE FIBERGLASS 4" REDUCING STRAINER. 2.5" PUMP DISCHARGE LINE INCLUDES 2 1/2" 4" EPOXY COATED INCREASER 4" CHECK VALVE, AND 4" BUTTERFLY VALVE TO 4" SCH. 80 PVC LINE TO FILTER SYSTEM.

SCALE: N.T.S.

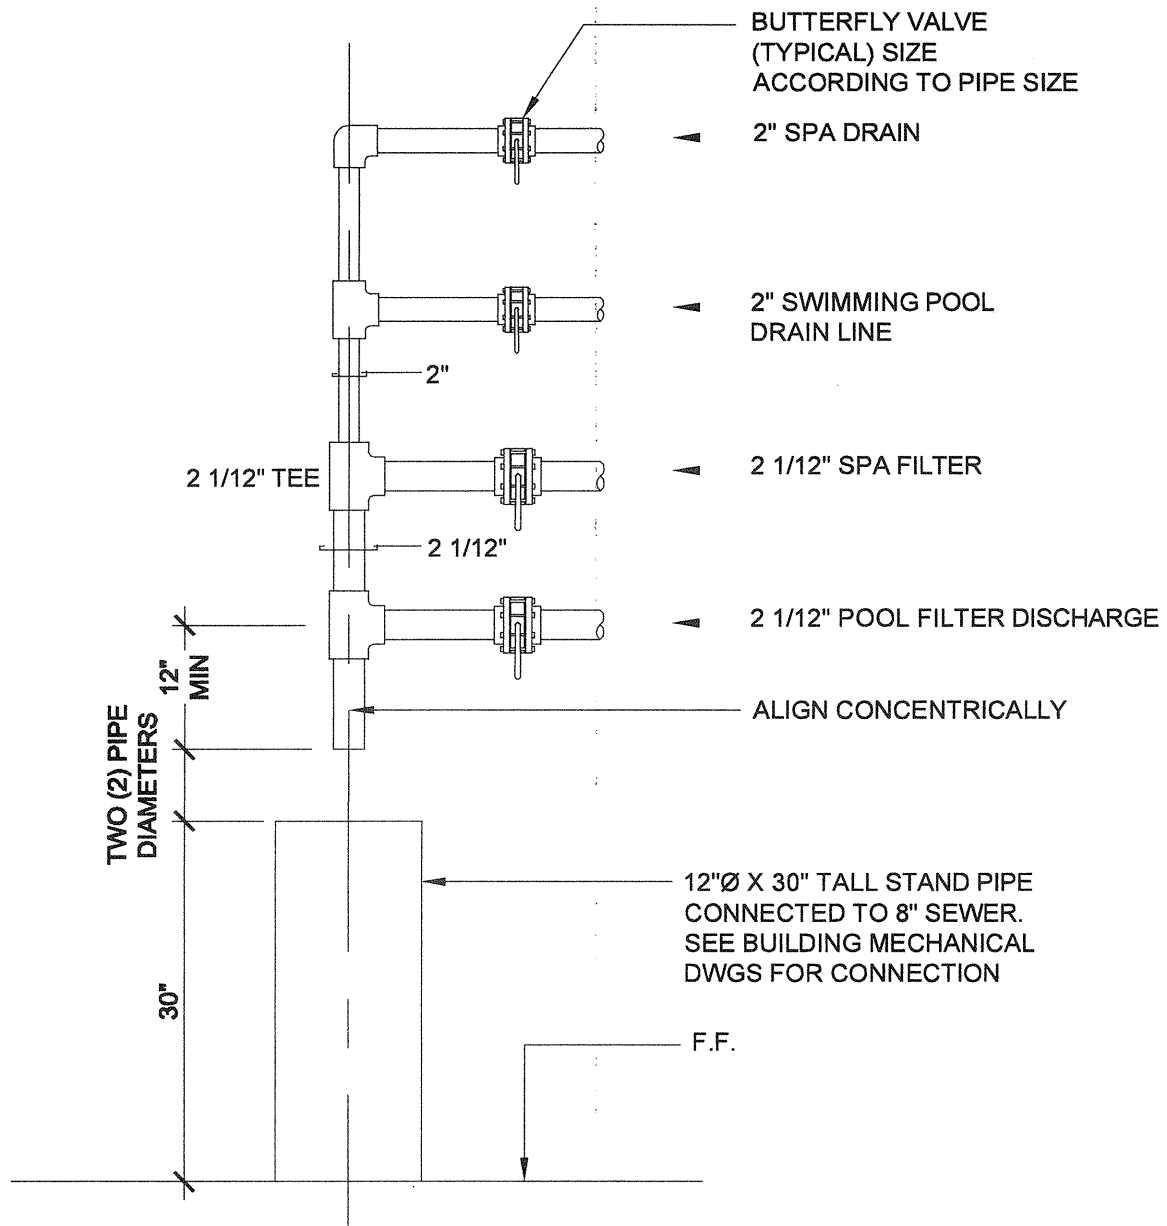


SCALE: 3/4" = 1'-0"

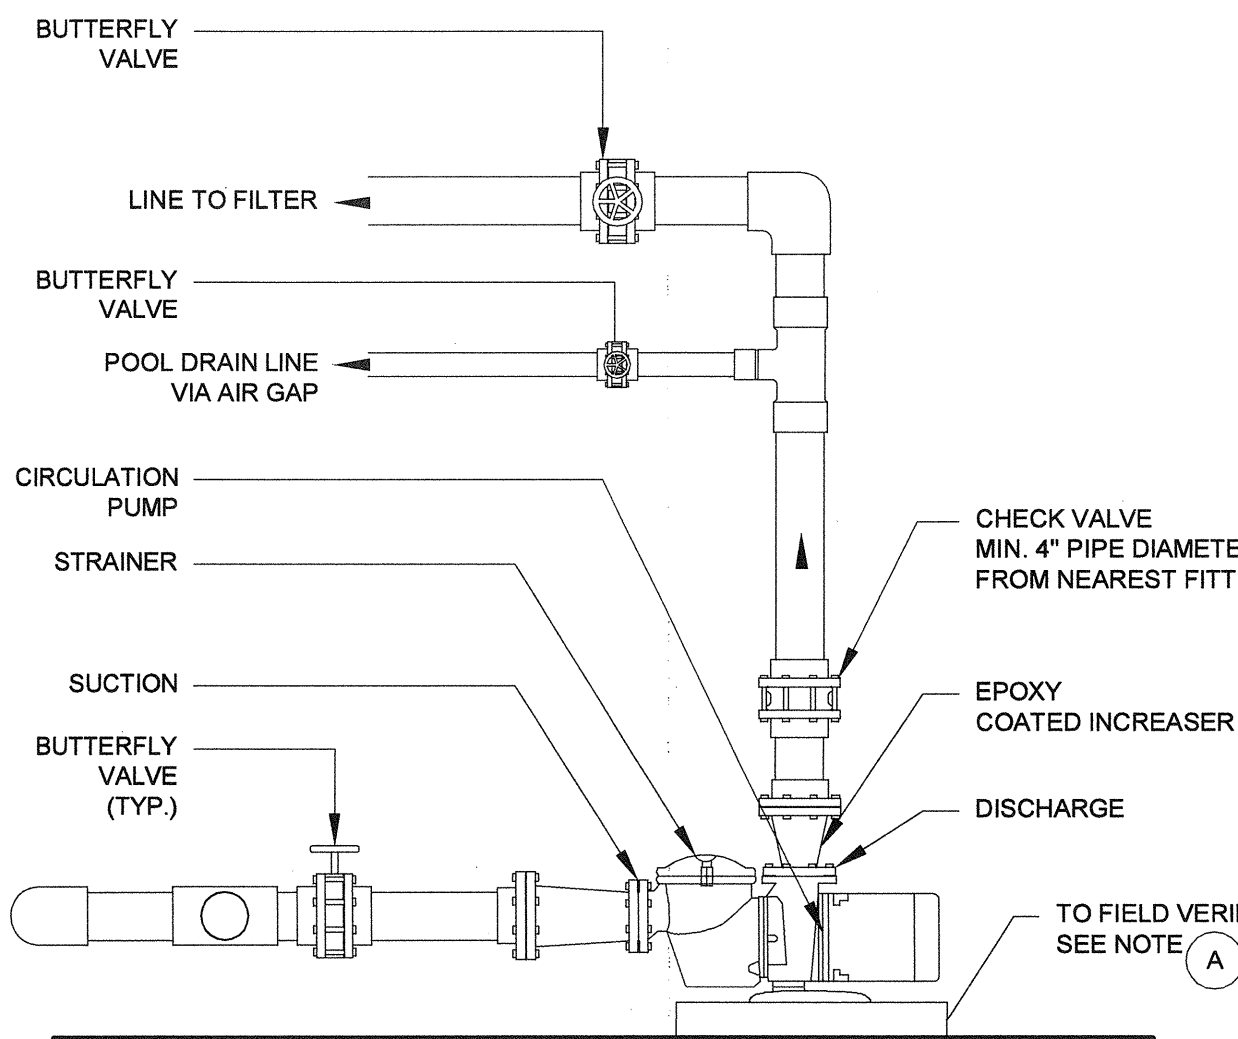


SCALE: NONE

SCALE: NONE


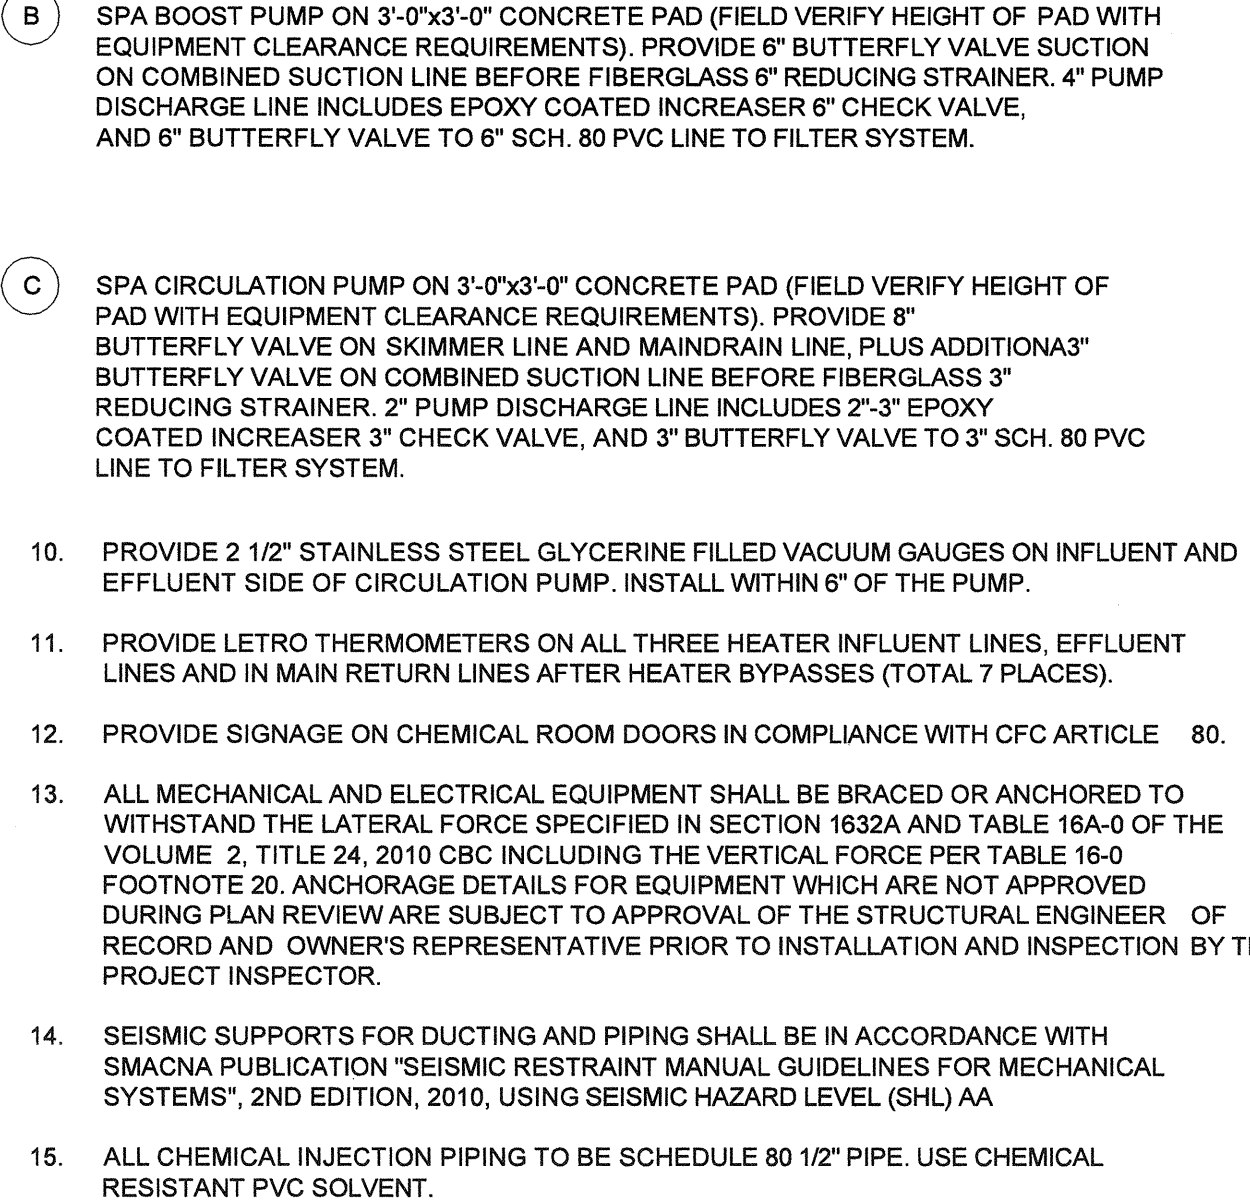


SCALE: NONE

SCALE: NONE

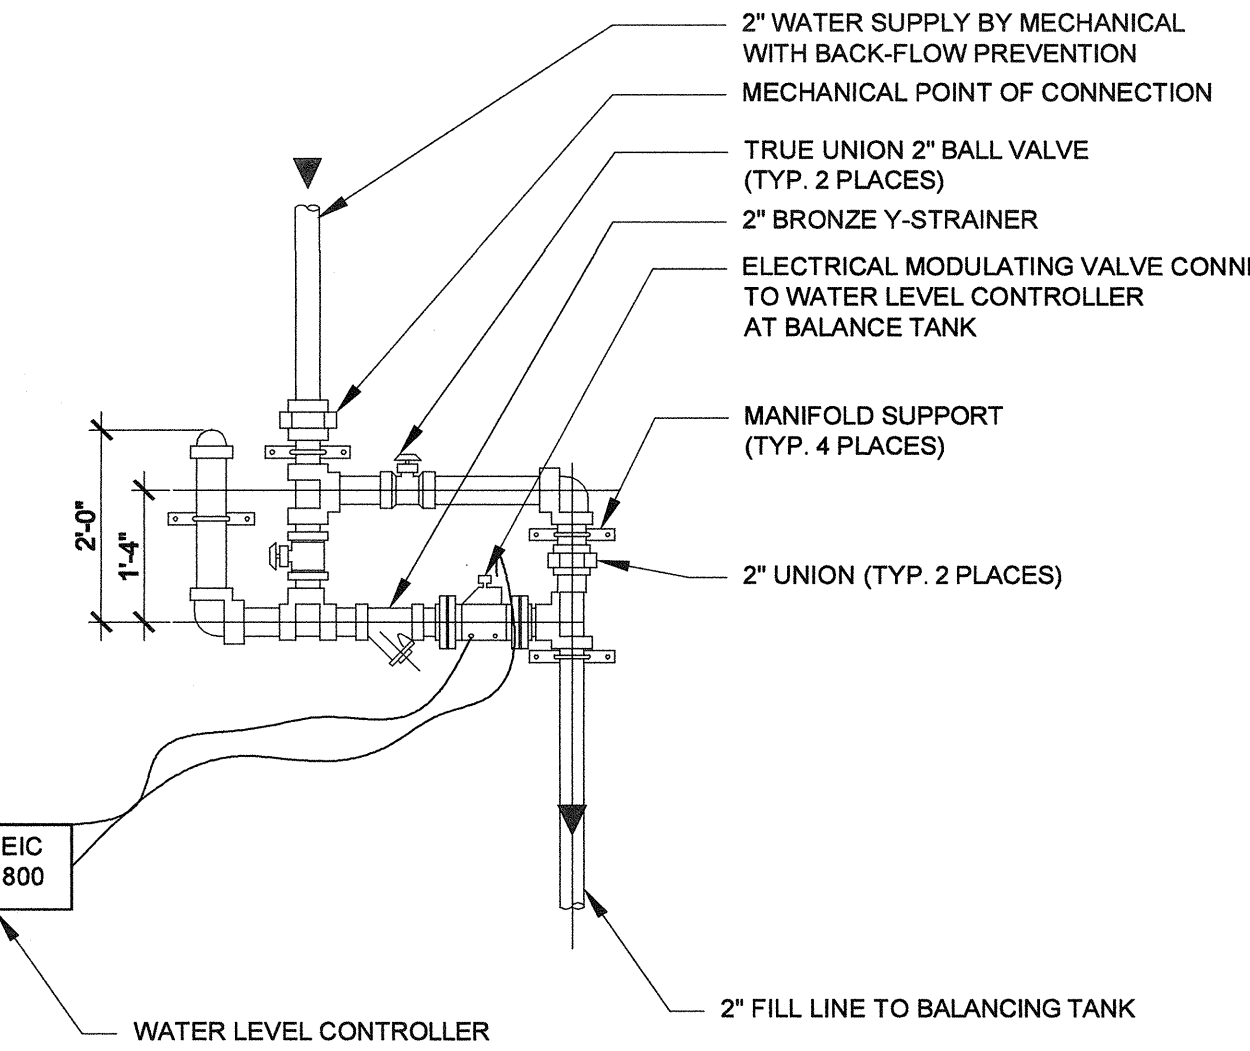


SCALE: 1/2" = 1'-0"

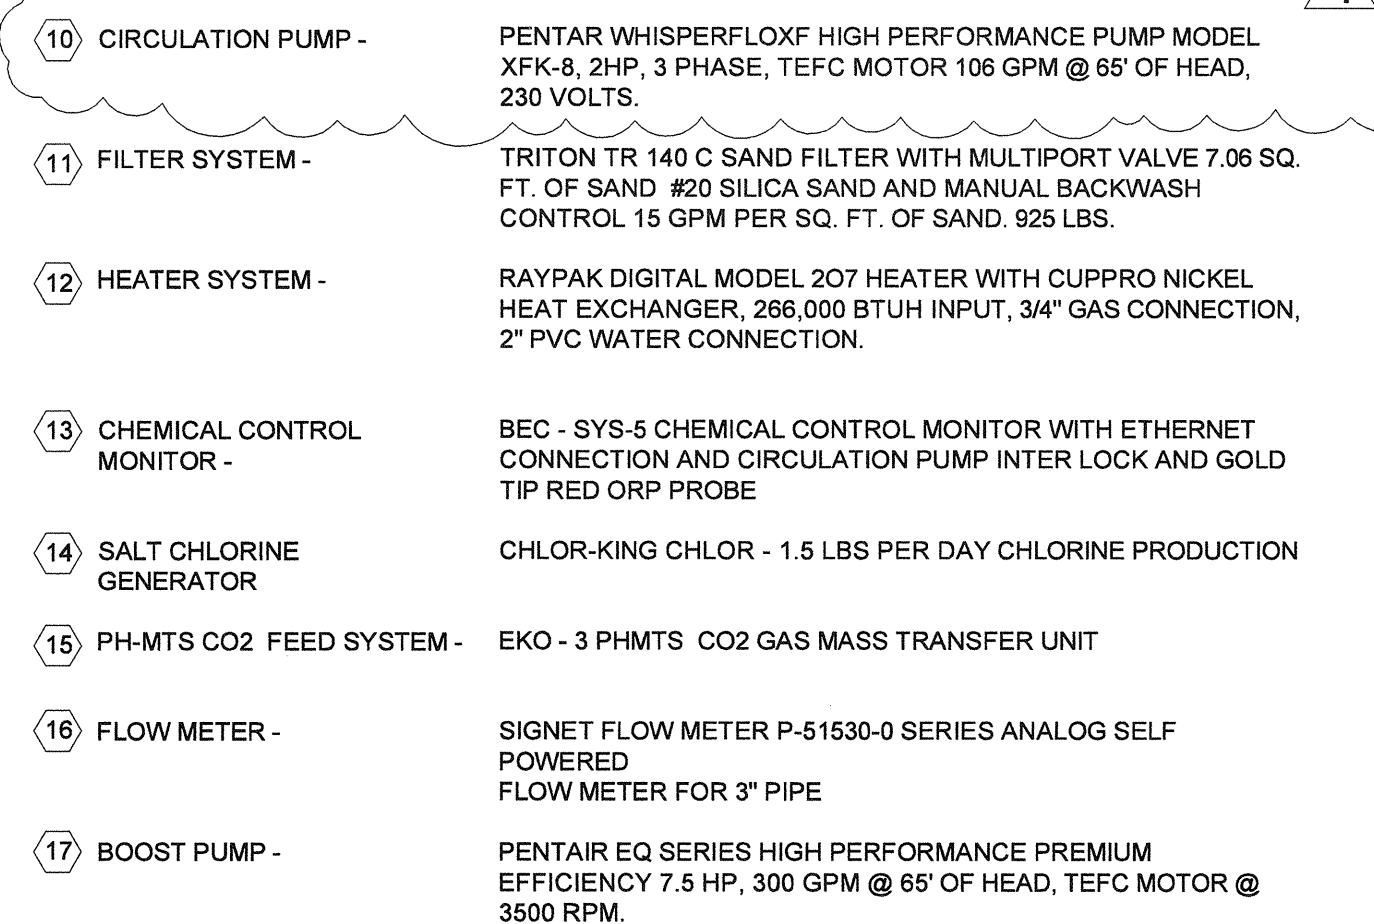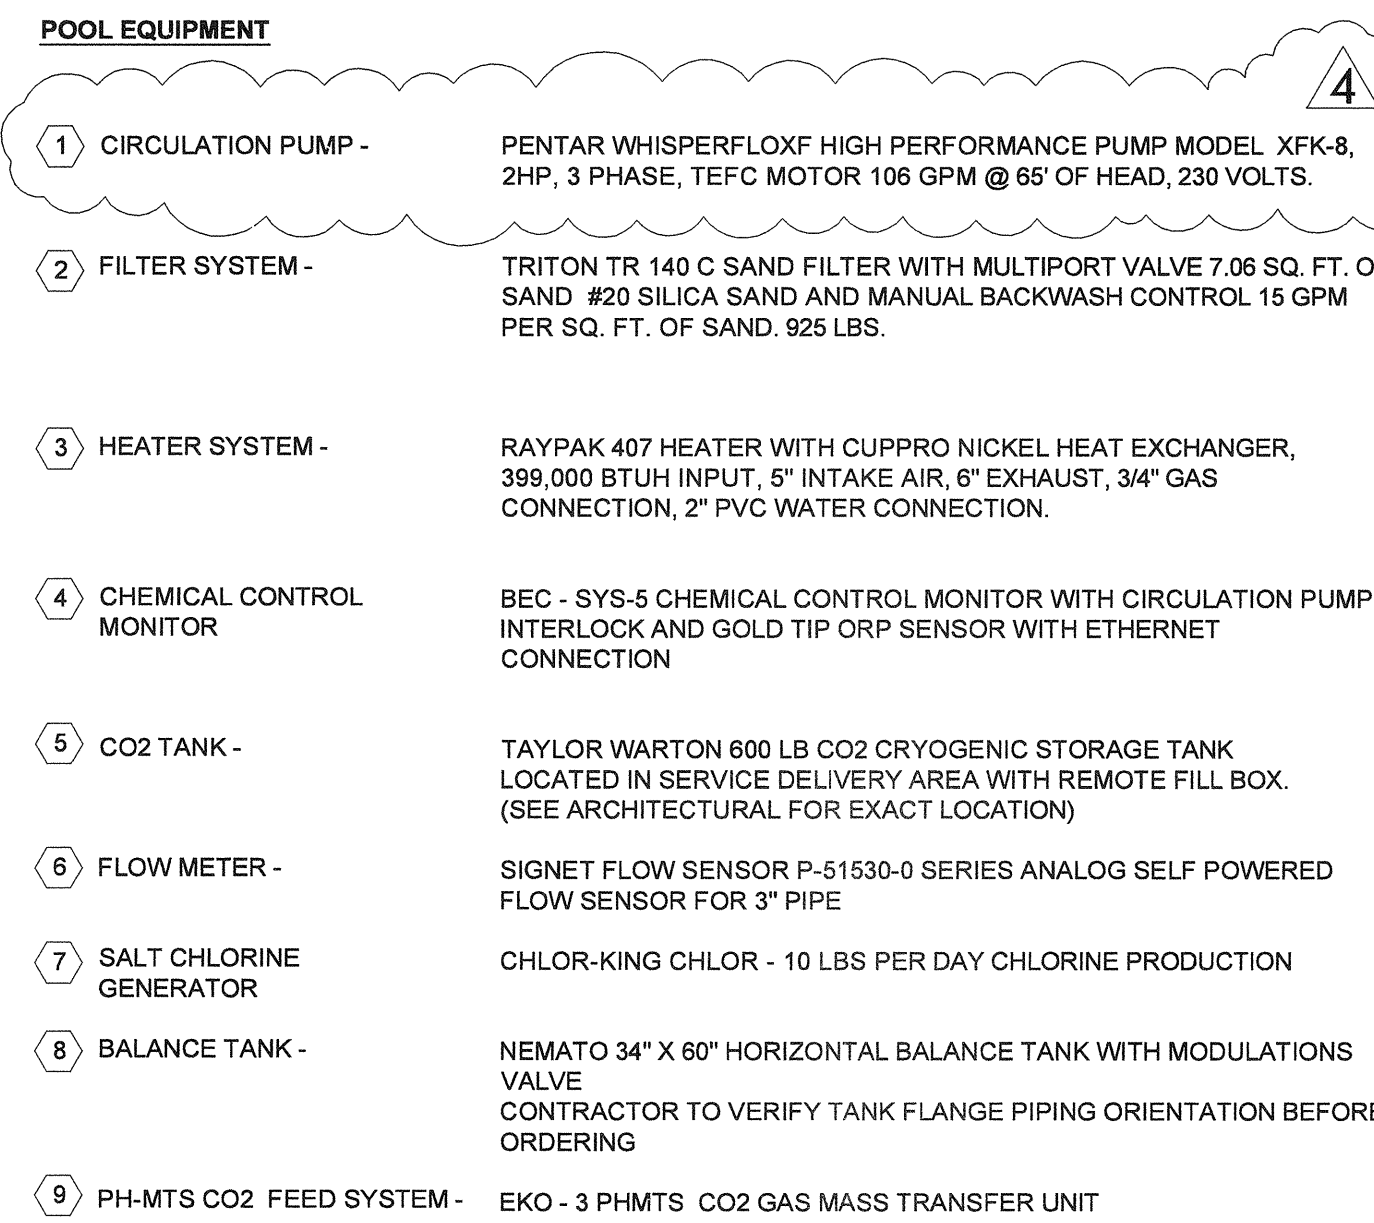


SCALE: N.T.S

SCALE: NONE

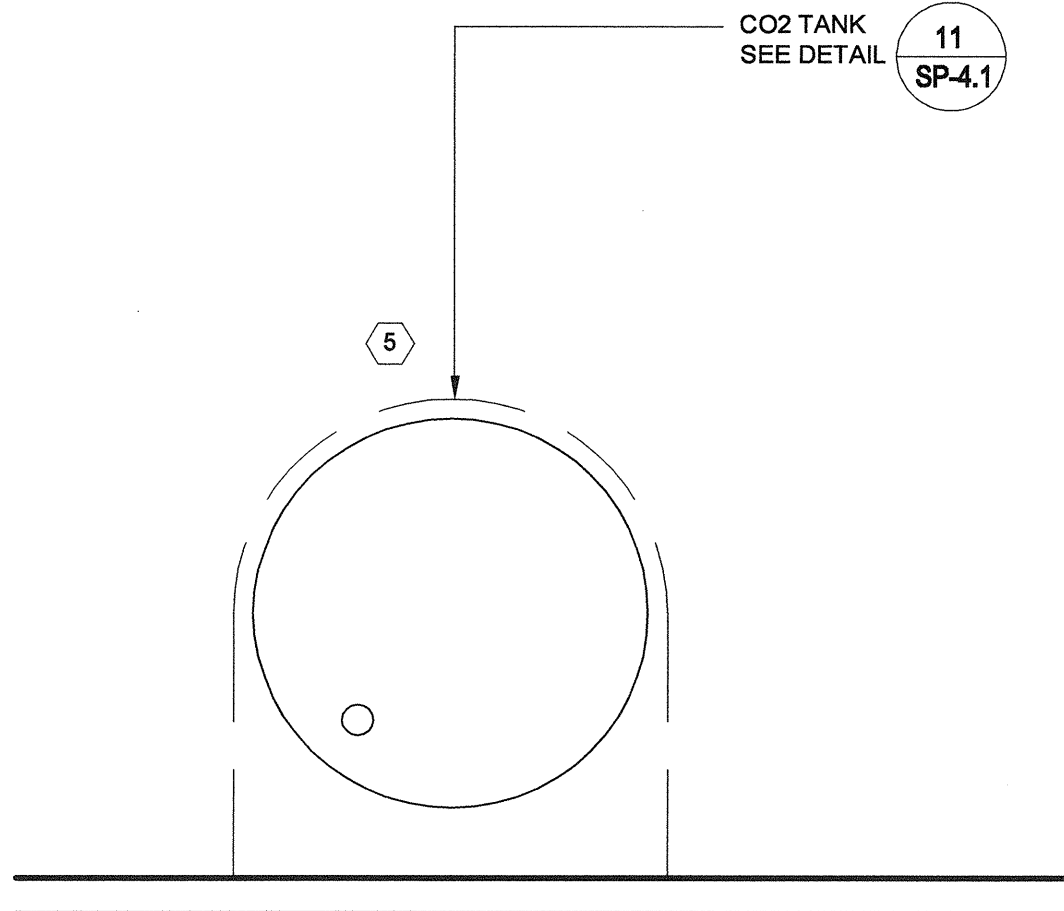

NOTES:
LOCATE IN LOADING DOCK AREA FOR DELIVERY ACCESS

SCALE: N.T.S

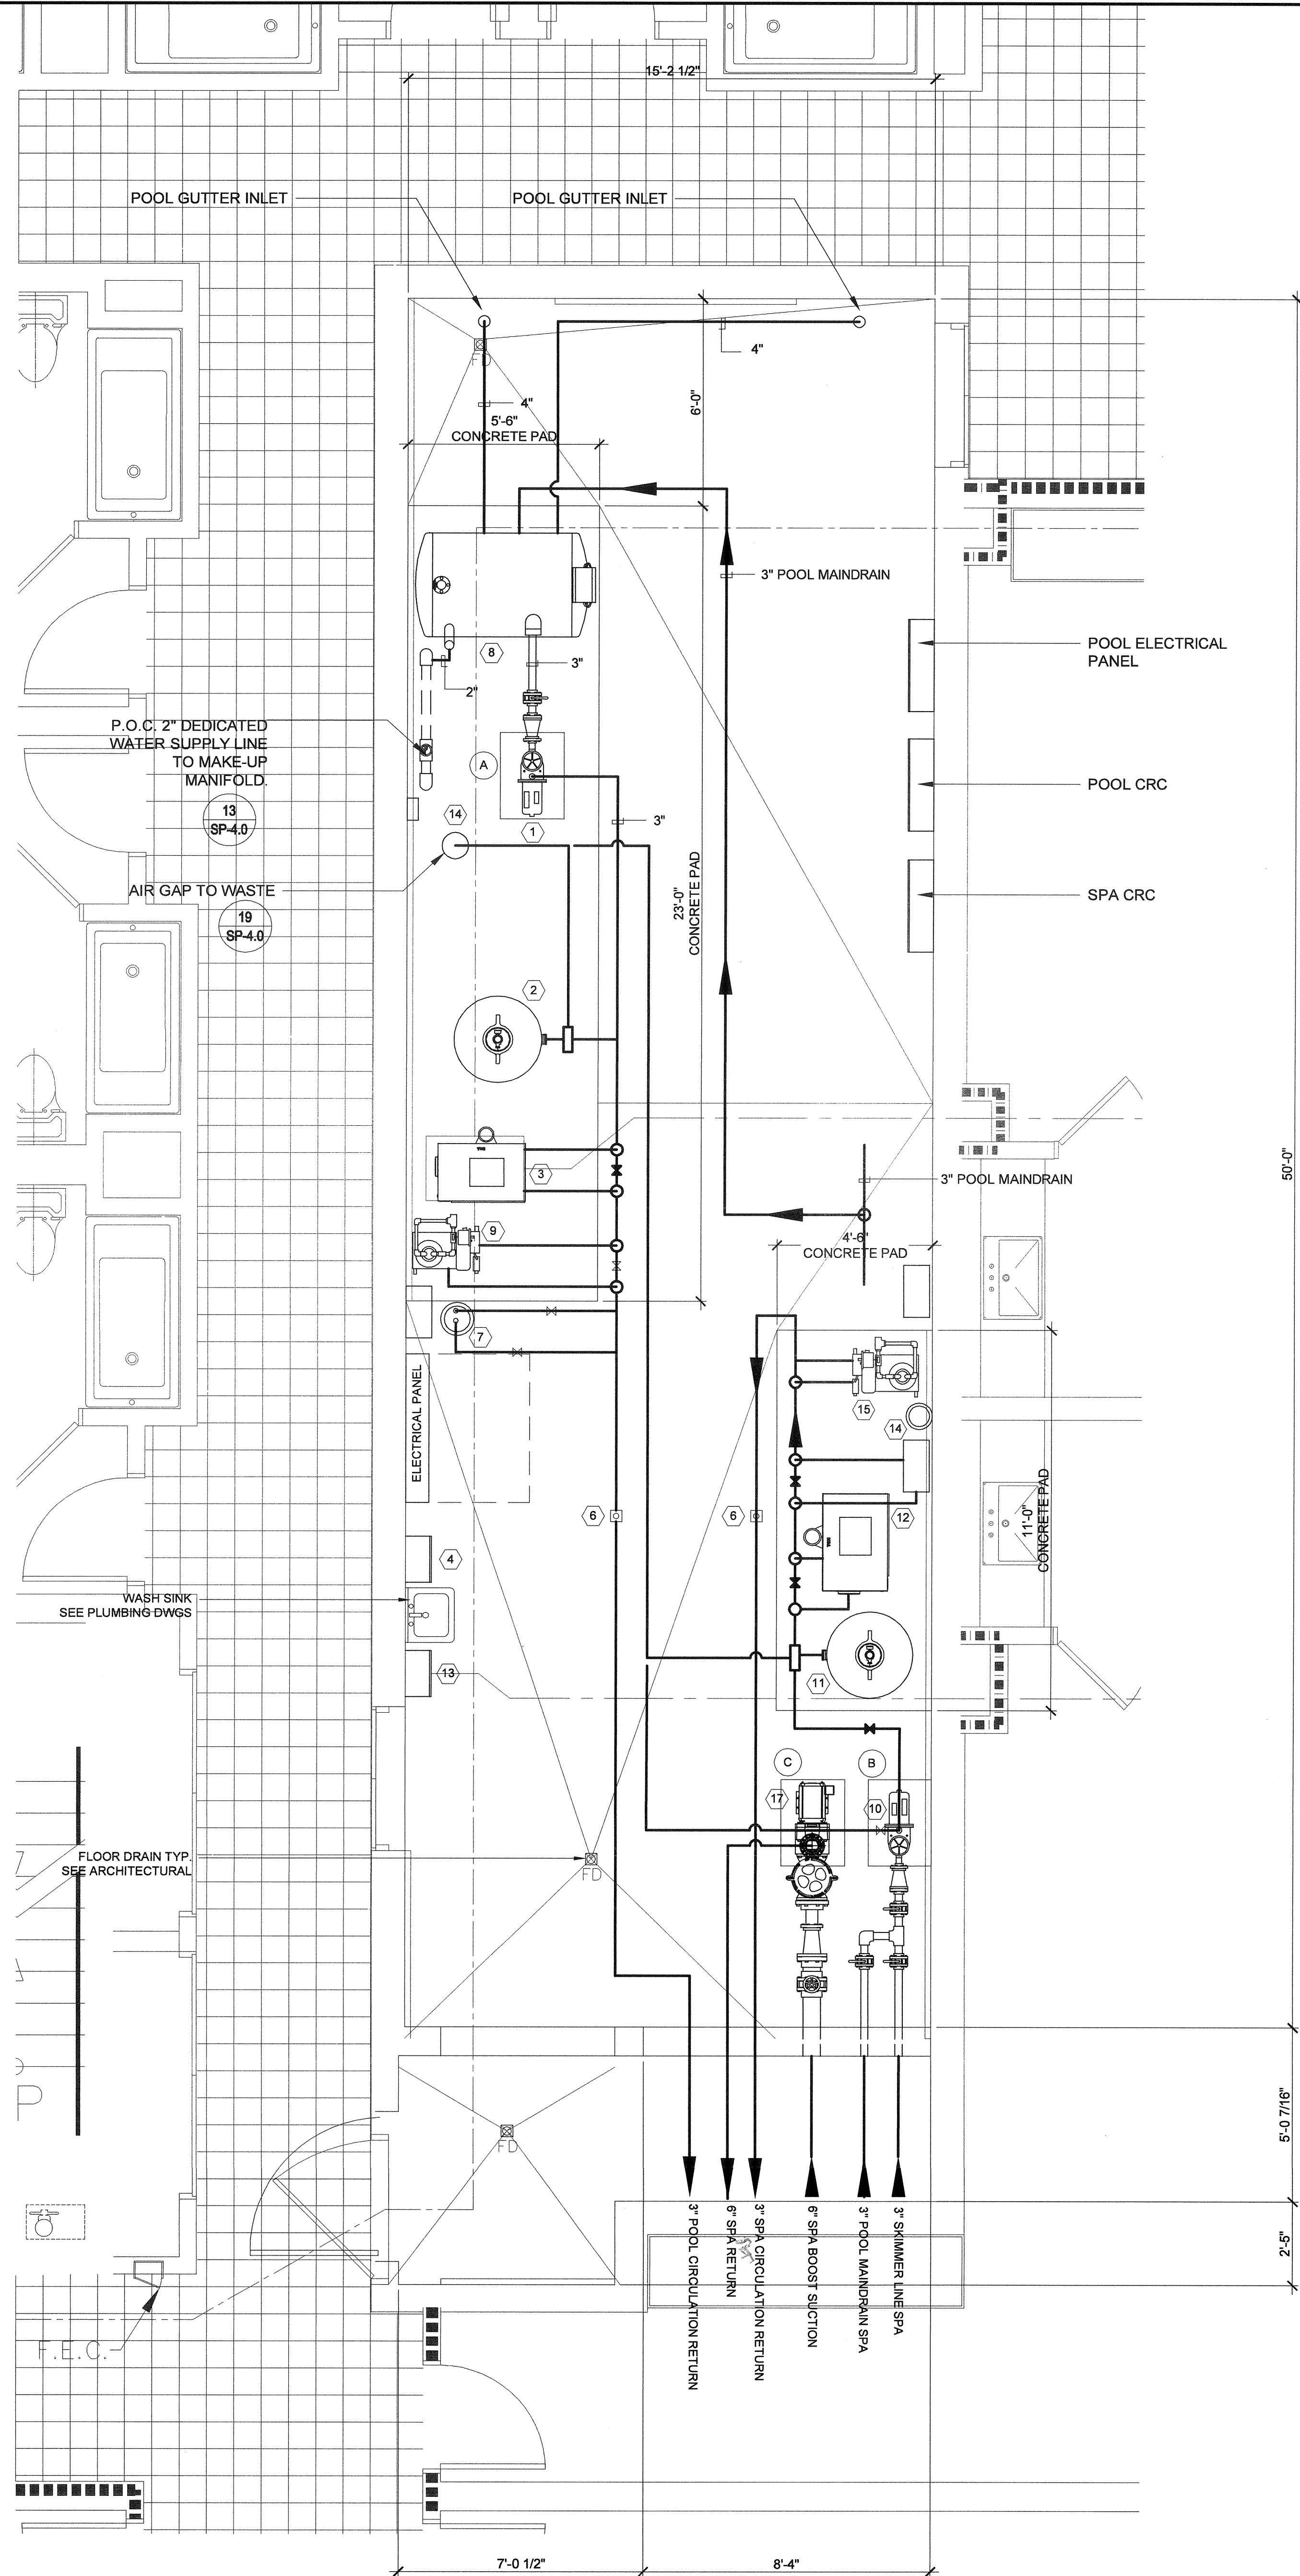

NOTES:

FOR POOL EQUIPMENT ROOM BUILDING DETAILS,
REFER TO BUILDING ARCHITECTURAL/CONSULTANT
DRAWINGS.

1. SEE DETAIL 7/SP-4.1 FOR FILTER ANCHOR.
2. SEE DETAIL 10/SP-4.1 FOR CHEMICAL TANK ANCHOR.
3. SEE DETAIL 12/SP-4.1 FOR HEATER ANCHOR.
4. SEE DETAIL 9/SP-4.0 FOR CHEMICAL INJECTION.
5. SEE DETAIL 8/SP-4.1 FOR PUMP ANCHOR.

SCALE: 3/8"=1'-0"